 





 







## MECHANICAL SYMBOLS LIST

	AIR HANDLING UNIT
	EXHAUST FAN
	CEILING DIFFUSER SUPPLY
	CEILING DIFFUSER RETURN/EXHAUST
	ROUND SUPPLY AIR DIFFUSER
	THERMOSTAT
	RECTANGULAR DUCT (WIDTH X DEPTH)
	ROUND DUCT (DIAMETER)
	POINT OF NEW CONNECTION
	VOLUME DAMPER W/ ACCESS DOOR
	MOTORIZED DAMPER
	FIRE SMOKE DAMPER
 
## MECHANICAL ABBREVIATIONS

ACCU	AIR COOL CONDENSING UNIT
AFF	ABOVE FINISHED FLOOR
AHU	AIR HANDLING UNIT
AL	ACOUSTIC LINING
BD	GRAVITY DAMPER
CD	CONDENSATE DRAIN
CFM	CUBIC FEET OF AIR PER MINUTE
DN	DOWN
E	EXISTING
EER	ENERGY EFFICIENCY RATIO
EF	EXHAUST FAN
FC	FLEXIBLE CONNECTION
FD/AD	FIRE DAMPER W/ACCESS DOOR
FD	FIRE DAMPER W/FUSIBLE LINK
FSD	FIRE SMOKE DAMPER
IEER	INTEGRATED ENERGY EFFICIENCY RATIO
OA	OUTSIDE AIR
RA	RETURN AIR
RAD	RETURN AIR DUCT
SA	SUPPLY AIR
SAD	SUPPLY AIR DUCT
SAE	SAME AS EXISTING
SEER	SEASONAL ENERGY EFFICIENCY RATIO
VD	VOLUME CONTROL DAMPER
VIF	VERIFY IN FIELD

## MECHANICAL DRAWING LIST

M-0.1	MECHANICAL SYMBOL, ABBREVIATION & NOTES
M-0.2	MECHANICAL SPECIFICATIONS
M-1.0	MECHANICAL FLOOR AND PART ROOF PLAN
M-2.0	MECHANICAL DETAILS
M-3.0	MECHANICAL SCHEDULE

## BUILDING DEPARTMENT NOTES

ALL WORK SHALL COMPLY WITH APPLICABLE SECTIONS OF INTERNATIONAL BUILDING CODE 2021 AND ALL AMENDMENTS AND RULES AND REGULATIONS OF THE DEPARTMENT OF BUILDINGS TO DATE.

- THE CONTRACTOR SHALL ENGAGE THE SERVICES OF A PROFESSIONAL ENGINEER TO PROVIDE THE REQUIRED SPECIAL INSPECTIONS AND TESTS.
- TESTS WILL BE CONDUCTED UNDER DIRECTION OF A LICENSED PROFESSIONAL ENGINEER, ARCHITECT OR OTHER PERSON HAVING NOT LESS THAN FIVE (5) YEARS EXPERIENCE SUPERVISING THE INSTALLATION OF SUCH MECHANICAL SYSTEMS. THE TESTS WILL SHOW COMPLIANCE WITH 2021 INTERNATIONAL BUILDING CODE .
- THE LICENSED PROFESSIONAL ENGINEER, ARCHITECT OR OTHER PERSON HAVING NOT LESS THAN FIVE (5) YEARS EXPERIENCE SUPERVISING THE INSTALLATION OF SUCH MECHANICAL SYSTEMS AND CONDUCTING SUCH TESTS WILL FILE DOCUMENTATION AND REPORTS OF TESTS THAT THE SYSTEM COMPLIES WITH THE CONSTRUCTION DOCUMENTS AND APPLICABLE LAWS.
- TESTS OF MECHANICAL SYSTEMS SHALL BE PERFORMED IN ACCORDANCE WITH SECTION IMC 107 AND THE FOLLOWING SECTIONS OF THE 2021 INTERNATIONAL MECHANICAL CODE:  
A. VENTILATION SYSTEM - 2021 IMC 401
- THE FOLLOWING WORK ITEMS, COMPONENTS, MATERIALS, CAPACITIES, ETC. SHALL COMPLY WITH THE REFERENCED CODE OR STANDARD INTERNATIONAL MECHANICAL CODE:  
A. STANDARDS OF HEATING - 2021 IMC 309.1  
B. DUCT CONSTRUCTION AND INSTALLATION- 2021 IMC 603  
C. AIR INTAKES, EXHAUSTS AND RELIEF - 2021 IMC 401.5  
D. AIR FILTERS - 2021 IMC 605
- MINIMUM TEMPERATURE TO BE MAINTAINED IN OCCUPIED SPACES DURING HEATING SEASON: 68 DEG. FAHRENHEIT.
- VENTILATION FOR ALL AREA SHALL COMPLY WITH 2021 IMC 401.
- A STATEMENT SHALL BE FILED BY THE OWNER OR TENANT IN POSSESSION THAT THE VENTILATION SYSTEM WILL BE KEPT IN CONTINUOUS OPERATION AT ALL TIMES DURING THE NORMAL OCCUPANCY OF THE STRUCTURE AS REQUIRED BY 2021 IMC 403.3
- REFER TO ARCHITECTURAL DRAWINGS FOR REQUIRED FIRE-RATED WALL AND SMOKE WALL CONSTRUCTION AND LOCATION.
- THESE PLANS ARE APPROVED ONLY FOR THE WORK INDICATED ON THE APPLICATION SPECIFICATION SHEET. ALL OTHER MATTERS SHOWN ARE NOT TO BE RELIED UPON OR TO BE CONSIDERED AS EITHER BEING APPROVED OR IN ACCORDANCE WITH APPLICABLE CODES.
- ALL HEATING AND COOLING LOADS CALCULATED PER ASHRAE/ACCA 183.
- SMOKE DETECTOR SHALL MEET UL268A.

## THERMOSTATIC CONTROL NOTES

- 6.4.3.1.1 GENERAL  
THE SUPPLY OF HEATING AND COOLING ENERGY TO EACH ZONE SHALL BE INDIVIDUALLY CONTROLLED BY THERMOSTATIC CONTROLS RESPONDING TO TEMPERATURE WITHIN THE ZONE. FOR THE PURPOSES OF THIS SECTION, A DWELLING UNIT SHALL BE PERMITTED TO BE CONSIDERED A SINGLE ZONE.
- 6.4.3.1.2 DEAD BAND  
WHERE USED TO CONTROL BOTH HEATING AND COOLING, ZONE THERMOSTATIC CONTROLS SHALL BE CAPABLE OF AND CONFIGURED TO PROVIDE A TEMPERATURE RANGE OR DEAD BAND OF AT LEAST 5°F WITHIN WHICH THE SUPPLY OF HEATING AND COOLING ENERGY TO THE ZONE IS SHUT OFF OR REDUCED TO A MINIMUM.
- 6.4.3.2 SET-POINT OVERLAP RESTRICTION  
WHERE HEATING AND COOLING TO A ZONE ARE CONTROLLED BY SEPARATE ZONE THERMOSTATIC CONTROLS LOCATED WITHIN THE ZONE, MEANS (SUCH AS LIMIT SWITCHES, MECHANICAL STOPS, OR FOR DDC SYSTEMS, SOFTWARE PROGRAMMING) SHALL BE PROVIDED TO PREVENT THE HEATING SET POINT FROM EXCEEDING THE COOLING SET POINT, MINUS ANY APPLICABLE PROPORTIONAL BAND.
- 6.4.3.3 OFF-HOUR CONTROLS  
HVAC SYSTEMS SHALL HAVE THE OFF-HOUR CONTROLS REQUIRED BY SECTIONS 6.4.3.3.1 THROUGH 6.4.3.3.5.
- 6.4.3.3.1 AUTOMATIC SHUTDOWN  
HVAC SYSTEMS SHALL BE EQUIPPED WITH AT LEAST ONE OF THE FOLLOWING:
  - CONTROLS THAT CAN START AND STOP THE SYSTEM UNDER DIFFERENT TIME SCHEDULES FOR SEVEN DIFFERENT DAY TYPES PER WEEK, ARE CAPABLE OF RETAINING PROGRAMMING AND TIME SETTING DURING LOSS OF POWER FOR A PERIOD OF AT LEAST TEN HOURS, AND INCLUDE AN ACCESSIBLE MANUAL OVERRIDE OR EQUIVALENT FUNCTION THAT ALLOWS TEMPORARY OPERATION OF THE SYSTEM FOR UP TO TWO HOURS.
  - AN OCCUPANCY SENSOR THAT IS CAPABLE OF SHUTTING THE SYSTEM OFF WHEN NO OCCUPANT IS SENSED FOR A PERIOD OF UP TO 30 MINUTES.
  - A MANUALLY OPERATED TIMER CAPABLE OF BEING ADJUSTED TO OPERATE THE SYSTEM FOR UP TO TWO HOURS.
  - AN INTERLOCK TO A SECURITY SYSTEM THAT SHUTS THE SYSTEM OFF WHEN THE SECURITY SYSTEM IS ACTIVATED.
- 6.4.3.3.2 SETBACK CONTROLS  
HEATING SYSTEMS SHALL BE EQUIPPED WITH CONTROLS CAPABLE OF AND CONFIGURED TO AUTOMATICALLY RESTART AND TEMPORARILY OPERATE THE SYSTEM AS REQUIRED TO MAINTAIN ZONE TEMPERATURES ABOVE AN ADJUSTABLE HEATING SET POINT AT LEAST 10°F BELOW THE OCCUPIED HEATING SET POINT. COOLING SYSTEMS SHALL BE EQUIPPED WITH CONTROLS CAPABLE OF AND CONFIGURED TO AUTOMATICALLY RESTART AND TEMPORARILY OPERATE THE MECHANICAL COOLING SYSTEM AS REQUIRED TO MAINTAIN ZONE TEMPERATURES BELOW AN ADJUSTABLE COOLING SET POINT AT LEAST 5°F ABOVE THE OCCUPIED COOLING SET POINT OR TO PREVENT HIGH SPACE HUMIDITY LEVELS.

## GENERAL NOTES

- CONTRACTOR SHALL SURVEY THE AREA OF THIS WORK BEFORE SUBMITTING A BID AND SHALL BE RESPONSIBLE FOR NOTIFYING THE ARCHITECT OF ANY CONDITIONS WHICH WOULD PREVENT THE INSTALLATION OF THE WORK AS SHOWN ON DRAWINGS.
  - ALL APPLICABLE CODES, LAWS AND REGULATIONS GOVERNING OR RELATING TO ANY PORTION OF THIS WORK ARE HEREBY INCORPORATED INTO AND MADE A PART OF THESE SPECIFICATIONS, AND THEIR PROVISIONS SHALL BE CARRIED OUT BY THE CONTRACTOR WHO SHALL INFORM THE OWNER, PRIOR TO SUBMITTING A PROPOSAL, OF ANY WORK OR MATERIALS WHICH VIOLATE ANY OF THE ABOVE LAWS AND REGULATIONS. ANY WORK DONE BY THE CONTRACTOR CAUSING SUCH VIOLATION SHALL BE CORRECTED BY THE CONTRACTOR.
  - BEFORE PROCEEDING WITH ANY WORK IN OCCUPIED OR USED AREAS, THE CONTRACTOR SHALL APPLY TO OWNER FOR PERMISSION TO ENTER SUCH AREAS. THE CONTRACTOR IS OBLIGED TO PERFORM HIS WORK ONLY AT THE TIMES DESIGNATED BY OWNER. THERE WILL BE NO ADDITIONAL COMPENSATION FOR THE WORK PERFORMED AFTER HOURS OR ON OFF-DAYS WITHOUT PRIOR WRITTEN APPROVAL.
  - THE WORK IN THE BUILDING SHALL BE DONE WHEN AND AS DIRECTED, AND IN A MANNER SATISFACTORY TO THE OWNER. THE WORK SHALL BE PERFORMED SO AS TO CAUSE THE LEAST POSSIBLE INCONVENIENCE AND DISTURBANCE TO THE PRESENT OCCUPANTS.
  - THE CONTRACTOR'S PROPOSAL FOR ALL WORK SHALL BE PREDICATED ON THE PERFORMANCE OF THE WORK DURING REGULAR WORKING HOURS. WHEN SO DIRECTED, HOWEVER, THE CONTRACTOR SHALL INSTALL WORK IN OVERTIME AND THE ADDITIONAL COST TO BE CHARGED THEREFORE SHALL BE ONLY THE "PREMIUM" PORTION OF THE WAGES PAID.
  - CONTRACTOR SHALL ASCERTAIN THE APPROPRIATE METHOD FOR BRINGING THE UNITS INTO AND THROUGH THE BUILDING TO POSITION UNIT IN LOCATION SHOWN ON THE PLANS. WHERE NECESSARY, EQUIPMENT SHALL BE SHIPPED FROM MANUFACTURER IN SECTIONS OF SIZE SUITABLE FOR MOVING THROUGH RESTRICTIVE SPACES. COORDINATE WITH BUILDING OWNER APPROPRIATE TIMES OF DAY SUCH EQUIPMENT MAY BE MOVED THROUGH ALL AREAS.
  - DUCTWORK AND PIPING IS SHOWN DIAGRAMMATICALLY AND DOES NOT SHOW ALL OFFSETS, DROPS AND RISES OF RUNS. THE CONTRACTOR SHALL MAKE ALLOWANCE IN PRICING FOR ROUTING OF DUCTWORK AND PIPING TO AVOID OBSTRUCTIONS. EXACT LOCATIONS ARE SUBJECT TO APPROVAL OF ARCHITECT. COORDINATION WITH THE OTHER TRADES IS REQUIRED.
  - SUPPORT ALL DUCTWORK AND PIPING FROM BUILDING STRUCTURE AND/OR FRAMING IN AN APPROVED MANNER. WHERE OVERHEAD CONSTRUCTION DOES NOT PERMIT FASTENING OR SUPPORTS FOR EQUIPMENT, FURNISH ADDITIONAL FRAMING. INSERTS SHALL BE STEEL, SLOTTED TYPE AND FACTORY PAINTED. SINGLE ROD SHALL BE SIMILAR TO GRINNELL FIG. 281. MULTI-ROD SHALL BE SIMILAR TO FEE & MASON SERIES 9000 WITH END CAPS AND CLOSURE STRIPS. MAXIMUM LOADING INCLUDING PIPES, DUCTWORK CONTENTS AND COVERING SHALL NOT EXCEED 75% OF RATED INSERT CAPABILITY. WHEN SUPPORTING FROM BUILDING USE BEAM CLAMPS IN APPROVED MANNER.
  - PROVIDE ALL NECESSARY FLASHING AND COUNTER FLASHING TO MAINTAIN THE WATERPROOFING INTEGRITY OF THIS BUILDING AS REQUIRED BY THE INSTALLATION OR REMOVAL OF PIPES, DUCTS, LOUVERS, CONDUIT, AND EQUIPMENT. PROVIDE EQUIPMENT CURBS AND DUNNAGE STEEL AS REQUIRED.
  - SEAL OPENINGS AROUND DUCTS AND PIPING THROUGH PARTITIONS, WALLS AND FLOORS (NOT IN SHAFTS) WITH MINERAL WOOL OR OTHER NONCOMBUSTIBLE MATERIAL (FIBERGLASS INSULATION IS NOT ACCEPTABLE).
  - WHERE PENETRATIONS THROUGH FIRE RATED WALLS ARE NOT FIRE PROOFED THIS CONTRACTOR SHALL BE RESPONSIBLE TO SEAL SAME TO MAINTAIN THE RATED INTEGRITY.
  - INSTALL WORK SO AS TO BE READILY ACCESSIBLE FOR OPERATION, MAINTENANCE AND REPAIR. MINOR DEVIATIONS FROM DRAWINGS MAY BE MADE TO ACCOMPLISH THIS, BUT CHANGES WHICH INVOLVE EXTRA COST SHALL NOT BE MADE WITHOUT APPROVAL.
  - ACCESS DOORS ARE REQUIRED FOR ALL BUILT-IN SERVICE VALVES THAT RUN THROUGH THE SPACE, AND ACCESS DOOR SHALL HAVE THE EQUAL RATED CAPACITY (1HR, 2HR, ETC.) AS WALL. COORDINATE ALL LOCATIONS OF ACCESS DOORS WITH THE ARCHITECT.
  - REMOVABLE ACCESS TILE AND/OR ACCESS DOOR ARE REQUIRED IN HUNG CEILINGS, SHAFTS AND WALLS FOR ALL VOLUME AND FIRE DAMPERS, AUTOMATIC DAMPERS AND ALL OTHER MECHANICAL EQUIPMENT AND DEVICES. HVAC CONTRACTOR TO FURNISH ACCESS LOCATION REQUIREMENTS TO GENERAL CONTRACTOR. ACCESS TILE IDENTIFICATION: PROVIDE BUTTONS, TABS, AND MARKERS TO IDENTIFY LOCATION OF CONCEALED VALVES, DAMPERS AND EQUIPMENT.
  - THE CONTRACTOR SHALL KEEP ALL EQUIPMENT AND MATERIALS, AND ALL PARTS OF THE BUILDING, EXTERIOR SPACES AND ADJACENT STREETS, SIDEWALKS AND PAVEMENTS, FREE FROM MATERIAL AND DEBRIS RESULTING FROM THE EXECUTION OF THIS WORK. EXCESS MATERIALS WILL NOT BE PERMITTED TO ACCUMULATE EITHER ON THE INTERIOR OR THE EXTERIOR.
  - MATERIALS AND WORKMANSHIP, UNLESS OTHERWISE NOTED, SHALL BE IN ACCORDANCE WITH BUILDING STANDARDS.
  - ALL EQUIPMENT SHALL BE PROVIDED WITH ONE YEAR WARRANTY PARTS AND LABOR AND FIVE YEARS ON COMPRESSORS. WARRANTY PERIOD BEGINS UPON PROJECT ACCEPTANCE
  - ALL MATERIAL AND EQUIPMENT TO BE NEW UNLESS OTHERWISE NOTED AND SHALL BE IN ACCORDANCE WITH BUILDING STANDARDS.
  - THE CONTRACTOR SHALL BE RESPONSIBLE FOR HIS WORK WITH ITS COMPLETION AND FINAL ACCEPTANCE AND SHALL REPLACE ANY OF THE SAME WHICH MAY BE DAMAGED, LOST, OR STOLEN WITHOUT ADDITIONAL COST TO THE OWNER.
  - THE CONTRACTOR SHALL BE RESPONSIBLE FOR THE FAILURE OF ANY DUCTWORK SYSTEM OR EQUIPMENT TO FUNCTION PROPERLY UPON COMPLETION OF HIS WORK UPON SAID SYSTEM OR EQUIPMENT.
  - SUBMIT SHOP DRAWING OF ALL WORK WHICH MUST BE APPROVED BY THE ARCHITECT AND ENGINEER BEFORE WORK COMMENCES.
  - INSURANCE: IN ACCORDANCE WITH BUILDING REQUIREMENTS THE CONTRACTOR SHALL INCLUDE A HOLD HARMLESS CLAUSE FOR OWNER AND ENGINEER.
  - THE FINAL ACCEPTANCE WILL BE MADE AFTER THE CONTRACTOR HAS ADJUSTED HIS EQUIPMENT, BALANCED THE VARIOUS SYSTEMS, DEMONSTRATED THAT IT FULFILLS THE REQUIREMENTS OF THE DRAWINGS AND SPECIFICATIONS AND HAS FURNISHED ALL THE REQUIRED CERTIFICATES OF INSPECTION AND APPROVAL.
  - SPECIFICATIONS ARE OF SIMPLIFIED FORM AND INCLUDE INCOMPLETE SENTENCES. WORDS OR PHRASES SUCH AS "THE CONTRACTOR SHALL," "SHALL BE," "FURNISH," "PROVIDE," "A," "THE," AND "ALL" HAVE BEEN OMITTED FOR BREVITY.
  - WHERE A CONFLICT EXISTS BETWEEN THE DRAWINGS, THE SPECIFICATIONS OR ANY OTHER CONSTRUCTION DOCUMENT, THE ONE WITH THE MOST STRINGENT REQUIREMENT(S) SHALL APPLY.
- DEFINITIONS:
- "PROVIDE": TO SUPPLY, INSTALL AND CONNECT UP COMPLETE AND READY FOR SAFE AND REGULAR OPERATION THE PARTICULAR WORK REFERRED TO UNLESS SPECIFICALLY OTHERWISE NOTED.
  - "INSTALL": TO ERECT, MOUNT AND CONNECT COMPLETE WITH RELATED ACCESSORIES.
  - "FURNISH" OR "SUPPLY": TO PURCHASE, PROCURE, ACQUIRE AND DELIVER COMPLETE WITH RELATED ACCESSORIES.

## GENERAL HVAC NOTES

- PROVIDE ALL MATERIAL AND EQUIPMENT AND PERFORM ALL LABOR REQUIRED TO INSTALL COMPLETE AND OPERABLE MECHANICAL SYSTEMS AS INDICATED ON THE DRAWINGS, AS SPECIFIED AND AS REQUIRED BY CODE.
- CONTRACT DOCUMENT DRAWINGS FOR MECHANICAL WORK (HVAC, PLUMBING, AND FIRE PROTECTION) ARE DIAGRAMMATIC AND ARE INTENDED TO CONVEY SCOPE AND GENERAL ARRANGEMENT ONLY.
- THE LOCATIONS OF ALL ITEMS SHOWN ON THE DRAWINGS OR CALLED FOR IN THE SPECIFICATIONS THAT ARE NOT FIXED BY DIMENSIONS ARE APPROXIMATE ONLY. THE EXACT LOCATIONS NECESSARY TO SECURE THE BEST CONDITIONS AND RESULTS MUST BE DETERMINED BY THE PROJECT SITE CONDITIONS AND SHALL HAVE THE APPROVAL OF THE ENGINEER BEFORE BEING INSTALLED. DO NOT SCALE DRAWINGS.
- WHEN MECHANICAL WORK (HVAC, PLUMBING, SHEET METAL, FIRE PROTECTION, ETC.) IS SUBCONTRACTED, IT SHALL BE THE MECHANICAL CONTRACTOR'S RESPONSIBILITY TO COORDINATE SUBCONTRACTORS AND THE ASSOCIATED CONTRACTS. WHEN DISCREPANCIES ARISE PERTAINING TO WHICH CONTRACTOR PROVIDES A PARTICULAR ITEM OF THE MECHANICAL CONTRACT OR WHICH CONTRACTOR PROVIDES FINAL CONNECTIONS FOR A PARTICULAR ITEM OF THE MECHANICAL CONTRACT, IT SHALL BE BROUGHT TO THE ATTENTION OF THE MECHANICAL CONTRACTOR, WHOSE DECISION SHALL BE FINAL.
- COORDINATE CONSTRUCTION OF ALL MECHANICAL WORK WITH ARCHITECTURAL, STRUCTURAL, CIVIL, ELECTRICAL WORK, ETC. SHOWN ON OTHER CONTRACT DOCUMENT DRAWINGS.
- INSTALL ALL MECHANICAL EQUIPMENT AND APPURTENANCES IN ACCORDANCE WITH MANUFACTURER'S RECOMMENDATIONS, CONTRACT DOCUMENTS, AND APPLICABLE CODES AND REGULATIONS.
- WHERE TWO OR MORE ITEMS OF THE SAME TYPE OF EQUIPMENT ARE REQUIRED, THE PRODUCT OF ONE MANUFACTURER SHALL BE USED.
- COORDINATE ALL EQUIPMENT CONNECTIONS WITH MANUFACTURERS' CERTIFIED DRAWINGS. COORDINATE AND PROVIDE ALL DUCT AND PIPING TRANSITIONS REQUIRED FOR FINAL EQUIPMENT CONNECTIONS TO FURNISHED EQUIPMENT. FIELD VERIFY AND COORDINATE ALL DUCT AND PIPING DIMENSIONS BEFORE FABRICATION.
- ALL CONTROL WIRE AND CONDUIT SHALL COMPLY WITH THE NATIONAL ELECTRIC CODE AND ELECTRICAL DIVISION OF THE SPECIFICATION.
- PROVIDE VIBRATION ISOLATION FOR ALL MECHANICAL EQUIPMENT TO PREVENT TRANSMISSION OF VIBRATION TO BUILDING STRUCTURE.
- LOCATE ALL TEMPERATURE, PRESSURE, AND FLOW MEASURING DEVICES IN ACCESSIBLE LOCATIONS WITH THE STRAIGHT SECTION OF PIPE OR DUCT UP- AND DOWNSTREAM AS RECOMMENDED BY THE MANUFACTURER FOR GOOD ACCURACY.
- WHERE BEAMS ARE INDICATED TO BE PENETRATED WITH DUCTWORK OR PIPING, COORDINATE DUCTWORK AND PIPING LAYOUT WITH BEAM OPENING SIZE AND OPENING LOCATIONS. COORDINATION SHALL BE DONE PRIOR TO THE FABRICATION OF DUCTWORK, CUTTING OF PIPING, OR FABRICATION OF BEAMS.
- ALL MISCELLANEOUS STEEL REQUIRED TO ENSURE PROPER INSTALLATION AND AS SHOWN IN THE DETAILS FOR PIPING, DUCTWORK, AND EQUIPMENT (UNLESS OTHERWISE NOTED) SHALL BE FURNISHED AND INSTALLED BY THE MECHANICAL CONTRACTOR.
- PROVIDE ACCESS PANELS FOR INSTALLATION IN WALLS AND CEILINGS, WHERE REQUIRED, TO SERVICE DAMPERS, VALVES, SMOKE DETECTORS, AND OTHER CONCEALED MECHANICAL EQUIPMENT. ACCESS PANELS SHALL BE TURNED OVER TO THE GENERAL CONTRACTOR FOR INSTALLATION. ACCESS PANELS SHALL HAVE THE EQUAL RATED CAPACITY (1HR, 2HR, ETC.) AS WALL.
- MECHANICAL EQUIPMENT, DUCTWORK, AND PIPING SHALL NOT BE SUPPORTED FROM A METAL DECK.
- ALL EQUIPMENT, PIPING, DUCTWORK, ETC., SHALL BE SUPPORTED AS DETAILED, SPECIFIED AND REQUIRED TO PROVIDE A VIBRATION-FREE INSTALLATION.
- ALL DUCTWORK, PIPING, AND EQUIPMENT SUPPORTED FROM STRUCTURAL STEEL SHALL BE COORDINATED WITH THE GENERAL CONTRACTOR. ALL ATTACHMENTS TO STEEL BAR JOISTS, TRUSSES, OR JOIST GIRDERS SHALL BE AT PANEL POINTS. PROVIDE BEAM CLAMPS MEETING MSS STANDARDS. WELDING TO STRUCTURAL MEMBERS SHALL NOT BE PERMITTED. THE USE OF C-CLAMPS SHALL NOT BE PERMITTED.
- ALL ROOF-MOUNTED EQUIPMENT CURBS/STEEL RAILS FOR EQUIPMENT PROVIDED BY THE MECHANICAL CONTRACTOR SHALL BE FURNISHED BY THE MECHANICAL CONTRACTOR AND INSTALLED BY THE GENERAL CONTRACTOR.
- LOCATIONS AND SIZES OF ALL FLOOR, WALL, AND ROOF OPENINGS SHALL BE COORDINATED WITH ALL OTHER TRADES INVOLVED.
- ALL OPENINGS IN FIRE WALLS DUE TO DUCTWORK, PIPING, CONDUIT, ETC., SHALL BE FIRE STOPPED WITH A PRODUCT SIMILAR TO 3M OR APPROVED EQUAL.
- ALL AIR CONDITIONING CONDENSATE DRAIN LINES FROM EACH AIR HANDLING UNIT SHALL BE PIPED FULL SIZE OF THE UNIT DRAIN OUTLET, WITH "P" TRAP, AND PIPED TO THE NEAREST DRAIN. SEE THE DETAILS SHOWN IN THE DRAWINGS OR THE CONTRACT SPECIFICATIONS FOR THE DEPTH OF THE AIR CONDITIONING CONDENSATE TRAP.
- REFER TO TYPICAL DETAILS FOR DUCTWORK, PIPING, AND EQUIPMENT INSTALLATION.

## SCOPE OF WORK

### SCOPE OF WORK

- THE WORK UNDER CONTRACT INCLUDES ALL LABOR, MATERIALS AND APPLIANCES NECESSARY FOR THE FURNISHING, INSTALLING AND TESTING, COMPLETE AND READY FOR SAFE OPERATION OF THE SYSTEMS AS DESCRIBED IN THE SPECIFICATIONS, FLOOR PLAN(S) DESIGN, DETAIL DRAWINGS, NOTES, RFIs, ETC. FOR THIS PROJECT. WORK SHALL BE INSTALLED IN A NEAT, WORKMANLIKE MANNER.
- THE CONTRACTOR SHALL GIVE NECESSARY NOTICE, FILE DRAWINGS AND SPECIFICATIONS WITH THE DEPARTMENT HAVING JURISDICTION, OBTAIN PERMITS OR LICENSES NECESSARY TO CARRY OUT THIS WORK AND PAY ALL FEES THEREFORE. THE CONTRACTOR SHALL ARRANGE FOR INSPECTION AND TESTS OF ANY OR ALL PARTS OF THE WORK IF SO REQUIRED BY AUTHORITIES AND PAY ALL CHARGES FOR SAME. THE CONTRACTOR SHALL PAY ALL COSTS FOR, AND FURNISH TO THE OWNER BEFORE FINAL BILLING, ALL CERTIFICATES NECESSARY AS EVIDENCE THAT THE WORK INSTALLED CONFORMS WITH ALL REGULATIONS WHERE THEY APPLY TO THIS WORK.
- THE CONTRACTOR SHALL FURNISH A WRITTEN GUARANTEE TO REPLACE OR REPAIR PROMPTLY AND ASSUME RESPONSIBILITY FOR ALL EXPENSES INCURRED FOR ANY WORKMANSHIP AND EQUIPMENT IN WHICH DEFECTS DEVELOP WITHIN ONE YEAR FROM THE DATE OF FINAL CERTIFICATE FOR PAYMENT AND/OR FROM DATE OF ACTUAL USE OF EQUIPMENT OR OCCUPANCY OF SPACES, BY OWNER, INCLUDED UNDER THE VARIOUS PARTS OF THE WORK, WHICHEVER DATE IS EARLIER. THIS WORK SHALL BE DONE AS DIRECTED BY THE OWNER. THIS GUARANTEE SHALL ALSO PROVIDE THAT WHERE DEFECTS OCCUR, THE CONTRACTOR WILL ASSUME RESPONSIBILITY FOR ALL EXPENSES INCURRED IN REPAIRING AND REPLACING WORK OF OTHER TRADES AFFECTED BY DEFECTS, REPAIRS OR REPLACEMENTS IN EQUIPMENT SUPPLIED BY THE CONTRACTOR.

### PROJECT INFORMATION:

KIDSUNITED

### DRAWING TITLE:

MECHANICAL SYMBOL  
ABBREVIATION & NOTES

### DRAWING NO.:

M-0.1

## SPECIFICATIONS

### SECTION 0001 - NOTICE TO BIDDERS

#### 1.1 BIDDERS REPRESENTATIONS

- A. THE BIDDER BY MAKING A BID REPRESENTS THAT:
  - B. THE BIDDER HAS READ AND UNDERSTANDS THE BIDDING DOCUMENTS, TO THE EXTENT THAT SUCH DOCUMENTATION RELATES TO THE WORK FOR WHICH THE BID IS SUBMITTED, AND FOR OTHER PORTIONS OF THE PROJECT, IF ANY, BEING BID CONCURRENTLY OR PRESENTLY UNDER CONSTRUCTION.
  - C. THE BID IS MADE IN COMPLIANCE WITH THE BIDDING DOCUMENTS.
  - D. THE SPECIFICATIONS AND DRAWINGS ARE INTENDED TO SERVE JOINTLY AS A BASIS FOR THE BIDDER TO SUBMIT A CONTRACT PRICE FOR THE MATERIAL AND LABOR.
  - E. SHOULD CONFLICTS OR DISCREPANCIES OCCUR WITHIN THE BIDDING DOCUMENTS, THE ITEM OR ITEMS IN DISPUTE THAT REPRESENT THE GREATER COST SHALL PREVAIL IN THE FINAL BID.
  - F. THE BID IS BASED UPON THE MATERIALS, EQUIPMENT AND SYSTEMS REQUIRED BY THE BIDDING DOCUMENTS WITHOUT EXCEPTION.

#### 1.2 EXISTING CONDITIONS AND COORDINATION

- A. THE BIDDER HAS VISITED THE SITE, BECOME FAMILIAR WITH LOCAL CONDITIONS UNDER WHICH THE WORK IS TO BE PERFORMED, AND HAS CORRELATED THE BIDDER'S OBSERVATIONS WITH THE REQUIREMENTS OF THE PROPOSED BIDDING DOCUMENTS.
- B. THE BIDDER SHALL PROPOSE COORDINATION OF WORK SUCH THAT CONFLICTS WITH OTHER TRADES AND SPACE ALLOCATIONS ARE AVOIDED.
- 1.3 RESPONSIBILITIES
  - A. THE BIDDER UNDERSTANDS THAT ANY CONTRACTOR SHALL BE FULLY RESPONSIBLE FOR THE TIMELY COMPLETION AND ACCEPTANCE OF THEIR WORK AND THAT ANY ITEMS DAMAGED, LOST, OR STOLEN DURING TIME OF CONSTRUCTION SHALL BE REPAIRED OR REPLACED WITHOUT ANY ADDITIONAL COST TO THE OWNER.
  - B. THE BIDDER UNDERSTANDS THAT ANY PROPOSED WORK IN OCCUPIED TENANT SPACES SHALL BE PERFORMED DURING TIMES OF NON-TENANT OCCUPANCY OR AS SCHEDULED OR DIRECTED BY THE BUILDING MANAGER.
  - C. THE BIDDER UNDERSTANDS THAT ANY PROPOSED SHUTDOWN OF EXISTING SYSTEMS DURING CONSTRUCTION SHALL BE PRE-ARRANGED WITH THE BUILDING MANAGER AND THAT SUCH SHUTDOWNS ARE TO BE KEPT TO A MINIMUM.

END OF SECTION 0001

### SECTION 0101 - QUALITY OF WORK

#### 1.1 WORKMANSHIP

- A. ALL WORK SHALL BE FREE FROM DEFECTS IN MATERIALS AND WORKMANSHIP FOR A PERIOD OF ONE YEAR FROM DATE OF FINAL ACCEPTANCE.
- B. ALL DEFECTS WHICH DEVELOP OR ARE DISCOVERED WITHIN THIS PERIOD SHALL BE REPAIRED BY THE CONTRACTOR TO THE SATISFACTION OF THE ARCHITECT OR BUILDING MANAGER AT NO ADDITIONAL COST TO THE OWNER.
- C. UPON COMPLETION OF THE WORK THE CONTRACTOR SHALL REMOVE FROM THE SITE, ALL TOOLS, DEMOLISHED APPLIANCES AND ANY SURPLUS MATERIAL.
- 1.2 CODE COMPLIANCE
  - A. ALL WORK SHALL MEET ALL STATE AND LOCAL CODES HAVING JURISDICTION.

END OF SECTION 0101

### SECTION 0102 -REQUIRED DOCUMENTS

- 1.1 SHOP DRAWINGS
  - A. A SET OF PRINTS FOR ANY MECHANICAL WORK INCLUDING BUT NOT LIMITED TO, DUCTWORK AND PIPING LAYOUT SHALL BE SUBMITTED FOR APPROVAL TO THE ENGINEER PRIOR TO CONSTRUCTION OR PURCHASE OF MATERIALS.
- 1.2 SUBMITTALS
  - A. EQUIPMENT SUBMITTALS OF ALL PROPOSED MECHANICAL AND ANCILLARY EQUIPMENT INCLUDING ALL ACCESSORIES SHALL BE SUBMITTED TO THE ENGINEER FOR REVIEW. ALL PERTINENT MODELS, SIZES, ACCESSORIES, AND CHOICES SHALL BE CHECKED, PRINTED, OR OTHERWISE INDICATED ON THE SUBMITTALS.
  - 1.3 RECORD DRAWINGS
    - A. UPON COMPLETION OF THE WORK, A RECORD DRAWING SHALL BE SUBMITTED TO THE OWNER DEPICTING ALL SUBSEQUENT CHANGES, ADDITIONS AND OR CORRECTIONS TO THE CONTRACT DRAWINGS AND OR CONTRACT SCOPE MADE DURING CONSTRUCTION. THIS DRAWING SHALL REPRESENT A COMPLETE RECORD OF THE WORK INSTALLED.
    - 1.4 EQUIPMENT OPERATING INSTRUCTIONS
      - A. ON COMPLETION AND ACCEPTANCE OF WORK, THIS CONTRACTOR SHALL FURNISH WRITTEN INSTRUCTIONS, EQUIPMENT MANUALS AND DEMONSTRATE TO THE OWNER THE PROPER OPERATION AND MAINTENANCE OF ALL EQUIPMENT AND APPARATUS FURNISHED UNDER THIS CONTRACT.
      - B. THESE INSTRUCTIONS SHALL BE TYPED ON 8-1/2 IN. X 11 IN. PAPER AND BOUND IN THREE-RING BINDERS WITH CLEAR ACETATE COVERS. THE CONTRACTOR SHALL GIVE THREE COPIES OF THE INSTRUCTIONS TO THE OWNER AND ONE ELECTRONIC COPY TO THE ENGINEER.
      - C. THE INSTRUCTION BOOKLET SHALL BE ORGANIZED IN SECTIONS, WITH ONE SECTION PER SYSTEM. THE COVER OF THE INSTRUCTION BOOKLET SHALL BEAR THE NAME, ADDRESS AND PHONE NUMBER OF THE PROJECT, ARCHITECT, ENGINEER, MECHANICAL CONTRACTOR AND SUBCONTRACTORS.

END OF SECTION 0102

### SECTION 078413-PENETRATION FIRE-STOPPING

#### 1.1 QUALITY ASSURANCE

- A. INSTALLER QUALIFICATIONS: AN FM GLOBAL-APPROVED FIRE-STOP QUALIFIER OR A UL-QUALIFIED FIRE-STOP CONTRACTOR.
- B. FIRE-TEST-RESPONSE CHARACTERISTICS: UL INTERTEK ETL SEMKO OR FM GLOBAL
- 1.2 PENETRATION FIRESTOPPING
  - A. PENETRATIONS IN FIRE-RESISTANCE-RATED WALLS: F-RATINGS PER ASTM E 814 OR UL 1479.
  - B. PENETRATIONS IN HORIZONTAL ASSEMBLIES: F- AND T-RATINGS PER ASTM E 814 OR UL 1479.
  - C. PENETRATIONS IN SMOKE BARRIERS: L-RATINGS PER UL 1479.
  - D. W-RATINGS: PER UL 1479.
  - 1.3 INSTALLATION
    - A. IDENTIFICATION: PREPRINTED METAL OR PLASTIC LABELS.
    - 1.5 FIELD QUALITY CONTROL
      - A. INSPECTION OF INSTALLED FIRE-STOPPING: BY OWNER-ENGAGED AGENCY ACCORDING TO ASTM E 2174.
      - 1.5 THROUGH-PENETRATION FIRESTOP SYSTEM SCHEDULE:
        - A. WHERE UL-CLASSIFIED SYSTEMS ARE INDICATED, THEY REFER TO SYSTEM NUMBERS IN UL'S "FIRE RESISTANCE DIRECTORY" UNDER PRODUCT CATEGORY XHEZ.
        - B. FOR THE FOLLOWING SYSTEMS: METALLIC AND NON-METALLIC PIPES, CONDUIT, OR TUBING, ELECTRICAL CABLES, CABLE TRAYS WITH ELECTRIC CABLES, MISCELLANEOUS ELECTRICAL PENETRANTS, INSULATED PIPES, GROUPINGS OF PENETRANTS, USE ONE OR MORE OF THE FOLLOWING MATERIALS:
          - a. LATEX SEALANT
          - b. SILICONE SEALANT
          - c. MORTAR
          - d. SILICONE FOAM
          - e. PILLOWS/BAGS
          - f. INTUMESCENT WRAP STRIPS
          - 1.6 MANUFACTURERS
            - A. HILTI CONSTRUCTION CHEMICAL, INC
            - B. 3M FIRE PROTECTION PRODUCTS

END OF SECTION 078413

### SECTION 230517 - SLEEVES AND SLEEVE SEALS FOR HVAC PIPING

- 1.1 SLEEVE-SEAL SYSTEMS
  - A. FIELD-ASSEMBLED, MODULAR SEALING-ELEMENT UNIT FOR FILLING ANNULAR SPACE BETWEEN PIPING AND SLEEVE.
    1. SEALING ELEMENTS: EPDM RUBBER OR NBR.
    2. PRESSURE PLATES: CARBON STEEL, PLASTIC, STAINLESS STEEL.
    3. CONNECTING BOLTS AND NUTS: CARBON STEEL WITH CORROSION-RESISTANT COATING, STAINLESS STEEL.
  - B. MANUFACTURERS: SUBJECT TO COMPLIANCE WITH REQUIREMENTS, AVAILABLE MANUFACTURERS OFFERING PRODUCTS THAT MAY BE INCORPORATED INTO THE WORK INCLUDE, BUT ARE NOT LIMITED TO, THE FOLLOWING:
    1. ADVANCE PRODUCTS & SYSTEMS, INC.
    2. CALPICO, INC.
    3. METRAFLEX COMPANY (THE).
    4. PIPELINE SEAL AND INSULATOR, INC.
  - 1.2 SLEEVE-SEAL FITTINGS
    - A. MANUFACTURED PLASTIC, SLEEVE-TYPE, PLASTIC OR RUBBER WATER-STOP ASSEMBLY MADE FOR IMBEDDING IN CONCRETE SLAB OR WALL.
    - 1.3 GROUT
      - A. NON-SHRINK, FACTORY PACKAGED.
      - 1.4 SLEEVE AND SLEEVE-SEAL SCHEDULE
        - A. USE SLEEVES AND SLEEVE SEALS FOR THE FOLLOWING PIPING-PENETRATION APPLICATIONS:
          1. INTERIOR PARTITIONS:
            - a. PIPING SMALLER THAN NPS 6 (DN 150): GALVANIZED-STEEL-PIPE SLEEVES, PVC-PIPE SLEEVES.
            - b. PIPING NPS 6 (DN 150) AND LARGER: GALVANIZED-STEEL-SHEET SLEEVES.

END OF SECTION 230517

### SECTION 230529 - HANGERS AND SUPPORTS FOR HVAC PIPING AND EQUIPMENT

- 1.1 PERFORMANCE REQUIREMENTS
  - A. DELEGATED DESIGN: DESIGN TRAPEZE PIPE HANGERS AND EQUIPMENT SUPPORTS, INCLUDING COMPREHENSIVE ENGINEERING ANALYSIS BY A QUALIFIED PROFESSIONAL ENGINEER, USING PERFORMANCE REQUIREMENTS AND DESIGN CRITERIA INDICATED.
  - B. STRUCTURAL PERFORMANCE: HANGERS AND SUPPORTS FOR HVAC PIPING AND EQUIPMENT SHALL WITHSTAND THE EFFECTS OF GRAVITY LOADS AND STRESSES WITHIN LIMITS AND UNDER CONDITIONS INDICATED ACCORDING TO ASCE/SEI 7.
    1. DESIGN SUPPORTS FOR MULTIPLE PIPES CAPABLE OF SUPPORTING COMBINED WEIGHT OF SUPPORTED SYSTEMS, SYSTEM CONTENTS, AND TEST WATER.
    2. DESIGN EQUIPMENT SUPPORTS CAPABLE OF SUPPORTING COMBINED OPERATING WEIGHT OF SUPPORTED EQUIPMENT AND CONNECTED SYSTEMS AND
    3. DESIGN SEISMIC-RESTRAINT HANGERS AND SUPPORTS FOR PIPING AND EQUIPMENT AND OBTAIN APPROVAL FROM AUTHORITIES HAVING JURISDICTION.
- 1.2 SUBMITTALS
  - A. SHOP DRAWINGS: SIGNED AND SEALED BY A PROFESSIONAL ENGINEER
  - 1.3 QUALITY ASSURANCE
    - A. AWS D1.1/D1.1M, "STRUCTURAL WELDING CODE - STEEL."

END OF SECTION 230529

### SECTION 230548 - VIBRATION CONTROLS FOR PIPING AND HVAC EQUIPMENT

- 1.1 PERFORMANCE REQUIREMENTS
  - A. VIBRATION ISOLATORS:
    1. ISOLATOR PADS: NEOPRENE, RUBBER, HERMETICALLY AND/OR SEALED COMPRESSED FIBERGLASS
    2. MOUNTS: DOUBLE-DEFLECTION TYPE.
    3. RESTRAINED MOUNTS: ALL DIRECTIONAL MOUNTINGS WITH SEISMIC RESTRAINT; CAST-DUCTILE-IRON HOUSING.
    4. SPRING ISOLATORS: FREESTANDING, LATERALLY STABLE, OPEN-SPRING TYPE.
    5. RESTRAINED SPRING ISOLATORS: FREESTANDING, STEEL, OPEN-SPRING TYPE WITH SEISMIC RESTRAINT.
    6. HOUSED SPRING MOUNTS: DUCTILE-IRON OR STEEL HOUSING, WITH INTEGRAL, VERTICALLY ADJUSTABLE SEISMIC SNUBBERS.
    7. ELASTOMERIC HANGERS: DOUBLE-DEFLECTION TYPE.
    8. SPRING HANGERS: COMBINATION COIL-SPRING AND ELASTOMERIC-INSERT HANGERS WITH SPRING AND INSERT IN COMPRESSION.
    9. SPRING HANGERS WITH VERTICAL-LIMIT STOP: COMBINATION COIL-SPRING AND ELASTOMERIC-INSERT HANGERS WITH SPRING AND INSERT IN COMPRESSION AND WITH VERTICAL-LIMIT STOP.
    10. PIPE RISER RESILIENT SUPPORT: ALL-DIRECTIONAL, ACOUSTICAL PIPE ANCHOR.
    11. RESILIENT PIPE GUIDES.
  - B. AIR-MOUNTING SYSTEMS:
    1. AIR MOUNTS: FREESTANDING, SINGLE OR MULTIPLE, COMPRESSED-AIR BELLOW.
    2. RESTRAINED AIR MOUNTS: HOUSED COMPRESSED-AIR BELLOW.
  - C. RESTRAINED VIBRATION ISOLATION ROOF-CURB RAILS: FACTORY-ASSEMBLED, FULLY ENCLOSED, INSULATED, AIR- AND WATERTIGHT CURB RAIL; WITH SPRING ISOLATORS MOUNTED ON ELASTOMERIC ISOLATION PADS, AND SNUBBER BUSHINGS.
- D. VIBRATION ISOLATION EQUIPMENT BASES:
  1. STEEL BASE: FACTORY- FABRICATED, WELDED, STRUCTURAL-STEEL BASES AND RAILS.
  2. INERTIA BASE: FACTORY- FABRICATED, WELDED, STRUCTURAL-STEEL BASES AND RAILS READY FOR FIELD-APPLIED, CAST-IN-PLACE CONCRETE
- 1.3 FIELD QUALITY CONTROL
  - A. TESTING: BY EITHER OWNER-ENGAGED AGENCY, CONTRACTOR-ENGAGED AGENCY, OR CONTRACTOR.

END OF SECTION 230548

- 1.2 COMPONENTS
  - A. METAL PIPE HANGERS AND SUPPORTS: CARBON OR STAINLESS STEEL
  - B. FIBERGLASS PIPE HANGERS: -CLEVIS, CENTURY COMPOSITES, COOPER B-LINE
  - C. METAL FRAMING SYSTEMS: MFMA MANUFACTURER
  - D. FIBERGLASS STRUT SYSTEMS: COOPER B-LINE
  - E. THERMAL-HANGER SHIELD INSERTS:
  - F. FASTENER SYSTEMS: POWDER-ACTUATED FASTENERS OR MECHANICAL-EXPANSION ANCHORS
  - H. PIPE STANDS: COMPACT, LOW TYPE, SINGLE PIPE, HIGH TYPE, SINGLE PIPE, HIGH TYPE, MULTIPLE PIPES, CURB-MOUNTED TYP EQUIPMENT SUPPORTS.

END OF SECTION 230548

### SECTION 230548 - VIBRATION CONTROLS FOR PIPING AND HVAC EQUIPMENT

- PART 1 - GENERAL
  - 1.1 PERFORMANCE REQUIREMENTS
    - A. SEISMIC-RESTRAINT LOADING:
      1. SITE CLASS AS DEFINED IN THE IBC: A, B
      2. ASSIGNED SEISMIC USE GROUP OR BUILDING CATEGORY AS DEFINED IN THE IBC: III, IIII
    - a. COMPONENT IMPORTANCE FACTOR: 1.0
    - b. COMPONENT RESPONSE MODIFICATION FACTOR: 2.5
    - c. COMPONENT AMPLIFICATION FACTOR: 2.5.
    3. DESIGN SPECTRAL RESPONSE ACCELERATION AT SHORT PERIODS (0.2 SECOND) 18%
    4. DESIGN SPECTRAL RESPONSE ACCELERATION AT 1-SECOND PERIOD: 8%
  - 1.2 COMPONENTS
    - A. VIBRATION ISOLATORS:
      1. ISOLATOR PADS: NEOPRENE, RUBBER, HERMETICALLY AND/OR SEALED COMPRESSED FIBERGLASS
      2. MOUNTS: DOUBLE-DEFLECTION TYPE.
      3. RESTRAINED MOUNTS: ALL DIRECTIONAL MOUNTINGS WITH SEISMIC RESTRAINT; CAST-DUCTILE-IRON HOUSING.
      4. SPRING ISOLATORS: FREESTANDING, LATERALLY STABLE, OPEN-SPRING TYPE.
      5. RESTRAINED SPRING ISOLATORS: FREESTANDING, STEEL, OPEN-SPRING TYPE WITH SEISMIC RESTRAINT.
      6. HOUSED SPRING MOUNTS: DUCTILE-IRON OR STEEL HOUSING, WITH INTEGRAL, VERTICALLY ADJUSTABLE SEISMIC SNUBBERS.
      7. ELASTOMERIC HANGERS: DOUBLE-DEFLECTION TYPE.
      8. SPRING HANGERS: COMBINATION COIL-SPRING AND ELASTOMERIC-INSERT HANGERS WITH SPRING AND INSERT IN COMPRESSION.
      9. SPRING HANGERS WITH VERTICAL-LIMIT STOP: COMBINATION COIL-SPRING AND ELASTOMERIC-INSERT HANGERS WITH SPRING AND INSERT IN COMPRESSION AND WITH VERTICAL-LIMIT STOP.
      10. PIPE RISER RESILIENT SUPPORT: ALL-DIRECTIONAL, ACOUSTICAL PIPE ANCHOR.
      11. RESILIENT PIPE GUIDES.
    - B. AIR-MOUNTING SYSTEMS:
      1. AIR MOUNTS: FREESTANDING, SINGLE OR MULTIPLE, COMPRESSED-AIR BELLOW.
      2. RESTRAINED AIR MOUNTS: HOUSED COMPRESSED-AIR BELLOW.
    - C. RESTRAINED VIBRATION ISOLATION ROOF-CURB RAILS: FACTORY-ASSEMBLED, FULLY ENCLOSED, INSULATED, AIR- AND WATERTIGHT CURB RAIL; WITH SPRING ISOLATORS MOUNTED ON ELASTOMERIC ISOLATION PADS, AND SNUBBER BUSHINGS.

END OF SECTION 230548

### SECTION 233713 - DIFFUSERS, REGISTERS, AND GRILLES

- 1.1 PRODUCTS
  - A. DIFFUSERS, REGISTERS AND GRILLES SHALL BE FURNISHED AND INSTALLED FOR CAPACITIES AND IN LOCATIONS INDICATED ON DRAWINGS. ALL REGISTERS AND DIFFUSERS SHALL BE PRIME COATED STEEL OR EXTRUDED ALUMINUM FINISHED UNLESS OTHERWISE NOTED IN BAKED WHITE ENAMEL.
  - B. MANUFACTURERS: TITUS
    1. SUBJECT TO COMPLIANCE WITH REQUIREMENTS, PROVIDE PRODUCT BY ONE OF THE FOLLOWING:
      - a. HART & COOLEY INC.
      - b. KRUEGER.
      - c. METALAIRE, INC.
      - d. RUSKIN
    - C. ALL DIFFUSERS SHALL HAVE CONTROLLING/EQUALIZING GRID AND OPPOSED BLADE DAMPER UNLESS OTHERWISE NOTED.
    - D. ALL DUCTED RETURN REGISTERS SHALL HAVE AN OPPOSED BLADE DAMPER UNLESS OTHERWISE NOTED.

END OF SECTION 233713

### SECTION 233113 - METAL DUCTS

- 1.1 CONSTRUCTION
  - A. EACH DUCT SYSTEM SHALL BE CONSTRUCTED FOR THE SPECIFIC SMACNA DUCT PRESSURE CLASSIFICATIONS SHOWN ON THE CONTRACT DRAWINGS, WHERE NO PRESSURE CLASSES ARE SPECIFIED BY THE DESIGNER, THE SMACNA 1 INCH WG PRESSURE, SEAL CLASS "A".
  - B. ALL DUCTWORK SHALL BE CONSTRUCTED TO SMACNA 1" WG DESIGN AND NOT LESS THAN THE FOLLOWING STANDARDS:
    1. CONSTRUCT SO THAT ALL INTERIOR SURFACES ARE SMOOTH. USE SLIP AND DRIVE OR FLANGED AND BOLTED CONSTRUCTION WHEN FABRICATING RECTANGULAR DUCTWORK. USE SPIRAL LOCK SEAM CONSTRUCTION WHEN FABRICATING ROUND SPIRAL DUCTWORK. SHEET METAL SCREWS MAY BE USED ON DUCT HANGERS, TRANSVERSE JOINTS AND OTHER SMACNA APPROVED LOCATIONS IF THE SCREW DOES NOT EXTEND MORE THAN 1/2 INCH INTO THE DUCT.
    2. SHEET STEEL SHALL COMPLY WITH ASTM A653 STANDARD SPECIFICATION FOR STEEL SHEET METAL, ZINC COATED (GALVANIZED) OR ZINC IRON ALLOY-COATED (GALVANNELED) BY HOT DIP PROCESS, AND A924 STANDARD SPECIFICATION FOR GENERAL REQUIREMENT FOR SHEET METALLIC-COATED BY HOT DIP PROCESS. ALL ANGLE IRON USED FOR SUPPORT SHALL BE GALVANIZED. CONNECTIONS TO WALLS OR FLOOR SHALL BE AIR TIGHT WITH ANGLE IRON AND CAULKING. SEAL ALL DUCT SEAMS, TRANSVERSE AND LONGITUDINAL, AIR TIGHT. PROVIDE TURNING VANES ALL 90° ELBOWS.
    3. USE ELBOWS AND TEES WITH A CENTER LINE RADIUS TO WIDTH OR DIAMETER RATIO OF 1.5 WHEREVER SPACE PERMITS. WHEN A SHORTER RADIUS MUST BE USED DUE TO LIMITED SPACE, INSTALL SINGLE WALL SHEET METAL SPLITTER VANES IN ACCORDANCE WITH SMACNA PUBLICATIONS, TYPE RE 3, WHERE SPACE WILL NOT ALLOW AND THE C VALUE OF THE RADIUS ELBOW, AS GIVEN IN SMACNA PUBLICATIONS, EXCEEDS 0.31. USE RECTANGULAR ELBOWS WITH TURNING VANES AS SPECIFIED IN SECTION 23 33 00. SQUARE THROAT-RADIUS HEEL ELBOWS WILL NOT BE ACCEPTABLE. STRAIGHT TAPS OR BULLHEAD TEES ARE NOT ACCEPTABLE.
    4. WHERE RECTANGULAR ELBOWS ARE USED, PROVIDE TURNING VANES IN ACCORDANCE WITH SECTION 23 33 00.
    5. PROVIDE EXPANDED TAKE-OFFS OR 45 DEGREE ENTRY FITTINGS FOR BRANCH DUCT CONNECTIONS WITH BRANCH DUCTWORK AIRFLOW VELOCITIES GREATER THAN 700 FPM. SQUARE EDGE 90-DEGREE TAKE-OFF FITTINGS OR TRIGHT TAPS WILL NOT BE ACCEPTED.
    6. BUTTON PUNCH SNAP-LOCK CONSTRUCTION WILL NOT BE ACCEPTED ON ALUMINUM DUCTWORK.

END OF SECTION 233113

### SECTION 230593 - TESTING, ADJUSTING, AND BALANCING FOR HVAC

- 1.1 SUMMARY
  - A. TESTING, ADJUSTING, AND BALANCING FOR THE FOLLOWING:
    1. MOTORS.
    2. CONDENSING UNITS.
    3. AIR SYSTEM: CONSTANT VOLUME
  - 1.2 QUALITY ASSURANCE
    - A. THE CONTRACTOR SHALL PROCURE THE SERVICES OF A TESTING, ADJUSTING AND BALANCING (TAB) SPECIALIST WHO SPECIALIZES IN HEATING, VENTILATION AND AIR CONDITIONING SYSTEMS. THE TAB AGENT SHALL HAVE THE FOLLOWING QUALIFICATIONS: AABC, NEBB OR TABB CERTIFIED.
  - 1.3 EXECUTION
    - A. THE TAB SPECIALIST SHALL PERFORM FLOW MEASUREMENTS OF ALL EXISTING AIR AND HYDRONIC SYSTEMS THAT ARE TO REMAIN OR TO BE INCORPORATED INTO NEW WORK PRIOR TO THE STARTING OF WORK IN THE PROJECT SCOPE. A REPORT OF THESE MEASUREMENTS, INDICATING ANY AND ALL DEFICIENCIES SHALL BE SUBMITTED FOR OWNER REVIEW.

- B. THE TAB SPECIALIST SHALL PERFORM FLOW MEASUREMENTS OF ALL NEW AIR AND HYDRONIC SYSTEMS AS LISTED ABOVE IN THE PROJECT SCOPE. A REPORT OF THESE MEASUREMENTS, INDICATING ANY AND ALL DEFICIENCIES SHALL BE SUBMITTED FOR OWNER REVIEW.
- C. THE REPORT SHALL INDICATE A SCHEMATIC DIAGRAM INDICATING LOCATIONS OF ALL EQUIPMENT TESTED AND MEASUREMENT LOCATIONS.
- D. PRIOR TO FINAL INSPECTION OF THE WORK, THE TAB SPECIALIST SHALL BALANCE ALL SYSTEMS AS INDICATED ABOVE TO THE REQUIREMENTS OF THE DESIGN.
- E. THE CONTRACTOR SHALL HAVE FURNISH AND INSTALL ALL ADDITIONAL BALANCING EQUIPMENT, PRESSURE TAPS, GAUGES AND OTHER EQUIPMENT AS REQUIRED FOR A PROPERLY BALANCED SYSTEM AT NO ADDITIONAL COST TO THE OWNER. SUCH ADDITIONAL EQUIPMENT SHALL ADHERE IN STRICT ACCORDANCE WITH THE RESPECTIVE EQUIPMENT MANUFACTURER'S RECOMMENDATIONS.
- F. THE CONTRACTOR SHALL HAVE THE TESTING AND BALANCING SPECIALIST COORDINATE ALL WORK OF THIS SECTION WITH THE BUILDING MANAGER. BALANCING WORK SHALL NOT CONFLICT WITH OTHER WORK SO AS TO MAINTAIN COMPLETION WITHIN THE SPECIFIED TIME.
- G. ALL INSTRUMENTS USED FOR TAB SHALL BE MAINTAINED IN GOOD WORKING CONDITION AND ACCURATELY CALIBRATED.
- H. TOLERANCES: PLUS OR MINUS 5 PERCENT OF DESIGN VALUES.
- I. INSPECTIONS: RANDOM CHECKS BY OWNER OR ARCHITECT TO VERIFY FINAL TESTING, ADJUSTING, AND BALANCING REPORT.
- J. ADDITIONAL TESTS: RANDOM TESTS WITHIN 90 DAYS OF COMPLETING TAB TO VERIFY BALANCE CONDITIONS AND SEASONAL TESTS.

END OF SECTION 230593

### SECTION 233713 - DIFFUSERS, REGISTERS, AND GRILLES

- 1.1 PRODUCTS
  - A. DIFFUSERS, REGISTERS AND GRILLES SHALL BE FURNISHED AND INSTALLED FOR CAPACITIES AND IN LOCATIONS INDICATED ON DRAWINGS. ALL REGISTERS AND DIFFUSERS SHALL BE PRIME COATED STEEL OR EXTRUDED ALUMINUM FINISHED UNLESS OTHERWISE NOTED IN BAKED WHITE ENAMEL.
  - B. MANUFACTURERS: TITUS
    1. SUBJECT TO COMPLIANCE WITH REQUIREMENTS, PROVIDE PRODUCT BY ONE OF THE FOLLOWING:
      - a. HART & COOLEY INC.
      - b. KRUEGER.
      - c. METALAIRE, INC.
      - d. RUSKIN
    - C. ALL DIFFUSERS SHALL HAVE CONTROLLING/EQUALIZING GRID AND OPPOSED BLADE DAMPER UNLESS OTHERWISE NOTED.
    - D. ALL DUCTED RETURN REGISTERS SHALL HAVE AN OPPOSED BLADE DAMPER UNLESS OTHERWISE NOTED.

END OF SECTION 233713

### SECTION 233113 - METAL DUCTS

- 1.1 CONSTRUCTION
  - A. EACH DUCT SYSTEM SHALL BE CONSTRUCTED FOR THE SPECIFIC SMACNA DUCT PRESSURE CLASSIFICATIONS SHOWN ON THE CONTRACT DRAWINGS, WHERE NO PRESSURE CLASSES ARE SPECIFIED BY THE DESIGNER, THE SMACNA 1 INCH WG PRESSURE, SEAL CLASS "A".
  - B. ALL DUCTWORK SHALL BE CONSTRUCTED TO SMACNA 1" WG DESIGN AND NOT LESS THAN THE FOLLOWING STANDARDS:
    1. CONSTRUCT SO THAT ALL INTERIOR SURFACES ARE SMOOTH. USE SLIP AND DRIVE OR FLANGED AND BOLTED CONSTRUCTION WHEN FABRICATING RECTANGULAR DUCTWORK. USE SPIRAL LOCK SEAM CONSTRUCTION WHEN FABRICATING ROUND SPIRAL DUCTWORK. SHEET METAL SCREWS MAY BE USED ON DUCT HANGERS, TRANSVERSE JOINTS AND OTHER SMACNA APPROVED LOCATIONS IF THE SCREW DOES NOT EXTEND MORE THAN 1/2 INCH INTO THE DUCT.
    2. SHEET STEEL SHALL COMPLY WITH ASTM A653 STANDARD SPECIFICATION FOR STEEL SHEET METAL, ZINC COATED (GALVANIZED) OR ZINC IRON ALLOY-COATED (GALVANNELED) BY HOT DIP PROCESS, AND A924 STANDARD SPECIFICATION FOR GENERAL REQUIREMENT FOR SHEET METALLIC-COATED BY HOT DIP PROCESS. ALL ANGLE IRON USED FOR SUPPORT SHALL BE GALVANIZED. CONNECTIONS TO WALLS OR FLOOR SHALL BE AIR TIGHT WITH ANGLE IRON AND CAULKING. SEAL ALL DUCT SEAMS, TRANSVERSE AND LONGITUDINAL, AIR TIGHT. PROVIDE TURNING VANES ALL 90° ELBOWS.
    3. USE ELBOWS AND TEES WITH A CENTER LINE RADIUS TO WIDTH OR DIAMETER RATIO OF 1.5 WHEREVER SPACE PERMITS. WHEN A SHORTER RADIUS MUST BE USED DUE TO LIMITED SPACE, INSTALL SINGLE WALL SHEET METAL SPLITTER VANES IN ACCORDANCE WITH SMACNA PUBLICATIONS, TYPE RE 3, WHERE SPACE WILL NOT ALLOW AND THE C VALUE OF THE RADIUS ELBOW, AS GIVEN IN SMACNA PUBLICATIONS, EXCEEDS 0.31. USE RECTANGULAR ELBOWS WITH TURNING VANES AS SPECIFIED IN SECTION 23 33 00. SQUARE THROAT-RADIUS HEEL ELBOWS WILL NOT BE ACCEPTABLE. STRAIGHT TAPS OR BULLHEAD TEES ARE NOT ACCEPTABLE.
    4. WHERE RECTANGULAR ELBOWS ARE USED, PROVIDE TURNING VANES IN ACCORDANCE WITH SECTION 23 33 00.
    5. PROVIDE EXPANDED TAKE-OFFS OR 45 DEGREE ENTRY FITTINGS FOR BRANCH DUCT CONNECTIONS WITH BRANCH DUCTWORK AIRFLOW VELOCITIES GREATER THAN 700 FPM. SQUARE EDGE 90-DEGREE TAKE-OFF FITTINGS OR TRIGHT TAPS WILL NOT BE ACCEPTED.
    6. BUTTON PUNCH SNAP-LOCK CONSTRUCTION WILL NOT BE ACCEPTED ON ALUMINUM DUCTWORK.

END OF SECTION 233113

SUPPORT SCHEDULE - DUCTWORK			
USG	MAX SIDE INCHES	TRANSVERSE JOINT AND BRACING	
22	UP TO 12	S SLIP, DRIVE, ONE INCH POCKET ON 8 FOOT	
22	13 TO 24	1"X1"X1/8" ANGLES ON 4 FOOT CENTERS	
20	25 TO 35	1"X1"X1/8" ANGLES ON 2 FOOT CENTERS	

- D. PROVIDE TAPPING IN DUCTS FOR THERMOMETERS WHERE SPECIFIED. IN ADDITION, PROVIDE AN AIRTIGHT PLUGGED TAPPING LOCATED AS FOLLOWS:
  1. UPSTREAM OF EACH REHEAT COIL AND VAV BOX.
  2. DOWNSTREAM OF EACH REHEAT COIL AND VAV BOX.
- E. FLAT OVAL OR ROUND DUCTWORK MAY BE PROVIDED IN LIEU OF RECTANGULAR DUCTWORK WITH THE REINFORCEMENT FOR FLAT SIDES SAME AS SPECIFIED FOR THE RECTANGULAR DUCTWORK, AND AS PER SMACNA FLAT OVAL DUCT CONSTRUCTION STANDARDS
- F. ALL DUCTWORK SHALL BE SEALED TO CLASS "A" AND LEAK TESTED TO MEAT SMACNA CLASS 6 FOR RECTANGULAR AND CLASS 3 FOR ROUND DUCTS.

- 1.2 MATERIALS
  - A. SINGLE-WALL RECTANGULAR DUCTS AND FITTINGS.
  - B. SINGLE-WALL ROUND AND FLAT-OVAL DUCTS AND FITTINGS.
  - C. SHEET METAL MATERIALS:
    1. GALVANIZED SHEET STEEL.
    2. STAINLESS-STEEL SHEETS.
    3. ALUMINUM SHEETS.
    4. FACTORY-APPLIED ANTI-MICROBIAL COATING.
  - D. DUCT LINER:
    1. FIBROUS GLASS, TYPE I, FLEXIBLE WITH ANTI-MICROBIAL EROSION-RESISTANT COATING.
    2. FLEXIBLE ELASTOMERIC.
    3. NATURAL FIBER.
  - E. SEALANT MATERIALS:
    1. TWO-PART TAPE SEALING SYSTEM.
    2. WATER-BASED JOINT AND SEAM SEALANT.
    3. SOLVENT-BASED JOINT AND SEAM SEALANT.
    6. FLANGED JOINT SEALANT.
    7. FLANGE GASKETS.
    8. ROUND DUCT JOINT O-RING SEALS.

- 1.3 DUCT CLEANING
  - A. CLEAN EXISTING DUCT SYSTEM(S) BEFORE TESTING, ADJUSTING, AND BALANCING.
  - B. CLEAN THE FOLLOWING ITEMS:
    1. AIR OUTLETS AND INLETS.
    2. SUPPLY, RETURN, AND EXHAUST FANS.
    3. AIR-HANDLING UNITS.
    4. COILS AND RELATED COMPONENTS.
    5. RETURN-AIR DUCTS, DAMPERS, ACTUATORS, AND TURNING VANES.
    6. SUPPLY-AIR DUCTS, DAMPERS, ACTUATORS, AND TURNING VANES.
    7. DEDICATED EXHAUST AND VENTILATION COMPONENTS AND MAKEUP AIR SYSTEMS.

- 1.4 DUCT SCHEDULE
  - A. ALL DUCTS SHALL BE GALVANIZED STEEL EXCEPT AS FOLLOWS:
    1. MOIST ENVIRONMENT DUCT MATERIAL: ALUMINUM.

END OF SECTION 233113

### SECTION 230713 - INSULATION

#### INSULATION - GENERAL REQUIREMENTS

- A. ALL INSULATION MATERIALS, INCLUDING JACKETS, FACING, ADHESIVE, COATINGS, AND ACCESSORIES ARE TO BE FIRE HAZARD RATED AND LISTED BY UNDERWRITERS LABORATORIES, INC. USING STEINER TUNNEL TEST METHOD FOR FIRE HAZARD CLASSIFICATION OF BUILDING MATERIALS, STANDARD UL 723 (ASTM E-84), (ASA A2.5-1963), FLAMESPREAD: MAXIMUM 25, FUEL CONTRIBUTED AND SMOKE DEVELOPED: MAXIMUM 50, FLAMEPROOFING TREATMENTS SUBJECT TO DETERIORATION FROM MOISTURE OR HUMIDITY ARE NOT ACCEPTABLE.
- B. DEFINITIONS:
  - 1) EXPOSED: INDOOR DUCTS, PIPING OR EQUIPMENT LOCATED IN MECHANICAL EQUIPMENT ROOMS AND IN AREAS WHICH WILL BE VISIBLE WITHOUT REMOVING CEILINGS OR OPENING ACCESS PANELS.
  - 2) CONCEALED: INDOOR DUCTS, PIPING OR EQUIPMENT WHICH IS NOT EXPOSED.
  - 3) OUTDOOR: DUCTS, PIPING OR EQUIPMENT WHICH IS EXPOSED TO THE WEATHER.

#### DUCTWORK INSULATION

- A. INSULATE ALL DUCTWORK IN ACCORDANCE WITH INSULATION SCHEDULE EXCEPT AS OTHERWISE NOTED.

INSULATION SCHEDULE - DUCTWORK				
SERVICE	LOCATION	R-VALUE	TYPE	FINISH
SUPPLY/RETURN	CONCEALED	R-6	D-1	VAPORSEAL
SUPPLY/RETURN	EXPOSED	R-12	D-1	VAPORSEAL
INTAKE	ALL	R-12	D-1	VAPORSEAL
SUPPLY	EXTERIOR	R-12	D-1	VAPORSEAL

- B. REINSULATE ALL DUCTWORK AND PIPING WHICH IS EXISTING TO REMAIN AND WAS DAMAGED DURING CONSTRUCTION OR SHOWN OR REQUIRED TO BE RELOCATED. INSULATE WITH SAME MATERIAL AND THICKNESS.
- C. NON-INSULATED DUCTWORK:

- 1) WHERE SOUND LINING IS OF MINIMUM THICKNESS SPECIFIED FOR INSULATION.
- 2) AIR CONDITIONING RETURN AIR DUCTWORK EXPOSED IN AIR CONDITIONED SPACES AND INSTALLED IN HUNG CEILINGS WHERE SPACE IMMEDIATELY ABOVE AND BELOW ARE BOTH AIR CONDITIONED MATERIAL:

PROJECT INFORMATION:  
  
**KIDSUNITED**

MECHANICAL SPECIFICATIONS

DRAWING TITLE:  
  
MECHANICAL SPECIFICATIONS


DRAWING NO.:  
  
**M-0.2**

**GENERAL NOTES:**

- A. CONTRACTOR SHALL BALANCE EACH DEVICE WITH THE CFM SHOWN ON PLAN.
- B. NEW DUCTWORK SHOWN ON PLAN ARE SCHEMATIC ONLY. CONTRACTOR SHALL COORDINATE WITH OTHER TRADES FOR PIPING AND DUCTWORK ROUTING, OFFSET AND RUN PIPING. DUCTWORK INSIDE THE STRUCTURE IF REQUIRED, PROVIDE ANY EXTRA PIPING, DUCTWORK, FITTINGS, INSULATIONS AND OTHER ACCESSORIES IN ORDER TO COMPLETE THE INSTALLATION.
- C. COORDINATE LOCATIONS AND SIZES OF INTAKE & EXHAUST OPENINGS WITH OWNER AND RESPECTIVE ENGINEER.
- D. EQUIPMENT SIZES, DIMENSIONS AND REQUIRED CONNECTIONS SHALL BE VERIFIED WITH THE ACTUAL EQUIPMENT SELECTED. VENDOR DRAWINGS BEFORE FABRICATION OF DUCTWORK, PIPING ETC.
- E. DUCT SIZES SHOWN ON PLANS ARE CLEAR INSIDE AIR STREAM DIMENSIONS.
- F. CONTRACTOR SHALL COORDINATE ALL ELECTRICAL REQUIREMENTS FOR ALL HVAC BASED ON ACTUAL EQUIPMENT SELECTED PRIOR TO INSTALLATION.
- G. CONTRACTOR SHALL COORDINATE EQUIPMENT WEIGHTS AND SUPPORTS BASED ON ACTUAL EQUIPMENT SELECTED.
- H. COORDINATE WITH ALL TRADES FOR MATERIALS IN RATED AND PLENUM SPACES.
- I. NEW DUCTWORK IN CONCEALED AREAS MAY BE RECTANGULAR WITH EQUIVALENT CROSS SECTIONAL FLOW AREA.
- J. PROVIDE INTERNAL INSULATION FOR ALL EXPOSED DUCTWORK AND EXTERNAL FOR ALL DUCTWORK IN CONCEALED AREAS.
- K. PROVIDE FIRE OR FIRE+SMOKE DAMPER WHEREVER DUCTS ARE CROSSING FIRE/SMOKE RATED WALLS/BARRIERS. COORDINATE WITH ARCHITECTURAL DRAWINGS FOR FIRE RATINGS OF THE WALLS.
- L. ARCHITECTURAL LAYOUT AND DIMENSIONS FOR EQUIPMENT TO TAKE PRECEDENCE OVER MEP.
- M. LIMIT FLEXIBLE DUCT LENGTH TO 5 LINEAR FEET. MAKE SURE DUCT IS FULLY STRETCHED OUT WITH NO KINKS & SHARP BENDS.
- N. PROVIDE CORD OPERATED DAMPER IN INACCESSIBLE CEILING.
- O. THE ENTIRE INSTALLATION SHALL BE GUARANTEED FREE OF DEFECTS AND CONTRACTOR SHALL REPAIR AND / OR REPLACE ANY DEFECTIVE MATERIALS OR EQUIPMENT AT NO COST TO THE OWNER FOR A MINIMUM PERIOD OF ONE YEAR FROM THE DATE OF ACCEPTANCE BY ARCHITECT OR ENGINEER.
- P. ALL WORK SHALL BE SUBJECT TO THE ACCEPTANCE AND APPROVAL OF THE ARCHITECT AND OWNER. THE ARCHITECT SHALL BE NOTIFIED OF ANY AND ALL DISCREPANCIES BETWEEN FIELD CONDITIONS AND THE CONTRACT DOCUMENTS BEFORE PROCEEDING WITH THAT PORTION OF THE WORK. FAILURE OF PROPER NOTIFICATION DOES NOT RELIEVE THE CONTRACTOR. THE CONTRACTOR SHALL CORRECT ANY AND ALL WORK ARISING FROM SUCH FAILURE TO COORDINATE DISCREPANCIES TO THE SATISFACTION OF THE ARCHITECT WITHOUT ADDITIONAL COST TO THE OWNER.
- Q. THE CONTRACTOR SHALL, UPON COMPLETION OF PROJECT, PERFORM A COMPLETE TEST AND BALANCE OF ALL EQUIPMENT. PROVIDE A WRITTEN REPORT TO THE ARCHITECT. ALL CAPACITIES MUST BE SET TO WITHIN ±10% OF AMOUNTS INDICATED ON THE FLOOR PLAN AND SCHEDULES.
- R. CONTRACTOR TO COORDINATE FSD WITH ELECTRICAL CONTRACTOR FOR POWER REQUIREMENT.


**KEYED NOTES:**

- 1. CONDENSATE DRAIN TO BE REMAIN AS IT IS FOR EXISTING AHU. CONTRACTOR TO FLUSH THE EXISTING DRAIN. CONTRACTOR TO CLEAN/REPAIR/REPLACE DRAIN IF FOUND DAMAGED. CONTRACTOR TO FIELD VERIFY EXACT LOCATION OF EXISTING AHU.
- 2. PROVIDE REMOTE TEMP SENSOR MOUNTED IN RETURN DUCT AND WIRE BACK TO T-STAT.
- 3. CONTRACTOR TO REUSE EXISTING THERMOSTAT AND RELOCATION TO LOCATION AS SHOWN ON PLAN. IF THERMOSTAT IS NOT REUSABLE OR DAMAGED, PROVIDE NEW 7-DAY PROGRAMMABLE THERMOSTAT. MOUNT ON WALL AT 48" A.F.F. COORDINATE EXACT LOCATION WITH ARCHITECT AND OWNER PRIOR TO ROUGH-IN. PROVIDE LOCKABLE COVER.
- 4. EXTEND FULL SIZE SUPPLY & RETURN DUCTWORK FROM UNIT TO SPACE. ACOUSTICALLY LINE THE FIRST 10 FEET OF BOTH SUPPLY AND RETURN MAIN DUCTS.
- 5. MD TO INTERLOCK WITH RESPECTIVE AHU.
- 6. CONTRACTOR TO RELOCATE EXISTING CEILING MOUNTED EXHAUST FAN AS PER NEW RCP. CEILING MOUNTED FAN TO BE REUSED ALONG WITH ALL REQUIRED ACCESSORIES. PROVIDE NEW DUCTWORK IF REQUIRED AND TERMINATE ON EXISTING LOUVER. CONTRACTOR TO VERIFY IF FAN IS IN PROPER WORKING CONDITION. CLEAN/REPAIR/REPLACE ANY PART OF FAN IF IT IS IN DAMAGED CONDITION.
- 7. EXISTING COMBUSTION AIR INTAKE AND FLUE VENT FOR AHU TO REMAIN AS IT IS.
- 8. CONTRACTOR TO CAPPED OFF/SEAL THE UNUSED EXISTING LOUVER AND REMOVE DUCTWORK AND EXHAUST FANS.
- 9. EXISTING ACCU TO REMAIN ALONG WITH ALL ACCESSORIES. REPAIR/REPLACE ANY ACCESSORIES AS REQUIRED TO PROVIDE FULLY FUNCTIONING. CONTRACTOR TO FIELD VERIFY EXACT LOCATION OF ACCU ON ROOF.
- 10. EXISTING AHU TO REMAIN ALONG WITH ALL ACCESSORIES. REPAIR/REPLACE ANY ACCESSORIES AS REQUIRED TO PROVIDE FULLY FUNCTIONING. CONTRACTOR TO FIELD VERIFY EXACT LOCATION OF AHU.

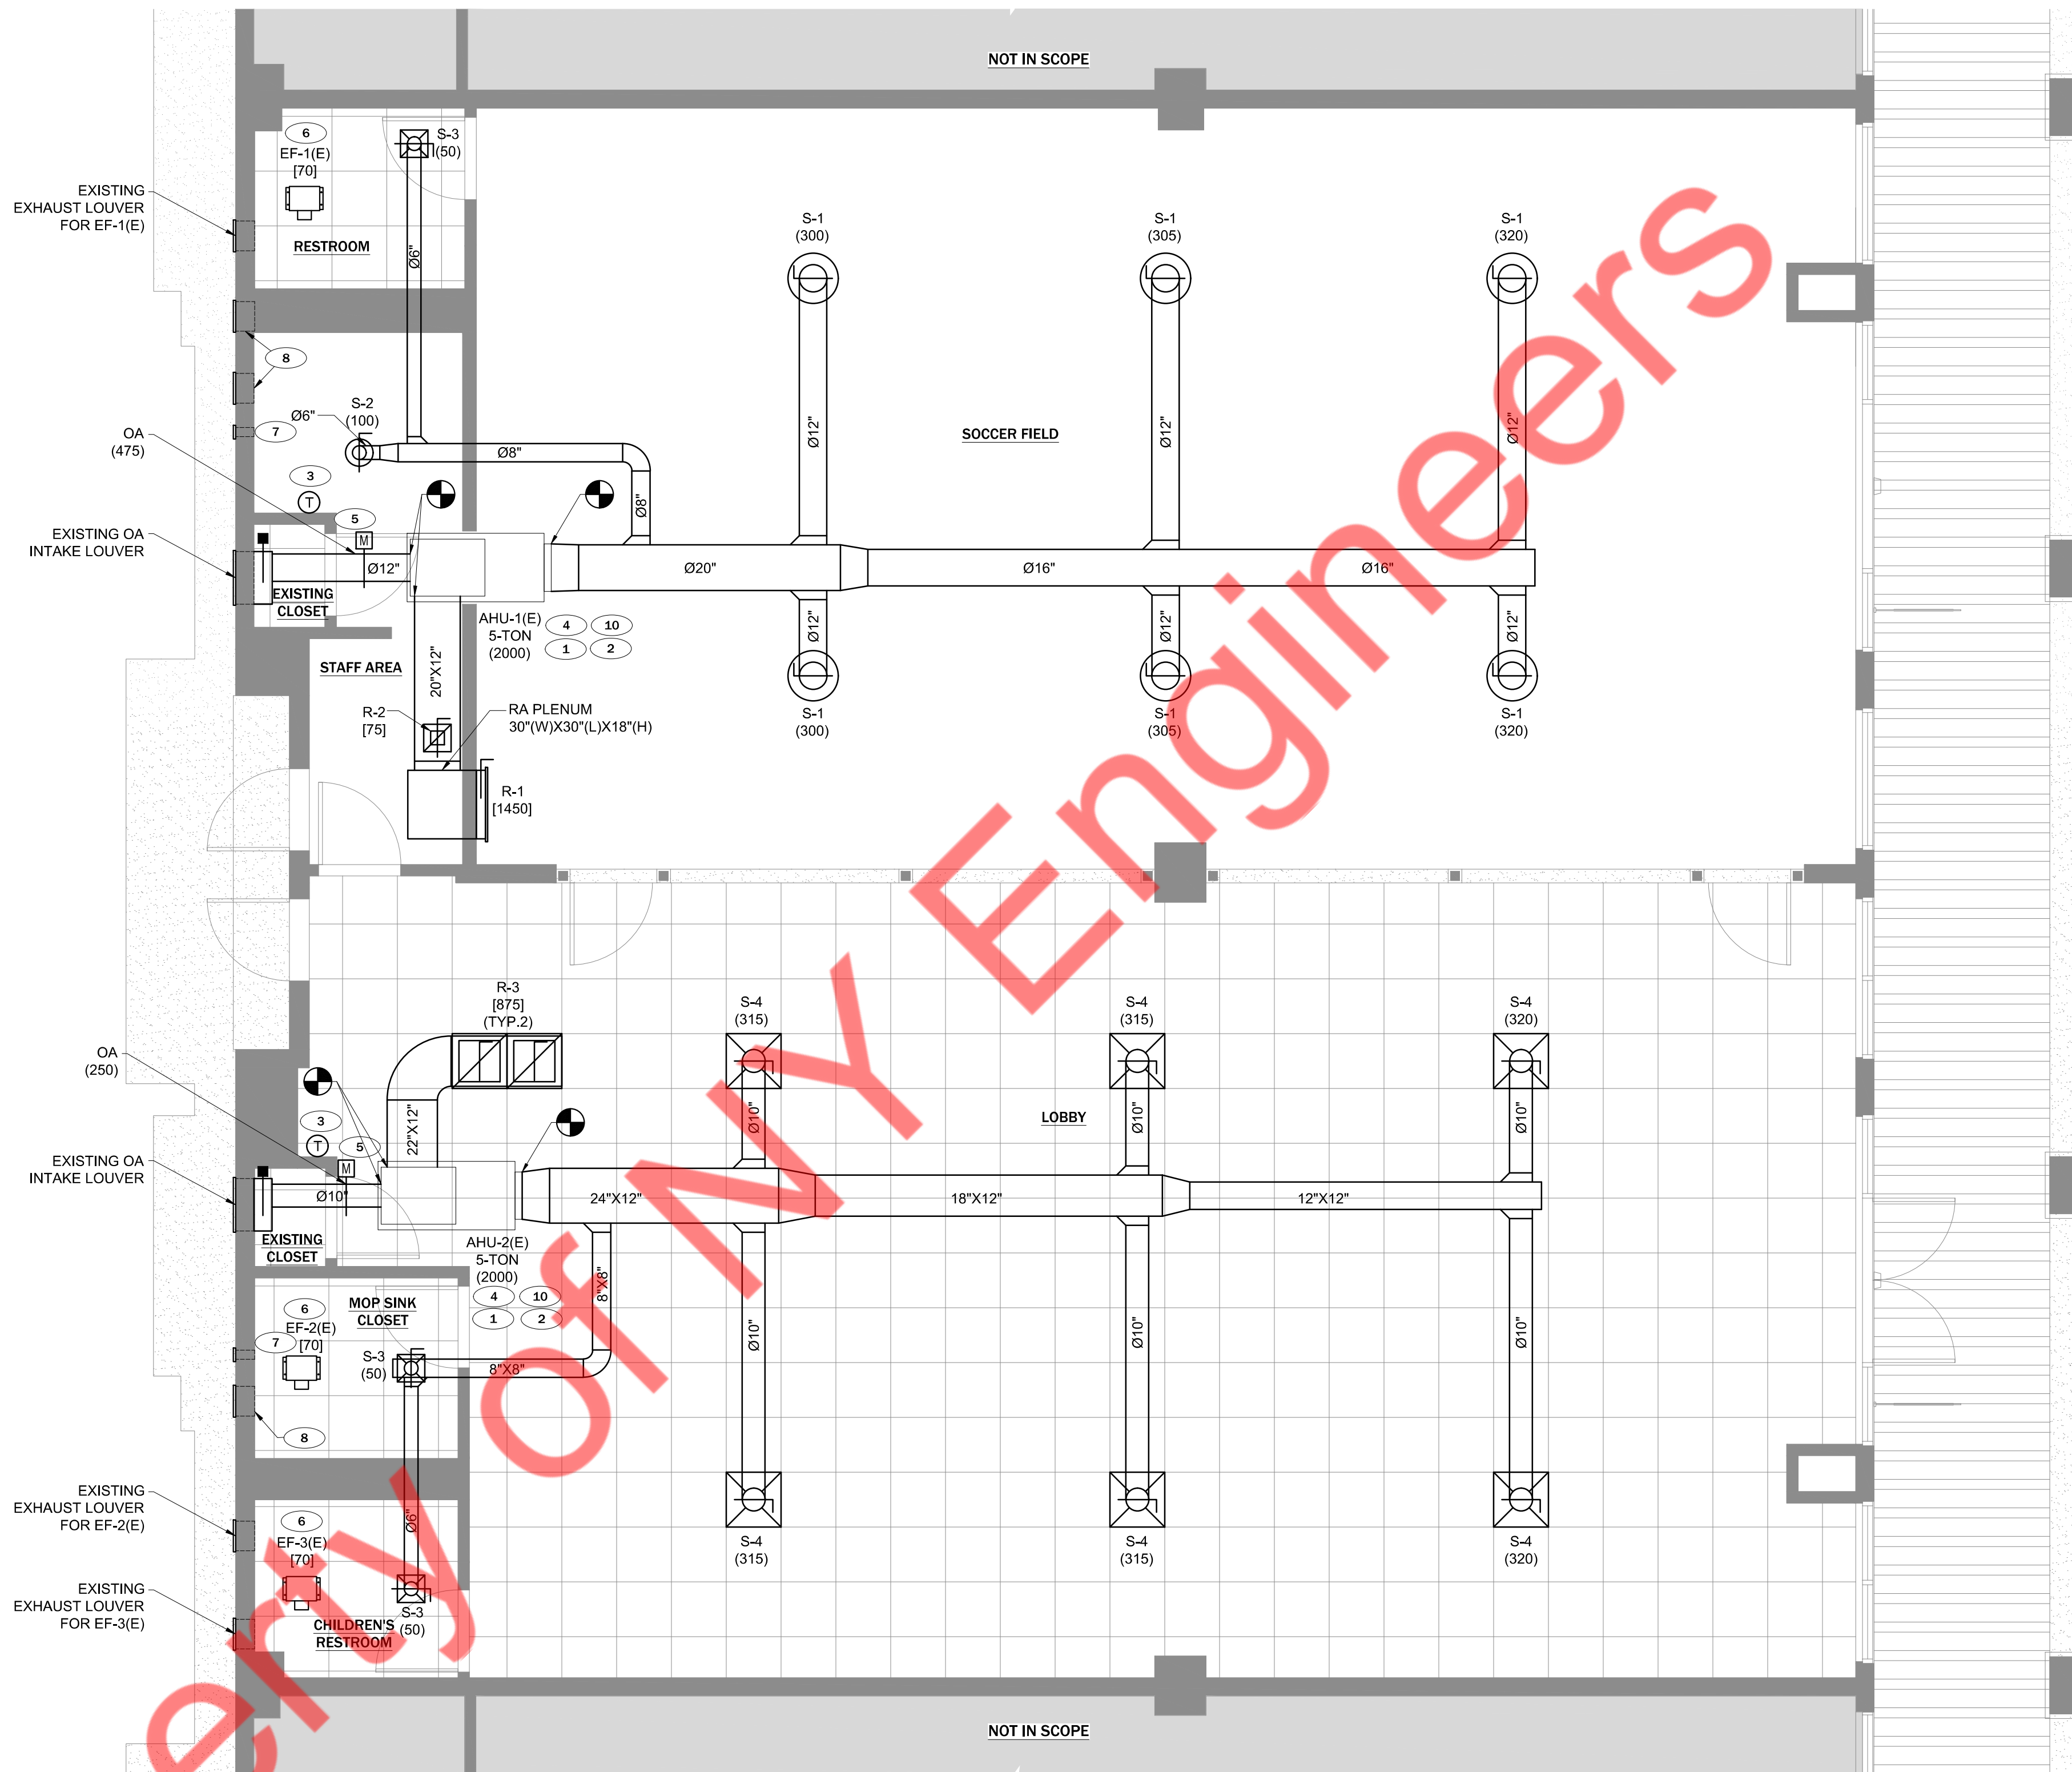

**1 MECHANICAL FLOOR PLAN**

1/4"=1'-0"

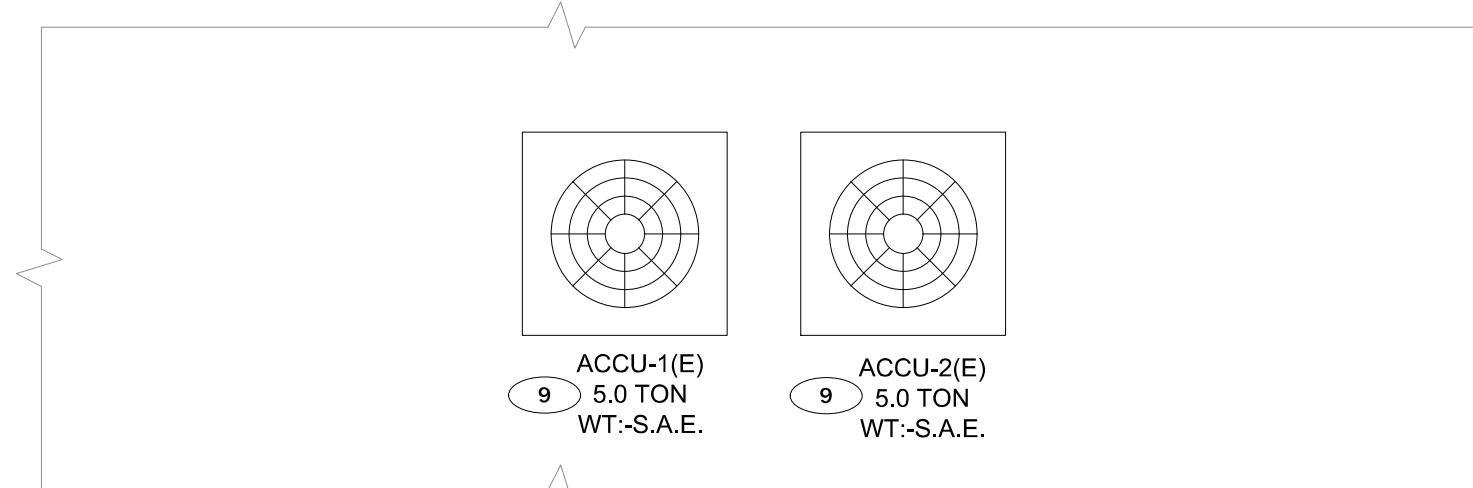

**2 MECHANICAL PART ROOF PLAN**

1/4"=1'-0"

**PROJECT INFORMATION:**


**KIDSUNITED**

**DRAWING TITLE:**

**MECHANICAL FLOOR AND PART ROOF PLAN**

**DRAWING NO.:**


**M-1.0**

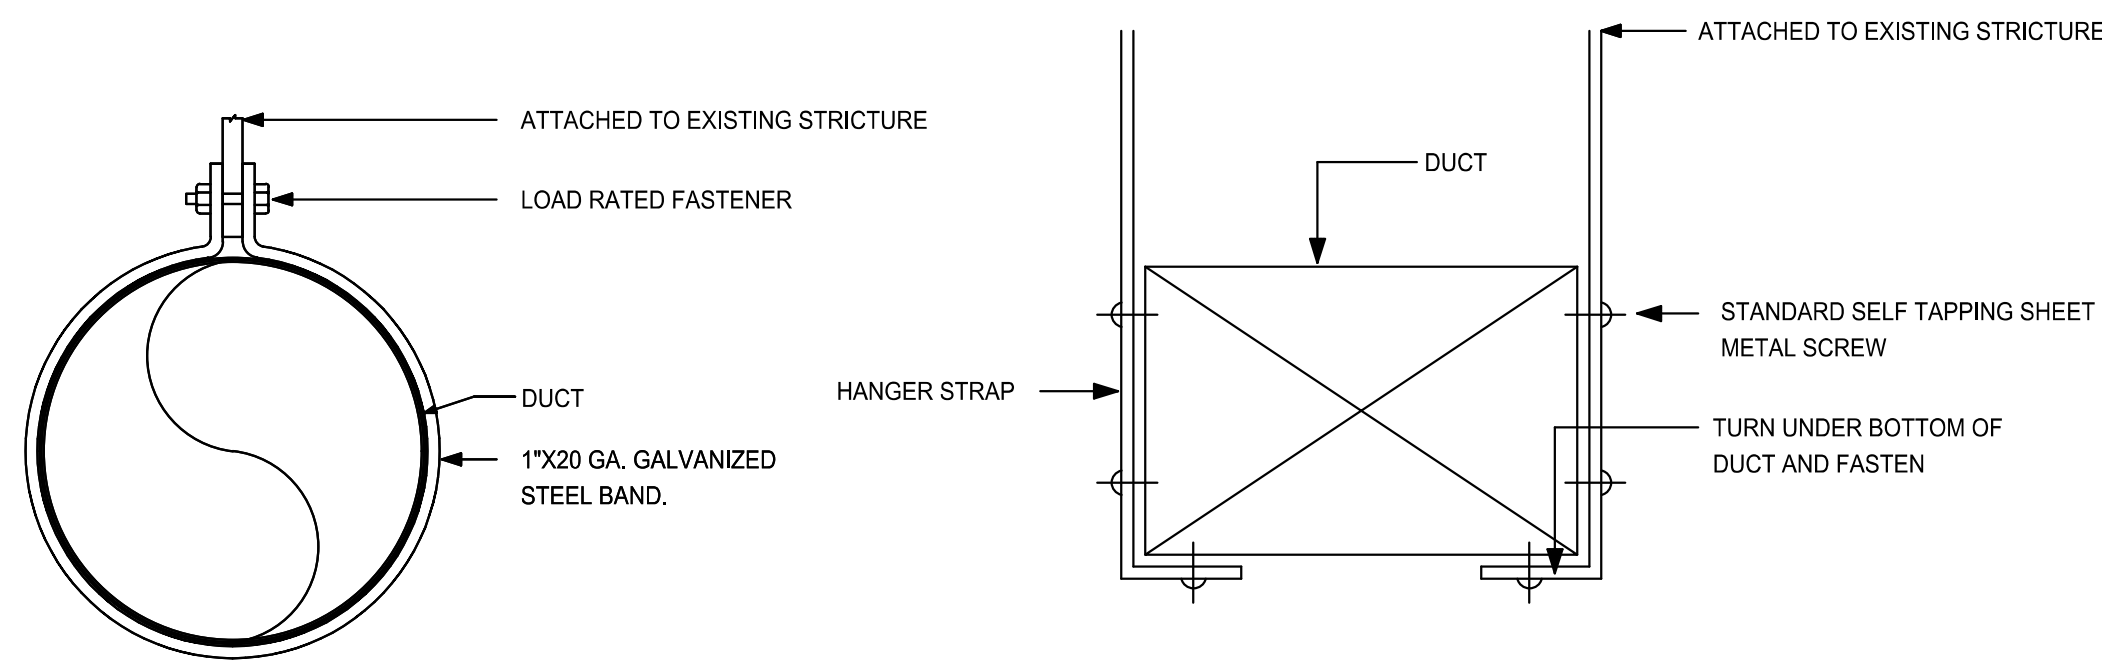

- NOTES:
1. DUCT CONSTRUCTION SHALL CONFORM TO LOW PRESSURE MATCH CONSTR. STD.
  2. DUCTS SHALL BE FABRICATED WITH LONGITUDINAL SEAMS.
  3. PROVIDE ONE PRIME-COAT PAINT FOR ROUND DUCTS INSTALLED IN EXPOSED AREAS.


DUCT HANGER SCHEDULE		
DUCT CROSS SECTIONAL AREA	STRAP HANGER SIZE	MAX. SPACING
UNDER 2 SQ. FT.	1" X 1/16"	6'-0" O.C.
2 TO 4 SQ. FT.	1" X 1/8"	8'-0" O.C.
4 TO 8 SQ. FT.	1" X 1/8"	6'-0" O.C.
OVER 8 SQ. FT.	1" X 1/8"	4'-0" O.C.

**1 DUCTWORK HANGING DETAILS**  
N.T.S.

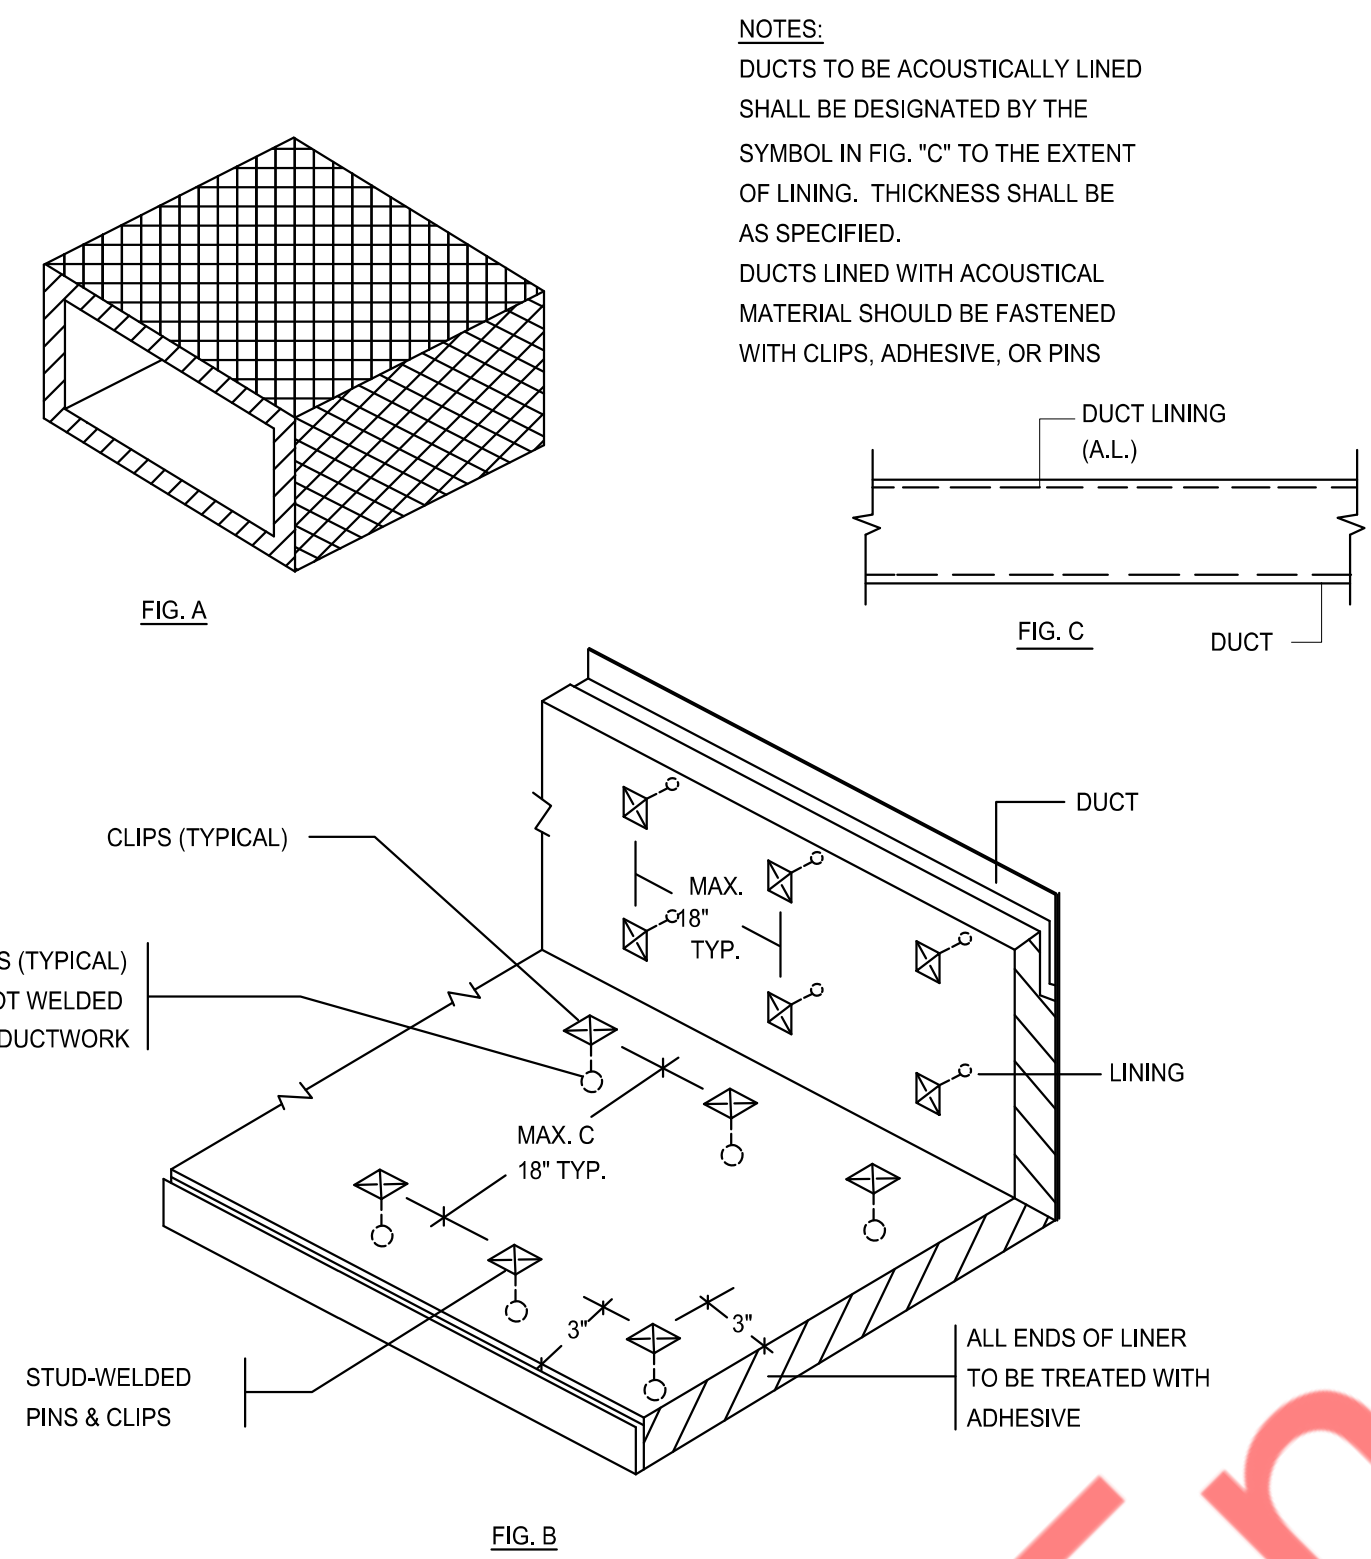


- NOTES:
- DUCTS TO BE ACOUSTICALLY LINED SHALL BE DESIGNATED BY THE SYMBOL IN FIG. "C" TO THE EXTENT OF LINING. THICKNESS SHALL BE AS SPECIFIED.
  - DUCTS LINED WITH ACOUSTICAL MATERIAL SHOULD BE FASTENED WITH CLIPS, ADHESIVE, OR PINS


**2 ACCOUSTICAL TREATMENT DUCT LINING**  
N.T.S.

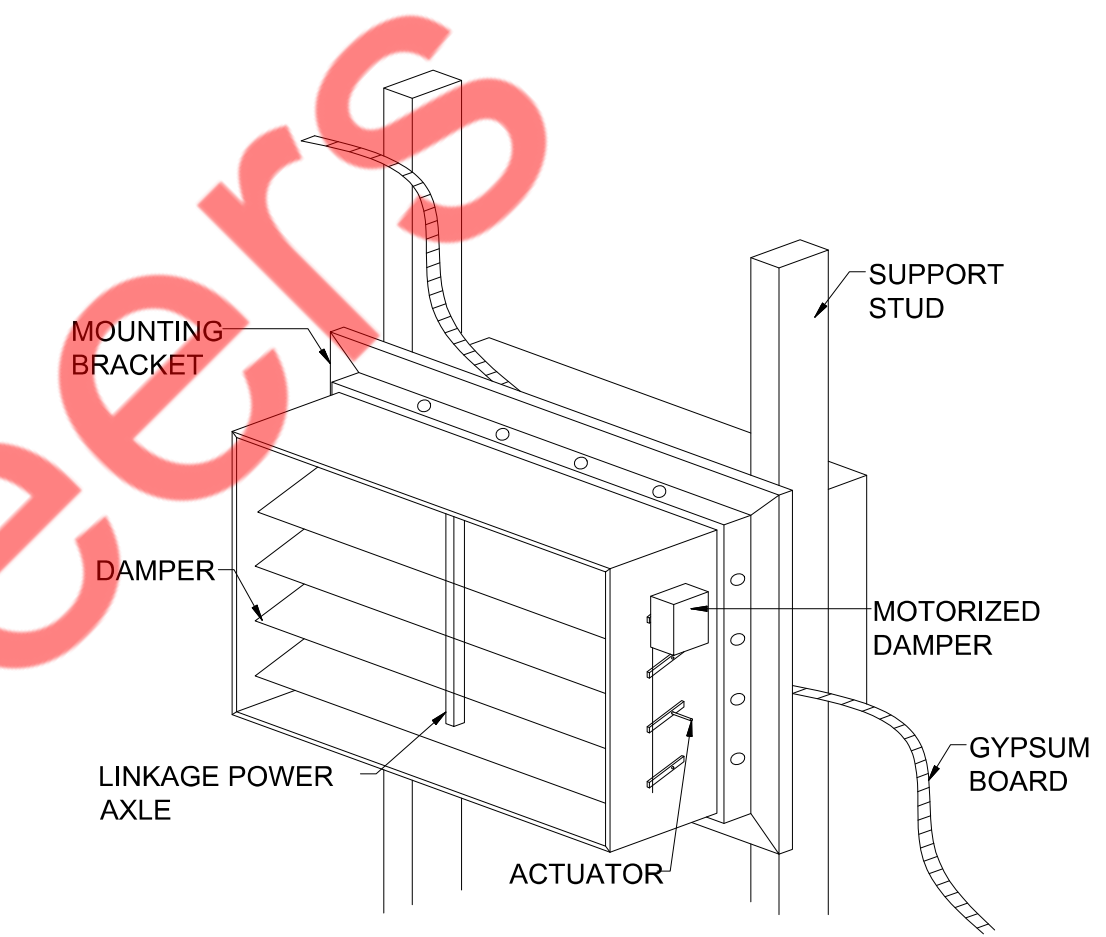


**3 MOTORIZED DAMPER DETAILS**  
N.T.S.

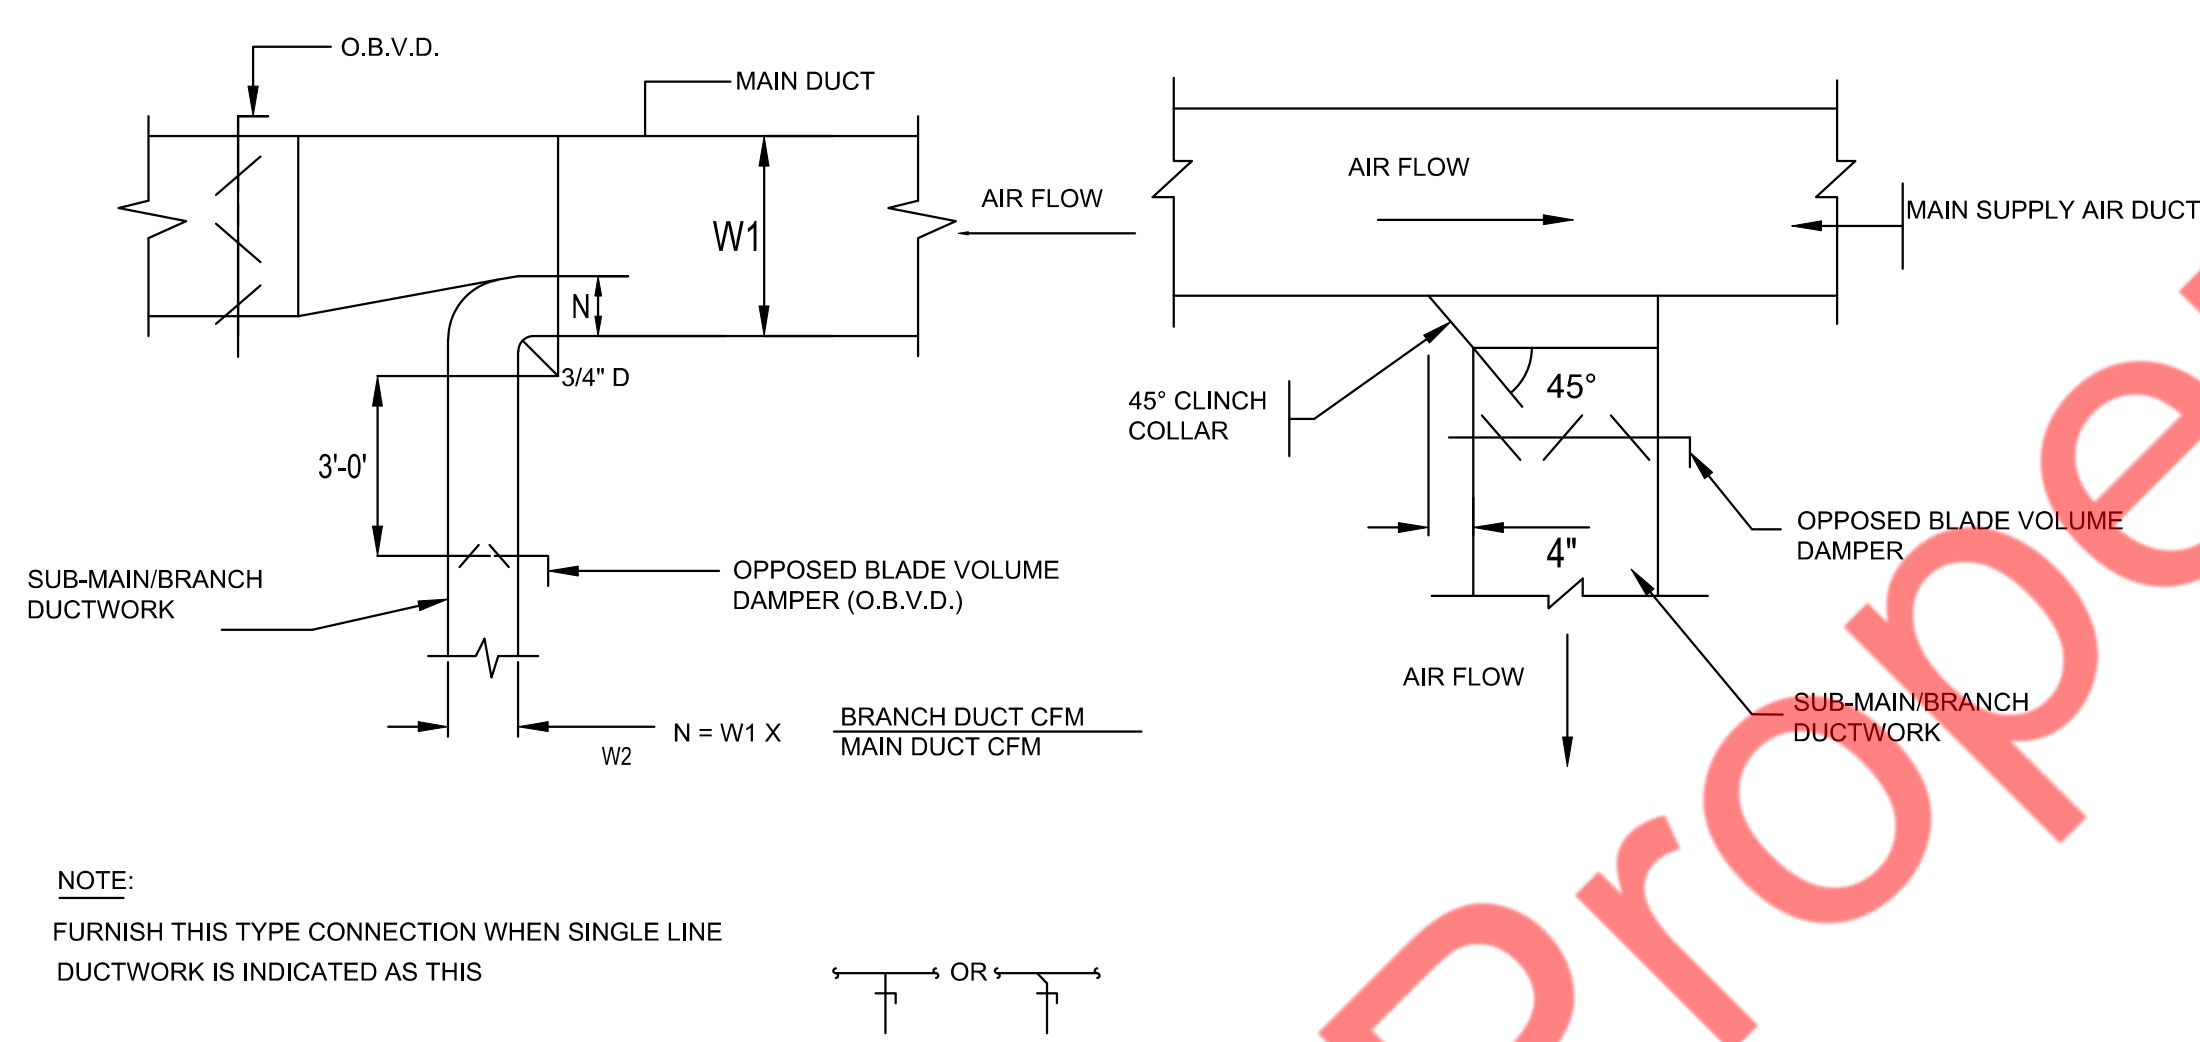

 
NOTE:  
FURNISH THIS TYPE CONNECTION WHEN SINGLE LINE DUCTWORK IS INDICATED AS THIS



**4 SUPPLY AIR DUCTWORK SUB-MAIN BRANCH DUCT CONNECTION**  
N.T.S.

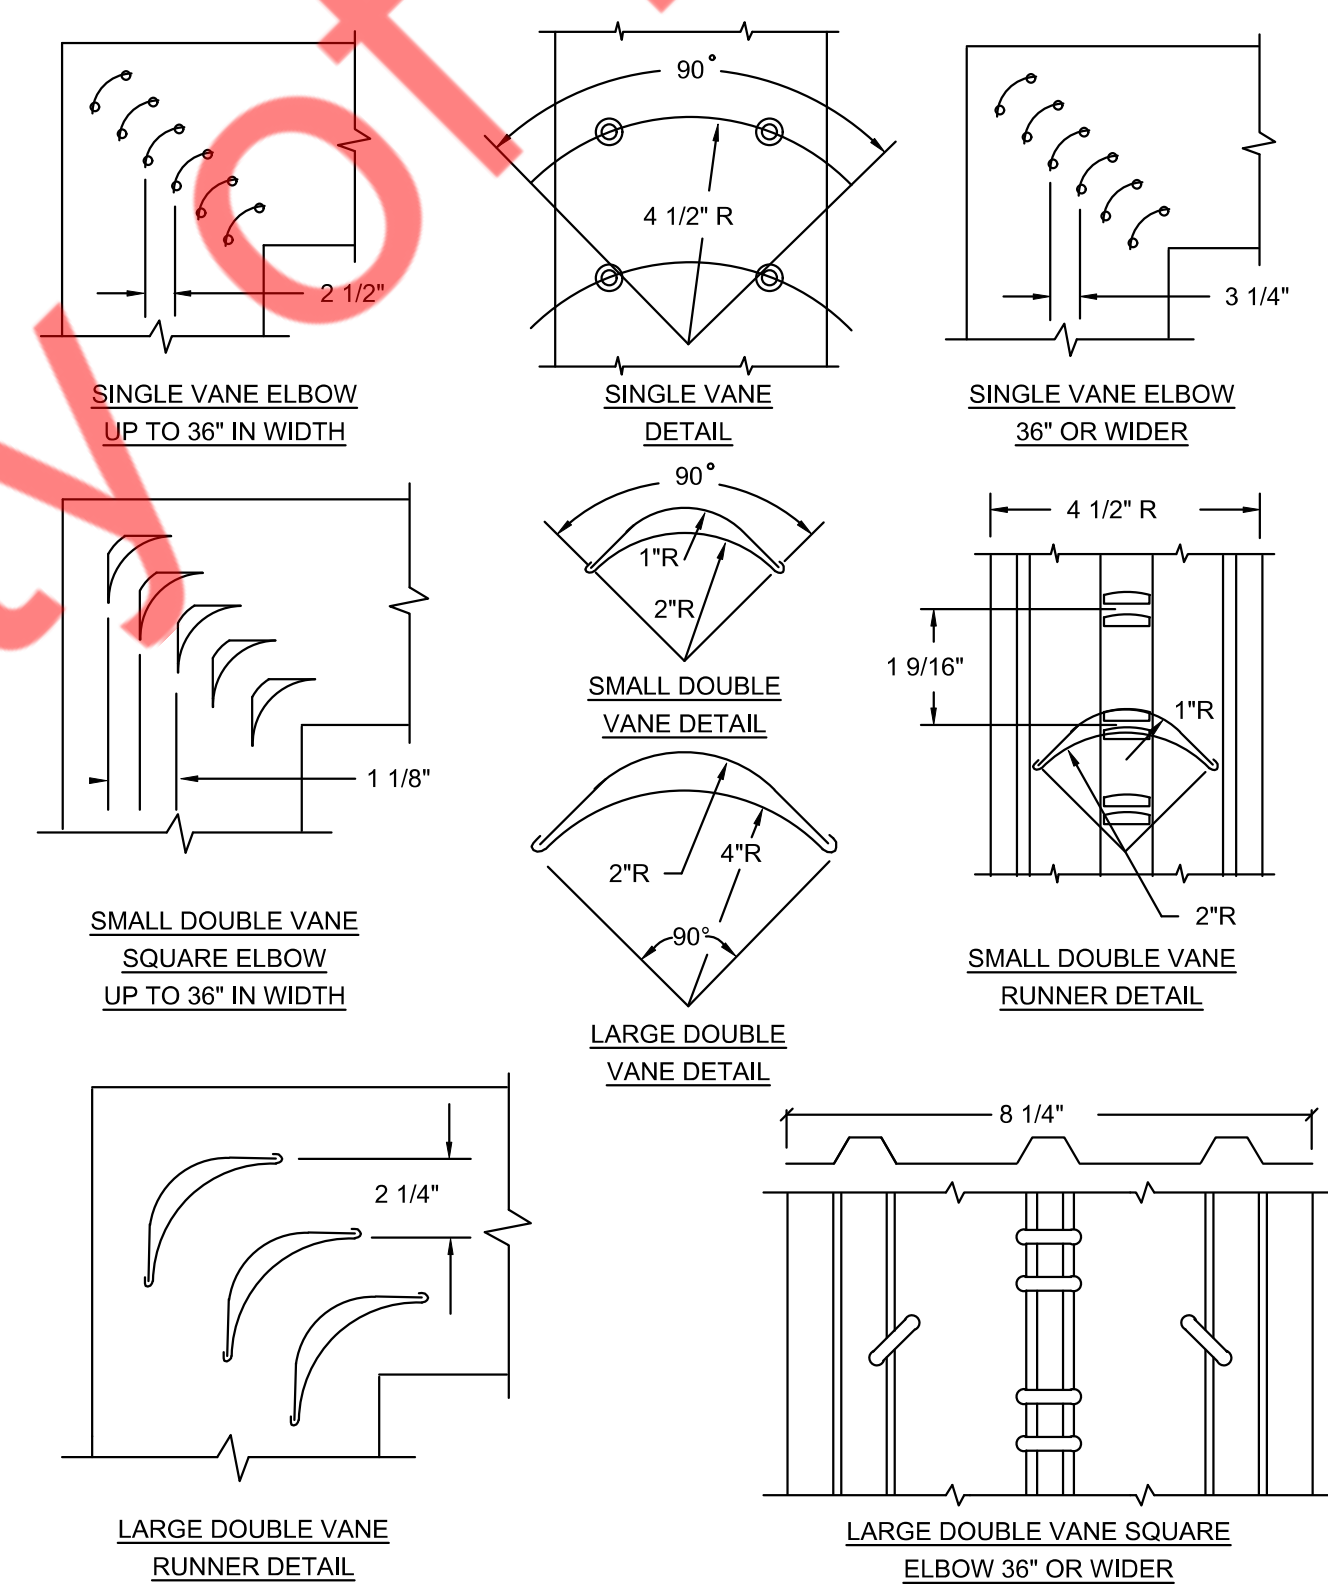

**5 LOW VELOCITY DUCTWORK ELBOWS**  
N.T.S.

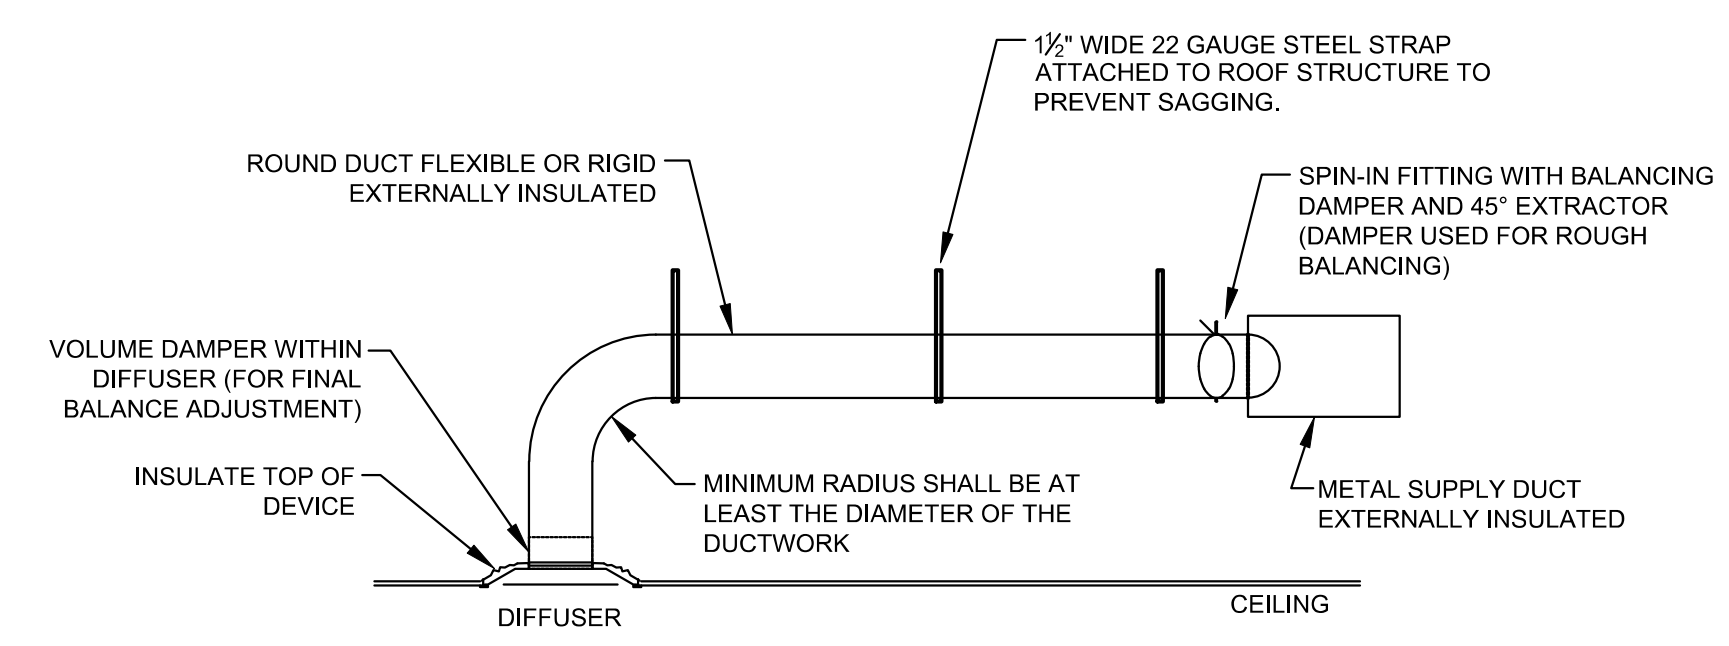

**6 TYPICAL DIFFUSER CONNECTION DETAILS**  
N.T.S.

PROJECT INFORMATION:  
**KIDSUNITED**

DRAWING TITLE:  
**MECHANICAL DETAILS (1 OF 2)**

DRAWING NO.:  
**M-2.0**

INDOOR UNIT SCHEDULE														MAKE:- CARRIER				
UNIT TAG	LOCATION	AREA SERVED	CAP. (TON)	COOLING			TOTAL CFM	OUTDOOR CFM	MAX RATED ESP. (IN. WG)	ELECTRICAL DATA			DIMENSIONS (HxWxD) (IN.)	PIPE SIZE (INCH)			WEIGHT (LBS.)	MODEL NO.
				MBH	INPUT MBH	OUTPUT MBH				PH/VOLT/Hz	MCA (A)	MOP (A)		LIQ.	SUCTION	DRAIN (ID)		
AHU-1(E)	SEE ON PLAN	SEE PLAN	5 & V.I.F.	S.A.E.	S.A.E.	S.A.E.	2000 & V.I.F.	475	S.A.E.	S.A.E.	S.A.E.	S.A.E.	S.A.E.	S.A.E.	S.A.E.	S.A.E.	V.I.F.	
AHU-2(E)	SEE ON PLAN	SEE PLAN	5 & V.I.F.	S.A.E.	S.A.E.	S.A.E.	2000 & V.I.F.	250	S.A.E.	S.A.E.	S.A.E.	S.A.E.	S.A.E.	S.A.E.	S.A.E.	S.A.E.	V.I.F.	

NOTES:-  
1. EXISTING SYSTEM WITH ALL ACCESSORIES TO REMAIN SAME TO BE REUSED.  
2. S.A.E. : SAME AS EXISTING & V.I.F. : VERIFY IN FIELD.  
3. CONTRACTOR TO FIELD VERIFY IN AHU AND ACCU IN WORKING AT THEIR 100% RATED CAPACITY. INFORM TO DESIGN ENGINEER IF ANY DISCREPANCIES ARE FOUND IN PERFORMANCE PRIOR TO CONSTRUCTION.  
4. PROVIDE NEW THERMOSTAT COMPATIBLE WITH THE EXISTING AC UNIT AND COORDINATE THE FINAL LOCATION WITH THE ARCHITECT/OWNER.  
5. CONTRACTOR TO BALANCE OUTSIDE AIR & RETURN AIR DAMPER ON EXISTING UNIT TO MATCH MENTIONED VALUE IN ABOVE TABLE.  
6. REPLACE FILTER WITH NEW FILTER IF REQUIRED.  
7. CONTRACTOR SHALL VERIFY EXACT ELECTRICAL CONDITION, WIRE SIZES, BREAKERS, DISCONNECT ETC. PRIOR TO OPENING BID.

OUTDOOR UNIT SCHEDULE														MAKE:- CARRIER			
UNIT TAG	LOCATION	INDOOR UNIT SERVED	CAP. TR	COOLING MBH	UNIT DIMENSIONS (HxWxD)(IN.)	WEIGHT (LBS)	PIPING		ELECTRICAL DATA			REFRIGERANT	MODEL NO.				
							LIQUID (INCH)	GAS (INCH)	(V/Hz/Ph)	MCA (A)	MOP (A)			EER	SEER		
ACCU-1(E)	SEE ON PLAN	AHU-1(E)	5 & V.I.F.	S.A.E.	S.A.E.	S.A.E.	S.A.E.	S.A.E.	S.A.E.	S.A.E.	S.A.E.	S.A.E.	S.A.E.	V.I.F.			
ACCU-2(E)	SEE ON PLAN	AHU-2(E)	5 & V.I.F.	S.A.E.	S.A.E.	S.A.E.	S.A.E.	S.A.E.	S.A.E.	S.A.E.	S.A.E.	S.A.E.	S.A.E.	V.I.F.			

NOTES:-  
1. EXISTING SYSTEM WITH ALL ACCESSORIES TO REMAIN SAME TO BE REUSED.  
2. S.A.E. : SAME AS EXISTING & V.I.F. : VERIFY IN FIELD.  
3. CONTRACTOR TO FIELD VERIFY IN AHU AND ACCU IN WORKING AT THEIR 100% RATED CAPACITY. INFORM TO DESIGN ENGINEER IF ANY DISCREPANCIES ARE  
4. PROVIDE NEW THERMOSTAT COMPATIBLE WITH THE EXISTING AC UNIT AND COORDINATE THE FINAL LOCATION WITH THE ARCHITECT/OWNER.  
5. CONTRACTOR SHALL PROVIDE A LONG LINE SET FOR REFRIGERANT PIPING IN THE EVENT THAT TOTAL REFRIGERANT LENGTH EXCEED THE MANUFACTURER'S  
6. CONTRACTOR SHALL VERIFY EXACT ELECTRICAL CONDITION, WIRE SIZES, BREAKERS, DISCONNECT ETC. PRIOR TO OPENING BID.

VENTILATION CALCULATIONS AS PER IMC-2021													
ROOM NAME	AREA (SQ.FT.)	NO. OF PEOPLE/1000sq.ft AS PER IMC-2021	NO. OF PEOPLE AS PER IMC-2021	NO. OF CHAIR	FINAL PEOPLE NO.	MIN OUTSIDE AIR		REQ. OA (CFM)	PROVIDED OA (CFM)	EXHAUST AIRFLOW RATE (CFMSQ.FT OR CFM/FIXT.)	TOTAL EXHAUST (CFM)	PROVIDED EXHAUST (CFM)	
						CFM/PEOPLE	CFMSQ.FT						
SOCCER FIELD	1385	7	10	-	10	20	0.18	449	475	-	-	-	
STAFF AREA	130	5	1	2	2	5	0.06	18	475	-	-	-	
RESTROOM	50	-	-	-	-	-	-	-	250	70	70	70	
LOBBY	1550	30	47	-	30	5	0.06	243	250	-	-	-	
MOP SINK CLOSET	50	-	-	-	-	-	-	-	250	-	-	70	
CHILDREN'S RESTROOM	50	-	-	-	-	-	-	-	250	70	70	70	
<b>TOTAL</b>									<b>710</b>	<b>725</b>	-	<b>210</b>	

AIR BALANCE						
UNIT	AREA SERVED	SUPPLY AIR (CFM)	OUTSIDE AIR (CFM)	RETURN AIR (CFM)	EX-HAUST AIR(CFM)	
AHU-1(E)	SEE PLAN	2000	475	1525	-	
AHU-2(E)	SEE PLAN	2000	250	1750	-	
EF-1(E)	SEE PLAN	-	-	-	70	
EF-2(E)	SEE PLAN	-	-	-	70	
EF-3(E)	SEE PLAN	-	-	-	70	
TOTAL:		4000	725	3275	210	
<b>BUILDING PRESSURE:</b>			515	<b>POSITIVE</b>		

NOTES:  
1. CONTRACTOR TO ADJUST MOTORIZED DAMPER ON OUTSIDE AIR TAP TO PROVIDE OUTSIDE AIR AS MENTIONED IN ABOVE TABLE.

DIFFUSER AND REGISTER SCHEDULE					
UNIT ID	MANUFACTURER	MODEL	FACE SIZE	NECK SIZE	DESCRIPTION
S-1	TITUS	TMR-AA	Ø22"	REFER TABLE A	ROUND DIFFUSER
S-2	TITUS	TMR-AA	Ø12"	REFER TABLE A	ROUND DIFFUSER
S-3	TITUS	TDC-AA	12"x12"	REFER TABLE A	4-WAY LOVERED DIFFUSER
S-4	TITUS	TDC-AA	24"x24"	REFER TABLE A	4-WAY LOVERED DIFFUSER
R-1	TITUS	350RL	32"x18"	30"x16"	LOUVERED GRILLE
R-2	TITUS	350RL	12"x12"	REFER TABLE A	LOUVERED GRILLE
R-3	TITUS	350RL	24"x24"	REFER TABLE A	LOUVERED GRILLE

NOTES / ACCESSORIES:  
1. MAXIMUM NOISE CRITERION RATING < 35 DBA.  
2. BAKED ENAMEL FINISH, COLOR TO BE SELECTED BY ARCHITECT.  
3. DIFFUSERS SHALL BE 4-WAY BLOW UNLESS OTHERWISE INDICATED ON PLANS.  
4. MOUNTING FRAME TYPE SHALL BE COORD. WITH CEILING / WALL/ DOOR CONSTRUCTION TYPE.

TABLE -A	
ROUND NECK SIZES SCHEDULE:	SQUARE NECK SIZE SCHEDULE:
6" DIA : Up To 100 CFM	6"x6" : 0 - 115 CFM
8" DIA : 101 To 180 CFM	8"x8" : 116 - 220 CFM
10" DIA : 181 To 285 CFM	10"x10" : 221 - 350 CFM
12" DIA : 286 To 400 CFM	12"x12" : 351 - 520 CFM
14" DIA : 401 To 550 CFM	14"x14" : 521 - 730 CFM
	16"x16" : 731 - 840 CFM
	18"x18" : 840 - 1035 CFM
	20"x20" : 1036 - 1285 CFM
	22"x22" : 1286 - 1570 CFM


 

 
Property of NY Engineers

PROJECT INFORMATION:  
  
KIDSUNITED


DRAWING TITLE:  
  
MECHANICAL SCHEDULES

DRAWING NO.:  
  
**M-3.0**


## SWITCHES AND CONTROLS

	SINGLE POLE SWITCH
	WALL OCCUPANCY SENSOR
	DIMMER SWITCH
	OVERRIDE SWITCH

 

## POWER DISTRIBUTION

	DISTRIBUTION PANELBOARD, SURFACE OR FLUSH MOUNTED.
---	--



 

## ANNOTATION

+24"	INDICATES MOUNTING HEIGHT, CENTER LINE TO FINISHED FLOOR
	KEYED NOTE REFERENCE






 

 
## WIRING SYSTEMS

	EXISTING
	NEW

## POWER AND TELECOMMUNICATION

	JUNCTION BOX
	DUPLEX CONVENIENCE RECEPTACLE, +18" AFF OR AS NOTED.
	CEILING MOUNTED DUPLEX RECEPTACLE
	DATA OUTLET - (1) PORT UNO, +18" AFF, UNO TEL / DATA OUTLET TO BE PROVIDED WITH 1" CONDUIT U.O.N. TO H.C. AND TERMINATED WITH 90 DEGREE ELBOW AND BUSHING. TEL / DATA OUTLET PLATE SHALL BE PROVIDED WITH 1 1/4" DIAMETER GROMMETTED OPENING.

## MOTORS AND CONTROLS

	AC INDOOR UNIT MOTOR AS NOTED WITH LIQUID TIGHT FLEXIBLE CONNECTION WITH JUNCTION BOX AND MOTOR SWITCH.
	AC OUTDOOR UNIT MOTOR AS NOTED WITH CONTROLLER AND DISCONNECT SWITCH WITH WEATHER PROOF.
	MANUAL MOTOR SWITCH
	NON FUSED DISCONNECT SWITCH AMPERAGE, AND NUMBER OF POLES AS NOTED.
	30A NON FUSED DISCONNECT SWITCH
	60A NON FUSED DISCONNECT SWITCH
	100A NON FUSED DISCONNECT SWITCH
	200A NON FUSED DISCONNECT SWITCH

## ELECTRICAL DRAWING LIST

E-0.1	ELECTRICAL SYMBOL LIST, ABBREVIATION AND GENERAL NOTES
E-0.2	ELECTRICAL SPECIFICATIONS (1 OF 2)
E-0.3	ELECTRICAL SPECIFICATIONS (2 OF 2)
E-1.0	LIGHTING PLAN
E-2.0	ELECTRICAL POWER PLAN & PARTIAL ROOF POWER PLAN
E-3.0	ELECTRICAL DETAILS
E-4.0	ELECTRICAL PANEL SCHEDULE AND RISER DIAGRAM

## ELECTRICAL ABBREVIATIONS

A	AMPERES	EA	EACH
A/C, AC	AIR CONDITIONING UNIT	EC	EMPTY CONDUIT/ ELECTRICAL CONTRACTOR
AF	AMPERE FRAME/AMP FUSE	EF	EXHAUST FAN
AFB	ABOVE FINISHED FLOOR	EM	EMERGENCY
AS	AMP SWITCH	EMT	ELECTRICAL METALLIC TUBING
AIC	AMPS INTERRUPTING CAPACITY	EQUIP	EQUIPMENT
AUTO	AUTOMATIC	ER	EXISTING TO BE RELOCATED
AWG	AMERICAN WIRE GAUGE	ETR	EXISTING TO REMAIN
C	CONDUIT	EFW	ELECTRIFIED WORKSTATION FURNITURE
C/B, CB	CIRCUIT BREAKER	EWH	ELECTRIC WATER HEATER
CKT	CIRCUIT	FA	FIRE ALARM
CLG	CEILING	FBO	FURNISHED BY OTHERS, INSTALLED & WIRED BY EC
COMM	COMMUNICATION	FDR	FEEDER
CT	CURRENT TRANSFORMER	FIBO	FURNISHED & INSTALLED BY OTHERS, WIRED BY EC
CU	COPPER	FIXT	FIXTURE
°C	DEGREE CELSIUS	FL	FLOOR
°F	DEGREE FAHRENHEIT	FLUOR	FLUORESCENT
DIA	DIAMETER	G	GROUND
DISC	DISCONNECT	GFI	GROUND FAULT INTERRUPTER
DN	DOWN	GP	GENERAL PURPOSE
DWG	DRAWING	HC	HUNG CEILING
JB	JUNCTION BOX	HP	HORSEPOWER
KCMIL	ONE THOUSAND CIRCULAR MILS	HWH	HOW WATER HEATER
KV	KILOVOLT	HZ	HERTZ
KVA	KILOVOLT-AMPERES	IC	INTERRUPTING CAPACITY
KW	KILOWATTS	PP	POWER PANEL
LP	LIGHTING PANEL	PVC	POLYVINYL CHLORIDE
LTG	LIGHTING	PWR	POWER
MAX	MAXIMUM	R	REMOVE
MC	MOTOR CONTROLLER	RE	RELOCATED EXISTING
MCB	MAIN CIRCUIT BREAKER	REC	RECEPTACLE
MER	MECHANICAL EQUIPMENT ROOM	RR	REMOVE & RELOCATE
MIN	MINIMUM	SECT	SECTION
MLO	MAIN LUGS ONLY	SPDT	SINGLE POLE DOUBLE THROW
MTD	MOUNTED	SPST	SINGLE POLE SINGLE THROW
N	NEUTRAL	SPEC	SPECIFICATION
NE	NEW DEVICE TO REPLACE EXISTING	SW	SWITCH
NIC	NOT IN CONTRACT	SWBD	SWITCHBOARD
NL	NIGHT LIGHT	SYM	SYMMETRICAL
NTS	NOT TO SCALE	SYS	SYSTEMS
OC	ON CENTER	TELE	TELEPHONE
P	POLES	TEMP	TEMPERATURE
PB	PULLBOX	TXF	TOILET EXHAUST FAN
PC	PERSONAL COMPUTER	TYP	TYPICAL
Ø	PHASE	UON	UNLESS OTHERWISE NOTED
PNL	PANEL	V	VOLT/VOLTAGE
W	WATT	VA	VOLT AMPERE
W	WIRE	VFD	VARIABLE FREQUENCY DRIVE
WH	WALL HEATER	WP	WEATHER PROOF
E	EXISTING	XFMR	TRANSFORMER
		IG	ISOLATED GROUND

## GENERAL NOTES

( APPLY TO ALL "E" DRAWINGS)

- ALL WORK SHALL BE PERFORMED IN STRICT ACCORDANCE WITH THE CURRENT VERSION OF THE NATIONAL ELECTRIC CODE(NEC) 2020 WITH NEW JERSEY AMENDMENTS, LOCAL JURISDICTION REQUIREMENTS, AND ALL GOVERNING LOCAL CODES, LAWS, AND REGULATIONS.
- CONTRACTOR SHALL VISIT THE SITE AND BECOME FAMILIAR WITH ALL EXISTING CONDITIONS THAT MAY AFFECT THE WORK. NO ADDITIONAL COMPENSATION WILL BE CONSIDERED FOR FAILURE TO DO SO.
- CONTRACTOR SHALL OBTAIN AND PAY FOR ALL PERMITS, TEST REPORTS, AND CERTIFICATIONS FOR TEMPORARY AND FINAL CERTIFICATE OF OCCUPANCY.
- FIRE STOP ALL PENETRATIONS OF FIRE RATED CONSTRUCTION IN A CODE APPROVED MANNER IN ORDER TO MAINTAIN FIRE RATING. ALL PENETRATIONS SHALL BE SLEEVED AND SEALED WATERTIGHT.
- SECURE ALL SUPPORTS TO BUILDING STRUCTURE UTILIZING TOGGLE BOLTS (HOLLOW MASONRY), EXPANSION SHIELDS OR INSERTS (CONCRETE AND BRICK), MACHINE SCREWS (METAL), BEAM CLAMPS (FRAMEWORK), WOOD SCREWS (WOOD) OR PAN THRU STRAPS (METAL DECK). NAILS, RAWL PLUGS AND WOOD PLUGS ARE NOT PERMITTED. WHERE REQUIRED BY STRUCTURE, PROVIDE THRU BOLTS AND FISH PLATES. SUPPORT HORIZONTAL RUNS OF METALLIC RACEWAYS NOT MORE THAN 10 FT APART. SUPPORT RACEWAY RISERS AT EACH FLOOR LEVEL. RUN EXPOSED RACEWAYS PARALLEL WITH OR AT RIGHT ANGLES TO WALLS.
- LEAVE WIRES WITH SUFFICIENT SLACK TO PERMIT MAKING FINAL CONNECTIONS. RACEWAYS OVER 10 FT LONG IN WHICH WIRING IS NOT INSTALLED. FURNISH FISH WIRE.
- VERIFY LOCATIONS OF OUTLETS AND SWITCHES IN FINISHED ROOMS WITH ARCHITECTURAL DRAWINGS OF INTERIOR DETAILS AND FINISH. IN CENTERING OUTLETS AND LOCATING BOXES AND OUTLETS, ALLOW FOR OVERHEAD PIPES, DUCTS AND MECHANICAL EQUIPMENT. VARIATIONS IN FIREPROOFING AND PLASTERING, WINDOW AND DOOR TRIM, PANELING, HUNG CEILINGS AND THE LIKE, CORRECT ANY INACCURACY RESULTING FROM FAILURE TO DO SO WITHOUT EXPENSE TO OWNER.
- CONTRACTOR SHALL PROVIDE A WARRANTY ON ALL MATERIALS, EQUIPMENT, AND WORKMANSHIP FOR A PERIOD OF ONE YEAR FROM THE DATE OF FINAL ACCEPTANCE.
- ALL UNUSED MATERIALS AND DEBRIS SHALL BE LEGALLY REMOVED AND DISPOSED OF AWAY FROM THE PREMISES ON A DAILY BASIS.
- CONTRACTOR SHALL PATCH, PAINT, AND RESTORE EXISTING SURFACES DAMAGED DURING THE COURSE OF THIS CONSTRUCTION TO PRE-EXISTING CONDITIONS OR BETTER.
- MINIMUM SIZE OF CONDUIT SHALL BE 3/4", AND TYPE SHALL BE ELECTRICAL METALLIC TUBING (EMT), UNLESS OTHERWISE NOTED. PROVIDE NYLON DRAG LINE AND CONDUIT CAP FOR ALL EMPTY CONDUITS.
- CONNECT CONDUIT TO MOTOR CONDUIT TERMINAL BOXES WITH FLEXIBLE CONDUIT (MINIMUM 18 IN. LENGTH AND 50% SLACK). DO NOT TERMINATE IN OR FASTEN RACEWAYS TO MOTOR FOUNDATION.
- PULL AND JUNCTION BOXES WHERE INDICATED ON THE DRAWINGS, SHALL BE CONSIDERED SHOWN AT THEIR APPROXIMATE LOCATION. THE CONTRACTOR SHALL LOCATE THEM AS FIELD CONDITIONS DICTATE. ADDITIONAL PULL AND JUNCTION BOXES NOT SHOWN ON DRAWINGS SHALL BE PROVIDED WHERE REQUIRED BY APPLICABLE CODE PROVISIONS OR WHERE CALLED FOR BY FIELD CONDITIONS. PULL AND JUNCTION BOXES SHALL BE SURFACE TYPE IN UNFINISHED AREAS AND INSTALLED CONCEALED IN FINISHED AREAS, AND ALL COVERS TO PULL & JUNCTION BOXES SHALL BE READILY ACCESSIBLE.
- SUPPORT PANEL, JUNCTION AND PULLBOXES INDEPENDENTLY TO BUILDING STRUCTURE WITH NO WEIGHT BEARING ON RACEWAYS.
- FOR EXACT LOCATION AND MOUNTING HEIGHT OF LIGHTING FIXTURES AND SWITCH/RECEPTACLE OUTLETS, REFER TO ARCHITECTURAL REFLECTED CEILING AND POWER PLANS.
- ALL ELECTRICAL ACCESSORIES AND EQUIPMENT INSTALLED OUTSIDE OR EXPOSED TO WEATHER SHALL HAVE NEMA 3R ENCLOSURES AND SHALL BE TIGHTLY GASKETED FOR A COMPLETE RAIN TIGHT INSTALLATION. ALL BUILDING EXTERIOR MOUNTED RECEPTACLES SHALL BE GFCI RATED AND MOUNTED IN WEATHERPROOF ENCLOSURE.
- ALL ACCESS PANEL LOCATIONS SHALL BE REVIEWED BY ARCHITECT PRIOR TO INSTALLATION.
- ELECTRICAL CONTRACTOR SHALL COORDINATE THE LOCATION AND INSTALLATION OF NEW WORK WITH THE GENERAL CONTRACTOR AND OTHER ASSOCIATED TRADES IN A TIMELY MANNER. THE CONTRACTOR IS RESPONSIBLE FOR FIELD VERIFYING ALL DIMENSIONS AND CONDITIONS PRIOR TO CONSTRUCTION. REFER TO ALL GENERAL, MECHANICAL, AND ELECTRICAL, DRAWINGS AND SPECIFICATIONS FOR THIS PROJECT.
- ALL CONDUITS AND EQUIPMENT TO BE CONCEALED IN FINISHED SPACES UNLESS OTHERWISE NOTED. CONDUITS SHALL BE ENCASED IN THE CONCRETE FLOOR SLAB.
- ALL EQUIPMENT AND MATERIALS INSTALLED IN PLENUM CEILINGS SHALL BE APPROVED FOR THAT APPLICATION.
- OUTLET BOXES AND JUNCTION BOXES ON OPPOSITE SIDES OF FIRE-RATED WALLS SHALL BE SEPARATED BY A HORIZONTAL DISTANCE OF NOT LESS THAN 24 INCHES, UNLESS FIRE-RATED BOXES OR PUTTY PADS ARE UTILIZED.
- COORDINATE ALL FLOOR PENETRATIONS WITH THE STRUCTURAL AND ARCHITECTURAL DRAWINGS. CONFIRM PENETRATION LOCATIONS WITH THE ENGINEER AND OWNER BEFORE INSTALLATION.
- COORDINATE THE MOUNTING HEIGHT AND LOCATION OF RACEWAYS, COMMUNICATIONS OUTLETS, AND RECEPTACLES WITH THE ARCHITECTURAL CASEWORK DRAWINGS AND DETAILS. COORDINATE LOCATIONS OF LIGHT FIXTURES, SWITCHES, AND RELATED DEVICES WITH THE ARCHITECTURAL DRAWINGS AND DETAILS.
- REFER TO ARCHITECTURAL PLANS FOR FINAL LOACTIONS OF ALL LUMINARIES AND SWITCHES, AND FOR ALL FINISHED CEILING HEIGHTS.
- REFER TO ARCHITECTURAL PLANS FOR FINAL LOCATIONS OF ALL ELECTRICAL DEVICES, AND FOR FINAL CEILING AND WALL HEIGHTS AND LAYOUTS.
- LIGHTING FIXTURES PROVIDED WITH EMERGENCY BATTERY PACKS AND INDICATED WITH SWITCH CONTROL SHALL BE WIRED WITH BATTERY CHARGING/SENSING CIRCUIT WIRED AHEAD OF SWITCH CONTROL.
- NUMBER(S) SHOWN AT RECEPTACLES, JUNCTION BOXES AND EQUIPMENT INDICATES CIRCUIT NUMBERS IN PANELBOARD. PROVIDE WIRE AND CONDUIT TO INTERCONNECT EQUIPMENT AND DEVICES WITH SAME CIRCUIT NUMBERS AND RUN TO PANELBOARD.

### PROJECT INFORMATION:

KIDSUNITED

### DRAWING TITLE:

ELECTRICAL SYMBOL LIST,  
ABBREVIATION AND GENERAL  
NOTES

### DRAWING NO.:

E-0.1

## ELECTRICAL SPECIFICATION

### 1. GENERAL:

A. THE "GENERAL CONDITIONS OF THE CONTRACT FOR CONSTRUCTION," AIA DOCUMENT, LATEST EDITION, AND THESE SPECIFICATIONS AS APPLICABLE ARE PART OF THIS CONTRACT.

B. DRAWING ARE DIAGRAMMATIC AND INDICATE GENERAL ARRANGEMENT OF SYSTEMS AND WORK. CONDUIT ROUTING IS SHOWN DIAGRAMMATICALLY AND DOES NOT SHOW ALL OFFSETS, DROPS AND RISERS OF RUNS, THE CONTRACTOR SHALL ALLOW IN HIS PRICE FOR ROUTING OF CONDUIT TO AVOID OBSTRUCTIONS. COORDINATION WITH EXISTING SERVICES, INCLUDING THOSE OF OTHER TRADES, IS REQUIRED, MAINTAIN HEADROOM AND SPACE CONDITIONS.

C. BIDDERS, BEFORE SUBMITTING PROPOSALS, SHALL VISIT AND CAREFULLY EXAMINE THE AREA AFFECTED BY THIS WORK TO FAMILIARIZE THEMSELVES WITH THE EXISTING CONDITIONS AND THE DIFFICULTIES THAT WILL ATTEND THE EXECUTION OF THIS WORK. SUBMISSION OF A PROPOSAL WILL BE CONSTRUED AS EVIDENCE THAT SUCH AN EXAMINATION HAS BEEN MADE, AND LATER CLAIMS WILL NOT BE RECOGNIZED FOR EXTRA LABOR, EQUIPMENT, OR MATERIALS, REQUIRED BECAUSE OF DIFFICULTIES ENCOUNTERED WHICH COULD HAVE BEEN FORESEEN HAD SUCH AN EXAMINATION BEEN MADE.

D. INSTALL WORK SO AS TO BE READILY ACCESSIBLE FOR OPERATION, MAINTANANCE AND REPAIR. MINOR DEVIATIONS FROM DRAWING MAY BE MADE TO ACCOMPLISH THIS, BUT CHANGES WHICH INVOLVE EXTRA COST SHALL NOT BE MADE WITHOUT APPROVAL.

E. REMOVAL AND RELOCATION OF CERTAIN EXISTING WORK MAY BE NECESSARY FOR THE PERFORMANCE OF THE GENERAL WORK. ALL EXISTING CONDITIONS CANNOT BE COMPLETELY DETAILED ON THE DRAWINGS. THE CONTRACTOR SHALL SURVEY THE SITE AND INCLUDE ALL CHANGES AND CHARGES IN MAKING UP THE WORK PROPOSAL.

F. CONNECTIONS TO EXISTING WORK: INSTALL NEW WORK AND CONNECT TO EXISTING WORK WITH MINIMUM INTERFERENCE TO EXISTING FACILITIES. TEMPORARY SHUTDOWNS OF EXISTING SERVICES SHALL BE PERFORMED AT NO ADDITIONAL CHARGES. AT TIMES NOT TO INTERFERE WITH NORMAL OPERATION OF EXISTING FACILITIES AND ONLY WITH WRITTEN CONSENT OF OWNER, ALARM AND EMERGENCY SYSTEMS SHALL NOT BE INTERRUPTED. MAINTAIN CONTINUOUS OPERATION OF EXISTING FACILITIES AS REQUIRED WITH NECESSARY TEMPORARY CONNECTIONS BETWEEN NEW AND EXISTING WORK. CONNECT NEW WORK TO EXISTING WORK IN NEAT AND ACCEPTABLE MANNER. RESTORE EXISTING DISTURBED WORK TO ORIGINAL CONDITION, INCLUDING MAINTENANCE OF WIRING CONTINUITY AS REQUIRED.

G. DISCONNECT, REMOVE AND/OR RELOCATE EXISTING MATERIAL, EQUIPMENT AND OTHER WORK AS NOTED OR REQUIRED FOR PROPER INSTALLATION OF NEW WORK.

H. THE CONTRACTOR SHALL KEEP ALL EQUIPMENT AND MATERIALS, AND ALL PARTS OF THE BUILDING EXTERIOR SPACES AND ADJACENT STREETS, SIDEWALKS AND PAVEMENTS, FREE FROM MATERIAL AND DEBRIS RESULTING FROM THE EXECUTION OF THIS WORK. EXCESS MATERIALS WILL NOT BE PERMITTED TO ACCUMULATE EITHER ON THE INTERIOR OR THE EXTERIOR.

I. SEAL OPENINGS THROUGH PARTITIONS, WALLS AND FLOORS WITH MINERAL WOOL OR OTHER NONCOMBUSTIBLE MATERIAL, UNLESS OTHERWISE NOTED.

J. PROVIDE ALL NECESSARY FLASHING AND COUNTER FLASHING TO MAINTAIN THE WATERPROOFING INTEGRITY OF THE BUILDING AS REQUIRED BY THE INSTALLATION OR REMOVAL OF CONDUIT AND EQUIPMENT, PROVIDE EQUIPMENT CURBS AS REQUIRED.

K. ALL EXISTING MATERIAL, EQUIPMENT AND CONSTRUCTION DEBRIS TO BE REMOVED UNDER THIS CONTRACT SHALL BECOME THE PROPERTY OF THE CONTRACTOR WITH THE EXCEPTION OF SPECIFIC EQUIPMENT ND APPARATUS REQUESTED BY THE BUILDING REPRESENTATIVE, ARCHITECT OR AS NOTED TO BE RELOCATED ON THE DRAWINGS. REMOVED EQUIPMENT SHALL BE PROPERLY DISPOSED OF BY THIS CONTRACTOR.

L. THE CONTRACTOR'S PROPOSAL FOR ALL WORK SHALL BE PREDICATED ON THE PERFORMANCE OF THE WORK DURING REGULAR WORKING HOURS, WHEN SO DIRECTED. HOWEVER, THE CONTRACTOR SHALL INSTALL WORK DURING OVERTIME HOURS AND THE ADDITIONAL COST TO BE CHARGED THEREFORE SHALL BE ONLY THE "PREMIUM" PORTION OF THE WAGES PAID.

M. UNLESS OTHERWISE SPECIFICALLY NOTED OR SPECIFIED, INCLUDE ALL CUTTING AND PATCHING OF EXISTING FLOORS, WALLS, PARTITIONS AND OTHER MATERIALS IN THE EXISTING BUILDING. THE CONTRACTOR SHALL RESTORE THESE AREAS TO ORIGINAL CONDITION.

N. ALL MATERIAL AND EQUIPMENT SHALL BE NEW UNLESS OTHERWISE NOTED AND SHALL BE IN ACCORDANCE WITH BUILDING STANDARDS.

O. INSURANCE: PROVIDE IN ACCORDANCE WITH OWNER/BUILDING REQUIREMENTS AND SHALL INCLUDE A HOLD HARMLESS CLAUSE FOR OWNER AND ENGINEER.

P. THE FINAL ACCEPTANCE SHALL BE MADE AFTER THE CONTRACTOR HAS ADJUSTED HIS EQUIPMENT, TESTED THE VARIOUS SYSTEMS, DEMONSTRATED THAT IT FULFILLS THE REQUIREMENTS OF THE DRAWINGS AND SPECIFICATIONS AND HAS FURNISHED ALL THE REQUIRED CERTIFICATED OF INSPECTION AND APPROVAL.

### 2. GENERAL PROVISIONS FOR ELECTRICAL WORK:

#### A. DEFINITIONS:

- "PROVIDE": TO FURNISH, INSTALL AND CONNECT UP COMPLETE AND READY FOR SAFE AND REGULAR OPERATION THE PARTICULAR WORK REFERRED TO UNLESS SPECIFICALLY OTHERWISE NOTED.
- "INSTALL": TO ERECT, MOUNT AND CONNECT COMPLETE WITH RELATED ACCESSORIES.
- "FURNISH" OR "SUPPLY": TO PURCHASE, PROCURE, ACQUIRE, AND DELIVER COMPLETE WITH RELATED ACCESSORIES.
- "WORK": LABOR, MATERIALS, EQUIPMENT, APPARATUS, CONTROLS, ACCESSORIES AND OTHER ITEMS REQUIRED FOR PROPER AND COMPLETE INSTALLATION.
- "WIRING": RACEWAY, FITTINGS, WIRE, BOXES, AND RELATED ITEMS.
- "CONCEALED": EMBEDDED IN MASONRY OR OTHER CONSTRUCTION, INSTALLED IN FURRED SPACES, WITHIN DOUBLE PARTITIONS OR HUNG CEILLINGS, IN TRENCHES, IN CRAWL SPACES, OR IN ENCLOSURES
- "EXPOSED": NOT INSTALLED UNDERGROUND OR "CONCEALED" AS DEFINED ABOVE.

8) "SIMILAR" OR "EQUAL": EQUAL IN MATERIALS, WEIGHT, SIZE, DESIGN AND EFFICIENCY OF SPECIFIED PRODUCT.

B. TEMPORARY LIGHT AND POWER: PROVIDE TEMPORARY LIGHT AND POWER SYSTEMS AT EARLIEST POSSIBLE DATE WITHIN THE CONSTRUCTION AREAS FOR THE REQUIREMENTS OF ALL TRADES AS HEREIN DESCRIBED. EXTEND SYSTEMS TO NEW CONSTRUCTION AS SOON AS PHYSICALLY POSSIBLE. MAINTAIN SYSTEM DURING WORKING OWNER. PROVIDE ALL REQUIRED MAINTENANCE, INCLUDING LAMPS AND SOCKETS.

#### C. QUALITY ASSURANCE

1) QUALITY OF MATERIALS: ALL EQUIPMENT SHALL BE NEW SPECIFICATION GRADE, FREE FROM DEFECTS AND LISTED BY APPROVED TESTING AGENCY AND BEARING THEIR LABEL. MATERIALS AND EQUIPMENT OF SIMILAR APPLICATION SHALL BE OF SAME MANUFACTURER, EXCEPT AS NOTED.

2) GUARANTEE: ALL MATERIALS AND WORKMANSHIP SHALL BE GUARANTEED AS DEFINED IN PARAGRAPH 2.C.

3) CURRENT CHARACTERISTICS:

a. SERVICE: 120/208 VOLT, 3 PHASE, 4 WIRE, 60 HERTZ WITH GROUNDED NEUTRAL.

4) HEIGHTS OF OUTLETS:

a. FROM FINISHED FLOOR TO CENTERLINE OF OUTLETS FOR:

- RECEPTACLES AND TELEPHONES: 1 FT-6 IN.
- WALL SWITCHES: 4 FT-0 IN.
- WALL FIXTURES: 7 FT-0 IN.
- MOTOR CONTROLLERS: 5 FT-0 IN.
- CLOCKS: 7 FT 6 IN

b. EXCEPTIONS: AT JUNCTION OF DIFFERENT WALL FINISH MATERIALS, ON MOLDING OR BREAK IN WALL SURFACE, IN VIOLATION OF CODE, OR AS NOTED OR DIRECTED.

#### D. PRODUCT DELIVERY, STORAGE AND HANDLING

1) MOVING OF EQUIPMENT: WHERE NECESSARY, SHIP IN CARTED SECTIONS OF SIZE TO PERMIT PASSING THROUGH AVAILABLE SPACES.

2) ACCESSIBILITY: FOR OPERATION, MAINTENANCE AND REPAIR, MINOR DEVIATIONS SHALL BE PERMITTED. CHANGES OF MAGNITUDE OR INVOLVING EXTRA COST ARE NOT PERMISSIBLE WITHOUT REVIEW. GROUP CONCEALED ELECTRICAL EQUIPMENT REQUIRING ACCESS WITH EQUIPMENT FREELY ACCESSIBLE THROUGH ACCESS DOORS.

#### E. MATERIALS

1) NAMEPLATES: PROVIDE BLACK LAMCROID SHEET WITH 3/4 IN. WHITE LETTERING, FASTENED WITH EPOXY CEMENT FOR EACH DISCONNECT SWITCH, CIRCUIT BREAKER, PANEL, CABINET, TRANSFORMER, ENCLOSURE, MOTOR CONTROLLER AND THE LIKE. NAMEPLATES SHALL DESCRIBE THE NAME AND NUMBER OF EACH COMPONENT.

2) CABLE TAGS: TAG EACH CONDUCTOR PASSING THROUGH SPLICE OR PULLBOX WITH A WHITE LINEN TAG, INDICATING POINT OF ORIGIN AND TERMINATION OF THE CIRCUIT.

3) INSERTS AND SUPPORTS:

a. INSERTS: STEEL, SLOTTED TYPE, FACTORY PAINTED.

- SINGLE ROD: SIMILAR TO GRINNELL FIG. 281.

- MULTI-ROD: SIMILAR TO FEE AND MASON SERIES 9000 WITH END CAPS AND CLOSURE STRIPS.

- CLIP FORM NAILS FLUSH WITH INSERTS.

- MAXIMUM LOADING 75 PERCENT OF RATING.

b. SUPPORTS FROM BUILDING CONSTRUCTION: INSERTS, BEAM CLAMPS, STEEL FISHPATHS (IN CONCRETE FILL ONLY), CLAMPTIEVER BRACKETS OR OTHER MEANS. SUBMIT FOR REVIEW.

c. GROUPED LINES AND SERVICES: TRAPEZE HANGERS OF BOLTED ANGLES OR CHANNELS.

d. WHERE BUILDING CONSTRUCTION IS INADEQUATE: PROVIDE ADDITIONAL FRAMING. SUBMIT FOR REVIEW.

F. PAINT SHALL BE THE BEST GRADE FOR ITS PURPOSE. DELIVER INORGANIC SEALED CONTAINERS AND APPLY IN ACCORDANCE WITH MANUFACTURER'S INSTRUCTIONS. COLORS SHALL BE AS SELECTED BY ARCHITECT OR ENGINEER. UTILIZE GALVANIZED IRON PRIMER ON PANEL AND PULL BOXES, AFTER FABRICATION, UTILIZE HOT DIPPED GALVANIZED OR DIPPED IN ZINC BASED PRIMER FOR: OUTLET BOXES, JUNCTION BOXES, CONDUIT HANGERS, RODS, INSERTS AND SUPPORTS. ZINC BASED PRIMER WITH FINISH TO MATCH BRUSH AND CLEAN WORK PRIOR TO CONCEALING, PAINTING AND ACCEPTANCE. PAINTED EXPOSED WORK SOILED OR DAMAGED; CLEAN AND REPAIR TO MATCH ADJOINING WORK BEFORE FINAL ACCEPTANCE. REMOVE DEBRIS FROM INSIDE AND OUTSIDE OF MATERIAL AND EQUIPMENT.

G. FINAL LOCATIONS AND MOUNTING ORIENTATIONS OF ALL SWITCHES, RECEPTACLES AND LIGHT FIXTURES SHALL BE VERIFIED WITH ARCHITECT.

H. ALL ACCESS DOOR LOCATIONS SHALL BE REVIEWED BY ARCHITECT PRIOR TO INSTALLATION.

### 3. SCOPE OF WORK:

A. SCOPE OF WORK SHALL CONSIST OF PROVIDING LABOR, MATERIALS, EQUIPMENT, SERVICES AND FEES NECESSARY FOR COMPLETE AND SAFE INSTALLATION IN CONFORMING WITH THE 2020 NATIONAL ELECTRIC CODE (NEC) WITH LOCAL ADOPTIONS, AND ALL OTHER APPLICABLE INDUSTRY, NATIONAL AND LOCAL CODES AND AUTHORITIES HAVING JURISDICTION, AS INDICATED ON DRAWINGS AND HEREIN SPECIFIED.

B. ALL DRAWINGS, PLANS, DETAILS, SPECIFICATIONS AND SPECIFICATION ADDENDA ARE MADE PART OF THIS CONTRACT AND SHALL APPLY TO ALL WORK UNDER THE CONTRACT UNLESS OTHERWISE AMENDED, MODIFIED, SUPPLIED OR SPECIFIED HEREIN.

C. THE CONTRACTOR SHALL FURNISH A WRITTEN GUARANTEE TO REPLACE OR REPAIR PROMPTLY AND ASSUME RESPONSIBILITY FOR ALL EXPENSES INCURRED FOR ANY WORKMANSHIP AND EQUIPMENT IN WHICH DEFECTS DEVELOP WITHIN ONE YEAR FROM THE DATE OF FINAL CERTIFICATE FOR PAYMENT AND/OR FROM DATE OR ACTUAL USE OF EQUIPMENT OR OCCUPANCY OF SPACES BY OWNER INCLUDED UNDER THE VARIOUS PARTS OF THE WORK, WHICHEVER, DATE IS EARLIER. THIS WORK SHALL BE DONE AS DIRECTED BY THE OWNER. THIS GUARANTEE SHALL ALSO PROVIDED THAT WHERE DEFECTS OCCUR, THE CONTRACTOR WILL ASSUME RESPONSIBILITY OF OTHER TRADES AFFECTED BY DEFECTS, REPAIRS OR

#### REPLACEMENTS IN EQUIPMENT SUPPLIED BY THE CONTRACTOR.

D. THE CONTRACTOR SHALL GIVE NECESSARY NOTICE, FILE DRAWINGS AND SPECIFICATIONS WITH ALL DEPARTMENTS HAVING JURISDICTION, WORK AND PAY ALL FEES THEREFOR. THE CONTRACTOR SHALL ARRANGE FOR INSPECTION AND TESTS OF ANY OR ALL PARTS OF THE WORK IF SO REQUIRED BY AUTHORITIES AND PAY ALL CHARGES FOR SAME. THE CONTRACTOR SHALL PAY ALL COSTS FOR, AND FURNISH TO THE OWNER BEFORE FINAL BILLING, ALL CERTIFICATES NECESSARY AS EVIDENCE THAT THE WORK INSTALLED CONFORMS WITH ALL REGULATIONS WHERE THEY APPLY TO THIS WORK.

E. CONTRACTOR SHALL PERFORM ALL CONTROLLED INSPECTIONS IN ACCORDANCE WITH THE BUILDING CODE. SECURE ALL REQUIRED PERMITS AND APPROVALS AND TRANSMIT SAME TO OWNER. CONTRACTOR SHALL BE RESPONSIBLE FOR ALL FEES.

F. AREAS WITH NO ELECTRICAL WORK SHALL REMAIN AS IS. CONTRACTOR SHALL MAINTAIN CONTINUITY OF ALL ELECTRICAL SYSTEMS TO ALL AREAS NOT COVERED BY THIS RENOVATION AND SHALL PROVIDE 48 HOUR NOTICE TO LANDLORD OF ANY PLANNED POWER INTERRUPTIONS OR SIGNAL SYSTEM OUTAGES.

#### 4. SHOP DRAWINGS

A. PRIOR TO THE INSTALLATION OF ANY WORK AND PROCUREMENT OF EQUIPMENT, CONTRACTOR SHALL PROVIDE COMPLETE SETS OF COORDINATED SHOP DRAWINGS OF ALL NEW AND EXISTING EQUIPMENT INDICATING CAPACITY, DIMENSIONS AND SEQUENCE OF OPERATION FOR WRITTEN APPROVAL BY THE ARCHITECT AND ENGINEER.

#### B. INDICATE ON EACH SHOP DRAWINGS SUBMITTED:

- PROJECT NAME AND LOCATION
- NAME OF ARCHITECT AND ENGINEER
- ITEM IDENTIFICATION
- APPROVAL STAMP OF PRIME CONTRACTOR

#### C. SUBMISSIONS:

1) SUBMISSIONS 11 IN. X 17 IN. OR SMALLER: IF THE SUBMISSION IS A CATALOG CUT, THEN THE CONTRACTOR SHALL SUBMIT ONE ORIGINAL AND TWO COPIES. OTHERWISE, HE SHALL SUBMIT THREE COPIES. THE ARCHITECT WILL FORWARD THE ORIGINAL AND ONE COPY (TWO COPIES WHEN NO ORIGINAL IS RECEIVED) TO THE ENGINEER. ALL CATALOG CUTS SHALL BE COMPLETE.

2) SUBMISSIONS LARGER THAN 11 IN. X 17 IN.: SUBMIT TWO PRINTS AND ONE PAPER SEPIA TO THE ARCHITECT. THE ARCHITECT WILL FORWARD ONE PRINT AND THE PAPER SEPIA TO THE ENGINEER.

#### D. SUBMIT SHOP DRAWINGS FOR THE FOLLOWING:

- SAFETY/DISCONNECT SWITCHES
- FUSES
- CIRCUIT BREAKERS
- PANELBOARDS/LOADCENTER (INCLUDING DIMENSIONS, SCHEDULES, AND CATALOG CUTS).
- RACEWAYS
- WIRE AND CABLE
- WALL SWITCHES
- INSERTION RECEPTACLES
- MEMORATORY CONTACT SWITCHES
- TIME SWITCHES
- LIGHTING FIXTURES.
- TRANSFORMER.

E. ASSIST AND PROVIDE ALL NECESSARY INFORMATION, DIAGRAMS, SKETCHES, ETC. TO THE HVAC CONTRACTOR, FOR THE PREPARATION OF COORDINATED SHOP DRAWINGS INDICATING ROUTING OF FEEDERS, CONTROL CONDUITS, RECESSED FIXTURES AND ADJACENT NEARBY PIPING AND DUCTWORK WHERE APPLICABLE, CERTIFIED BY ALL TRADES (THAT COORDINATION HAS BEEN ESTABLISHED. SUBMIT FOUR(4) BOOKBOUND OPERATING AND SERVICE MANUALS WHICH SHALL INCLUDE COPIES OF ALL SHOP DRAWING, PROVIDE SHOP DRAWINGS FOR PANELS, FIXTURES, WIRING DEVICES, CONDUIT, CABLE, DISCONNECT SWITCH, RELAYS, CONTRACTORS, AND OTHER SYSTEMS AS DIRECTED BY THE ENGINEER.

#### 5. AS-BUILT DRAWINGS AND EQUIPMENT OPERATIONAL INSTRUCTIONS

A. UPON COMPLETION AND ACCEPTANCE OF WORK, CONTRACTOR SHALL FURNISH WRITTEN INSTRUCTIONS AND EQUIPMENT MANUALS AND DEMONSTRATE TO THE OWNER THE PROPER OPERATION AND MAINTENANCE OF ALL EQUIPMENT AND APPARATUS FURNISHED UNDER THIS CONTRACT.

B. THESE INSTRUCTIONS SHALL BE TYPED ON 8-1/2 IN. X 11 IN. PAPER A BOUND IN THREE RING BINDERS WITH CLEAR ACETATE COVERS. CONTRACTOR SHALL GIVE THREE COPIES OF THE INSTRUCTIONS TO THE OWNER AND ONE COPY TO THE ENGINEER.

C. THE INSTRUCTION BOOKLET SHALL BEAR THE NAME, ADDRESS AND TELEPHONE NUMBER OF THE PROJECT, ARCHITECT AND ENGINEER.

D. REPRODUCIBLE "AS-BUILT" DRAWINGS SHALL BE PROVIDED INDICATING THE AS INSTALLED CONDITIONS OF THE WORK. "AS-BUILT" DRAWINGS SHALL BE PROVIDED TO THE ARCHITECT AFTER COMPLETION OF THE INSTALLATION.

#### 6. LOW-VOLTAGE DISTRIBUTION EQUIPMENT:

A. PROVIDE COMPLETE EQUIPMENT INCLUDING: SWITCHES, FUSES, CIRCUIT BREAKERS, PANELS AND TRANSFORMERS.

B. ALL EQUIPMENT SHALL CONFORM TO NEMA, ANSI AND IEEE STANDARDS.

C. DISCONNECT SWITCHES SHALL BE FUSED OR NONFUSED AS NOTED. VOLTAGE SHALL BE AS REQUIRED. SWITCHES SHALL BE HEAVY DUTY, EXCEPT AS NOTED, AND HORSEPOWER RATED FOR MOTOR LOADS. TOGGLE TYPE SWITCHES SHALL BE NONFUSED, LOAD BREAK, HAVING MAXIMUM RATINGS OF 20 AMP AT 600 VOLTS AND 30 AMP AT 240 VOLTS. TWO-POLE SWITCHES SHALL BE SIMILAR TO HART AND HEGEMAN NO. 6808F. THREE-POLE SWITCHES SHALL BE SIMILAR TO HART AND HEGEMAN NO. 7810F. KNIFE-BLADE TYPE SWITCHES SHALL BE LOAD BREAK, QUICK-MAKE, QUICK-BREAK, UL CLASS R UP TO 600 AMP. MAXIMUM RATING EXCEPT AS NOTED SHALL BE 800 AMP. ARC QUENCHERS SHALL BE PROVIDED. SWITCHES SHALL BE SIMILAR TO GENERAL ELECTRIC QMR. ALL SWITCH ENCLOSURES SHALL BE DEAD FRONT, NEMA TYPE 1, EXCEPT AS NOTED.

#### 7. FUSES:

A. CIRCUITS 0 TO 600 AMPERES SHALL BE PROTECTED BY FUSES SIMILAR TO CURRENT LIMITING BUSSMAN LOW-PEAK DUAL-ELEMENT TIME-DELAY LPN-RK (AMP)SP (250V) /LPS-RK (AMP)SP (600V) OR LPJ (AMP)SP (600V) (UL CLASS RK1 OR CLASS J), AND BE LISTED BY UL WITH AN INTERRUPTING RATING OF 300,000 AMPERES RMS SYMMETRICAL.

B. MOTOR CIRCUITS - ALL INDIVIDUAL MOTOR CIRCUITS WITH FULLLOAD AMPERE RATINGS (FLA) OF 480 AMPERES OR LESS SHALL BE PROTECTED BY FUSES SIMILAR TO CURRENT LIMITINGBUSSMANN LOW-PEAK DUAL-ELEMENT TIME-DELAY LPN-RK (AMP)SP (250V) /LPS-RK (AMP)SP (600V) OR LPJ (AMP)SP (600V) (UL CLASS RK1 OR CLASS J), AND BE LISTED BY UL WITH AN INTERRUPTING RATING OF 300,000 AMPERES RMS SYMMETRICAL.

C. ALL FUSES SHALL BE PROVIDED BY SAME MANUFACTURER.

D. PROVIDE 1 SPACE MATCHING FUSE FOR EACH SET OF 3.

E. CIRCUIT BREAKERS: MOLDED CASE BREAKERS SHALL BE THERMAL-MAGNETIC, QUICK-MAKE-QUICK-BREAK, BOLT-ON TYPE, MANUALLY OPERATED WITH INSULATED TRIP-FREE HANDLE. MULTI-POLE TYPE BREAKERS SHALL CONTAIN INTERNAL TRIP BAR. TERMINALS SHALL BE SUITABLE FOR COPPER OR ALUMINUM CABLE. FURNISH AUXILIARY DEVICES WHERE REQUIRED FOR SHUNT-TRIPPING, OPEN AND CLOSE MOTOR OPERATOR AND ALARM INDICATION. ENCLOSURES SHALL BE DEAD FRONT, NEMA TYPE 1, EXCEPT AS NOTED. FRAMES, IC AND INTERCHANGEABLE TRIPS SHALL BE AS FOLLOWS, UNLESS OTHERWISE NOTED:

- 120 VOLTS, 100-AMP FRAME: 10,000 AMPS, 1 POLE.
- 120/240 VOLTS, 225-AMP FRAME: 22,000 AMPS MINIMUM

#### 8. DISTRIBUTION PANELBOARDS, CIRCUIT BREAKER TYPE:

A. THREE PHASE, 4 OR 5 WIRE, COPPER BUS BARS, WITH 2-, 3-, OR 4 WIRE BRANCHES, AS NOTED, CAPACITY OF PANEL AND CIRCUITS, AS NOTED BELOW. PANELBOARD TO HAVE GROUND BUS SAME SIZE AS PHASE BUSES.

B. CABINETS: CODE GAUGE GALVANIZED SHEET STEEL PRIMED AND PAINTED WITH TRIM AND DOOR, TYPE AS NOTED. LAP AND RIVET CORNERS OR FORM AS APPROVED.

C. TRIM: ONE PIECE FULL FINISH PRIMED AND PAINTED SHEET STEEL, TRIM SHALL BE MOUNTED WITH A CONTINUOUS PIANO HINGE CONFIGURED IN SUCH A MANNER THAT IT SHALL BE POSSIBLE TO GAIN FULL ACCESS TO CIRCUIT BREAKERS AND WIRING GUTTERS WITHOUT REMOVING THE TRIM. PROVIDE A MULTIPIN CYLINDER LOCK (YALE, CORBIN OR EQUAL) TO LATCH THE TRIM. KEYS SHALL BE MILLED.

D. HARDWARE: MULTIPIN, CYLINDER LOCKS WITH MILLED KEYS. ALL PANELS SHALL BE KEYPED ALIKE. DOOR OVER 48" HIGH SHALL BE EQUIPPED WITH A CHROME PLATED VAULT HANDLE, BUILT-IN LOCK AND 3-POINT CATCH FASTENING DOOR AT TOP, BOTTOM AND CENTER.

E. HINGES: CONCEALED, CONTINUOUS PIANO HINGE AS DESCRIBED ABOVE.

F. DIRECTORY HOLDER: MEAL FRAME WITH NONBREAKABLE TRANSPARENT COVER AND DIRECTORY CARD. ENTRIES TO BE TYPED BY ELECTRICAL CONTRACTOR. PROVIDE AN ENGRAVED LAMINATED NAMEPLATE ADJACENT TO EACH BRANCH BREAKER. MOUNT WITH SELF TAPPING MACHINE SCREWS.

G. FURNISH MULTI-CABLE LUGS WHERE REQUIRED. DOUBLE LUGGING NOT PERMITTED. SECURE LUGS TO BUS BY STUD BOLTS.

H. PANELBOARD CONSTRUCTION FOR BOLTED TYPE BREAKERS. MINIMUM SHORT CIRCUIT RATING 25,000 AMPERES, RMS SYMMETRICAL FOR ALL 120/208V APPLICATIONS. INDIVIDUAL CIRCUIT BREAKERS SHALL HAVE MINIMUM 100A FRAME, TRIPS SIZED AS SHOW ON THE PLANS.

I. MINIMUM GUTTER SPACES: PANELS WITH 225 AMPERE MAINS, 5-3/4" MINIMUM, 400 AMPERES AND OVER, MINIMUM GUTTERS 8". FOR PANELS WITH THROUGH FEEDERS, INCREASE GUTTER WIDTH BY 2" MINIMUM AND PROVIDE A SHEET STEEL BARRIER BETWEEN THE PANEL, GUTTER AND THE THROUGH FEEDER PORTION OF THE BACK BOX. BRANCH CIRCUIT BREAKERS SHALL BE MECHANICALLY INTERLOCKED WHEN SHOWN ON DRAWINGS.

J. DISTRIBUTION AND SUB-DISTRIBUTION PANELBOARDS SHALL BE A MINIMUM OF 30" WIDE AND 10" DEEP.

K. PANELBOARD SHALL HAVE MAIN CIRCUIT BREAKER OR MAIN LUGS AS INDICATED ON THE DRAWINGS, QUANTITY, POLES AND TRIP RATINGS OF BRANCH CIRCUIT BREAKERS TO BE AS INDICATED ON DRAWINGS.

L. PANELBOARD SHALL HAVE ENGRAVED WHITE CORE, BLACK LAMACOID NAMEPLATE SCREWED ONTO PANE TRIM WITH DESIGNATION LISTED (PANELBOARD NAME, VOLTAGE, RATING OR MAINS IN AMPS).

#### 9. DISTRIBUTION PANELBOARDS, SWITCH AND FUSE:

A. THREE PHASE, 3 OR 4 WIRE WITH COPPER BUS BARS. ALL THROUGH BUS SHALL BE INSULATED.

B. NEMA CLASS 1 CONSTRUCTION TO ACCOMMODATE FUSIBLE, INDIVIDUALLY ENCLOSED SWITCHES, FRONT REMOVABLE, SWITCH AND DOOR INTERLOCKS, COVERS TO BE PAD-LOCKABLE.

C. PANELBOARD SHALL BE CONSTRUCTED OF CODE-GAUGE STEEL. GRAY FINISH OVER RUST INHIBITOR; FOR SURFACE MOUNTING, BOX AND PANEL FRAME SHALL BE FLANGED AND REINFORCED FOR RIGID SUPPORT OF INTERIOR AND ACCURATE ALIGNMENT OF INTERIOR WITH FRONT, TRIMS TO BE FASTENED TO BACK BOX WITH SCREWS.

D. ALL BRANCH SWITCHES SHALL HAVE INDIVIDUAL ENGRAVED LAMCROID NAMEPLATES (BLACK WITH WHITE CORE).

E. DISTRIBUTION PANELBOARD CONSTRUCTION MINIMUM SHORT CIRCUIT RATING 25,000 AMPERES, REMS SYMMETRICAL FOR ALL 120/208V APPLICATIONS, APPLICATIONS.

#### F. DISCONNECTS

1) DISCONNECT SWITCHES SHALL CONFORM TO NEMA AND UL STANDARDS, AND SHALL BE HORSEPOWER RATED.

2) SWITCHING MECHANISM SHALL BE QUICK-MAKE, QUICK-BREAK, SINGLE THROW WITH EXTERNAL OPERATING HANDLE MECHANICALLY INTERLOCKED WITH ENCLOSURE COVER TO PROVIDE ACCESS TO INTERIOR WHEN DISCONNECT IS IN OFF POSITION ONLY. PROVIDE MEANS TO LOCK OPERATING HANDLE IN THE OPEN AND CLOSED POSITION. DESIGNATE ON THE ENCLOSURE THE OPEN AND CLOSED POSITION OF THE OPERATING HANDLE.

3) SWITCHES SHALL BE OF THE DOUBLE STATIONARY CONTACT TYPE.

4) SWITCHES SHALL BE EQUIPPED WITH REJECTION TYPE FUSE HOLDERS, FUSIBLE AS SHOWN ON THE DRAWINGS; PROVIDE COMPLETE WITH FUSES AS SCHEDULED.

#### PROJECT INFORMATION:

KIDSUNITED

#### DRAWING TTLE:

ELECTRICAL SPECIFICATIONS  
(1 OF 2)

#### DRAWING NO.:

E-0.2

## ELECTRICAL SPECIFICATION (CONT.)

### G. INSTALLATION

- 1) DISTRIBUTION PANELBOARD SHALL BE MOUNTED TO STRUCTURAL STEEL CHANNEL (KINDORF) WHICH SHALL BE BOLTED TO THE WALL USING EXPANSION ANCHORS FOR LARGE PANELS.

### H. IDENTIFICATION

- 1) PROVIDE NAMEPLATE AT EACH SWITCH IDENTIFYING THE LOAD SERVED.
- 2) NAMEPLATES SHALL BE MOUNTED ON THE FRONT COVER SECURED WITH SELF-TAPPING SCREWS OR NUTS AND BOLTS. NAMEPLATES SHALL BE LAMINATED PHENOLIC, BLACK WITH A MINIMUM OF 1/4" HIGH WHITE LETTERING.

- I. DISTRIBUTION AND SUB-DISTRIBUTION PANELBOARDS SHALL BE A MINIMUM OF 30" WIDE AND 10" DEEP.

- J. POWER PANELBOARDS SHALL BE SIMILAR TO GENERAL ELECTRIC TYPE "OMR", AS MANUFACTURED BY ATLAS SWITCH COMPANY, ELECTRIC SWITCHBOARD COMPANY OR APPROVED EQUAL.

- K. PANELBOARD SHALL HAVE MAIN CIRCUIT BREAKER OR MAIN LUGS AS INDICATED ON THE DRAWINGS. QUANTITY, POLES AND TRIP RATINGS OF BRANCH CIRCUIT BREAKERS TO BE AS INDICATED ON DRAWINGS.

- L. PANELBOARD SHALL HAVE ENGRAVED WHITE CORE, BLACK LAMACOID NAMEPLATE SCREWED ONTO PANE TRIM WITH DESIGNATION LISTED (PANELBOARD NAME, VOLTAGE, RATING OR MAINS IN AMPS).

### M. MATERIALS

#### 1) RACEWAYS:

- a. RIGID STEEL CONDUIT: FULL-WEIGHT PIPE, GALVANIZED, THREADED.
- b. ELECTROMETALLIC TUBING (EMT): THIN WALL PIPE, GALVANIZED, THREADED.
- c. FLEXIBLE STEEL CONDUIT: CONTINUOUS SINGLE STRIP, GALVANIZED.
- d. WIREWAYS: WIRE SHALL BE AS NOTED, MINIMUM NO. 16 GAUGE STEEL WITH GROUND CONTINUITY. FINISH SHALL BE BAKED ENAMEL. COVERS SHALL BE SCREW-ON.
- e. SURFACE METAL RACEWAY: SIZE AS NOTED, BASE 0.04 IN., COVER 0.25 IN. MATERIAL SHALL BE STEEL. FINISH SHALL BE BAKED ENAMEL. COVERS SHALL BE SCREW-ON.

#### 2) FITTINGS AND ACCESSORIES:

- a. RIGID STEEL: NONSPLIT, THREADED, STEEL OR MALLEABLE IRON, ZINC DIE CAST NOT PERMITTED.
- b. ELECTROMETALLIC TUBING: COMPRESSION TYPE. GALVANIZED RIGID STEEL ELBOWS, 2 IN. OR LARGER.
- c. FLEXIBLE METALLIC CONDUIT: ANGLE WEDGE TYPE WITH INSULATED THROAT.
- d. BUSHINGS: METALLIC INSULATED TYPE.

#### 3) BOXES:

- a. OUTLET BOXES: EXCEPT AS OTHERWISE REQUIRED BY CONSTRUCTION, DEVICES OR WIRING, BOXES SHALL BE STAMPED STEEL, 4 IN. SQUARE OR OCTAGON FOR FIXTURES. BOXES ABOVE CEILING SHALL BE 1-1/2 IN. DEEP. BOXES IN CEILING OR SLAB SHALL BE 3 IN. DEEP. BOXES IN WALL FOR FIXTURES SHALL BE 2-3/4 IN. DEEP. BOXES IN WALL FOR RECEPTACLES AND SWITCHES SHALL BE 1-1/2 IN. DEEP. FURNISH WITH RAISED COVERS AND FIXTURE STUDS WHERE REQUIRED. WITHOUT FIXTURE OR DEVICE; FURNISH BLANK COVER. OFFSET BACK-TO-BACK OUTLETS WITH MINIMUM 6 IN. SEPARATION.
- b. JUNCTION AND PULL BOXES: GALVANIZED SHEET STEEL WITH SCREW-ON COVERS, EXCEPT AS NOTED. FURNISH WITH INSULATED SUPPORTS FOR CABLES. LOCATIONS SHALL BE AS NOTED OR REQUIRED AND ACCESSIBLE. PROVIDE BARRIERS IN NEW AND RENOVATED BOXES BETWEEN 120/208 VOLT AND 265/460 VOLT WIRING AND BETWEEN EMERGENCY AND NORMAL WIRING. FLOOR BOXES SHALL BE SUITABLE FOR CONDUIT AND DEVICES NOTED. RAISED OUTLETS SHALL BE HUBBELL #B2414 SERIES WITH ABOVE FLOOR FITTING. TELEPHONE: BUSHED HOLE. POWER: DUPLEX RECEPTACLE OR OTHER AS NOTED. INCREASE SIZE TO SUIT AS NECESSARY. FLUSH OUTLETS SHALL BE HUBBELL #B2414 SERIES WITH FLUSH FLOOR FITTING FOR TELEPHONE AND FLUSH DUAL FLAP COVER WITH DUPLEX RECEPTACLE FOR POWER AS NOTED. INCREASE SIZE TO SUIT AS NECESSARY.

- N. PROVIDE RACEWAYS ONLY AS HEREIN SPECIFIED, EXCEPT AS NOTED. RACEWAYS SHALL BE RUN CONCEALED, EXCEPT AS NOTED.

PROVIDE RACEWAY SUPPORT UTILIZING CEILING TRAPEZE, STRAP HANGERS, OR WALL BRACKETS. PROVIDE U-BOLTS AT EACH FLOOR LEVEL OF RISER RACEWAYS AND CONNECTED TO ACCEPTABLE SUPPORTS. PROVIDE RISER CLAMPS AT EACH FLOOR LEVEL OF RISER RACEWAYS AND RESTING ON SLAB. FOR THROUGH-THE-FLOOR SYSTEMS, UTILIZE AN ASSEMBLY SIMILAR TO HUBBELL FIRE RATED POKE-THROUGH-FLOOR BOX SYSTEM, FOR ABOVE FLOOR FITTINGS. TELEPHONE SHALL BE BUSHED HOLE AND POWER SHALL BE DUPLEX RECEPTACLE OR OTHER AS NOTED. PROVIDE SEPARATION BARRIER BETWEEN POWER AND TELEPHONE COMPARTMENTS. PROVIDE JUNCTION BOX ON UNDERSIDE OF FLOOR. PACK FITTING TO RESTORE FIRE RATING OF FLOOR.

SECURE ALL RACEWAYS TO SUPPORTS WITH PIPE STRAPS OR U-BOLTS. SPACING OF SUPPORTS SHALL BE A MINIMUM OF 10 FT ON CENTER FOR METALLIC RACEWAY AND AS REQUIRED FOR NONMETALLIC RACEWAY. SPACING SHALL BE 5 FT ON CENTER FOR WIREWAYS AND PER CODE AND AS NOTED FOR OTHERS. MOUNT SUPPORTS TO STRUCTURE MASONRY WITH TOGGLE BOLTS ON HOLLOW MASONRY, EXPANSION SHIELDS OR INSERTS IN CONCRETE AND BRICK. MACHINE SCREWS ON METAL. BEAM CLAMPS ON FRAMEWORK, WOOD SCREWS ON WOOD, AND PAN THROUGH STRAPS IN METAL DECK, NAILS, RAWL PLUGS OR WOOD PLUGS SHALL NOT BE PERMITTED, WHERE REQUIRED BY STRUCTURE, FURNISH THROUGH BOLTS AND FISHPLATES.

EXPOSED RACEWAYS SHALL BE RUN PARALLEL WITH OR AT RIGHT ANGLES TO WALLS. PROVIDE CLEARANCE WITH WATER, STEAM OR OTHER PIPING (MINIMUM 3 IN. SEPARATION FROM STEAM AND HOT WATER PIPES, EXCEPT 1 IN. FROM PIPE COVER AT CROSSINGS AND 18 IN. FOR PARALLEL RUNS). FOR HUNG CEILING OUTLETS, RUN IN HUNG CEILING AND CONNECT TO CEILING SUPPORT CHANNELS. IN MASONRY AND POURED CONCRETE, RUN VERTICALLY ONLY.

EMPTY RACEWAYS OVER 10 FT LONG: PROVIDE FISH OR PULL WIRE,

GALVANIZED OR NYLON ROPE.

RIGID STEEL CONDUIT SHALL BE PERMITTED FOR FEEDERS AND BRANCH CIRCUITS, PAINT MALE THREADS OF FIELD-THREADED CONDUIT WITH GRAPHITE-BASE PIPE COMPOUND AND BUTT CONDUIT ENDS. TOUCH UP MARRED SURFACES AND FIELD-CUT THREADS, CRC-COLD GALVANIZED. EMT SHALL BE PERMITTED FOR BRANCH CIRCUITS ONLY, IN DRY LOCATIONS; DRY WALLS, HUNG CEILINGS, HOLLOW BLOCK WALLS AND FURRED SPACES. EMT SHALL NOT BE PERMITTED IN RAISED FLOORS. FLEXIBLE STEEL CONDUIT SHALL BE UTILIZED FOR SHORT CONNECTIONS WHERE RIGID CONDUIT IS IMPRACTICAL. FROM OUTLET BOX TO RECESSED LIGHTING FIXTURE: PROVIDE MINIMUM 4 FT AND MAXIMUM 6 FT LENGTHS. FOR FINAL CONNECTION TO MOTOR TERMINAL BOX, TRANSFORMER AND OTHER VIBRATING EQUIPMENT: PROVIDE WITH POLYVINYL SHEATHING AND GROUND CONDUCTOR. MINIMUM LENGTH: 18 IN. WITH SLACK. CONNECT GROUND CONDUCTOR TO ENCLOSURE OR RACEWAY AT EACH END. FOR EXPANSION JOINT CROSSINGS, CROSS AT RIGHT ANGLES AND ANCHOR ENDS.

CUT CONDUIT ENDS SQUARE. REAM SMOOTH. PAINT MALE THREADS OF FIELD THREADED RACEWAYS WITH GRAPHITE BASE PIPE COMPOUND. DRAW UP TIGHT WITH RACEWAY COUPLING.

ALL COUPLINGS SHALL BE COMPRESSION TYPE. NO SET SCREW FITTINGS.

EXPANSION FITTINGS SHALL BE INSTALLED AT RIGHT ANGLES WITH CLIP JOINT CENTERED IN EXPANSION JOINT. PROVIDE A LENGTH OF RUN IN ACCORDANCE MANUFACTURER'S RECOMMENDATIONS. PRESET FITTINGS SHALL ALLOW FOR TEMPERATURE VARIATION.

RACEWAYS PASSING THROUGH FIRE-RATED CONSTRUCTION: SEAL OPENING WITH FIRE SEALANT.

- O. PROVIDE CABLE SUPPORTS IN ACCORDANCE WITH NATIONAL ELECTRIC CODE ARTICLE 300.19. CABLE SUPPORTS SHALL UTILIZE A ONE-PIECE PLUG WITH POZI-GRIP WEDGING PLUG AS MANUFACTURED BY OZ-GEDNEY. TYPE SF SHALL BE USED FOR ARMORED CABLE.

INSTALL CABLE SUPPORTS AT THE TOP OF A VERTICAL RISE AND PROVIDE INTERMEDIATE ADDITIONAL SUPPORTS AS REQUIRED TO LIMIT SUPPORTED CONDUCTOR LENGTHS TO NOT GREATER THAN THOSE SPECIFIED IN TABLE 300.19(A).

- P. ERECT WALL AND SWITCH OUTLETS IN ADVANCE OF FURRING AND FIREPROOFING. OUTLET BOXES SHALL BE SET SQUARE AND TRUE WITH BUILDING FINISH. SECURE TO BUILDING STRUCTURE BY ADJUSTABLE STRAP IRON OR GROUT IN WITH MASONRY. VERIFY OUTLET LOCATIONS IN FINISHED SPACES WITH ARCHITECTURAL DRAWINGS OF INTERIOR DETAILS AND FINISHES. PROVIDE BARRIER BETWEEN SWITCHES CONNECTED TO DIFFERENT PHASES FOR VOLTAGES EXCEEDING 150 VOLTS TO GROUND.

- Q. PANEL, JUNCTION AND PULL BOXES SHALL BE LOCATED CLEAR OF OTHER TRADES. CONCEAL JUNCTION AND PULL BOXES IN FINISHED WHERE NECESSARY. REROUTE RACEWAYS OR MAKE OTHER ARRANGEMENTS FOR CONCEALMENT; BOXES SHALL BE ACCESSIBLE. SUPPORT BOXES FROM BUILDING STRUCTURE. INDEPENDENT OF CONDUIT, PROVIDE FLOOR-TO-CEILING CHANNELS FOR MOUNTING ON DRYWALL AND LIGHTWEIGHT CONSTRUCTION. OUTLET BOXES FOR FIXTURES RECESSED IN HUNG CEILINGS SHALL BE ACCESSIBLE THROUGH OPENING CREATED BY REMOVAL OF FIXTURE. SECURE TO BLACK IRON SUPPORT. MOTOR TERMINAL BOXES: COORDINATE WITH MOTOR BRANCH CIRCUIT CONDUIT AND WIRING; ADD BOX VOLUME WHERE REQUIRED.

- R. FIRE SEALANTS: PROVIDE FOR RACEWAYS AND WIRE PASSING THROUGH FLOOR SLOTS, SLEEVES OR OPENINGS IN FIRE-PARTITIONS ROOMS.

- S. PERFORM CONTINUITY TESTS OF RESISTANCE OF FEEDER CONDUITS FROM SERVICE TO POINT OF FINAL DISTRIBUTION USING 1 CONDUCTOR RETURN. MAXIMUM RESISTANCE SHALL BE 25 OHMS.

#### 10. WIRE AND CABLE:

- A. PROVIDE WIRE AND CABLE COMPLETE WITH ACCESSORIES. SIZE REFERENCE SHALL BE AWG EXCEPT AS NOTED.
- B. CONDUCTORS SHALL BE COPPER, ASTM STANDARD SOLID (NO. 10 AND SMALLER) OR STRANDED (NO. 8 AND LARGER). GENERAL USE CABLING SHALL BE NO. 12 MINIMUM. AT 120 VOLTS AND OVER 100 FT CIRCUIT LENGTH PROVIDE NO. 10 MINIMUM. AT 265 VOLTS AND OVER 200 FT CIRCUIT LENGTH PROVIDE NO. 10 MINIMUM.
- C. CONTROL AND ALARM CABLING, EXCEPT AS NOTED, SHALL BE NO. 14 MINIMUM. AT 120 VOLTS AND OVER 200 FT CIRCUIT LENGTH PROVIDE NO. 12 MINIMUM. OTHER VOLTAGES AND PHASES: ADJUST CABLE SIZING AS REQUIRED TO MAINTAIN VOLTAGE DROP. INCREASE RACEWAY SIZES FOR LARGER WIRE AS REQUIRED.
- D. INSULATION SHALL BE RUBBER AND THERMOPLASTIC MEETING ASTM AND IPCEA STANDARDS. TYPE THW OR THWN SHALL BE UTILIZED FOR FEEDERS AND BRANCH CIRCUITS EXCEPT AS NOTED. TYPE SFF-2 SHALL BE UTILIZED FOR BRANCH CIRCUITS LOCATED IN WIRING CHANNELS OF CONTINUOUS FLOURESCENT FIXTURES AND IN AMBIENT TEMPERATURES OVER 90 DEG C. FOR UNGROUNDED ISOLATED BRANCH CIRCUITS PROVIDE CROSS-LINKED POLYETHYLENE INSULATION (TYPE XHHW).
- E. ARMORED CABLE (BX) SHALL BE UTILIZED FOR BRANCH CIRCUITS IN DRY, HOLLOW LOCATIONS, HUNG CEILINGS, AND BLOCK WALLS, WHEN USED, IN LIEU OF WIRING IN CONDUIT. STATE IN PROPOSAL THAT PRICE IS BASED UPON THE USE OF HOSPITAL GRADE BX.
- F. COLOR CODING SHALL BE AS FOLLOWS:

120/208 VOLT SYSTEM:	277/480 VOLT SYSTEM:
BLACK FOR A PHASE	BROWN FOR A PHASE
RED FOR B PHASE	ORANGE FOR C PHASE
BLUE FOR C PHASE	YELLOW FOR C PHASE

- 1) NEUTRAL WIRE SHALL UTILIZE WHITE. OUTER COVERING THROUGHOUT. EQUIPMENT GROUND WIRE SHALL UTILIZE GREEN OUTER COVERING THROUGHOUT.

- G. WHERE COLOR-CODED CABLE IS NOT AVAILABLE, CERTIFY IN WRITING AND REQUEST PERMISSION TO OVERLAP CONDUCTORS WITH 6 IN. OF COLOR TAPING IN ACCESSIBLE LOCATIONS.

- H. TERMINATIONS, SPLICES AND TAPS UNDER 600 VOLTS: COPPER CONDUCTORS NO. 10 AND SMALLER SHALL UTILIZE COMPRESSION-TYPE OF TWIST-ON SPRING-LOADED CONNECTORS AND CLEAR NYLON-INSULATED COVERING. COPPER CONDUCTORS NO. 8 AND LARGER SHALL UTILIZE MECHANICAL BOLTED PRESSURE OR HYDRAULIC COMPRESSION TYPE USING MANUFACTURER'S RECOMMENDED TOOLING. CABLE LUGS AND CONNECTORS SHALL UTILIZE COMPRESSION TYPE OF SAME METAL AS CONDUCTOR. PROVIDE TO MATCH CABLE, WITH MARKING INDICATING SIZE AND TYPE. COPPER LUG CONNECTIONS TO BUS BARS: USE ANTISEIZE COMPOUND ON TANG.

- I. NOT MORE THAN 3 LIGHTING OR CONVENIENCE OUTLET CIRCUITS SHALL BE INSTALLED IN ONE CONDUIT UNLESS OTHERWISE INDICATED. PULL NO THERMOPLASTIC WIRES AT TEMPERATURES LOWER THAN 32 DEG F. PROVIDE SEPARATE RACEWAYS FOR CONDUCTORS OF 120/208 AND 265/460 VOLT SYSTEMS. EXCEPT 460 VOLT MOTOR BRANCH CIRCUIT WIRING AND RELATED 120 VOLT CONTROL WIRING. THERMOPLASTIC WIRES SHALL NOT BE INSTALLED IN COMPUTER AREA RAISED FLOORS.

- J. LEAVE WIRES WITH SUFFICIENT SLACK TO PERMIT MAKING FINAL CONNECTIONS.

- K. PERFORM CONTINUITY AND INSULATION TESTS. MEGGER TEST 100 PERCENT OF FEEDERS, 10 PERCENT OF BRANCH CIRCUITS AND ALL MOTOR BRANCH CIRCUITS OVER 25 HP.

PERFORM TESTS PRIOR TO CONNECTING EQUIPMENT AND IN PRESENCE OF AUTHORIZED REPRESENTATIVES. SUBMIT WRITTEN REPORT OF RESULTS. CORRECT OR REPLACE CABLE TESTING BELOW MANUFACTURER'S STANDARDS.

#### 11. WIRING DEVICES:

- A. WIRING DEVICES SHALL BE SPECIFICATION GRADE UNLESS OTHERWISE SPECIFIED. ALL DEVICES SHALL BE FLUSH MOUNTED, UNLESS OTHERWISE NOTED. PROVIDE COMPLETE MATERIAL AND ACCESSORIES AS NOTED.

- B. LOCAL WALL SWITCHES SHALL BE ROCKER TYPE, QUIET OPERATING, RATED 20 AMP, 120/277 VOLT, AC, SIMILAR TO LEVITON DECORA SERIES A5621 (SINGLE POLE), A5623 (3-WAY) AND A5624 (4-WAY).

- C. STRAIGHT BLADE RECEPTACLES SHALL BE RESIDENTIAL GRADE DUPLEX CONVENIENCE 125 VOLTS, 2 POLE, 3 WIRE, U GROUND SLOT, DECORA SERIES BY LEVITON, GROUNDED, EXCEPT AS NOTED.

- 1) SINGLE GANG, RECESSED, DUPLEX RECEPTACLE: TAMPER RESISTANT, 2-POLE, 3-WIRE GROUNDING, 15A, 125V, NEMA 5-20R; LEVITON 689 SERIES (COLOR AS SPECIFIED BY ARCHITECT).
- 2) USB CHARGER/ DUPLEX TAMPER-RESISTANT RECEPTACLE: TAMPER RESISTANT.

- D. DEVICE PLATES: SEE ARCHITECT FOR TYPE. FOR RECEPTACLES WITH OTHER THAN 120 VOLT, INSCRIBED VOLTAGE AVAILABLE.

- E. COLORS: COORDINATE COLORS WITH ARCHITECT.

- F. MOUNTING ORIENTATION OF RECEPTACLES (HORIZONTAL OR VERTICAL): COORDINATE WITH ARCHITECT.

#### 12. LIGHTING FIXTURES:

- A. FIXTURES TO BE AS SPECIFIED BY ARCHITECT AND SHALL BE COMPLETELY FACTORY ASSEMBLED, WIRED AND EQUIPPED WITH ALL NECESSARY SOCKETS, BALLASTS, SUPPORTING HARDWARE AND ACCESSORIES. REFER TO DRAWINGS FOR INDIVIDUAL FIXTURE DESCRIPTIONS.

- B. FIXTURE CATALOG NUMBERS USED TO ILLUSTRATE EQUIPMENT TYPE DO NOT NECESSARILY DENOTE REQUIRED MOUNTING EQUIPMENT OR ACCESSORIES. PROVIDE ACCESSORIES TO SUIT.

- C. BALLAST: CLASS P, HIGH POWER FACTOR, LOWEST AVAILABLE NEMA RATED NOISE LEVEL, ET1 AND CBM APPROVED, ENERGY SAVING TYPE, TRIGGER START FOR 24-INCH LAMPS AND RAPID START FOR 48-INCH, TWO LAMP BALLASTS; NO THREE LAMP BALLASTS. BALLASTS SHALL BE ADVANCE MAGNETEK, UNIVERSAL OR EQUAL.

- D. LED DRIVERS SHALL BE ELECTRONIC TYPE, LABELED AS COMPLIANT WITH RADIO FREQUENCY INTERFERENCE (RFI) REQUIREMENTS OF FCC TITLE 47, PART 15 AND COMPLY WITH NEMA SSL 1 "ELECTRONIC DRIVERS SHALL HAVE A SOUND RATING OF 'A', HAVE A MINIMUM EFFICIENCY OF 85% AND BE RATED FOR A THD OF LESS THAN 20% AT ALL INPUT VOLTAGES.

- E. DIMMABLE LED DRIVERS SHALL BE CAPABLE OF DIMMING WITHOUT LED STROBING OR FLICKER ACROSS THEIR FULL DIMMING RANGE. PROVIDE TYPE OF LED DRIVER AS PER LIGHTING FIXTURE SCHEDULE. DIMMABLE LED DRIVERS SHALL BE 0-10V WHERE NOT INDICATED.

- F. CONTINUOUS ROW, TWO LAMP STRIP FIXTURES SHALL BE STAGGERED TYPE.

- G. EXIT SIGNS SHALL BE PRECISION DIE-CAST ALUMINUM HOUSING WITH LASER-FORMED ACRYLIC LEGEND. EXIT SIGNS SHALL COMPLY WITH UL 924 AND BE MEA APPROVED, AC POWERED WITH PREMIUM LONG-LIFE NICKEL CADMIUM BATTERY WITH STANDARD UL LISTED 3-HOUR RUN TIME. PROVIDE WITH INTEGRAL AUTOMATIC CHARGER IN A SELF CONTAINED POWER PACK. LED INDICATOR WITH PUSH TO TEST SWITCH.

#### 13. TELEPHONE CONDUIT SYSTEM:

- A. PROVIDE COMPLETE SYSTEM OF: RACEWAYS AND ACCESSORIES, OUTLET BOXES, SLEEVES AND FISHWIRES.

- B. EQUIPMENT SHALL CONFORM TO REQUIREMENTS OF TELEPHONE COMPANY.

- C. OUTLETS SHALL BE:

- 1) WALL: 4 IN. SQUARE WITH BUSHED COVER PLATE.

- D. PROVIDE FISHWIRES, IN RACEWAYS OVER 10 FT LONG.

- E. CONDUIT SHALL BE 3/4 IN. MINIMUM. FURNISH EMPTY CONDUIT FROM OUTLET BOX TO BUSHED END THRU WALL 6" BELOW THE PLASTER CEILING.

- F. FACE RACEWAYS IN ROOMS SHALL HUBBELL HBL500, HBL750 OR HBL2000 SERIES OR AS ACCEPTABLE.

#### 14. GROUNDING AND BONDING:

- A. PROVIDE GROUNDING SYSTEM IN ACCORDANCE WITH 2020 NATIONAL ELECTRIC CODE (NEC), AND THESE SPECIFICATIONS. THE WIRING SYSTEM SHALL BE INSTALLED AS REQUIRED TO PROVIDE A CONTINUOUSLY GROUNDED SYSTEM. WHERE FLEXIBLE CONDUIT IS USED FOR PART OF A CONDUIT RUN, EXCEPT LIGHTING BRANCH CIRCUITS, AN INSULATED GROUNDING CONDUCTOR SHALL BE PROVIDED IN THE CONDUIT AND CONNECTED TO GROUNDING BUSHINGS AT EACH END OF THE RUN.

- B. USE EXOTHERMIC WELDING PROCESS FOR INACCESSIBLE CONNECTIONS.

- C. EXTEND EXISTING SYSTEM GROUND TO INCLUDE ALL THE ELECTRICAL EQUIPMENT IN THE SCOPE OF WORK.

- D. WHERE FLEXIBLE METALLIC CONDUIT IS USED AN INTERNAL BONDING CONDUCTOR SHALL BE INSTALLED.

- E. IN ADDITION, FURNISH A SEPARATE INSULATED GREEN EQUIPMENT GROUND CONDUCTOR WHERE INDICATED ON DRAWINGS AND FOR THE FOLLOWING BRANCH CIRCUITS:

- 1) CIRCUITS SERVING ANY WALL BOX DIMMER.

- 2) CIRCUITS SERVING ANY ISOLATED GROUND RECEPTACLES. TERMINATE GROUND DIRECTLY AT AN EQUIPMENT GROUNDING CONDUCTOR TERMINAL OF THE SOURCE AT THE SOURCE, OR AS OTHER WISE NOTED ON DRAWINGS.

- 3) CIRCUITS SERVING ANY DUPLEX OR SIMPLEX COMPUTER RECEPTACLES

- 4) ANY CIRCUIT SERVED VIA AN ISOLATION TRANSFORMER OR COMPUTER POWER DISTRIBUTION UNIT.

#### 15. PANELBOARDS:

- A. PANELBOARDS SHALL BE OF THE DEAD FRONT TYPE MANUFACTURED IN CODE GAUGE AND SIZE BOXES FOR MOUNTING AS INDICATED ON PLANS COMPLETE WITH TRIM, DOORS AND LOCKS. ALL LOCKS SHALL BE KEYED ALIKE.

- B. CIRCUIT BREAKERS SHALL BE OF THE BOLT-ON THERMAL MAGNETIC MOLDED CASE TYPE, AND SHALL HAVE THE TRIP RATINGS AND NUMBER OF POLES SHOWN IN SCHEDULES ON THE CONTRACT DRAWINGS. FOR BLANK (SPACE) COMPARTMENTS, PROVIDE FULL RATED BUS, MINIMUM GUTTER SPACES SHALL BE 5-3/4" SIDES, TOP AND BOTTOM. INCREASE FOR THROUGH FEEDERS. PROVIDE 25% COPPER GROUND BUS AND 100% COPPER NEUTRAL BUS AND INCREASE NEUTRAL BUS INDICATED.

- C. LOCKING TABS SHALL BE PROVIDED ON ALL CIRCUIT BREAKERS SERVING EMERGENCY LIGHTING, FIRE ALARM SYSTEM, SECURITY SYSTEMS AND OTHER EMERGENCY OR CRITICAL EQUIPMENT AND AS NOTED ON THE CONTRACT DRAWINGS. A TOTAL OF 8 SPARE LOCKING TABS SHALL BE FURNISHED TO THE OWNER.

- D. BUSES SHALL BE HARD DRAWN COPPER OF 98 PERCENT CONDUCTIVITY AND SHALL HAVE CROSS SECTIONAL AREAS LARGE ENOUGH TO LIMIT THE TEMPERATURE RISE, WHEN CARRYING FULL LOAD, TO 35 DEGREES C ABOVE AN AMBIENT INSIDE THE ENCLOSURE OF 55 DEGREES C, AS DEFINED IN IEEE STANDARD RULES. MAIN BUS CAPACITY SHALL BE AS SHOWN ON THE CONTRACT DRAWINGS.

- E. ENCLOSURES SHALL BE SURFACE OR FLUSH AS INDICATED. TRIMS SHALL BE SECURED TO PANEL WITH MACHINE SCREWS. COVERS SHALL BE HINGED DOOR-IN-DOOR CONSTRUCTION WITH CYLINDER LOCKS AND CATCHES. LOCKS MUST BE COMPATIBLE WITH BUILDING STANDARD KEY SYSTEM AND WHEN NONE EXISTS, THEY SHALL BE SIMILAR TO A YALE NO. 911 KEY.

- F. DISTRIBUTION AND SUB-DISTRIBUTION PANELBOARD SHALL BE A MINIMUM OF 30" WIDE AND 10" DEEP.

- G. ALL STANDARD PANELBOARDS SHALL BE A MINIMUM OF 20" WIDE AND 5 3/4" DEEP.

- H. FURNISH ALL PANELBOARDS WITH FEED-THRU LUGS UNLESS OTHERWISE INDICATED ON THE DRAWINGS.

- I. ALL NEW PANELBOARDS SHALL BE PROVIDED WITH AN ENGRAVED WHITE CORE LAMACOID NAMEPLATE, WITH 3/4 IN. WHITE LETTERING ON A BLACK BACKGROUND, WITH DESIGNATION LISTED (PANELBOARD NAME), FASTENED WITH EPOXY CEMENT OR OVAL HEAD CHROME PLATED MACHINE SCREWS.

- J. THE CIRCUIT DIRECTORY SHALL BE TYPEWRITTEN AND PROVIDED INSIDE EACH PANEL DOOR TO INDICATE EQUIPMENT AND/OR AREA SERVED. DIRECTORY HOLDER SHALL BE METAL FRAME WITH CLEAR PLASTIC, TRANSPARENT COVER. THE TYPEWRITTEN LIST INDICATING CIRCUIT NUMBERS, OUTLETS SUPPLIED AND THEIR LOCATIONS SHALL BE PROVIDED.

- K. TIE-BARS SHALL NOT BE USED TO CREATE MULTI-POLE CIRCUITS. MAXIMUM 42 CIRCUITS ALLOWED.

- L. ONLY ONE WIRE SHALL BE INSTALLED UNDER EACH CIRCUIT BREAKER LUG.

- M. SHORT CIRCUIT RATING OF PANELBOARDS SHALL NOT BE LESS THAN AS INDICATED ON THE CONTRACT DRAWINGS OR SPECIFIED HEREIN, WHERE NOT INDICATED OR SPECIFIED THE MINIMUM SHORT CIRCUIT RATING SHALL BE EQUAL TO THE INTERRUPTING CAPACITY OF THE LOWEST RATED CIRCUIT BREAKER IN THE PANELBOARD, BUT IN NO CASE LESS THAN 10,000 AMPERES R.M.S. SYMMETRICAL FOR 208Y/120 VOLT SYSTEM AND 14,000 AMPERES R.M.S. SYMMETRICAL FOR 480Y/277 VOLT SYSTEM. SERIES RATED PANELBOARDS SHALL BE USED TO ACHIEVE REQUIRED SHORT CIRCUIT RATINGS.

- N. FOR ALL EXISTING PANELBOARDS, CONTRACTOR SHALL PROVIDE NEW CIRCUIT BREAKERS TO REPLACE EXISTING AS REQUIRED AS INDICATED ON DRAWINGS.

#### 16. INTERCOM CONDUIT SYSTEM:

- A. PROVIDE COMPLETE SYSTEM OF: RACEWAYS AND ACCESSORIES, OUTLET BOXES, SLEEVES AND FISHWIRES.

- B. EQUIPMENT SHALL CONFORM TO REQUIREMENTS OF INTERCOM MANUFACTURER.

- C. OUTLETS SHALL BE:

- 1) WALL: 4 IN. SQUARE WITH SINGLE GANG COVER PLATE.

- D. PROVIDE FISHWIRES, IN RACEWAYS OVER 10 FT LONG.

- E. CONDUIT SHALL BE 3/4 IN. MINIMUM. FURNISH EMPTY CONDUIT FROM EACH APARTMENT TO MAIN INTERCOM CONTROLLER AT ENTRANCE.

#### PROJECT INFORMATION:

KIDSUNITED


#### DRAWING TITLE:

ELECTRICAL SPECIFICATIONS  
(2 OF 2)

#### DRAWING NO.:

E-0.3

**INTERMATIC ET1125C WIRING DIAGRAM**

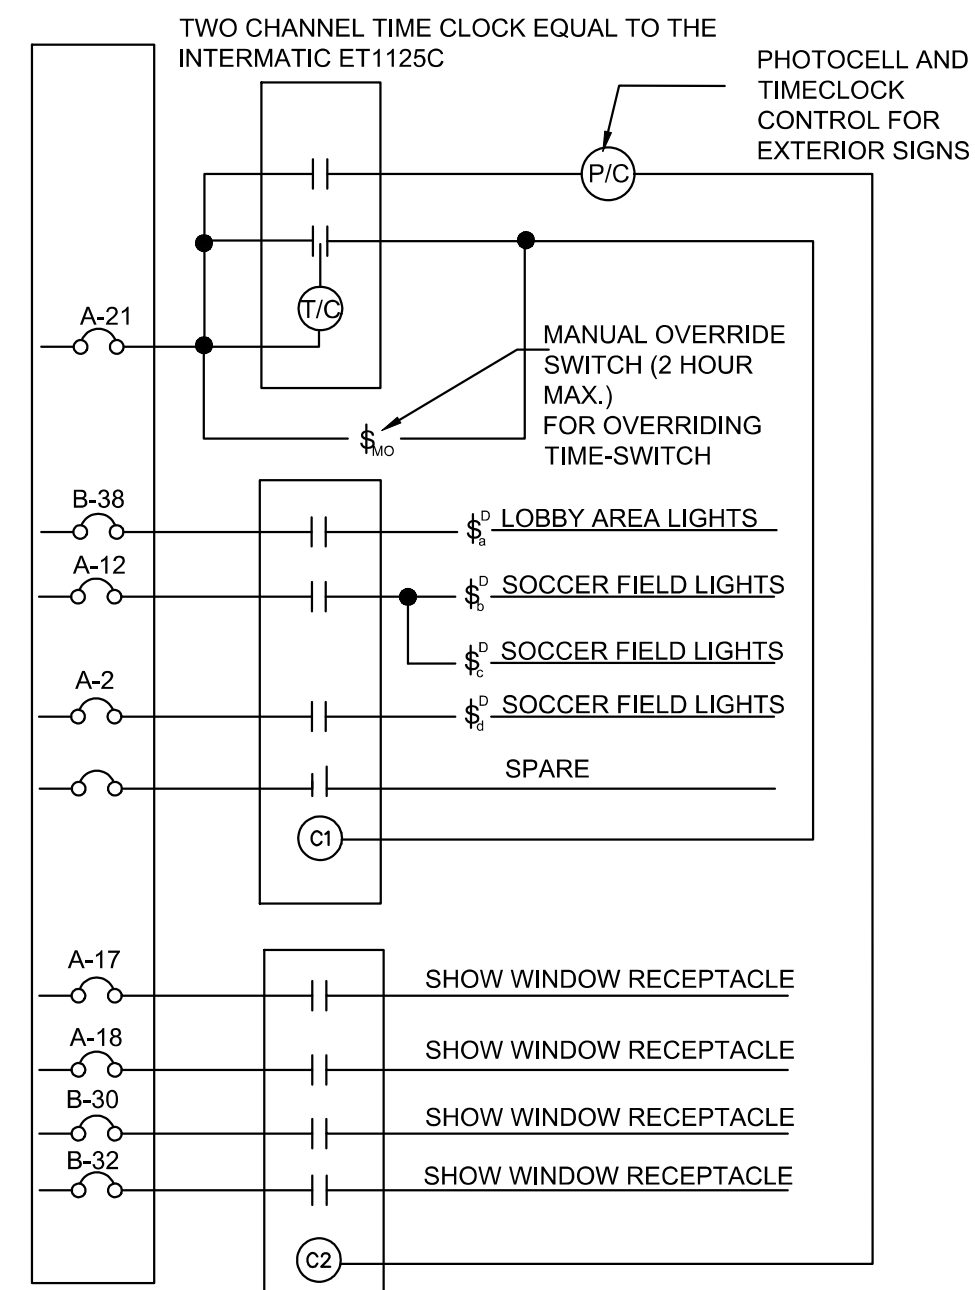


**INTERMATIC ET1125C ELECTRONIC TIME SWITCH NOTES:**

1. INTERMATIC TIMER BOX SHALL BE LOCATED AS CLOSE TO PANELBOARD AS PRACTICAL. PROVIDE WIRING FROM LOW VOLTAGE SWITCH TO RELAY CABINET REQUIRED FOR EACH RELAY AS REQUIRED.
2. PROGRAM LIGHTING SCHEDULE AND HOURS OF OPERATION WITH OWNER.
3. PROVIDE LOW VOLTAGE OVERRIDE SWITCH AS INDICATED ON DRAWINGS INTERMATIC ET1125C SERIES. LOW-VOLTAGE OVERRIDE SWITCH CONTROLS SHALL INITIATE AN OVERRIDE OF A MAXIMUM TIME OF NO MORE THAN TWO (2) HOURS.
4. PROVIDE TWO (2) HOUR TRAINING ON PROGRAMMING OF SYSTEM & SYSTEM OPERATION.

**LIGHTING CONTROL SEQUENCE OF OPERATIONS**

- A. HOURS OF OPERATION**  
 GENERAL NOTE: CONFIRM ALL TIMELOCK SCHEDULES AND SENSOR TIME DELAYS WITH OWNER PRIOR TO FINAL PROGRAMMING.  
 OCCUPIED HOURS: MON-SAT 8:00 AM - 10:00 PM, SUN 9:00 AM 8:00 PM  
 BUSINESS HOURS: MON-SAT 10:00 AM - 8:00 PM, SUN 11:00 AM 6:00 PM  
 EMERGENCY LIGHTING: EMERGENCY LIGHTING SHALL BE PROVIDED VIA 'BUG EYE'S' WITH 90 MINUTES BATTERY BACKUP
- B. LOBBY**
1. TIMELOCK: SPACE IS NETWORKED TO CENTRAL TIMECLOCK.
  2. MANUAL CONTROL: OCCUPANT CAN MANUALLY CONTROL LIGHTS VIA REMOTELY-LOCATED SWITCHES. SWITCHES CAN OVERRIDE TIMECLOCK SETTING FOR 2 HOURS MAXIMUM.
  3. VACANCY: LIGHTS SHALL TURN OFF AUTOMATICALLY BASED ON TIMECLOCK SCHEDULE.
- C. SOCCER FIELD**
1. TIMELOCK: SPACE IS NETWORKED TO CENTRAL TIMECLOCK.
  2. MANUAL CONTROL: OCCUPANT CAN MANUALLY CONTROL LIGHTS VIA REMOTELY-LOCATED SWITCHES, ALSO PROVIDING BI-LEVEL CONTROL FOR GENERAL LIGHTING DIMMING. SWITCHES CAN OVERRIDE TIMECLOCK SETTING FOR 2 HOURS MAXIMUM.
  3. VACANCY: LIGHTS SHALL TURN OFF AUTOMATICALLY BASED ON TIMECLOCK SCHEDULE.
- D. RESTROOMS**
1. MANUAL CONTROL: OCCUPANT CAN MANUALLY CONTROL LIGHTS VIA LOCAL SWITCH.
  2. OCCUPANCY: SENSOR SHALL AUTOMATICALLY TURN LIGHTS ON.
  3. VACANCY: AFTER 15 MINUTES, ALL CONTROLLED LOADS SHALL TURN OFF.

**LIGHTING LEGEND**

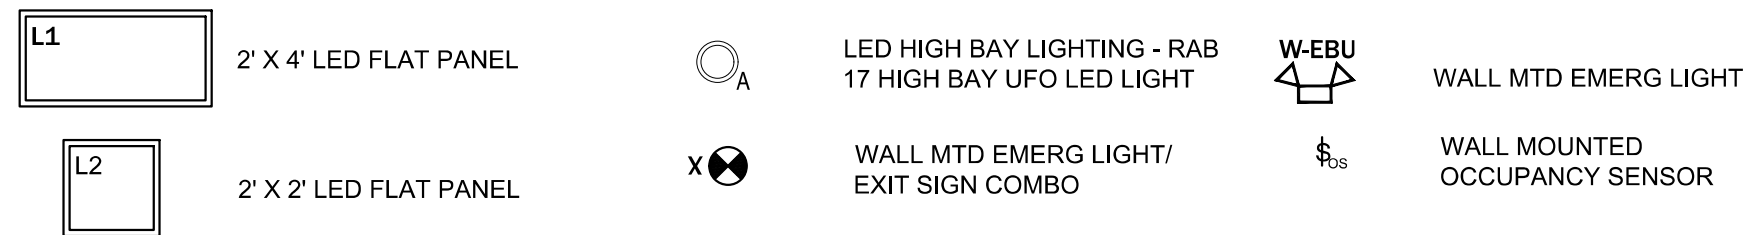

**KEYED NOTES:**


1. WIRE ALL EMERGENCY, EXIT LIGHT AND NIGHT LAMP TO THE NEAREST CIRCUIT AHEAD OF ALL CONTROLS & SWITCHING FOR CONTINUOUS OPERATION.
2. TIME CLOCK OVERRIDE SWITCH.
3. LIGHTING NEAR ELECTRICAL PANELS SHALL NOT BE CONTROLLED BY ANY AUTOMATIC MEANS AND SHALL BE COMPILED AS PER NEC 110.26(D).
4. WALL MOUNTED OCCUPANCY SENSOR, E.C. TO COORDINATE EXACT LOCATION OF OCCUPANCY SENSOR WITH ARCHITECT/OWNER PRIOR TO ROUGH-IN.
5. EXISTING LIGHT FIXTURE & ITS ELECTRICAL CONNECTION SHALL REMAIN SAME. E.C. SHALL VERIFY THE OPERABLE CONDITION OF EXISTING LIGHTS & ITS ELECTRICAL CONNECTION IN FIELD. REPLACE IF FOUND INOPERABLE. BASE BID ACCORDINGLY.
6. SHOW WINDOW RECEPTACLE CONTROL BY PHOTOCELL AND TIME CLOCK. E.C. TO COORDINATE WITH ARCHITECT FOR EXACT LOCATION OF TIME CLOCK.
7. E.C. SHALL COORDINATE EXACT LOCATION OF TIME CLOCK WITH ARCHITECT/OWNER.
8. LOCATION OF LIGHTING SWITCH BANK. E.C. TO VERIFY EXACT LOCATION WITH ARCHITECT/OWNER PRIOR ROUGH-IN.

**GENERAL NOTES:**

1. VERIFY ALL LUMINAIRE COLORS, TRIMS, LENGTHS, ETC. WITH THE ARCHITECT PRIOR TO PLACING FINAL PURCHASE ORDERS. SUBMISSION PF SHOP DRAWINGS WILL BE INTERPRETED AS HAVING BEEN COORDINATED WITH THE ARCHITECTURAL DRAWINGS.
2. PROVIDE ALL LENGTHS, FEEDS, ACCESSORIES, CONNECTORS, WIRING, POWER SUPPLIES, DRIVERS ETC. FOR A COMPLETE INSTALLATION. THE E.C. SHALL VERIFY THE COMPLETE BILL OF MATERIAL WITH MANUFACTURER'S REPRESENTATIVE AND ENSURE ALL EQUIPMENT ARE INCLUDED IN BID PRICE. COORDINATE INSTALLATION WITH ARCHITECTURAL DETAILS.
3. VERIFY FINAL LUMINAIRE LOCATIONS WITH OTHER CEILING MOUNTED EQUIPMENTS SUCH AS DIFFUSER WITH ARCHITECTURAL REFLECTED CEILING PLANS.
4. VERIFY EXACT MOUNTING HEIGHT AND LOCATIONS OF ALL WALL MOUNTED LUMINAIRE WITH ARCHITECTURAL PLANS AND ELEVATIONS PRIOR TO ROUGH-IN.
5. ANY PROPOSED ALTERNATE LUMINAIRES SHALL BE APPROVED BY THE ARCHITECT PRIOR TO FINAL BID PRICING.
6. EXIT SIGNS SHALL BE DUAL VOLTAGE WITH RED FACE LETTERING.
7. VERIFY FINAL SELECTION OF THE FIXTURES WITH THE WITH ARCHITECT/OWNER.
8. PLACEMENT OF LIGHT FIXTURES SHALL BE SET AS DIMENSIONED & AS SCHEDULED.
9. LIGHT FIXTURES SHALL BE SUPPLIED AS SCHEDULED WITH NO EXCEPTIONS.
10. ALL EMERGENCY LIGHTS, NIGHT LAMPS AND EXIST LIGHTS SHALL BE CONNECTED TO NEAREST LIGHTING CIRCUIT IN THE AREA AHEAD OF ALL LIGHTING CONTROL MEANS IN ORDER TO BE ENERGIZED AT ALL TIME.

**LIGHT FIXTURE SCHEDULE**

CODE	DESCRIPTION	QTY	MANUFACTURER	CATALOG NUMBER	VOLTAGE	WATT PER FIXTURE	LAMP TYPE	REMARKS
L1	2X4 LED LAY IN	13	LITHONIA	EPANL 24-40L-40K	120/277 V	38.9W	LED	
L2	2X2 LED LAY IN	3	EXISTING TO REMAIN					
A	HI-BAY LIGHT	14	RAB	H17	120/277 V	100W	LED	
W-EBU	ULTRA COMPACT LED EMERGENCY UNIT (WHITE)	4	EXITRONIX	LED-95-WH	120/277 V	1.5 W	LED	WHITE FINISH
X	EXIT LED LIGHT	4	EXITRONIX	VLED-U-WH-EL90-R	120/277 V	2.2 W	LED	WHITE FINISH

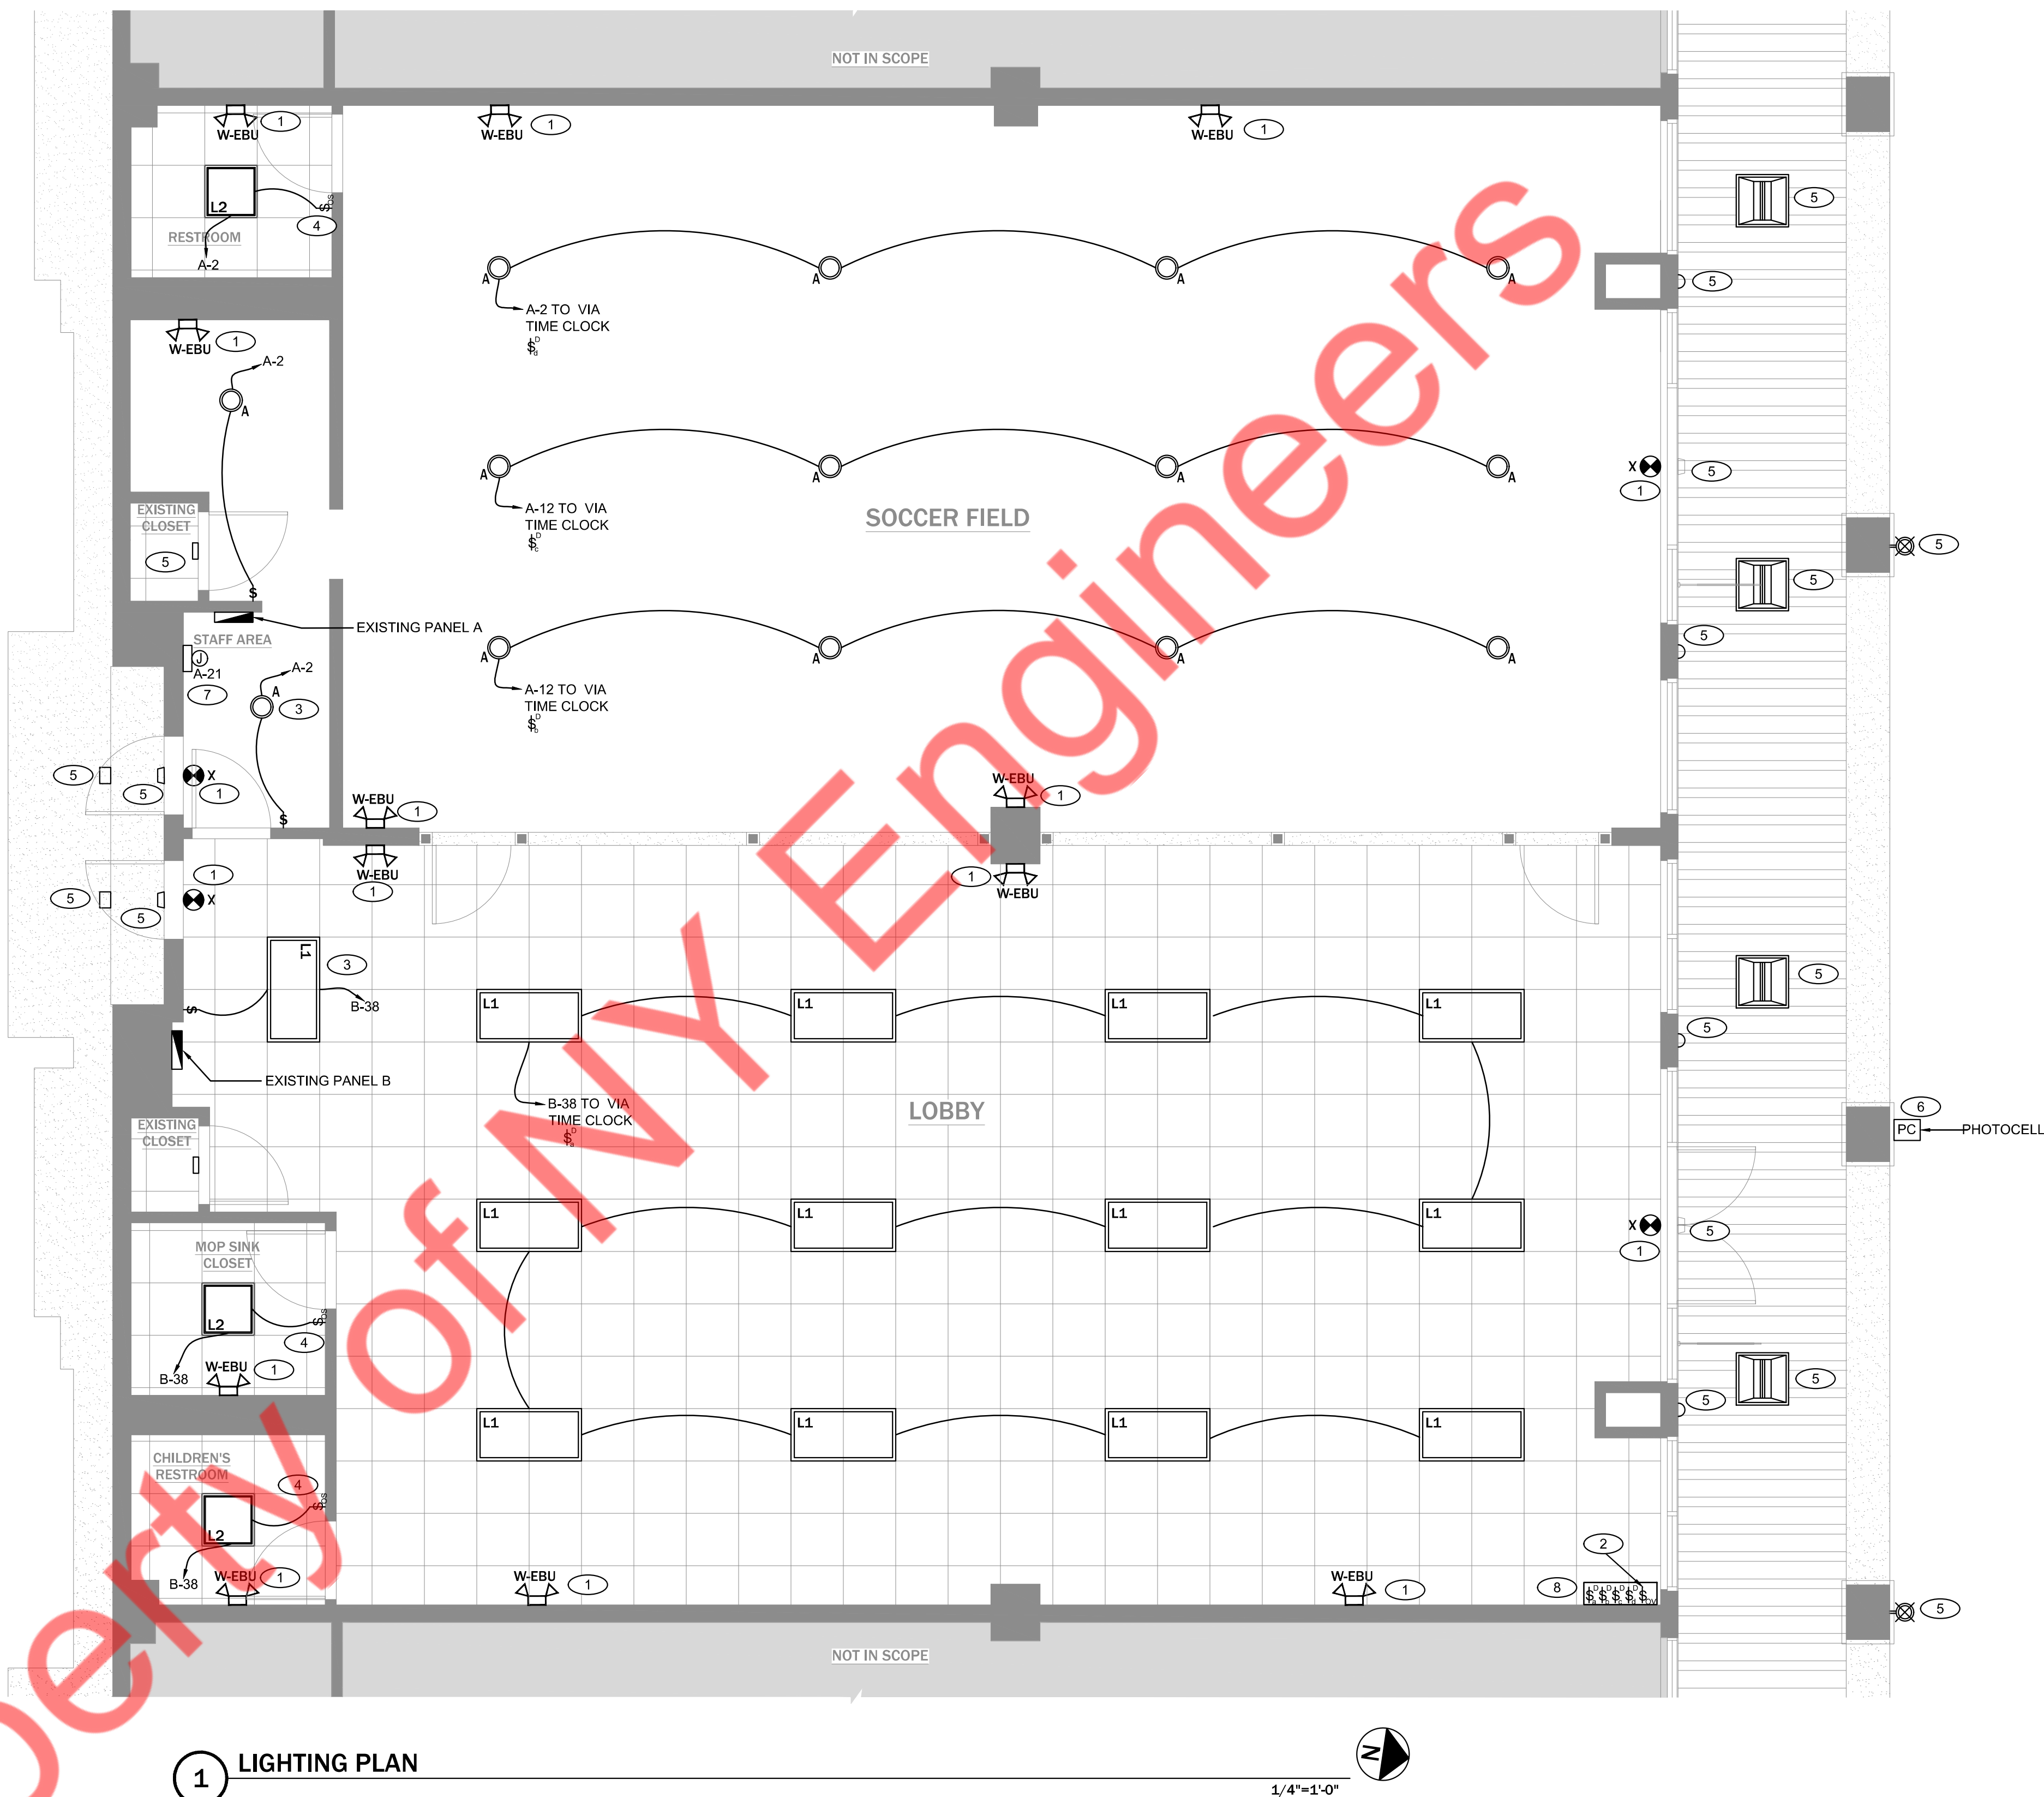

**1 LIGHTING PLAN**

1/4"=1'-0"

**PROJECT INFORMATION:**

**KIDSUNITED**


**DRAWING TITLE:**

**LIGHTING PLAN**


**DRAWING NO.:**

**E-1.0**

- KEYED NOTES:**
- SHOW WINDOW RECEPTACLE. E.C. TO PROVIDE SHOW WINDOW RECEPTACLES AS PER NEC 210.62.
  - JUNCTION BOX AND DISCONNECT SWITCH FOR RECIRCULATION PUMP AND WATER HEATER. E.C. TO COORDINATE FINAL LOCATION WITH PLUMBING CONTRACTOR IN FIELD PRIOR TO ROUGH-IN.
  - RECEPTACLES FOR RECEPTION. E.C. SHALL COORDINATE WITH ARCHITECT/OWNER FOR EXACT LOCATION & REQUIREMENT IN FIELD. BASE BID ACCORDINGLY.
  - ALL 15/20A, 125V AND 250V NON LOCKING TYPE RECEPTACLES SHALL BE TAMPER RESISTANCE AS PER NEC 406.12.
  - EXISTING MECHANICAL EQUIPMENTS & ITS ELECTRICAL CONNECTION SHALL REMAIN. E.C. SHALL FIELD VERIFY THE OPERABLE CONDITION. REPLACE IF FOUND IN OPERABLE. BASE BID ACCORDINGLY.
  - JUNCTION BOX FOR MOTORIZED /FIRE SMOKE DAMPER. E.C. TO FIELD VERIFY EXACT LOCATION OF MOTORIZED/FIRE SMOKE DAMPER WITH MECHANICAL CONTRACTOR PRIOR TO ROUGH-IN.
  - EXISTING EXHAUST FAN SHALL REMAIN. E.C. SHALL VERIFY IF THE EXHAUST FAN IS CONNECTED TO EXISTING PANEL. VERIFY THE OPERABLE CONDITION OF EXISTING FEEDER. IF NOT CONNECTED THEN PROVIDE NEW CIRCUIT AS SHOWN. BASE BID ACCORDINGLY.
- GENERAL NOTES:**
- VERIFY MOUNTING HEIGHTS OF ALL RECEPTACLES WITH EQUIPMENT SUPPLIED PRIOR TO INSTALLATION.
  - E.C. TO PROVIDE CORD & PLUG CONNECTIONS FOR EQUIPMENT AS REQUIRED.
  - ALL CIRCUITS FOR P.O.S. (POINT OF SALE) EQUIPMENT SHALL BE CONNECTED TO THE SAME PHASE OF POWER IN THE PANEL. ALL BRANCH CIRCUIT BREAKERS SUPPLYING P.O.S. EQUIPMENT SHALL HAVE LOCKING HANDLES DEVICES.
  - EACH RECEPTACLE TYPE (LOCKING OR STRAIGHT BLADE) SHALL MATCH THAT OF THE EQUIPMENT FURNISHED.
  - COORDINATE EXACT LOCATION OF HVAC EQUIPMENTS WITH MECHANICAL CONTRACTOR.
  - ELECTRICAL CONTRACTOR SHALL COORDINATE DISCONNECT AND FUSE REQUIREMENT FOR MECHANICAL UNIT WITH MECHANICAL CONTRACTOR AND EQUIPMENT MANUFACTURER PRIOR TO ROUGH-IN AND PROVIDE AS REQUIRED. COORDINATE LOCATION OF DISCONNECT WITH MANUFACTURER AND MECHANICAL CONTRACTOR PRIOR TO ROUGH-IN. LOCATE AS REQUIRED TO MAINTAIN NEC CLEARANCES.

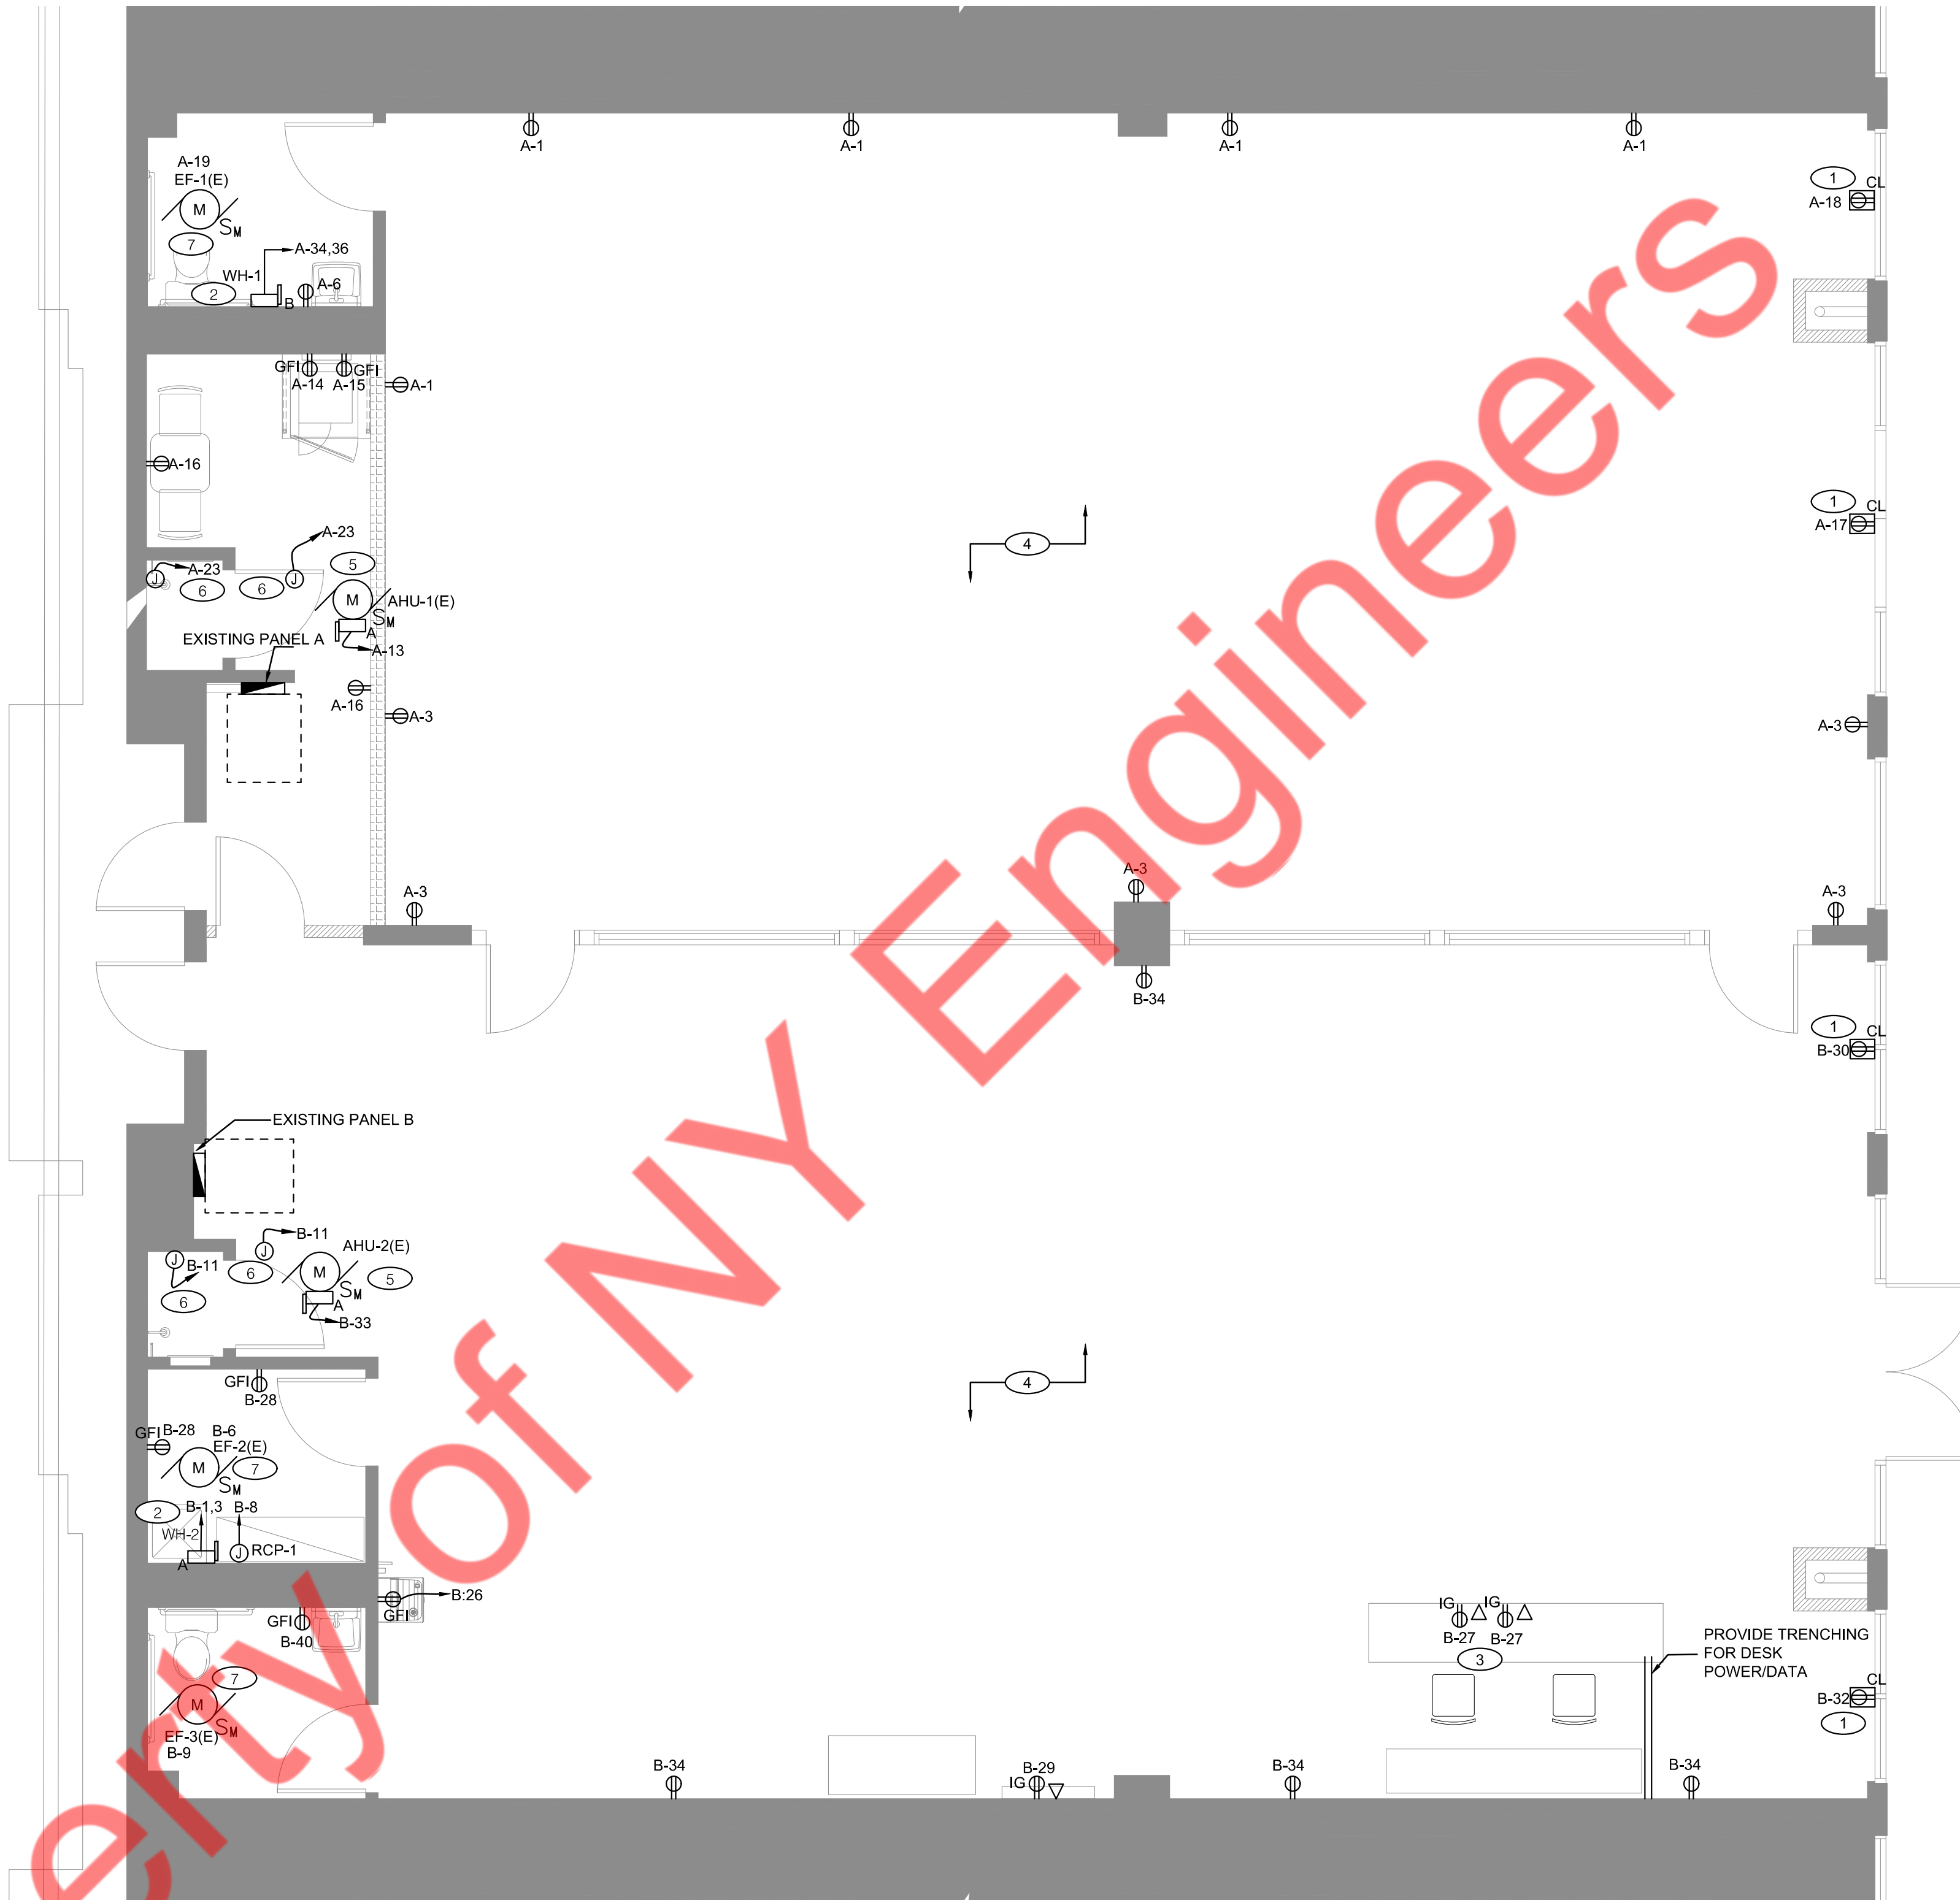

**1 ELECTRICAL POWER PLAN** 1/4"=1'-0"

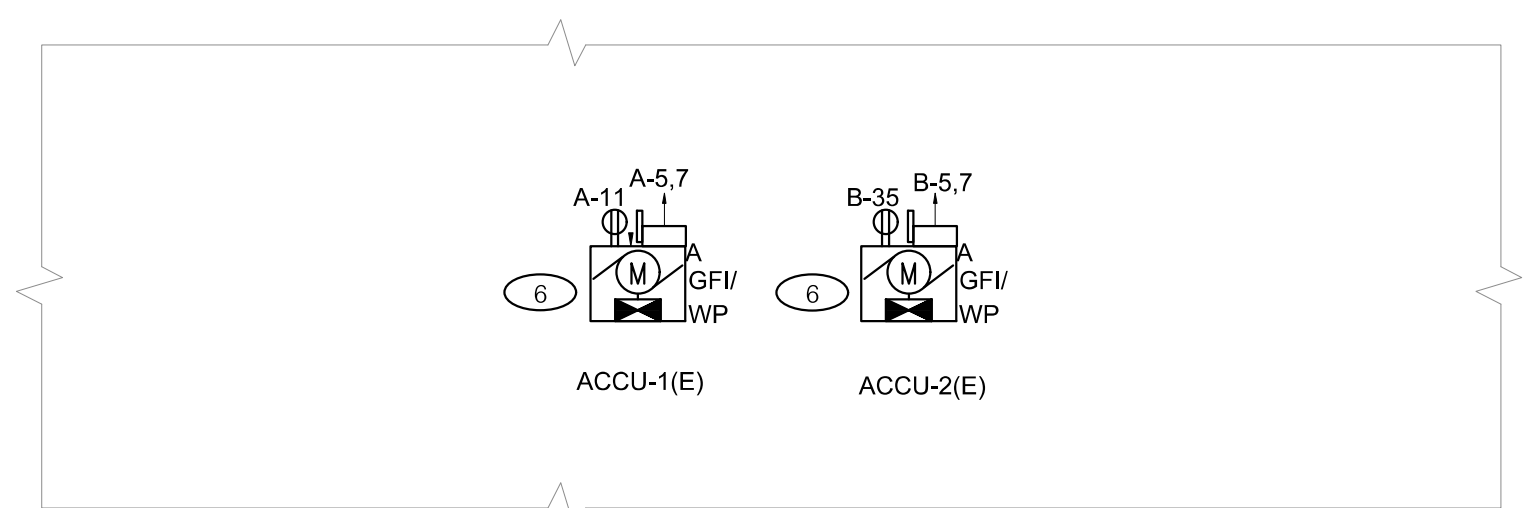


**2 ELECTRICAL PART ROOF PLAN** 1/4"=1'-0"

PROJECT INFORMATION:  
**KIDSUNITED**

DRAWING TITLE:  
**ELECTRICAL POWER PLAN & PART OF ROOF POWER PLAN**

DRAWING NO.:  
**E-2.0**


**NOTE:**  
THIS INFORMATION MAY NOT CONTAIN ALL DETAILS REQUIRED FOR CONSTRUCTION. APPROPRIATE MODIFICATION MAY BE REQUIRED TO ENSURE SUITABILITY OF THESE DRAWINGS FOR THE SPECIFIC APPLICATION. IT IS THE USER'S RESPONSIBILITY TO ENSURE INSTALLATION OF THE EQUIPMENT/SYSTEM IS IN ACCORDANCE WITH BUILDING/PROJECT SPECIFICATIONS, APPLICABLE CODES AND STANDARDS.

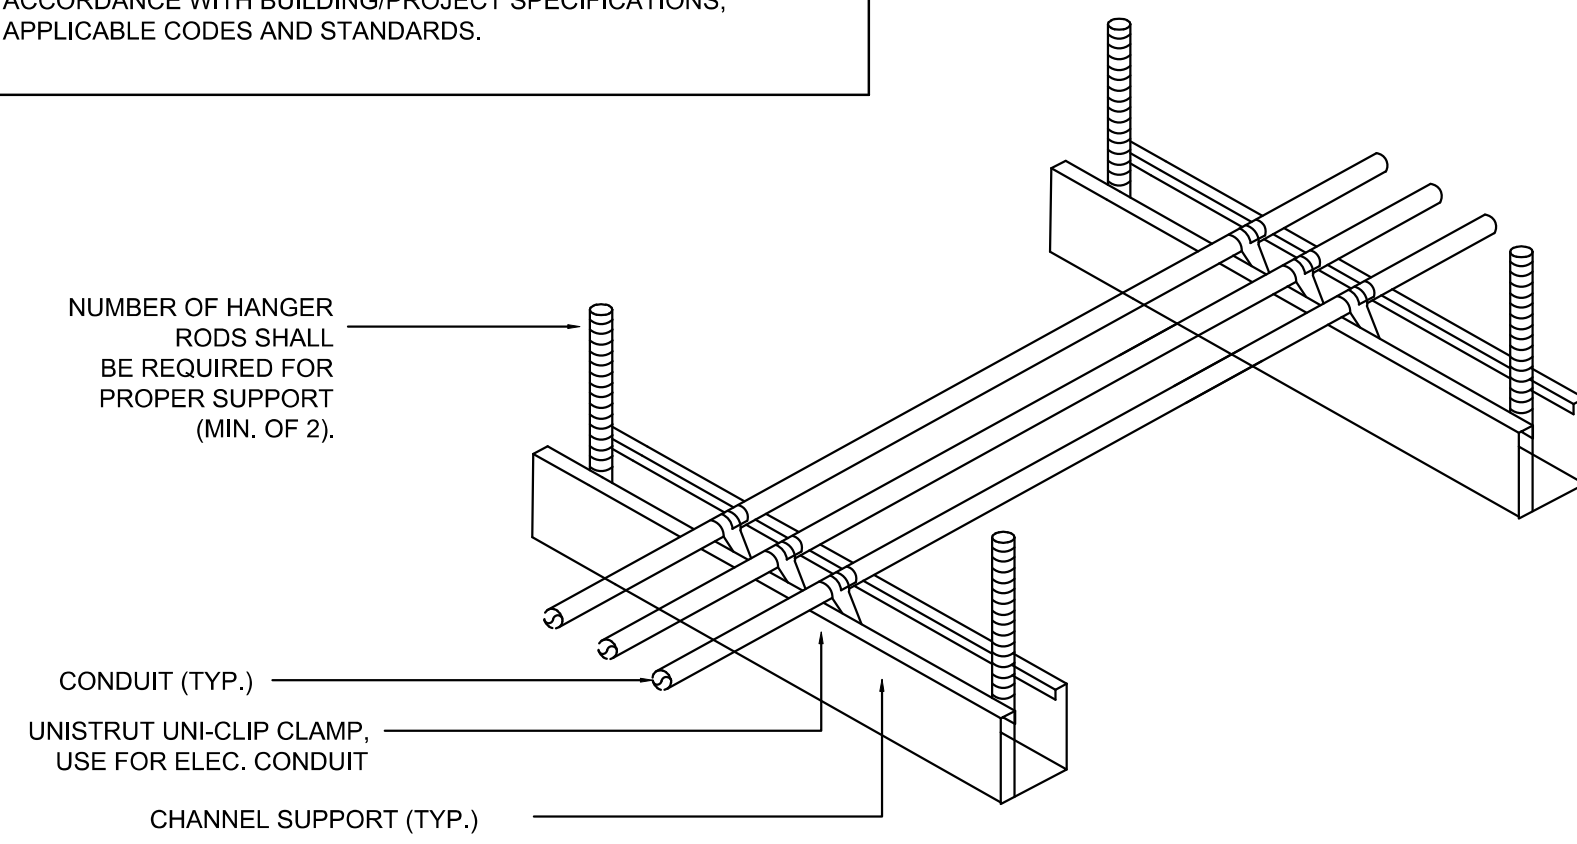


- NOTES:**
1. ALL CONDUIT MAY BE COMBINED ON SAME SUPPORT CHANNEL WHERE PRACTICAL.
  2. SUPPORT CHANNEL LENGTH SHALL NOT BE DETERMINED UNTIL ALL PIPING, CONDUIT, ETC. TO BE SUPPORTED IS COORDINATED.
  3. SUPPORT CHANNEL SPACING SHALL BE NO MORE THAN 10'-0".
  4. UNISTRUT AND CONDUIT INSTALLATION MAY BE REVERSED.

**1 CONDUIT SUPPORT DETAIL**  
N.T.S.

- NOTES:**
1. ALL CONDUCTORS IN VERTICAL RACEWAYS SHALL BE SUPPORTED IN ACCORDANCE WITH ARTICLE 300.19 OF NEC. CABLE SUPPORTS SHALL BE LOCATED AT THE INTERVALS REQUIRED BY THE NEC.
  2. CABLE SUPPORT SYSTEM SHALL BE AS MANUFACTURED BY O-Z GEDNEY WITH μOZ-GRIP "S-STYLE" WEDGING PLUG OR APPROVED EQUAL.
  3. FOR THREADLESS CONDUIT (RIGID, IMC OR EMT), ATTACH CONDUIT BODY TO MALE THREADS OF A SET SCREW OR COMPRESSION CONNECT, AS PERMITTED BY SPECIFICATIONS.
  4. PROVIDE PULL BOX AT EACH LOCATION OF CABLE SUPPORTS. PULL BOX SHALL BE SIZED AS PER CODE TO ACCOMMODATE ALL CONDUITS.

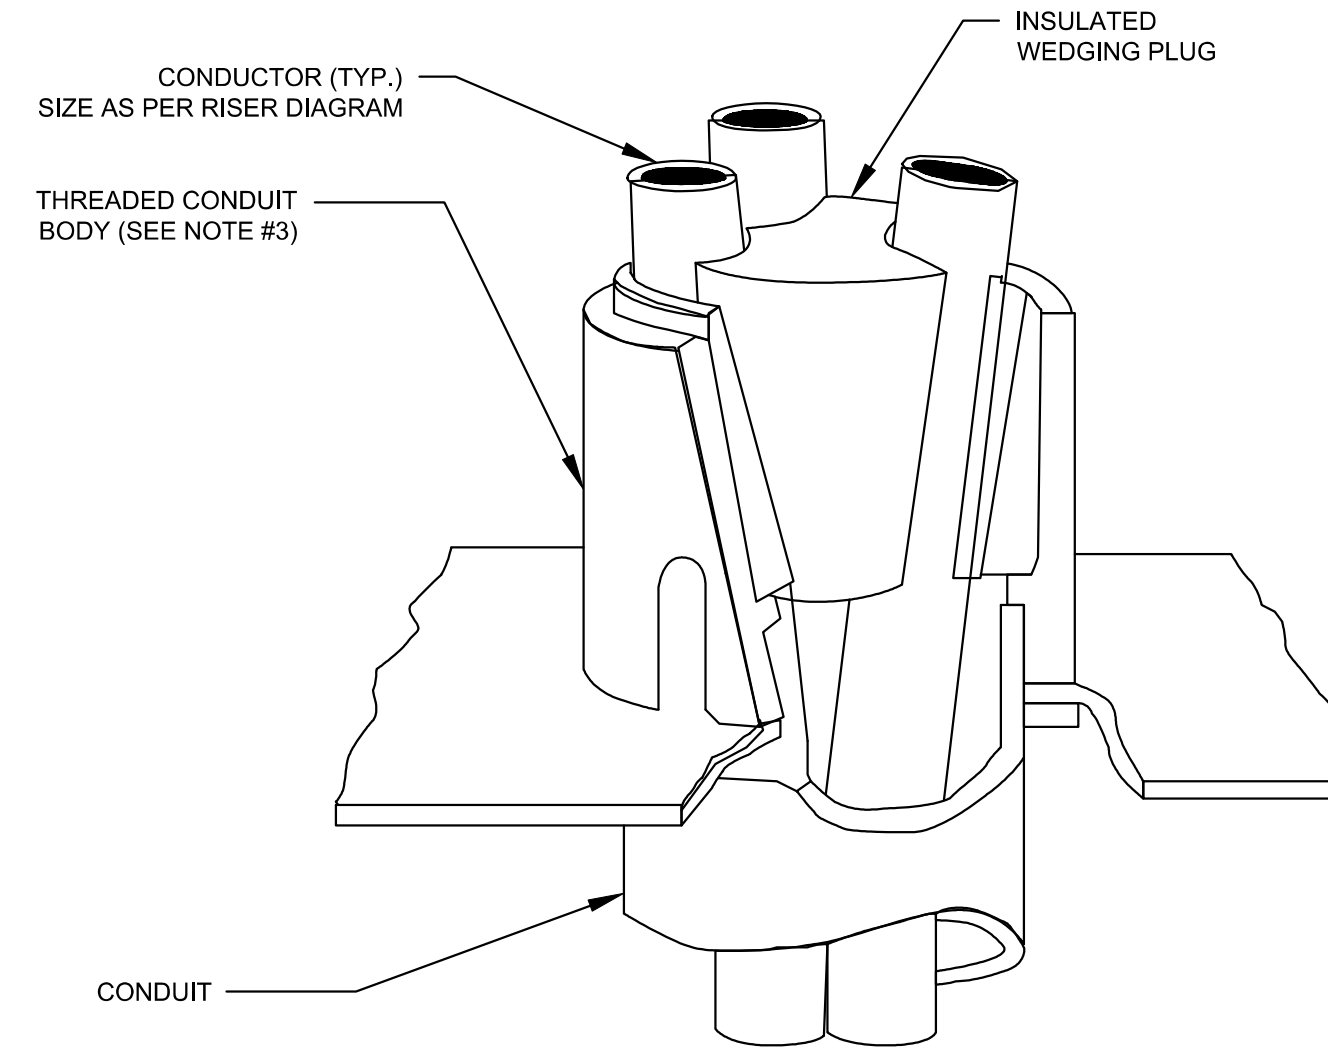

**2 VERTICAL CABLE SUPPORT DETAIL**  
N.T.S.

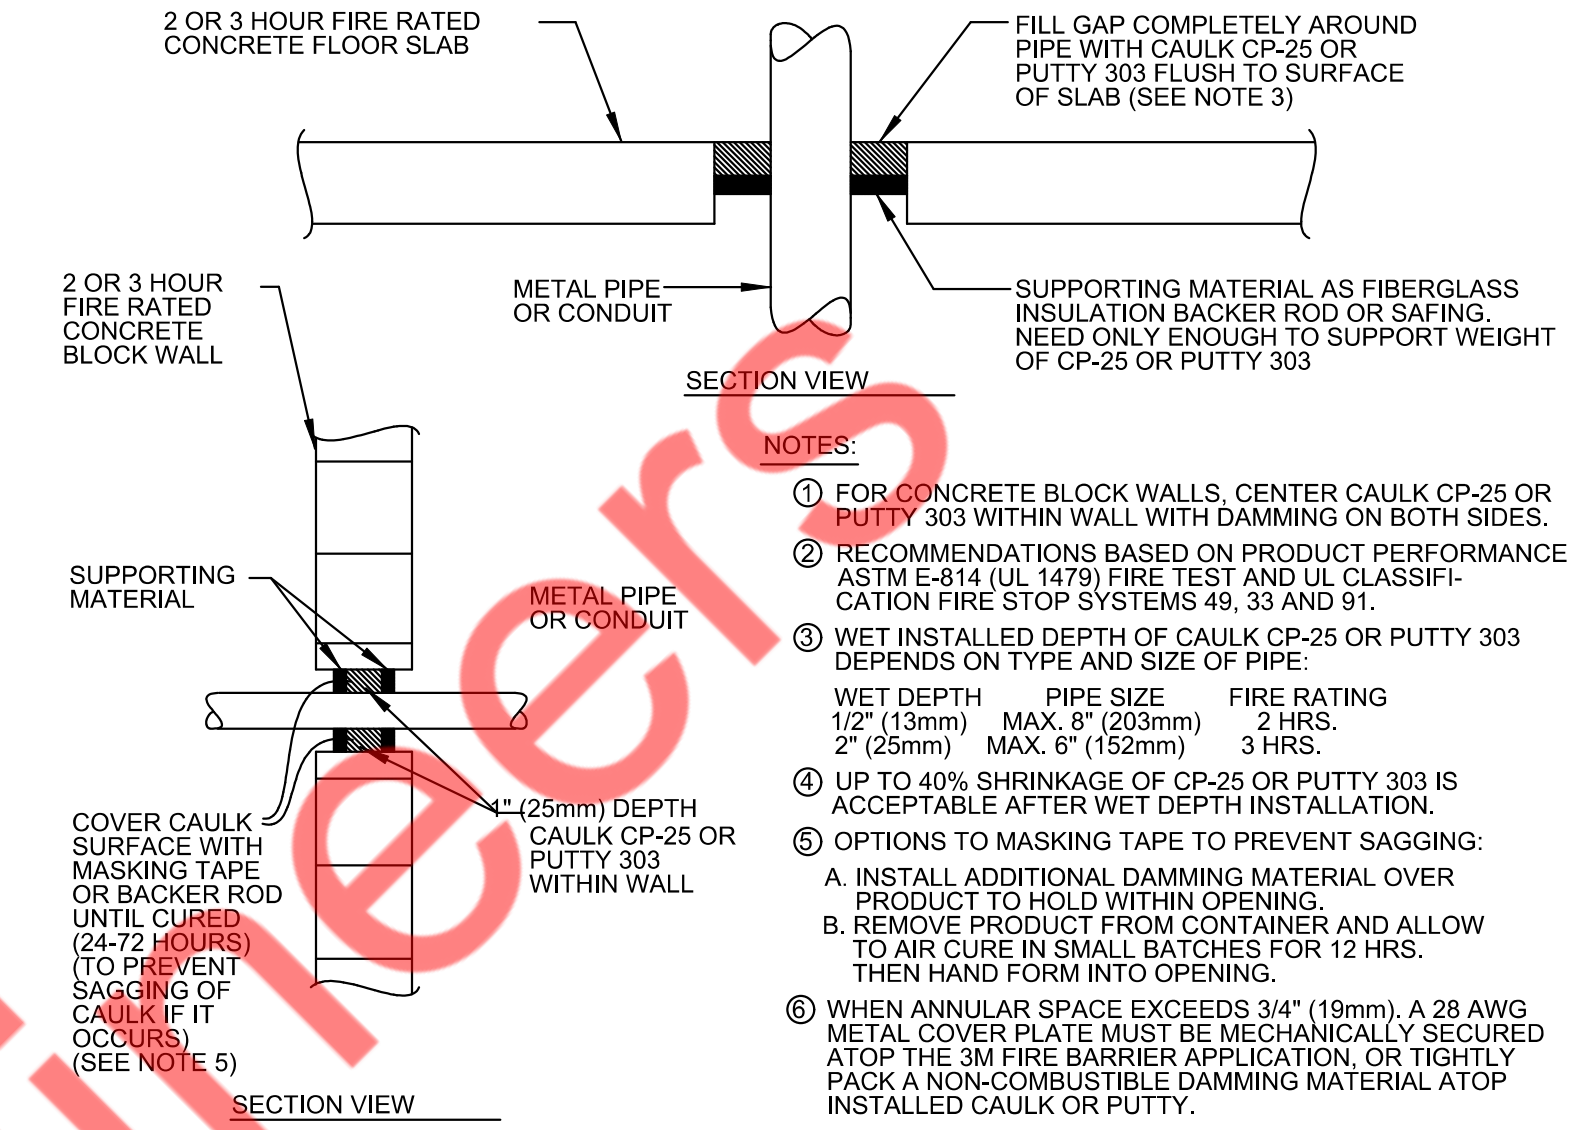

- NOTES:**
1. FOR CONCRETE BLOCK WALLS, CENTER CAULK CP-25 OR PUTTY 303 WITHIN WALL WITH DAMMING ON BOTH SIDES.
  2. RECOMMENDATIONS BASED ON PRODUCT PERFORMANCE PER ASTM E-814 (UL 1479) FIRE TEST AND UL CLASSIFICATION FIRE STOP SYSTEMS 49, 33 AND 91.
  3. WET INSTALLED DEPTH OF CAULK CP-25 OR PUTTY 303 DEPENDS ON TYPE AND SIZE OF PIPE:  

PIPE SIZE	FIRE RATING
1/2" (13mm) MAX. 8" (203mm)	2 HRS.
2" (25mm) MAX. 6" (152mm)	3 HRS.
  4. UP TO 40% SHRINKAGE OF CP-25 OR PUTTY 303 IS ACCEPTABLE AFTER WET DEPTH INSTALLATION.
  5. OPTIONS TO MASKING TAPE TO PREVENT SAGGING:  
 A. INSTALL ADDITIONAL DAMMING MATERIAL OVER PRODUCT TO HOLD WITHIN OPENING.  
 B. REMOVE PRODUCT FROM CONTAINER AND ALLOW TO AIR CURE IN SMALL BATCHES FOR 12 HRS. THEN HAND FORM INTO OPENING.
  6. WHEN ANNULAR SPACE EXCEEDS 3/4" (19mm), A 28 AWG METAL COVER PLATE MUST BE MECHANICALLY SECURED ATOP THE 3M FIRE BARRIER APPLICATION, OR TIGHTLY PACK A NON-COMBUSTIBLE DAMMING MATERIAL ATOP INSTALLED CAULK OR PUTTY.

**3 FIRE SUPPORT DETAIL**  
N.T.S.

**MANUAL MODE OPERATION:**


1. PUSHBUTTON PRESS IS REQUIRED TO TURN LOAD ON.
2. LOAD TURNS OFF WHEN SENSOR TIMES OUT OR BY PRESSING PUSH BUTTON.
3. IF DAYLIGHT SENSOR IS ENABLED AND LIGHT LEVEL IS ABOVE SETPOINT, LOAD WILL NOT TURN ON.

**AUTOMATIC MODE OPERATION:**

1. WHEN SENSOR ACTIVATES LOAD TURNS ON.
2. PUSHBUTTON CAN BE USED TO TURN LOAD ON OR OFF. IF PUSHBUTTON IS USED TO TURN LOAD OFF, SENSOR MUST TIME OUT FIRST, BEFORE LOAD CAN TURN BACK ON AUTOMATICALLY.
3. IF DAYLIGHT SENSOR IS ENABLED AND LIGHT LEVEL IS ABOVE SETPOINT, LOAD WILL NOT TURN ON.

**SENSOR TYPES INCLUDE:**

ONW-D-1001-MV-N

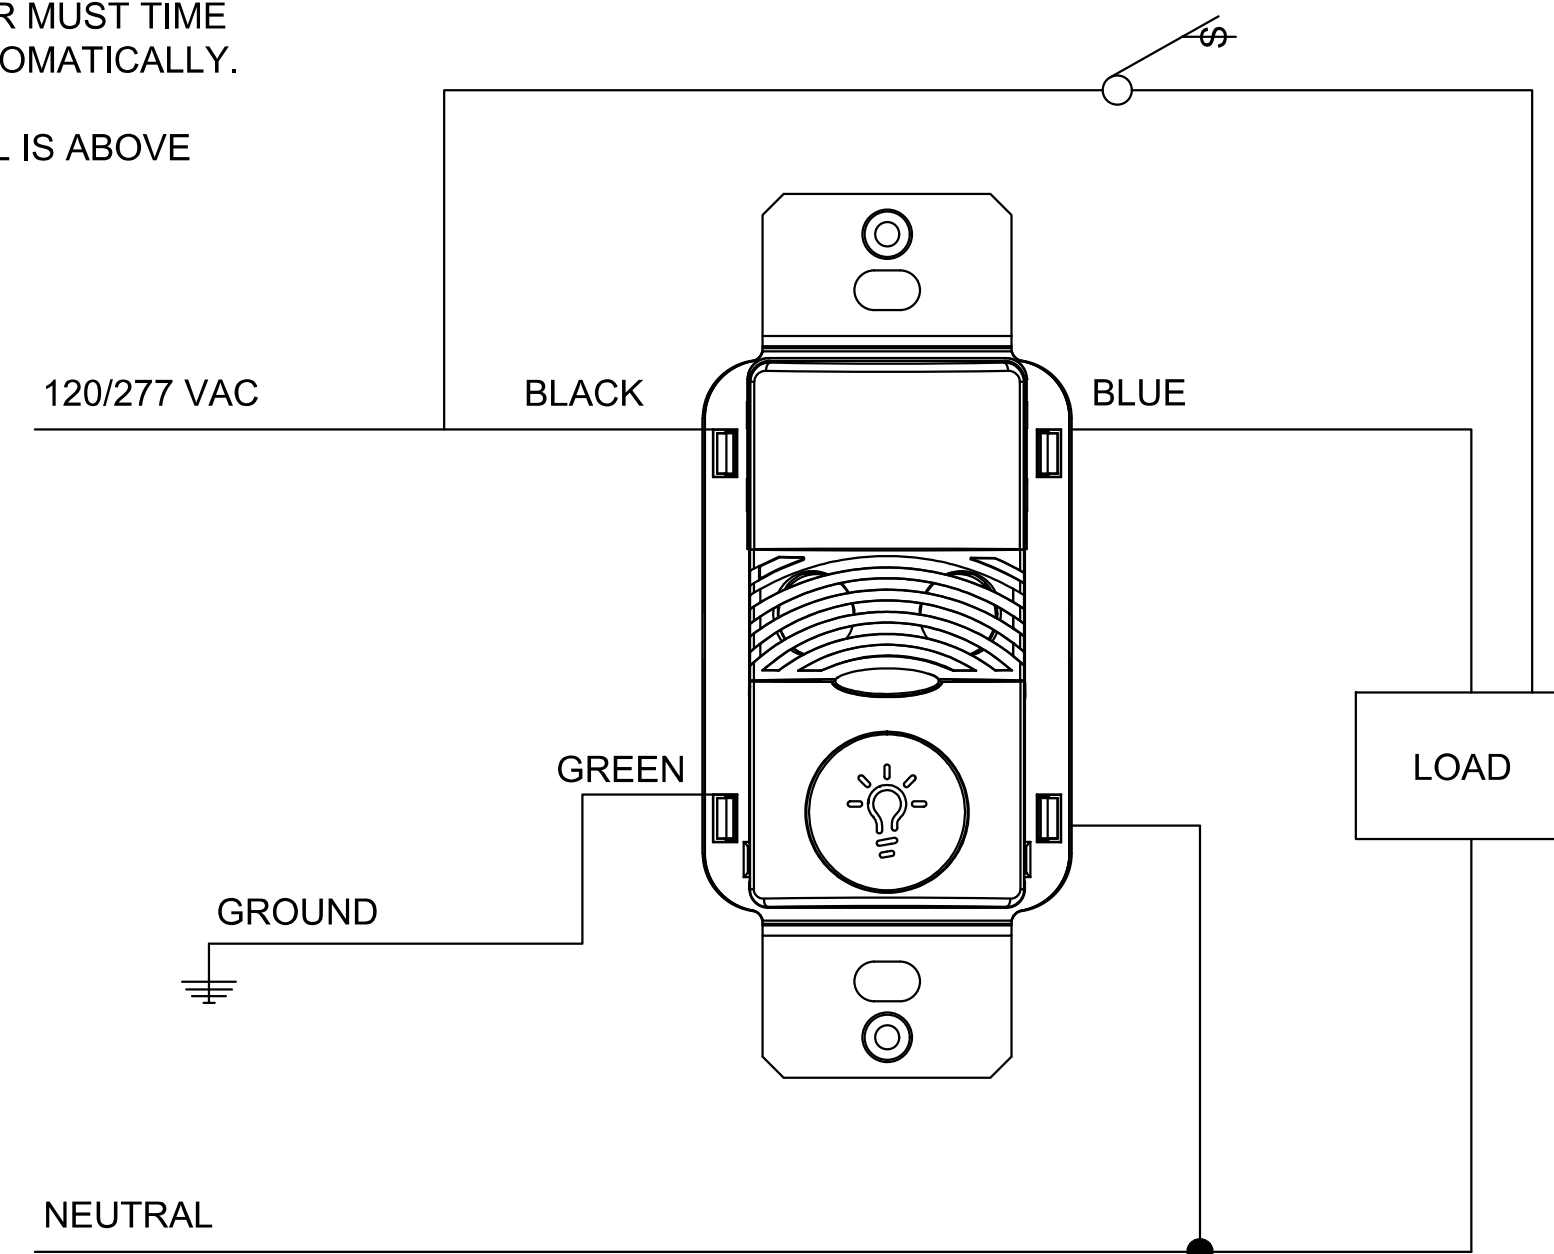

- NOTES:**
1. TYPICAL FOR WOOD AND METAL STUD ROUGH-IN.
  2. PLASTER RINGS NOT SHOWN.
  3. LOCATE ALL OUTLET BOXES IN ACCORDANCE WITH ARCHITECTURAL AND MECHANICAL DRAWINGS, AND WITH ALL APPLICABLE SHOP DRAWINGS.
  4. IN ACCORDANCE WITH UBC 4304 OUTLETS ON OPPOSITE SIDES OF WALLS OR PARTITIONS IN THE SAME STUD SPACE MUST BE SEPARATED BY A MIN. OF 24" HORIZONTAL DISTANCE.

**4 DETAIL TYPICAL ROUGH-IN REQUIREMENTS**  
N.T.S.

**5 LOW VOLTAGE WALL SWITCH SENSOR(NEUTRAL CONNECTION) OCCPANCY/VACANCY-SINGLE LEVEL**  
N.T.S.

**PROJECT INFORMATION:**  
  
KIDSUNITED

**DRAWING TITLE:**  
  
ELECTRICAL DETAILS

**DRAWING NO.:**  
  
E-3.0

PANEL: <b>A(EXISTING)</b>		MOUNTING: SURFACE												
208Y/120	VOLTS,	3	PHASE,	4	WIRE	PANEL LOCATION: BOH								
MAIN CB: 225 A		MLO: NA		BUS: EXISTING		MIN,				FED FROM: EXISTING DISCONNECT SWITCH				
NOTE: LIGHTING, R - RECEPTACLE, H - HVAC, E - KITCHEN EQUIPMENTS, O - OTHER/MISCELLANEOUS, * - NEW BREAKER														
CKT NO.	TRIP AMPS	DESCRIPTION OF LOAD	LOAD TYPE	LOAD (KVA)	MINIMUM BRANCH CIRCUIT	PER PHASE (KVA)			MINIMUM BRANCH CIRCUIT	LOAD (KVA)	LOAD TYPE	DESCRIPTION OF LOAD	TRIP AMPS	CKT NO.
						A	B	C						
1	20	SOCCER FIELD RECEPTACLES	R	0.90	2#12, #12G, 3/4"C	1.53	0.90		2#12, #12G, 3/4"C	0.63	L	SOCCER FIELD, RESTROOM ,STAFF AREA LIGHTING	20	2
3	20	SOCCER FIELD RECEPTACLES	R	0.90	2#12, #12G, 3/4"C						SP	SPARE	20	4
5	30/2P	ACCU-1(E)	H	2.50	EXISTING	2.50		2.68	2#12, #12G, 3/4"C	0.18	R	RESTROOM RECEPTACLE	20	6
7			H	2.50										
9	20	GOOSE NECK LIGHTS	L	1.00	EXISTING		1.80		EXISTING	0.80	R	VERIZON BOX	20	10
11	20	GFI ROOF	R	0.80	EXISTING			1.60	2#12, #12G, 3/4"C	0.80	L	SOCCER FIELD LIGHTING	20	12
13	20	AHU-1(E)	H	1.92	EXISTING	3.48			2#12, #12G, 3/4"C	1.56	E	MICROWAVE	20	14
15	20	UNDER COUNTER REFRIGERATOR	E	0.84	2#12, #12G, 3/4"C		1.20		2#12, #12G, 3/4"C	0.36	R	STAFF AREA RECEPTACLE	20	16
17	20	SHOW WINDOW RECEPTACLE	R	1.20	2#12, #12G, 3/4"C			2.40	2#12, #12G, 3/4"C	1.20	R	SHOW WINDOW RECEPTACLE	20	18
19	20	EF-1(E)	M	0.04	2#12, #12G, 3/4"C	0.04					SP	SPARE	20	20
21	20	TIME CLOCK	O	0.10	2#12, #12G, 3/4"C		0.10				SP	SPARE	20	22
23	20	MD/FSD	O	0.50	2#12, #12G, 3/4"C			0.50			SP	SPARE	20	24
25	20	SPARE	SP			0.00					SP	SPARE	20	26
27	20	SPARE	SP				0.00				SP	SPARE	20	28
29	20	SPARE	SP					0.00			SP	SPARE	20	30
31	20	SPARE	SP			0.00					SP	SPARE	20	32
33	20	SPARE	SP				3.12			3.12	O	WATER HEATER-1	40/2P*	34
35	20	SPARE	SP					3.12	2#8, #10G, 3/4"C	3.12	O	WATER HEATER-1	40/2P*	36
37	30/2P	SPARE	SP			0.00					SP	SPARE	30/2P	38
39			SP				0.00					SP	SPARE	30/2P
41	20	SPACE	SP					0.00			SP	SPACE	20	42
TOTAL CONNECTED LOAD (KVA)						7.54	7.12	10.30						


PANEL: <b>B (EXISTING)</b>		MOUNTING: SURFACE												
208Y/120	VOLTS,	3	PHASE,	4	WIRE	PANEL LOCATION: BOH								
MAIN CB: 225 A		MLO: NA		BUS: EXISTING		MIN,				FED FROM: EXISTING DISCONNECT SWITCH				
NOTE: LIGHTING, R - RECEPTACLE, H - HVAC, E - KITCHEN EQUIPMENTS, O - OTHER/MISCELLANEOUS, * - NEW BREAKER														
CKT NO.	TRIP AMPS	DESCRIPTION OF LOAD	LOAD TYPE	LOAD (KVA)	MINIMUM BRANCH CIRCUIT	PER PHASE (KVA)			MINIMUM BRANCH CIRCUIT	LOAD (KVA)	LOAD TYPE	DESCRIPTION OF LOAD	TRIP AMPS	CKT NO.
						A	B	C						
1	30/2P	WATER HEATER -2	O	2.00	2#10, #10G, 3/4"C	2.00					SP	SPARE	30/2P	2
3			O	2.00			2.00					SP	SPARE	30/2P
5	30/2P	ACCU-2(E)	H	2.50	EXISTING	2.60		2.53	2#12, #12G, 3/4"C	0.04	M	EF-2(E)	20	6
7			H	2.50										
9	20	EF-3(E)	M	0.04	2#12, #12G, 3/4"C		0.04		2#12, #12G, 3/4"C	0.10	O	SPARE	20	10
11	20	MD/FSD	O	0.50	2#12, #12G, 3/4"C			0.50			SP	SPARE	15	12
13	20	SPARE	SP			0.00					SP	SPARE	15	14
15	20	SPARE	SP				0.00				SP	SPARE	15	16
17	20	SPARE	SP					0.00			SP	SPARE	20	18
19	20	SPARE	SP			0.00					SP	SPARE	20	20
21	20	SPARE	SP				0.00				SP	SPARE	20	22
23	20	SPARE	SP					0.00			SP	SPARE	20	24
25	20	SPARE	SP			0.58			2#12, #12G, 3/4"C	0.58	E	#10_WATER FOUNTAIN	20	26
27	20	RECEPTION DESK RECEPTACLES	R	0.36	2#12, #12G, 3/4"C		0.72		2#12, #12G, 3/4"C	0.36	SP	MOP SINK AREA RECEPTACLE	20	28
29	20	TV OUTLET	R	0.18	2#12, #12G, 3/4"C			1.38	2#12, #12G, 3/4"C	1.20	R	SHOW WINDOW RECEPTACLE	20	30
31	20	GOOSENECK LIGHTS	L	0.80	2#12, #12G, 3/4"C	2.00			2#12, #12G, 3/4"C	1.20	R	SHOW WINDOW RECEPTACLE	20	32
33	20	AHU-2(E)	H	1.92	EXISTING		2.64		2#12, #12G, 3/4"C	0.72	R	FOH AREA RECEPTACLES	20	34
35	20	GFI ROOF	R	0.18	EXISTING			1.18	EXISTING	1.00	R	VERIZON BOX	20	36
37	20	SPARE				0.57			2#12, #12G, 3/4"C	0.57	L	LIGHTING IN LOBBY AREA & RESTROOM	20	38
39	20	SPARE						0.18	2#12, #12G, 3/4"C	0.18	R	RESTROOM RECEPTACLE	20	40
41	20	SPACE	SP					0.00			SP	SPACE	20	42
TOTAL CONNECTED LOAD (KVA)						7.74	5.58	5.59						

**ELECTRICAL PANEL SCHEDULE GENERAL NOTES:**

- ALL ARE EXISTING BREAKERS UNLESS OTHERWISE SPECIFIED.
- ALL CIRCUITING SHOWN IS FOR REFERENCE PURPOSE ONLY. E.C. SHALL VERIFY CIRCUITING OF THE EXISTING DEVICES IN FIELD AND INFORM ENGINEER FOR ANY DISCREPANCIES.
- ELECTRICAL CONTRACTOR TO VERIFY THE EXACT PANEL SIZES AND INCOMING FEEDER SIZE.
- ELECTRICAL CONTRACTOR SHALL VERIFY EXACT CIRCUIT NUMBER & BREAKER SIZE OF EXISTING DEVICES IN FIELD.
- E.C. SHALL PROVIDE NEW CIRCUIT BREAKERS IN PLACE OF EXISTING CIRCUIT BREAKERS WHEREVER NECESSARY TO BE IN LINE WITH THE PANEL SCHEDULE.
- E.C. SHALL VERIFY THE EXISTING EQUIPMENT LOAD & RATINGS IN FIELD AND ACCORDINGLY CONSIDER THE ELECTRICAL LOAD IN PANEL BOARD SCHEDULE.
- E.C. SHALL COORDINATE WITH OWNER FOR THE EXISTING TO REMAIN EQUIPMENTS WHOSE ELECTRICAL CONNECTIONS NEED TO BE MAINTAINED.
- E.C. SHALL VERIFY THE EXISTING BREAKER RATING AND SIZES IN FIELD AND ACCORDINGLY UPDATE THE PANEL SCHEDULE TO MATCH THE EQUIPMENT REQUIREMENTS.

**1 ELECTRICAL PANEL SCHEDULE**

NTS

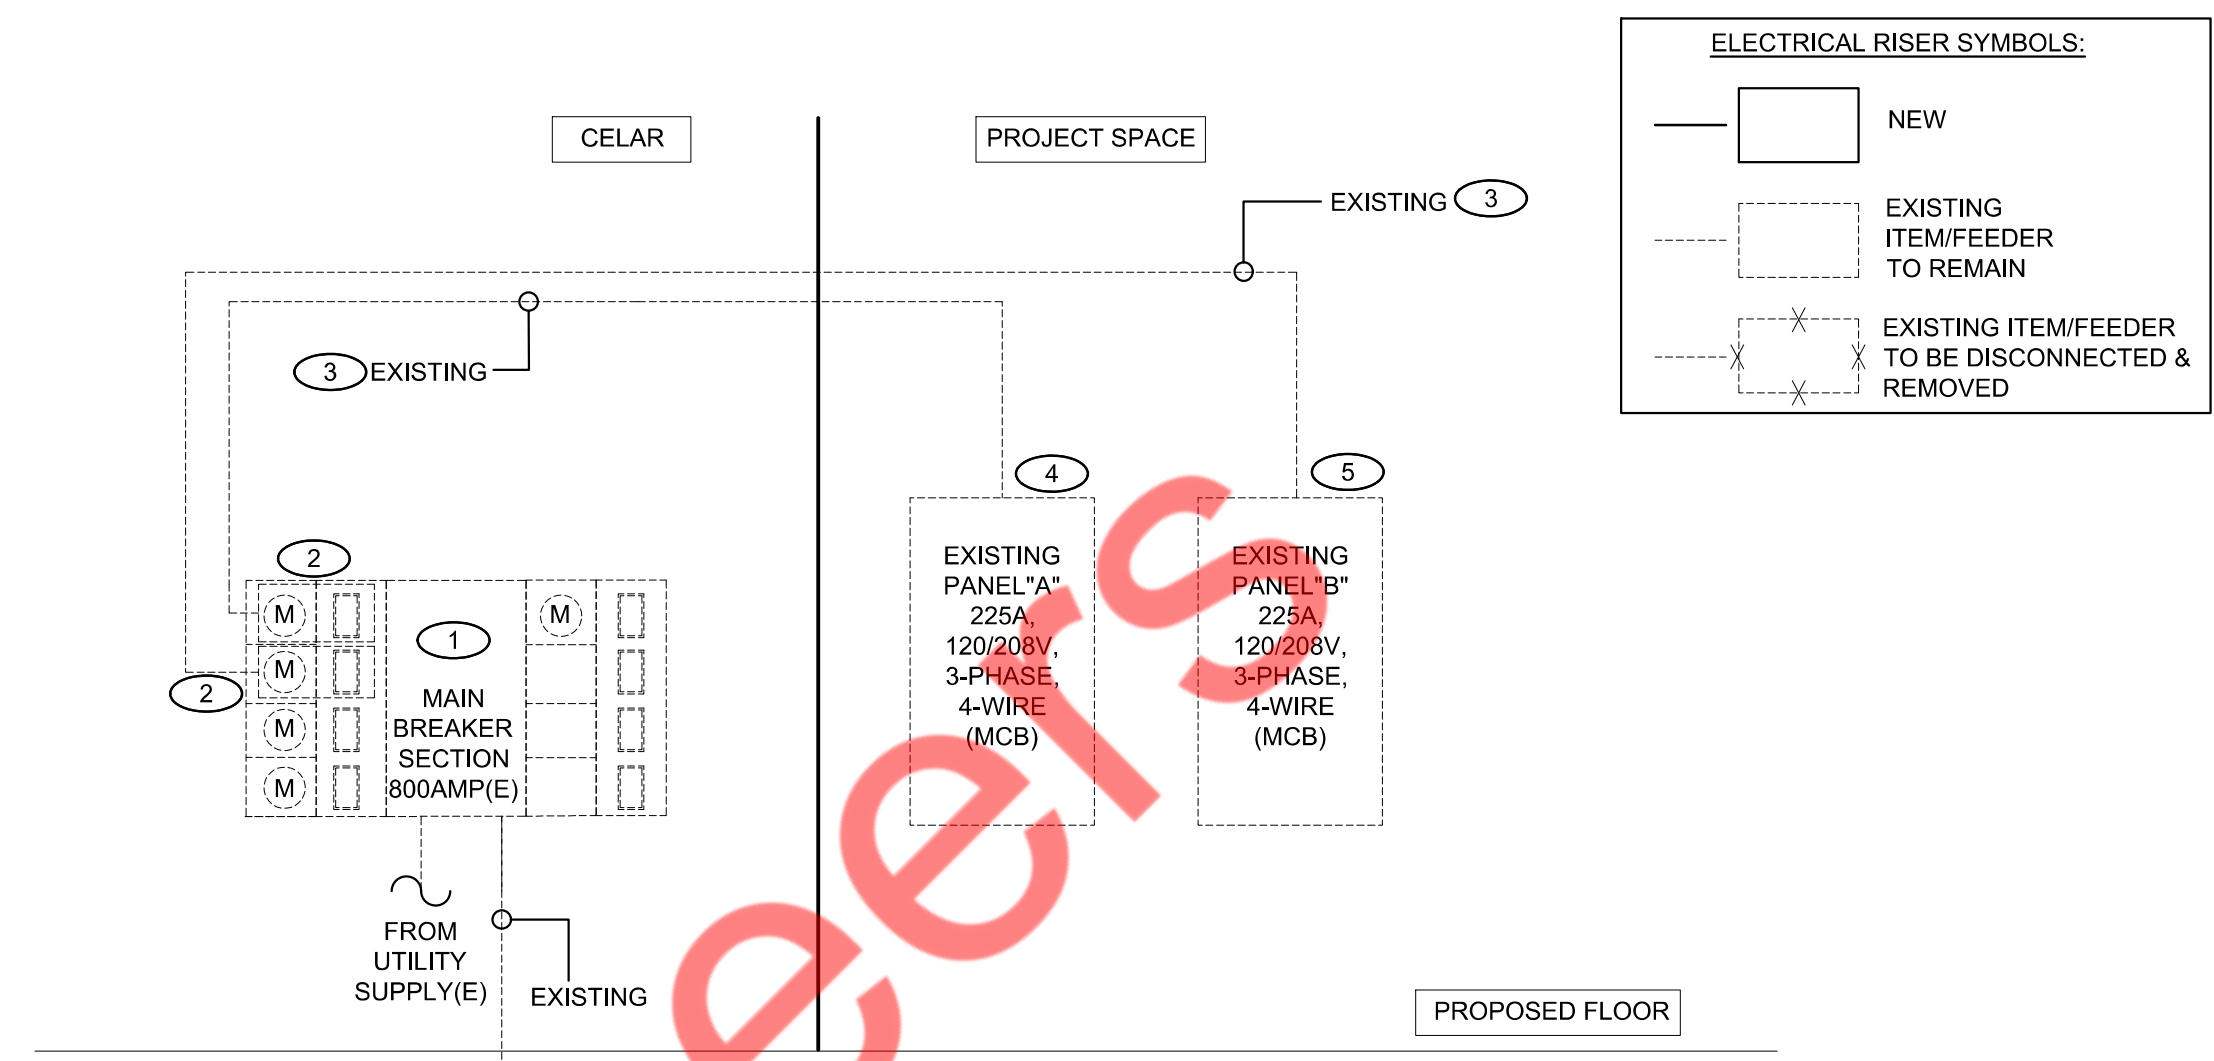

**ELECTRICAL RISER GENERAL NOTES:**

- E.C. SHALL VERIFY THE INCOMING SERVICE AMPERAGE, VOLTAGE, NUMBER OF PHASES, WIRE SIZE AND DISTRIBUTION IN FIELD.
- E.C. TO COORDINATE FAULT CURRENT (ISC) RATING WITH UTILITY COMPANY AND AHJ PRIOR TO COMMENCING ANY WORK.
- E.C. SHALL VERIFY THE EXACT POWER DISTRIBUTION & INCOMING CONNECTION TO ALL PANELS IN FIELD. INFORM ENGINEER FOR ANY DISCREPANCY FOUND.

**Ⓜ ELECTRICAL RISER KEYED NOTES:**

- EXISTING #2 200A, 120/208V, 3-PHASE ELECTRICAL SERVICE FROM EXISTING METERING BANK FOR THE PROJECT SPACE SHALL REMAIN. E.C. SHALL GET INFORMATION ABOUT THE EXISTING POWER DISTRIBUTION PRIOR TO COMMENCING ANY WORK AND INFORM ENGINEER ON RECORD FOR ANY DISCREPANCIES BASE BID ACCORDINGLY.
- EXISTING 200A 120/208V, 3-PHASE, 4-WIRE DISCONNECT SWITCH & METER FOR PROJECT SPACE SHALL REMAIN. E.C. TO VERIFY THE RATING, SIZE AND OPERABLE CONDITION OF EXISTING METER AND DISCONNECT SWITCH IN FIELD. REPLACE IF FOUND INOPERABLE. BASE BID ACCORDINGLY.
- EXISTING FEEDER/CONNECTION SHALL REMAIN. E.C. TO VERIFY THE RATING, SIZE AND OPERABLE CONDITION OF EXISTING FEEDER/CONNECTION IN FIELD. REPLACE IF FOUND INOPERABLE. BASE BID ACCORDINGLY.
- EXISTING 225A(MCB), 120/208V, 3-PHASE, 4-WIRE ELECTRICAL PANEL "A"(PANEL NAME SHOULD VERIFIED IN FIELD) TO REMAIN. E.C. TO FIELD VERIFY THE EXACT SIZE, LOCATION & OPERABLE CONDITION OF THE PANEL, REPLACE IF INOPERABLE. BASE BID ACCORDINGLY.
- EXISTING 225A(MCB), 120/208V, 3-PHASE, 4-WIRE ELECTRICAL PANEL "B" (PANEL NAME SHOULD VERIFIED IN FIELD) TO REMAIN. E.C. TO FIELD VERIFY THE EXACT SIZE, LOCATION & OPERABLE CONDITION OF THE PANEL, REPLACE IF INOPERABLE. BASE BID ACCORDINGLY.

**2 ELECTRICAL RISER DIAGRAM**

NTS

**PROJECT INFORMATION:**

**KIDSUNITED**

**DRAWING TITLE:**

**ELECTRICAL PANEL SCHEDULE AND RISER DIAGRAM**

**DRAWING NO.:**

**E-4.0**

**PLUMBING SYMBOLS LIST**

— — — — —	COLD WATER PIPING
— — — — —	HOT WATER PIPING
— · — · — ·	HOT WATER RETURN PIPING
— SAN —	SANITARY PIPING
— — — — —	VENT PIPING
— O —	P-TRAP
— O —	PIPE UP
— O —	PIPE DROP
— II —	PLUGGED OUTLET/CLEANOUT
⊠	FLOOR DRAIN
⊥	SHUT-OFF VALVE
∇	ANGLE VALVE
⊗	BALANCING VALVE
⊕	POINT OF NEW CONNECTION

**PLUMBING ABBREVIATIONS**

CW	CLEANOUT
CO	COLD WATER
HW	HOT WATER
HWR	HOT WATER RETURN
FW	FILTERED WATER
SAN	SANITARY
V	VENT
W	WASTE
LAV	LAVATORY
WC	WATER CLOSET
TYP.	TYPICAL
DN	DOWN
EXIST./EX.	EXISTING
FD	FLOOR DRAIN
GC	GENERAL CONTRACTOR

**PLUMBING DRAWING LIST**

- P-0.1 PLUMBING NOTES, SYMBOLS, ABBREVIATIONS AND SPECIFICATIONS
- P-0.2 PLUMBING SPECIFICATIONS
- P-1.0 PLUMBING WATER PLAN AND RISER
- P-2.0 PLUMBING SANITARY PLAN AND RISER
- P-3.0 PLUMBING DETAILS
- P-4.0 PLUMBING SCHEDULE

**BUILDING DEPARTMENT PLUMBING NOTES**

1. ALL PLUMBING SYSTEMS (SANITARY, WASTE, VENT, WATER) AND ASSOCIATED EQUIPMENT SHALL BE INSTALLED, OPERATED AND MAINTAINED IN ACCORDANCE WITH THE REQUIREMENTS OF 2021 NEW JERSEY PLUMBING CODE (NSPC 2021).
2. INSTALLATION OF UNDERGROUND PIPING SHALL BE IN ACCORDANCE WITH THE REQUIREMENTS OF SECTION 2.6.6.
3. PROTECTION OF PIPING AND PLUMBING SYSTEM COMPONENTS AS PER SECTION 2.9
4. TRENCHING, EXCAVATION AND BACKFILL AS PER SECTION PC 2.6.
5. MATERIALS USED IN PLUMBING SYSTEMS SHALL BE IN ACCORDANCE WITH THE REQUIREMENTS CHAPTER 3.
6. EQUIPMENT CONNECTIONS AND JOINING OF PIPING SHALL BE IN ACCORDANCE WITH THE REQUIREMENTS OF CHAPTER 4
7. DEEP SEAL TRAPS FOR FLOOR DRAINS AND CLEAN-OUTS SHALL BE INSTALLED IN ACCORDANCE WITH THE REQUIREMENTS OF CHAPTER 5.
8. DRAINAGE PIPE CLEANOUTS AS PER SECTION 5.4.
9. VERTICAL AND HORIZONTAL PIPING SHALL BE SUPPORTED IN ACCORDANCE WITH THE REQUIREMENTS OF SECTION 8.2 AND 8.3.
10. WATER SUPPLY SYSTEMS SHALL BE INSTALLED AND MAINTAINED IN ACCORDANCE WITH THE REQUIREMENTS OF CHAPTER 10.
11. THE SANITARY DRAINAGE SYSTEM SHALL BE SIZED AND INSTALLED IN ACCORDANCE WITH THE REQUIREMENTS OF CHAPTER 11.
12. VENT PIPING FOR THE SANITARY DRAINAGE SYSTEM SHALL BE INSTALLED IN ACCORDANCE WITH THE REQUIREMENTS OF CHAPTER 12.
13. INSPECTION AND TESTING OF PLUMBING SYSTEMS SHALL BE IN ACCORDANCE WITH CHAPTER 15.

**PLUMBING SPECIFICATIONS**

1. BASIC PLUMBING REQUIREMENTS, MATERIALS AND METHODS
  - 1.01 SCOPE
    - A. PROVIDE ALL MATERIAL, TOOLS, SUPERVISION AND LABOR INCLUDING ALL MISCELLANEOUS AND INCIDENTAL ITEMS REQUIRED FOR COMPLETE AND OPERABLE PLUMBING INSTALLATIONS AS SHOWN OR DESCRIBED ON THE DRAWINGS AND IN THESE SPECIFICATIONS.
    - B. THE CONTRACTOR SHALL BE RESPONSIBLE FOR THE PROTECTION OF ALL NEW CONDITIONS AND MATERIALS WITHIN THE CONSTRUCTION AREA. ANY DAMAGE CAUSED BY THE CONTRACTOR SHALL BE REPAIRED TO THE OWNER'S SATISFACTION.
    - C. OBTAIN ALL PERMITS, PAY ALL PERMIT FEES AND SCHEDULE ALL REQUIRED INSPECTIONS. COPIES OF ALL PERMITS AND INSPECTION CERTIFICATES SHALL BE FORWARDED TO THE OWNER FOR RECORD.
    - D. THE GENERAL CONDITIONS OF THE CONTRACT AND ALL DIVISION 1 REQUIREMENTS APPLY TO THE WORK OF THIS SECTION.
    - E. THE CONTRACTOR SHALL VISIT THE SITE PRIOR TO SUBMITTING BID TO DETERMINE CONDITIONS AND THE EXTENT OF THE WORK. BY COMMENCING WORK, THE CONTRACTOR ACKNOWLEDGES HIS CONFIRMATION OF ALL CONDITIONS AS ACCEPTABLE WITH REFERENCE TO HIS CONTRACT, SCOPE OF WORK AND BID PRICE SUCH THAT NO ADDITIONAL COMPENSATION SHALL BE FORTHCOMING FOR UNFORESEEN EXISTING CONDITIONS.
    - F. IN ALL AREAS SUBJECT TO FREEZING CONDITIONS, THE CONTRACTOR SHALL PROVIDE FREEZE PROTECTION FOR ALL DOMESTIC WATER PIPING INSTALLED UNDER HIS CONTRACT.
    - G. ALL ELECTRICAL REQUIREMENTS SHALL BE COORDINATED WITH THE CONTRACTOR FOR ELECTRICAL WORK. THIS CONTRACTOR IS RESPONSIBLE FOR ALL LOW VOLTAGE WIRING FOR EQUIPMENT INSTALLED UNDER HIS CONTRACT. THE CONTRACTOR FOR ELECTRICAL WORK IS RESPONSIBLE FOR LINE VOLTAGE POWER WIRING ONLY.
    - H. COLOR AND FINISH SELECTIONS FOR ALL MATERIALS, INCLUDING PAINTING OF PIPING, SHALL BE AS DIRECTED AND/OR APPROVED BY THE ARCHITECT.
    - I. MINOR DETAILS NOT SHOWN OR SPECIFIED, BUT NECESSARY FOR THE PROPER AND ACCEPTABLE CONSTRUCTION, INSTALLATION OR OPERATION OF ANY PART OF THE WORK AS DETERMINED BY THE ENGINEER SHALL BE INCLUDED AS IF SPECIFIED OR INDICATED ON THE DRAWINGS.
    - J. THIS CONTRACTOR SHALL BE RESPONSIBLE FOR COORDINATING ALL REQUIREMENTS FOR THE INSTALLATION, CONNECTION, EXTENSION OR MODIFICATION TO ALL UTILITY SERVICES WITH RESPECTIVE PROVIDERS INCLUDING PAYMENT OF ALL ASSOCIATED FEES.
    - K. THE CONTRACTOR IS RESPONSIBLE FOR ALL PAINTING ASSOCIATED WITH CUTTING AND PATCHING. ALL PAINTING IN AREAS WITH COMPLETE FINISH RENOVATIONS SHALL BE PROVIDED BY THE GENERAL CONTRACTOR.

**1.02 SUBMITTALS**

- A. SUBMITTAL REQUIREMENTS SHALL BE COORDINATED WITH THE ARCHITECT AND AUTHORITIES HAVING JURISDICTION. UNLESS OTHERWISE DIRECTED, CONTRACTOR SHALL PROVIDE SUBMITTALS AS LISTED BELOW.
  1. PIPE AND FITTINGS
  2. VALVES
  3. HANGERS AND SUPPORTS
  4. PLUMBING PIPING LAYOUT
  5. TESTS
  6. PLUMBING FIXTURES
  7. FLOOR DRAINS
  8. MIXING VALVES
  9. ALL SCHEDULED PLUMBING EQUIPMENT
  10. WATER HEATER AND ACCESSORIES
- B. SUBMITTALS FROM SUPPLIERS OR MANUFACTURERS WHICH DO NOT BEAR THE STAMP OF THE SUBMITTING CONTRACTOR INDICATING THAT THE CONTRACTOR HAS REVIEWED THE SUBMITTAL FOR CONFORMANCE WITH THE PROJECT REQUIREMENTS WILL BE RETURNED REJECTED.
- C. THE ENGINEER'S REVIEW OF SUBMITTALS IS A COURTESY WHICH DOES NOT RELIEVE THE CONTRACTOR FROM CONFORMING WITH THE CONSTRUCTION DOCUMENTS, REGARDLESS OF THE ACTION INDICATED BY THE SHOP DRAWINGS STAMP.
- D. REVIEW OF SHOP DRAWINGS BY THE ENGINEER SHALL BE LIMITED TO THE INITIAL REVIEW, AND A SECOND REVIEW OF ANY REQUIRED RESUBMITTED DATA. IF THE ENGINEER IS REQUIRED TO REVIEW SHOP DRAWINGS FOR A THIRD (OR MORE) SUBMISSION OF THE SAME ITEM, THE CONTRACTOR SHALL BE LIABLE FOR COMPENSATING THE ENGINEER FOR THESE SUBSEQUENT REVIEWS AS PER THE ENGINEER'S CURRENT HOURLY RATE SCHEDULE.
- E. SUBMIT PROOF OF APPROVAL AND/OR CONFIRMATION OF SATISFACTORY TEST RESULTS TO THE OWNER AND THE ARCHITECT.
- F. SUBMIT TO THE OWNER'S MAINTENANCE PERSONNEL OPERATION AND MAINTENANCE DATA FOR ALL SYSTEM COMPONENTS, SERVICING REQUIREMENTS, INSPECTION DATA, REPLACEMENT PART NUMBERS AND AVAILABILITY AND CONTACT INFORMATION FOR SERVICE/SUPPLY COMPANY.
- G. FOR ALL BELOW GRADE PIPING WHERE ACTUAL INSTALLATION DEVIATES FROM CONSTRUCTION DRAWINGS, THE CONTRACTOR SHALL PROVIDE AS-BUILT DRAWINGS INDICATING BELOW GRADE PIPE LOCATIONS DIMENSIONED TO NEAREST COLUMN LINES.
- H. RECORD AS-BUILT DRAWINGS SHALL BE SUPPLIED TO THE OWNER/TENANT AFTER COMPLETION OF THE WORK SHOWING ANY ALTERATIONS, ADDITIONS AND/OR DELETIONS TO THE SYSTEM(S) INSTALLED.

**1.03 SUBSTITUTIONS**

- A. ALL EQUIPMENT SHALL BE PRODUCTS OF THE SPECIFIED MANUFACTURER OR MANUFACTURERS. ALL BIDS SHALL BE BASED ON THE SPECIFIED MANUFACTURER OR MANUFACTURERS EQUIPMENT. FOR SUBSTITUTIONS OF OTHER MANUFACTURER'S EQUIPMENT TO BE CONSIDERED, THE SUBSTITUTION MUST BE INDICATED PRIOR TO BIDDING WITH THE REASON FOR THE PROPOSED SUBSTITUTION IDENTIFIED, AND THE PROPOSED CREDIT TO THE OWNER INDICATED. THE ENGINEER SHALL DETERMINE THE ACCEPTABILITY OF ANY PROPOSED SUBSTITUTIONS.
  - B. THE CONTRACTOR ASSUMES ALL RESPONSIBILITY FOR COORDINATING THE WORK OF OTHER TRADES WHICH MAY BE AFFECTED BY SUBSTITUTIONS, INCLUDING ALL RELATED COSTS.
- 1.04 DEFINITIONS**
- A. FURNISH: TO PURCHASE, PROCURE, ACQUIRE AND DELIVER, COMPLETE WITH RELATED ACCESSORIES.
  - B. INSTALL: TO ERRECT, MOUNT AND CONNECT, COMPLETE WITH RELATED ACCESSORIES.
  - C. PROVIDE: TO FURNISH AND INSTALL.
  - D. PLUMBING CONTRACTOR, THE CONTRACTOR, THIS CONTRACTOR: THE CONTRACTOR FOR PLUMBING WORK WHICH IS SPECIFIED HEREIN AND SHOWN ON THESE DRAWINGS.
  - E. REFER TO THE NATIONAL STANDARD PLUMBING CODE 2021 FOR ADDITIONAL DEFINITIONS.

**1.05 DRAWINGS**

- A. THE DRAWINGS ARE DIAGRAMMATIC AND ARE INTENDED TO ILLUSTRATE THE GENERAL ARRANGEMENT AND ROUTING OF PIPING AND GENERAL LOCATIONS OF EQUIPMENT. PRECISE LOCATIONS OF EQUIPMENT, RISERS AND STACKS, AND ROUTING AND ELEVATION OF ALL PIPING SYSTEMS SHALL BE COORDINATED IN THE FIELD WITH THE ARCHITECT, ARCHITECTURAL DRAWINGS, THE WORK OF OTHER TRADES, EXISTING AND NEW BUILDING CONDITIONS AND/OR THE PREFERENCES OF THE OWNER/TENANT AS CONSTRUCTION PROCEEDS. ALL PIPING SHALL BE INSTALLED CONCEALED IN FINISHED SPACES, UNLESS NOTED OTHERWISE.
- B. PROVIDE ALL NECESSARY INCIDENTAL MATERIALS AND ACCESSORIES REQUIRED TO MAKE THE WORK COMPLETE IN ALL RESPECTS, EVEN IF NOT PARTICULARLY SHOWN OR SPECIFIED.
- C. REFER TO PLUMBING EQUIPMENT/FIXTURE SCHEDULE ON THE DRAWINGS FOR ALL FIXTURE AND EQUIPMENT SPECIFICATIONS.
- D. REFER TO FIXTURE CONNECTION SIZE SCHEDULE FOR ALL FIXTURE ROUGHING SIZE REQUIREMENTS.
- E. VERIFY ALL INDICATED CONDITIONS BEFORE STARTING WORK AND REPORT ANY DISCREPANCIES. THE DRAWINGS REFLECT CONDITIONS WHICH CAN BE REASONABLY INTERPRETED FROM THE EXISTING VISIBLE CONDITIONS OR FROM DRAWINGS AND INFORMATION FURNISHED BY THE OWNER.
- F. LOCATE ALL FIXTURES AND EQUIPMENT AS PER THE FINAL ARCHITECTURAL DRAWINGS.

**1.06 PRODUCTS**

- A. SANITARY AND VENT PIPING:
  1. ABOVE GRADE PIPING SHALL BE HUBLESS CAST IRON PIPE WITH STAINLESS STEEL COUPLINGS AND ELASTOMERIC GASKETS WITH A MINIMUM NO. OF BANDS PER COUPLING AS PER CISPI 310-12.
  2. SLOPE OF DRAINAGE SYSTEM SHALL BE 1/8" PER FOOT OF RUN FOR PIPE OVER 3" (I.D.) AND 1/4" PER FOOT OF RUN FOR PIPE 3" AND SMALLER (I.D.). VENT PIPING SHALL BE PITCHED TO DRAIN.
  3. ALL CAST IRON SOIL PIPE AND FITTINGS SHALL BE MARKED WITH THE COLLECTIVE TRADEMARK OF THE CAST IRON SOIL PIPE INSTITUTE (CISPI) AND BE LISTED BY NSF INTERNATIONAL.
- B. DOMESTIC WATER PIPING:
  1. ABOVE GRADE WATER PIPING SHALL BE TYPE 'L' HARD-DRAWN COPPER TUBE.
  2. FITTINGS IN DOMESTIC WATER PIPING SHALL BE WROUGHT COPPER OR CAST BRASS.
  3. JOINTS SHALL BE MADE WITH LEAD-FREE SOLDER.
  4. THE ENTIRE DOMESTIC WATER DISTRIBUTION SYSTEM SHALL BE INSULATED INCLUDING ALL VALVES, FITTINGS, ETC.
  5. COMPLY WITH NSF 61 FOR MATERIALS FOR WATER-SERVICE PIPING AND SPECIALTIES FOR DOMESTIC WATER.
  6. ALL DOMESTIC WATER PIPING ABOVE GRADE SHALL BE INSULATED WITH FIRE RETARDANT, FACTORY-APPLIED JACKET. PROVIDE COLD WATER PIPING WITH FACTORY-APPLIED VAPOR BARRIER. INSULATION REQUIREMENT SHOULD COMPLY WITH ASHRAE 90.1 2019 SECTION ENERGY CONSERVATION CODE 7.4.3 BELOW TABLE.
 

FLUID OPERATING TEMPERATURE RANGE AND USAGE (°F)	MINIMUM PIPE INSULATION THICKNESS		NOMINAL PIPE OR TUBE SIZE (INCHES)				
	CONDUCTIVITY BTU-IN./ (H·FT <sup>2</sup> ·°F)	MEAN RATING TEMPERATURE, °F	<1	1 to < 1 1/2	1 1/2 to < 4	4 to < 8	≥8
141-200	0.25-0.29	125	1.5	1.5	2	2	2
105-140	0.21-0.28	100	1.0	1.0	1.5	1.5	1.5
40-60	0.21-0.27	75	0.5	0.5	1.0	1.0	1.0
  7. AS PER ASHRAE 90.1 2019 SECTION 7.4.4.1, TEMPERATURE CONTROL SHALL BE PROVIDED THAT ALLOW FOR STORAGE TEMPERATURE ADJUSTMENT FROM 120° OR LOWER TO A MAXIMUM TEMPERATURE COMPATIBLE WITH THE INTENDED USE.
  8. AS PER ASHRAE 90.1 2019 SECTION 7.4.4.2, SYSTEM DESIGNED TO MAINTAIN USAGE TEMPERATURE IN HOT WATER PIPES, SUCH AS RECIRCULATING HOT WATER SYSTEMS OR HEAT TRAPS, SHALL BE EQUIPPED WITH AUTOMATIC TIME SWITCHES OR OTHER CONTROLS THAT CAN BE USED TO SWITCH THE USAGE TEMPERATURE MAINTENANCE SYSTEM DURING EXTENDED PERIOD WHEN HOT WATER IS NOT REQUIRED.
  9. AS PER ASHRAE 90.1 2019 SECTION 7.4.4.3, TEMPERATURE CONTROLLING MEANS SHALL BE PROVIDED TO LIMIT THE MAXIMUM TEMPERATURE OF WATER DELIVERED FROM LAVATORY FAUCETS IN PUBLIC FACILITY RESTROOMS TO 110°F.
  10. SEAL ALL JOINTS BETWEEN SEGMENTS OF INSULATION.
  11. PROVIDE SHIELDS BETWEEN HANGERS AND INSULATION.
- C. 1.1 ELECTRIC WATER HEATER(WH-1)
  1. TANKS SHALL 20 GALLON CAPACITY AND SHALL HAVE 140 PSI WORKING PRESSURE AND BE EQUIPPED WITH EXTRUDED HIGH DENSITY ANODE.
  2. ALL INTERNAL SURFACES OF THE HEATER(S) EXPOSED TO WATER SHALL BE GLASS-LINED WITH AN ALKALINE BORO SILICATE COMPOSITION THAT HAS BEEN FUSED-TO-STEEL BY FIRING AT A TEMPERATURE RANGE OF 1400°F TO 1600°F.
  3. ELECTRIC HEATING ELEMENTS SHALL BE LOW WATT DENSITY GOLDENROD 1" SCREW-IN TYPE.
  4. EACH ELEMENT SHALL BE CONTROLLED BY AN INDIVIDUALLY MOUNTED THERMOSTAT AND HIGH TEMPERATURE CUT-OFF SWITCH. ALL INTERNAL CIRCUITS SHALL BE FUSED. THE OUTER JACKET SHALL BE OF BAKED ENAMEL FINISH AND SHALL BE PROVIDED WITH FULL SIZE CONTROL COMPARTMENT FOR PERFORMANCE OF SERVICE AND MAINTENANCE THROUGH HINGED FRONT PANEL AND SHALL ENCLOSE THE TANK WITH FOAM INSULATION. ELECTRICAL JUNCTION BOX WITH HEAVY DUTY TERMINAL BLOCK SHALL BE PROVIDED. THE DRAIN VALVE SHALL BE LOCATED IN THE FRONT FOR EASE OF SERVICING.
- D. HOT WATER RE-CIRCULATING PUMP
  1. IN-LINE PUMP: SINGLE STAGE VOLUTE TYPE PUMP SHALL BE MADE OF CAST IRON OR FORGED LEAD-FREE BRONZE IMPELLER.
  2. THE PUMP SHALL HAVE A GROUND AND POLISHED STEEL SHAFT WITH A HARDENED INTEGRAL THRUST COLLAR. THE SHAFT SHALL BE SUPPORTED BY TWO HORIZONTAL SLEEVE BEARINGS DESIGNED TO CIRCULATE OIL. THE PUMPS ARE TO BE EQUIPPED WITH A MECHANICAL SEAL WITH CARBON SEAL FACE ROTATING AGAINST CERAMIC SEAT. THE MOTOR SHALL BE NON-OVERLOADING AT ANY POINT ON PUMP CURVE.
  3. DIRECT CONNECT PUMP TO ELECTRIC MOTOR WITH FLEXIBLE COUPLING. THE MOTOR SHALL BE OF THE DRIP-PROOF, SLEEVE- BEARING, QUIET OPERATING, RUBBER-MOUNTED CONSTRUCTION. EQUIPMENT MOTOR WITH BUILT-IN THERMAL OVERLOAD PROTECTION.
  4. INSTALL IN-LINE CIRCULATING PUMPS BETWEEN PIPE FLANGES IN PIPING SYSTEMS. INSTALL OVERHEAD PIPE SUPPORTS, BOTH SIDES OF IN-LINE PUMPS, INSTALLED IN HORIZONTAL PIPING RUNS.

**E. HANGERS AND SUPPORTS:**

1. HANGERS SHALL BE STANDARD STEEL, MALLEABLE OR WROUGHT IRON, AS MANUFACTURED BY GRINNELL OR APPROVED EQUAL, SUITABLE FOR THE TYPE OF CONSTRUCTION. PIPING SHALL NOT BE HUNG FROM OTHER PIPE.
2. SECTIONS OF INDIVIDUAL PIPE RUNS SHALL BE SUPPORTED BY CLEVIS HANGERS.
3. ALL EQUIPMENT SHALL BE PROVIDED WITH APPROVED SUPPORTS.
4. PROVIDE SEISMIC RESTRAINTS IN ACCORDANCE WITH ALL APPLICABLE FEDERAL, STATE AND LOCAL CODES AND STANDARDS AND THE REQUIREMENTS OF AUTHORITIES HAVING JURISDICTION.
5. UNLESS OTHERWISE INDICATED OR REQUIRED BY AUTHORITIES HAVING JURISDICTION, THE FOLLOWING SHALL BE PROVIDED WITH SEISMIC RESTRAINTS AS REQUIRED BY THE BOCA NATIONAL BUILDING CODE, SECTION 1610.6.4: ALL EQUIPMENT AND MACHINERY, ALL NEW PIPING 2-1/2" AND LARGER (1-1/4" AND LARGER IN BOILER/MECHANICAL ROOMS) WITH HANGERS GREATER THAN 12" IN LENGTH FROM THE TOP OF PIPE TO THE STRUCTURE.
6. SUPPORTS SHALL BE PROVIDED IN STRICT ACCORDANCE WITH THE RECOMMENDATIONS OF THE PIPING MANUFACTURER.

**F. VALVES:**

1. PROVIDE GATE VALVES, BUTTERFLY OR BALL VALVES FOR SHUT-OFF DUTY ON MAIN AND BRANCH SUPPLY LINES. FOR ALL PIPE RUNS 2" AND SMALLER, PROVIDE BALL FOR ALL PIPE RUNS LARGER THAN 2" AND SMALLER THAN 4". PROVIDE GATE VALVES. PIPING 4" AND LARGER, PROVIDE BUTTERFLY VALVES FOR SHUT-OFF DUTY.
2. ALL FIXTURES WITH THE EXCEPTION OF FLUSHMETER-EQUIPPED WATER CLOSETS AND URINALS SHALL HAVE STOP VALVES TO CONTROL SUPPLY TO THE FIXTURE. WHERE SUPPLIES ARE EXPOSED PROVIDE CHROME-PLATED STOPS WITH CHROME-PLATED ESCUTCHEONS ON PIPING PENETRATIONS.
3. ALL PLUMBING FIXTURES AND EQUIPMENT TO HAVE SHUT-OFF VALVES ON SUPPLY LINES.
4. ALL BRANCH LINES TO HAVE SHUT-OFF VALVES.
5. ALL VALVES SHALL BE ACCESSIBLE. PROVIDE ACCESS DOORS WHERE REQUIRED FOR VALVE ACCESS.
6. PROVIDE GLOBE VALVES FOR THROTTLING/BALANCING OF THE HOT WATER CIRCULATING SYSTEM.

**G. SLEEVES AND ESCUTCHEONS:**

1. SLEEVES THROUGH STRUCTURAL CONCRETE MEMBERS AND SLEEVES FOR WALLS BELOW GRADE AND FLOORS ON GRADE SHALL BE STANDARD WEIGHT GALVANIZED SCHEDULE 40 STEEL PIPE. SLEEVES THROUGH OTHER THAN STRUCTURAL COMPONENTS OF THE BUILDING SHALL BE 20 GAGE GALVANIZED SHEET METAL WITH LOCK SEAM JOINTS. USG THERMAFIBER SAFING INSULATION SHALL BE INSTALLED BETWEEN PIPE AND SLEEVE.
2. PIPE ESCUTCHEON PLATES SHALL BE INSTALLED WHERE EXPOSED PIPING PASSES THROUGH WALLS, CEILINGS, AND FLOORS AND SHALL BE MINIMUM 20 GAGE STEEL. PROVIDE CHROME PLATED ESCUTCHEON PLATES IN FINISHED AREAS.
- H. DRAINAGE ACCESSORIES
  1. GENERAL:
    - a. INSTALL THE WORK OF THIS SECTION IN ACCORDANCE WITH THE MANUFACTURERS' PRINTED INSTALLATION INSTRUCTIONS, UNLESS OTHERWISE SPECIFIED.
    - b. SECURE EXTERNAL COMPONENTS IN PLACE WITH VANDAL RESISTANT FASTENERS OR DEVICES WHICH CANNOT BE REMOVED WITHOUT SPECIAL TOOLS.
  - I. INSTALL PIPING TO CONSERVE BUILDING SPACE. DO NOT INTERFERE WITH USE OF BUILDING SPACE AND THE WORK OF OTHER TRADES. ALL PIPING RUN IN CEILING SHALL BE INSTALLED TIGHT TO THE STRUCTURE ABOVE.
  - J. INSTALL PIPING TO ALLOW FOR EXPANSION AND CONTRACTION WITHOUT STRESSING PIPE, JOINTS OR CONNECTED EQUIPMENT. PROVIDE PIPE ANCHORS, GUIDES AND EXPANSION JOINTS OR LOOPS IN ALL HOT WATER AND HOT WATER CIRCULATING MAIN SUPPLY PIPING AND SEGMENTS OF SUCH PIPE THAT EXCEED 30'-0" IN LENGTH.
  - K. IN ALL AREAS WITH FINISHED SURFACES, SYSTEM PIPING AND COMPONENTS SHALL BE CONCEALED ABOVE OR WITHIN FINISHED SURFACES.
  - L. REDUCTIONS IN PIPE SIZES SHALL BE MADE WITH ONE-PIECE REDUCING FITTINGS. BUSHINGS ARE NOT ACCEPTABLE. USE FLANGED FITTINGS AT THE BASE OF RISERS.
- M. VENT PENETRATIONS THROUGH THE ROOF SHALL BE FLASHED.

**PROJECT INFORMATION:**

**KIDSUNITED**

**DRAWING TITLE:**  
PLUMBING NOTES, SYMBOLS, ABBREVIATIONS AND SPECIFICATIONS

**DRAWING NO.:**  
**P-0.1**

- N. IF WATER PRESSURE EXCEEDS 80 PSI, A WATER PRESSURE REDUCING VALVE SHALL BE INSTALLED IN WATER PIPING AT CONNECTION TO MAIN.
- O. PROVIDE DIELECTRIC FITTINGS BETWEEN DISSIMILAR METALS.
- P. PIPE BACKFLOW PREVENTER DRAINS TO FLOOR DRAIN OR OTHER APPROVED INDIRECT WASTE SOURCE.
- Q. PROVIDE ACCESS DOORS/PANELS FOR SERVICE AND ACCESS TO ALL VALVES AND OTHER SYSTEM COMPONENTS ENCLOSED IN WALLS AND CEILINGS. ACCESS DOORS SHALL BE FURNISHED BY THIS CONTRACTOR, INSTALLED BY THE GENERAL CONTRACTOR.
- R. ALL FIXTURES REQUIRING VACUUM BREAKERS SHALL BE EQUIPPED WITH INTEGRAL VACUUM BREAKERS.
- S. ANY PENETRATIONS THROUGH FIRE RATED PARTITIONS, FLOORS, OR CEILINGS SHALL BE STEEL SLEEVED AND SEALED WITH 3M BRAND UL RATED FIRE BARRIER CAULK OR APPROVED EQUAL.
- T. WHEN THE WATER PIPING SYSTEM IS COMPLETE, THOROUGHLY FLUSH ALL DIRT, SEDIMENT, SOLDER, ETC., OUT OF THE SYSTEM, REMOVING ALL STRAINERS, VALVE STEM SEATS, ETC., REQUIRED TO ACCOMPLISH THE FLUSHING.
- U. AT ALL INDIRECT WASTE DRAINS, MAINTAIN AIR GAP AS REQUIRED BY CODE.
- V. INSTALL SLEEVES FOR ALL PIPES WHICH PASS THROUGH WALLS, FLOORS, AND CEILINGS. WHERE PIPES ARE TO BE INSULATED, THE SLEEVE SHALL BE LARGE ENOUGH TO ACCOMMODATE INSULATION. SLEEVES SHALL BE FLUSH WITH FINISHED SURFACES AT BOTH ENDS. ON FINISHED SURFACES IN EXPOSED AREAS PROVIDE ESCUTCHEONS COMPATIBLE WITH FINISH.
- W. PROVIDE WATER HAMMER ARRESTERS ON SUPPLY PIPING TO ALL FLUSHMETER VALVES AND QUICK-CLOSING VALVES.
- X. MAINTAIN ALL REQUIRED AND RECOMMENDED CLEARANCES FOR ALL PLUMBING SYSTEM COMPONENTS AND EQUIPMENT.

2. INSTALLATION

2.01 GENERAL

- A. ALL WORK WHICH REQUIRES DISRUPTION OF THE ROOFING SHALL BE DONE BY A CONTRACTOR CERTIFIED BY THE ROOFING MANUFACTURER AS REQUIRED TO MAINTAIN ANY EXISTING ROOF WARRANTIES.
- B. EXTERIOR INSTALLATIONS TO BE WEATHER PROOF IN ALL RESPECTS.
- C. EXTERIOR MATERIALS AND EQUIPMENT SHALL BE PAINTED TO PREVENT CORROSION, COLOR PER ARCHITECT.
- D. COORDINATE THE PLUMBING WORK WITH ALL OTHER AFFECTED WORK AND THE CONSTRUCTION SCHEDULE.
- E. REAM PIPE AND TUBE ENDS. REMOVE BURRS, BEVEL PLAIN AND FERROUS END PIPE.
- F. REMOVE SCALE AND FOREIGN MATERIAL, FROM INSIDE AND OUTSIDE, BEFORE ASSEMBLY.
- G. PREPARE PIPING CONNECTIONS TO EQUIPMENT WITH FLANGES AND UNIONS.
- H. COORDINATION WITH THE WORK OF OTHER TRADES IS REQUIRED. PROVIDE OFFSETS IN PIPING SYSTEMS OR MINOR DEVIATIONS TO THE INDICATED PIPE ROUTING IN ORDER TO COORDINATE THE PLUMBING WORK WITH THE WORK OF ALL OTHER TRADES AND THE GENERAL BUILDING CONDITIONS.
- I. NO DOMESTIC WATER PIPING SHALL BE INSTALLED IN UNHEATED SPACES.
- J. PRIOR TO DISCONNECTING AND CONNECTING NEW WORK TO EXISTING SYSTEMS, THE PLUMBING CONTRACTOR SHALL NOTIFY THE PROPERTY MANAGER AND OFFER A PROPOSED SCHEDULE OF WORK. ESB WILL AUTHORIZE CONNECTIONS AND COORDINATE NECESSARY SHUT DOWNS AND DRAIN DOWNS AS REQUIRED. SHUT DOWNS AND DRAIN DOWNS MAY BE PERFORMED BY THE PLUMBING CONTRACTOR ONLY AFTER RECEIVING ESB AUTHORIZATION, AND SHOULD BE PERFORMED UNDER SUPERVISION OF ESB PERSONNEL, THREE (3) DAYS ADVANCE NOTICE TO THE PROPERTY MANAGER IS REQUIRED.
- K. THE PLUMBING CONTRACTOR IS ADVISED THAT DUE TO THE NATURE OF THE OPERATIONS AND TENANT REQUIREMENTS, CONNECTIONS TO EXISTING SYSTEMS MAY HAVE TO BE MADE AFTER REGULAR WORKING HOURS. THE PROPERTY MANAGER WILL ADVISE THE PLUMBING CONTRACTOR OF THE TIME CONSTRAINTS UPON RECEIPT AND APPROVAL OF THE PLUMBING CONTRACTOR'S REQUEST FOR SHUT DOWN AND CONNECTION TO EXISTING SYSTEMS.
- L. WHEN CONNECTING TO EXISTING STACKS AND RISERS, PROVISION IS TO BE MADE FOR FUTURE CONNECTIONS BY PROVIDING CAPPED AND VALVED OUTLETS ON DOMESTIC WATER RISERS AND PLUGGED OUTLETS ON THE SANITARY AND VENT STACKS.

2.02 ABOVE GRADE

- a. INSTALL PLUMBING PIPING IN ACCORDANCE WITH RECOGNIZED INDUSTRY PRACTICES TO ENSURE THAT PIPING COMPLIES WITH REQUIREMENTS AND SERVES INTENDED PURPOSES.
- b. ROUTE PIPING IN AN ORDERLY MANNER, PLUMB AND PARALLEL TO BUILDING STRUCTURE, MAINTAIN GRADIENT, SLOPE PIPING AND ARRANGE SYSTEMS TO DRAIN. IN DOMESTIC WATER SYSTEMS, PROVIDE DRAIN VALVES AT MAIN SHUT-OFF VALVES AND ALL LOW POINTS IN PIPING.
- c. USE EXISTING CONNECTIONS AT MAINS WHERE AVAILABLE FOR NEW BRANCH PIPING. LOCATE ALL RISERS AND PIPING BEFORE CONSTRUCTION COMMENCES AND TAKE CARE NOT TO DAMAGE SAME. ANY DAMAGE OCCURRING TO THE EXISTING PIPING WILL BE THE SOLE RESPONSIBILITY OF THE CONTRACTOR.

J. DRAINAGE ACCESSORIES

1. GENERAL:

- a. INSTALL THE WORK OF THIS SECTION IN ACCORDANCE WITH THE MANUFACTURER'S PRINTED INSTALLATION INSTRUCTIONS, UNLESS OTHERWISE SPECIFIED.
- b. SECURE EXTERNAL COMPONENTS IN PLACE WITH VANDAL RESISTANT FASTENERS OR DEVICES WHICH CANNOT BE REMOVED WITHOUT SPECIAL TOOLS.

K. DEVICES:

- a. CLEANOUT & CLEANOUT PLUG
- THREADED PIPE FITTING OR CAST IRON FERRULE WITH GAS TIGHT CLEANOUT PLUG
  - PLUG SHOULD BE CAST BRASS OR BRONZE, WITH THREADED END, AND RAISED OR COUNTERSUNK HEAD.
  - LUBRICATE THREADS OF CLEANOUT PLUG WITH ANTI-SEIZE LUBRICANT BEFORE FINAL INSTALLATION.
- b. CLEANOUT WALL PLATE
- IT SHOULD BE ROUND, STAINLESS STEEL OR POLISHED CHROME PLATED BRONZE COVER PLATE WITH STAINLESS STEEL VANDAL RESISTANT FASTENER TO SECURE TO CLEANOUT PLUG.
- c. CLEANOUT DECK PLATE
- IT SHOULD BE STANDARD DUTY FLOOR CLEANOUT FITTING WITH COATED CAST IRON BODY; ROUND, POLISHED NICKEL BRONZE SCORiated TOP SECURED TO CLEANOUT PLUG WITH STAINLESS STEEL VANDAL RESISTANT FASTENER; THREADED HEIGHT ADJUSTMENT, CAST IRON HEAD, GAS TIGHT CLEANOUT PLUG, AND CONNECTION TO MATCH PIPING OPTION SELECTED.
  - GRILLE FREE AREA SHOULD BE AT LEAST EQUAL TO CROSS-SECTION AREA OF PIPE TO WHICH CONNECTION MADE AND MADE OF POLISHED NICKEL BRONZE, WITH REMOVABLE GRATE, EITHER PERFORATED OR BAR TYPE. GRATE ATTACHED TO GRILLE BODY WITH VANDAL RESISTANT FASTENER.

- L. INSTALL PIPING TO CONSERVE BUILDING SPACE. DO NOT INTERFERE WITH USE OF BUILDING SPACE AND THE WORK OF OTHER TRADES. ALL PIPING RUN IN CEILING SHALL BE INSTALLED TIGHT TO THE STRUCTURE ABOVE.

- M. INSTALL PIPING TO ALLOW FOR EXPANSION AND CONTRACTION WITHOUT STRESSING PIPE, JOINTS OR CONNECTED EQUIPMENT. PROVIDE PIPE ANCHORS, GUIDES AND EXPANSION JOINTS OR LOOPS IN ALL HOT WATER AND HOT WATER CIRCULATING MAIN SUPPLY PIPING AND SEGMENTS OF SUCH PIPE THAT EXCEED 30'-0" IN LENGTH.

- N. IN ALL AREAS WITH FINISHED SURFACES, SYSTEM PIPING AND COMPONENTS SHALL BE CONCEALED ABOVE OR WITHIN FINISHED SURFACES.

- O. REDUCTIONS IN PIPE SIZES SHALL BE MADE WITH ONE-PIECE REDUCING FITTINGS. BUSHINGS ARE NOT ACCEPTABLE. USE FLANGED FITTINGS AT THE BASE OF RISERS.

- P. VENT PENETRATIONS THROUGH THE ROOF SHALL BE FLASHED.

- Q. IF WATER PRESSURE EXCEEDS 80 PSI, A WATER PRESSURE REDUCING VALVE SHALL BE INSTALLED IN WATER PIPING AT CONNECTION TO MAIN.

- R. PROVIDE DIELECTRIC FITTINGS BETWEEN DISSIMILAR METALS.

- S. PIPE BACKFLOW PREVENTER DRAINS TO FLOOR DRAIN OR OTHER APPROVED INDIRECT WASTE SOURCE.

- T. PROVIDE ACCESS DOORS/PANELS FOR SERVICE AND ACCESS TO ALL VALVES AND OTHER SYSTEM COMPONENTS ENCLOSED IN WALLS AND CEILINGS. ACCESS DOORS SHALL BE FURNISHED BY THIS CONTRACTOR, INSTALLED BY THE GENERAL CONTRACTOR.

- U. ALL FIXTURES REQUIRING VACUUM BREAKERS SHALL BE EQUIPPED WITH INTEGRAL VACUUM BREAKERS.

- V. PIPE BACKFLOW PREVENTER DRAINS TO FLOOR DRAIN OR OTHER APPROVED INDIRECT WASTE SOURCE.

- W. PROVIDE ACCESS DOORS/PANELS FOR SERVICE AND ACCESS TO ALL VALVES AND OTHER SYSTEM COMPONENTS ENCLOSED IN WALLS AND CEILINGS. ACCESS DOORS SHALL BE FURNISHED BY THIS CONTRACTOR, INSTALLED BY THE GENERAL CONTRACTOR.

- X. ALL FIXTURES REQUIRING VACUUM BREAKERS SHALL BE EQUIPPED WITH INTEGRAL VACUUM BREAKERS.

- Y. ANY PENETRATIONS THROUGH FIRE RATED PARTITIONS, FLOORS, OR CEILINGS SHALL BE STEEL SLEEVED AND SEALED WITH 3M BRAND UL RATED FIRE BARRIER CAULK OR APPROVED EQUAL.

- Z. WHEN THE WATER PIPING SYSTEM IS COMPLETE, THOROUGHLY FLUSH ALL DIRT, SEDIMENT, SOLDER, ETC., OUT OF THE SYSTEM, REMOVING ALL STRAINERS, VALVE STEM SEATS, ETC., REQUIRED TO ACCOMPLISH THE FLUSHING.

- AA. AT ALL INDIRECT WASTE DRAINS, MAINTAIN AIR GAP AS REQUIRED BY CODE.

- AB. INSTALL SLEEVES FOR ALL PIPES WHICH PASS THROUGH WALLS, FLOORS, AND CEILINGS. WHERE PIPES ARE TO BE INSULATED, THE SLEEVE SHALL BE LARGE ENOUGH TO ACCOMMODATE INSULATION. SLEEVES SHALL BE FLUSH WITH FINISHED SURFACES AT BOTH ENDS. ON FINISHED SURFACES IN EXPOSED AREAS PROVIDE ESCUTCHEONS COMPATIBLE WITH FINISH.

- AC. PROVIDE WATER HAMMER ARRESTERS ON SUPPLY PIPING TO ALL FLUSHMETER VALVES AND QUICK-CLOSING VALVES.

- AD. UNLESS OTHERWISE INDICATED, TRAPS SEALS AT ALL FLOOR DRAINS SHALL BE MAINTAINED BY AN APPROVED TRAP PRIMING DEVICE.

- AE. MAINTAIN ALL REQUIRED AND RECOMMENDED CLEARANCES FOR ALL PLUMBING SYSTEM COMPONENTS AND EQUIPMENT.

- AF. MAINTAIN MINIMUM 10'-0" CLEARANCE BETWEEN ALL PLUMBING V.T.R.S AND ALL OUTDOOR AIR INTAKES. OFFSET VENT STACKS AND STACK VENTS IF AND AS REQUIRED BELOW ROOF TO MAINTAIN SUCH CLEARANCE WHETHER OR NOT SUCH OFFSET IS INDICATED ON THE DRAWINGS. PROVIDE ALL REQUIRED SEISMIC SUPPORTS.

3. TESTING

1. GENERAL:

- A. AT THE COMPLETION OF THE PLUMBING WORK, COMPLETELY TEST THE ENTIRE INSTALLATION OF ALL SYSTEMS FOR PROPER OPERATION AND COMPLIANCE WITH APPLICABLE CODES AND LOCAL REQUIREMENTS. CORRECT ALL DEFICIENCIES FOUND.

- B. TESTING OF THE INSTALLED SYSTEMS SHALL BE MADE BY THE CONTRACTOR IN THE PRESENCE OF A REPRESENTATIVE OF THE OWNER.

- C. THE CONTRACTOR SHALL NOT COVER UP OR PERMANENTLY CONCEAL PIPING, DEVICES OR ANY PORTION OF NEWLY CONSTRUCTED PLUMBING SYSTEM(S) UNTIL SUCH SYSTEM, OR PORTION OF THE SYSTEM, HAS BEEN TESTED IN THE PRESENCE OF A REPRESENTATIVE OF THE OWNER AND INSPECTED BY THE LOCAL INSPECTOR AND APPROVED IN WRITING. EXCEPT PIPING PASSING THROUGH FLOORS, WALLS, PARTITIONS, OR BEAMS, FOR DISTANCES EQUAL TO THE THICKNESS OF SUCH FLOOR, WALL, PARTITION OR BEAM.

- D. THIS CONTRACTOR SHALL NOTIFY THE VARIOUS DEPARTMENTS, BUREAUS AND INDIVIDUALS AT LEAST TWO WEEKS IN ADVANCE OF THE TIME THAT THE TESTS ARE TO BE CONDUCTED.

- E. ALL DEFECTIVE PARTS SHALL BE REPLACED OR CORRECTED BY THIS CONTRACTOR AND AN EXTRA TEST OR TESTS SHALL BE MADE UNTIL THE OPERATION IS SATISFACTORY. ALL ARRANGEMENTS AND EXPENSES NECESSARY TO CONDUCT ALL TESTS REQUIRED BY THESE SPECIFICATIONS AND THE VARIOUS AGENCIES HAVING JURISDICTION OVER THE WORK INSTALLED UNDER THIS CONTRACT SHALL BE MADE BY THIS CONTRACTOR. NO EXTRA COMPENSATION WILL BE ALLOWED FOR THESE TESTS, THE COST THEREOF BEING INCLUDED IN THE LUMP SUM BID FOR THIS CONTRACT.

- F. WHERE ANY EVIDENCE OF STOPPAGE IS FOUND IN PIPING OR EQUIPMENT, THIS CONTRACTOR SHALL DISCONNECT, CLEAN, REPAIR AND RECONNECT ALL OBSTRUCTED PIPING OR EQUIPMENT AND SHALL ALSO PAY FOR ALL NECESSARY CUTTING AND REPAIRS TO ADJOINING WORK.

- G. ALL PIPING AND EQUIPMENT SHALL BE THOROUGHLY CLEANED INSIDE AND OUT, OF DIRT, CUTTINGS, OILS AND OTHER FOREIGN SUBSTANCES AND SHALL BE LEFT CLEAN.

- H. ALL REQUIRED TESTS SHALL BE WITNESSED BY LOCAL AUTHORITIES AND THE OWNER'S REPRESENTATIVE.

- I. ALL EQUIPMENT WILL BE FACTORY TESTED.

- J. CONTRACTOR SHALL IDENTIFY TO THE OWNER'S REPRESENTATIVE ANY LEAKS OR DAMAGE THAT OCCURS AS A RESULT OF SYSTEM TESTING. CONTRACTOR SHALL TAKE NECESSARY PRECAUTIONS TO LIMIT ANY POTENTIAL DAMAGE. CORRECTIVE ACTION REQUIRED AS A RESULT OF TESTING SHALL BE PERFORMED IMMEDIATELY AND AT THE CONTRACTOR'S EXPENSE.

- K. REPORT IN WRITING TO AUTHORITIES HAVING JURISDICTION, THE ARCHITECT AND THE OWNER THE RESULTS OF ALL TESTING.

L. TESTING REQUIREMENTS

- a. TEST ALL DOMESTIC WATER PIPING AS PER NJPC 2021.
- b. TESTS SHALL BE WITNESSED BY THE BUILDING ENGINEER.
- c. THE PLUMBING CONTRACTOR WILL BE HELD RESPONSIBLE FOR ALL DAMAGE DUE TO TEST FAILURES AND LEAKAGE IN THE TEST AREA AND ADJACENT TENANT OR ESB SPACES.

- M. THOROUGHLY FLUSH PIPING SYSTEM WITH FRESH WATER IMMEDIATELY PRIOR TO FINAL ACCEPTANCE.

- N. INSPECTION & TESTING SHALL BE AS PER NJPC 2021.

4. WARRANTY

- A. EQUIPMENT, MATERIALS AND WORKMANSHIP FURNISHED UNDER THIS CONTRACT SHALL BE GUARANTEED BY THE CONTRACTOR FOR A PERIOD OF ONE YEAR FROM THE DATE OF FINAL ACCEPTANCE OF THE WORK BY THE OWNER. THE CONTRACTOR SHALL KEEP THE WORK IN GOOD REPAIR FOR ONE YEAR AFTER THE DATE OF FINAL APPROVAL. THE CONTRACTOR SHALL, AT HIS OWN EXPENSE, PROMPTLY CORRECT AND REPAIR ANY AND ALL BREAKS, FAILURES OR WEAR DUE TO FAULTY MATERIALS, WORKMANSHIP OR EQUIPMENT. ALL SETTLEMENTS OF SURFACES THAT MAY OCCUR WITHIN THAT PERIOD SHALL ALSO BE PROMPTLY REPAIRED.

PROJECT INFORMATION:

KIDSUNITED

DRAWING TITLE:

PLUMBING SPECIFICATIONS

DRAWING NO.:

P-0.2



**GENERAL NOTES:**

1. WATER HEATER DRAIN SPILLS TO THE NEW MOP SINK.
2. REFER RISER DIAGRAMS FOR ALL PIPE SIZES.
3. CW/HW/HWR PIPING TO BE PROVIDED WITH INSULATION AS PER 2021 NATIONAL STANDARD PLUMBING CODE.
4. PROVIDE BRANCH PRV IF PRESSURE EXCEEDS 80 PSI.
5. CONTRACTOR SHALL CONFIRM EXISTING CONDITIONS PRIOR TO BID.
6. CONFIRM LOCATIONS OF ALL EXISTING UTILITIES AND ADJUST ROUTING OF TENANT SYSTEMS AS REQUIRED.

**KEYED NOTES:**


1. INSTALL NEW FIXTURE AND CONNECT TO THE EXISTING CW PIPING. CONTRACTOR TO FIELD VERIFY THE EXACT LOCATION AND SIZE OF EXISTING CW PIPING.
2. CONNECT NEW 1/2" CW PIPING TO EXISTING CW PIPING IN SPACE. CONTRACTOR TO FIELD VERIFY EXACT SIZE AND LOCATION OF EXISTING CW PIPING.
3. CONNECT NEW 3/4" CW/HW PIPING IN SPACE. CONTRACTOR TO FIELD VERIFY THE EXACT SIZE AND LOCATION OF CW/HW PIPING.
4. CONNECT NEW 3/4" WATER LINE TO EXISTING WATER LINE WITH EXISTING WATER METER. CONTRACTOR TO FIELD VERIFY THE EXACT SIZE, ROUTING & LOCATION OF EXISTING WATER LINE.
5. THE EXISTING SEPARATE METERS LOCATED IN CEILING ABOVE THE RESTROOMS WILL REMAIN AS IS. THE CONTRACTOR SHALL VERIFY THE EXACT SIZE AND LOCATION IN THE FIELD.
6. INSTALL AN ASSE 1070 MIXING VALVE AT LAVATORY TO TEMPER HOT WATER. SET VALVE AT 110°F.

**RISER DIAGRAM:**

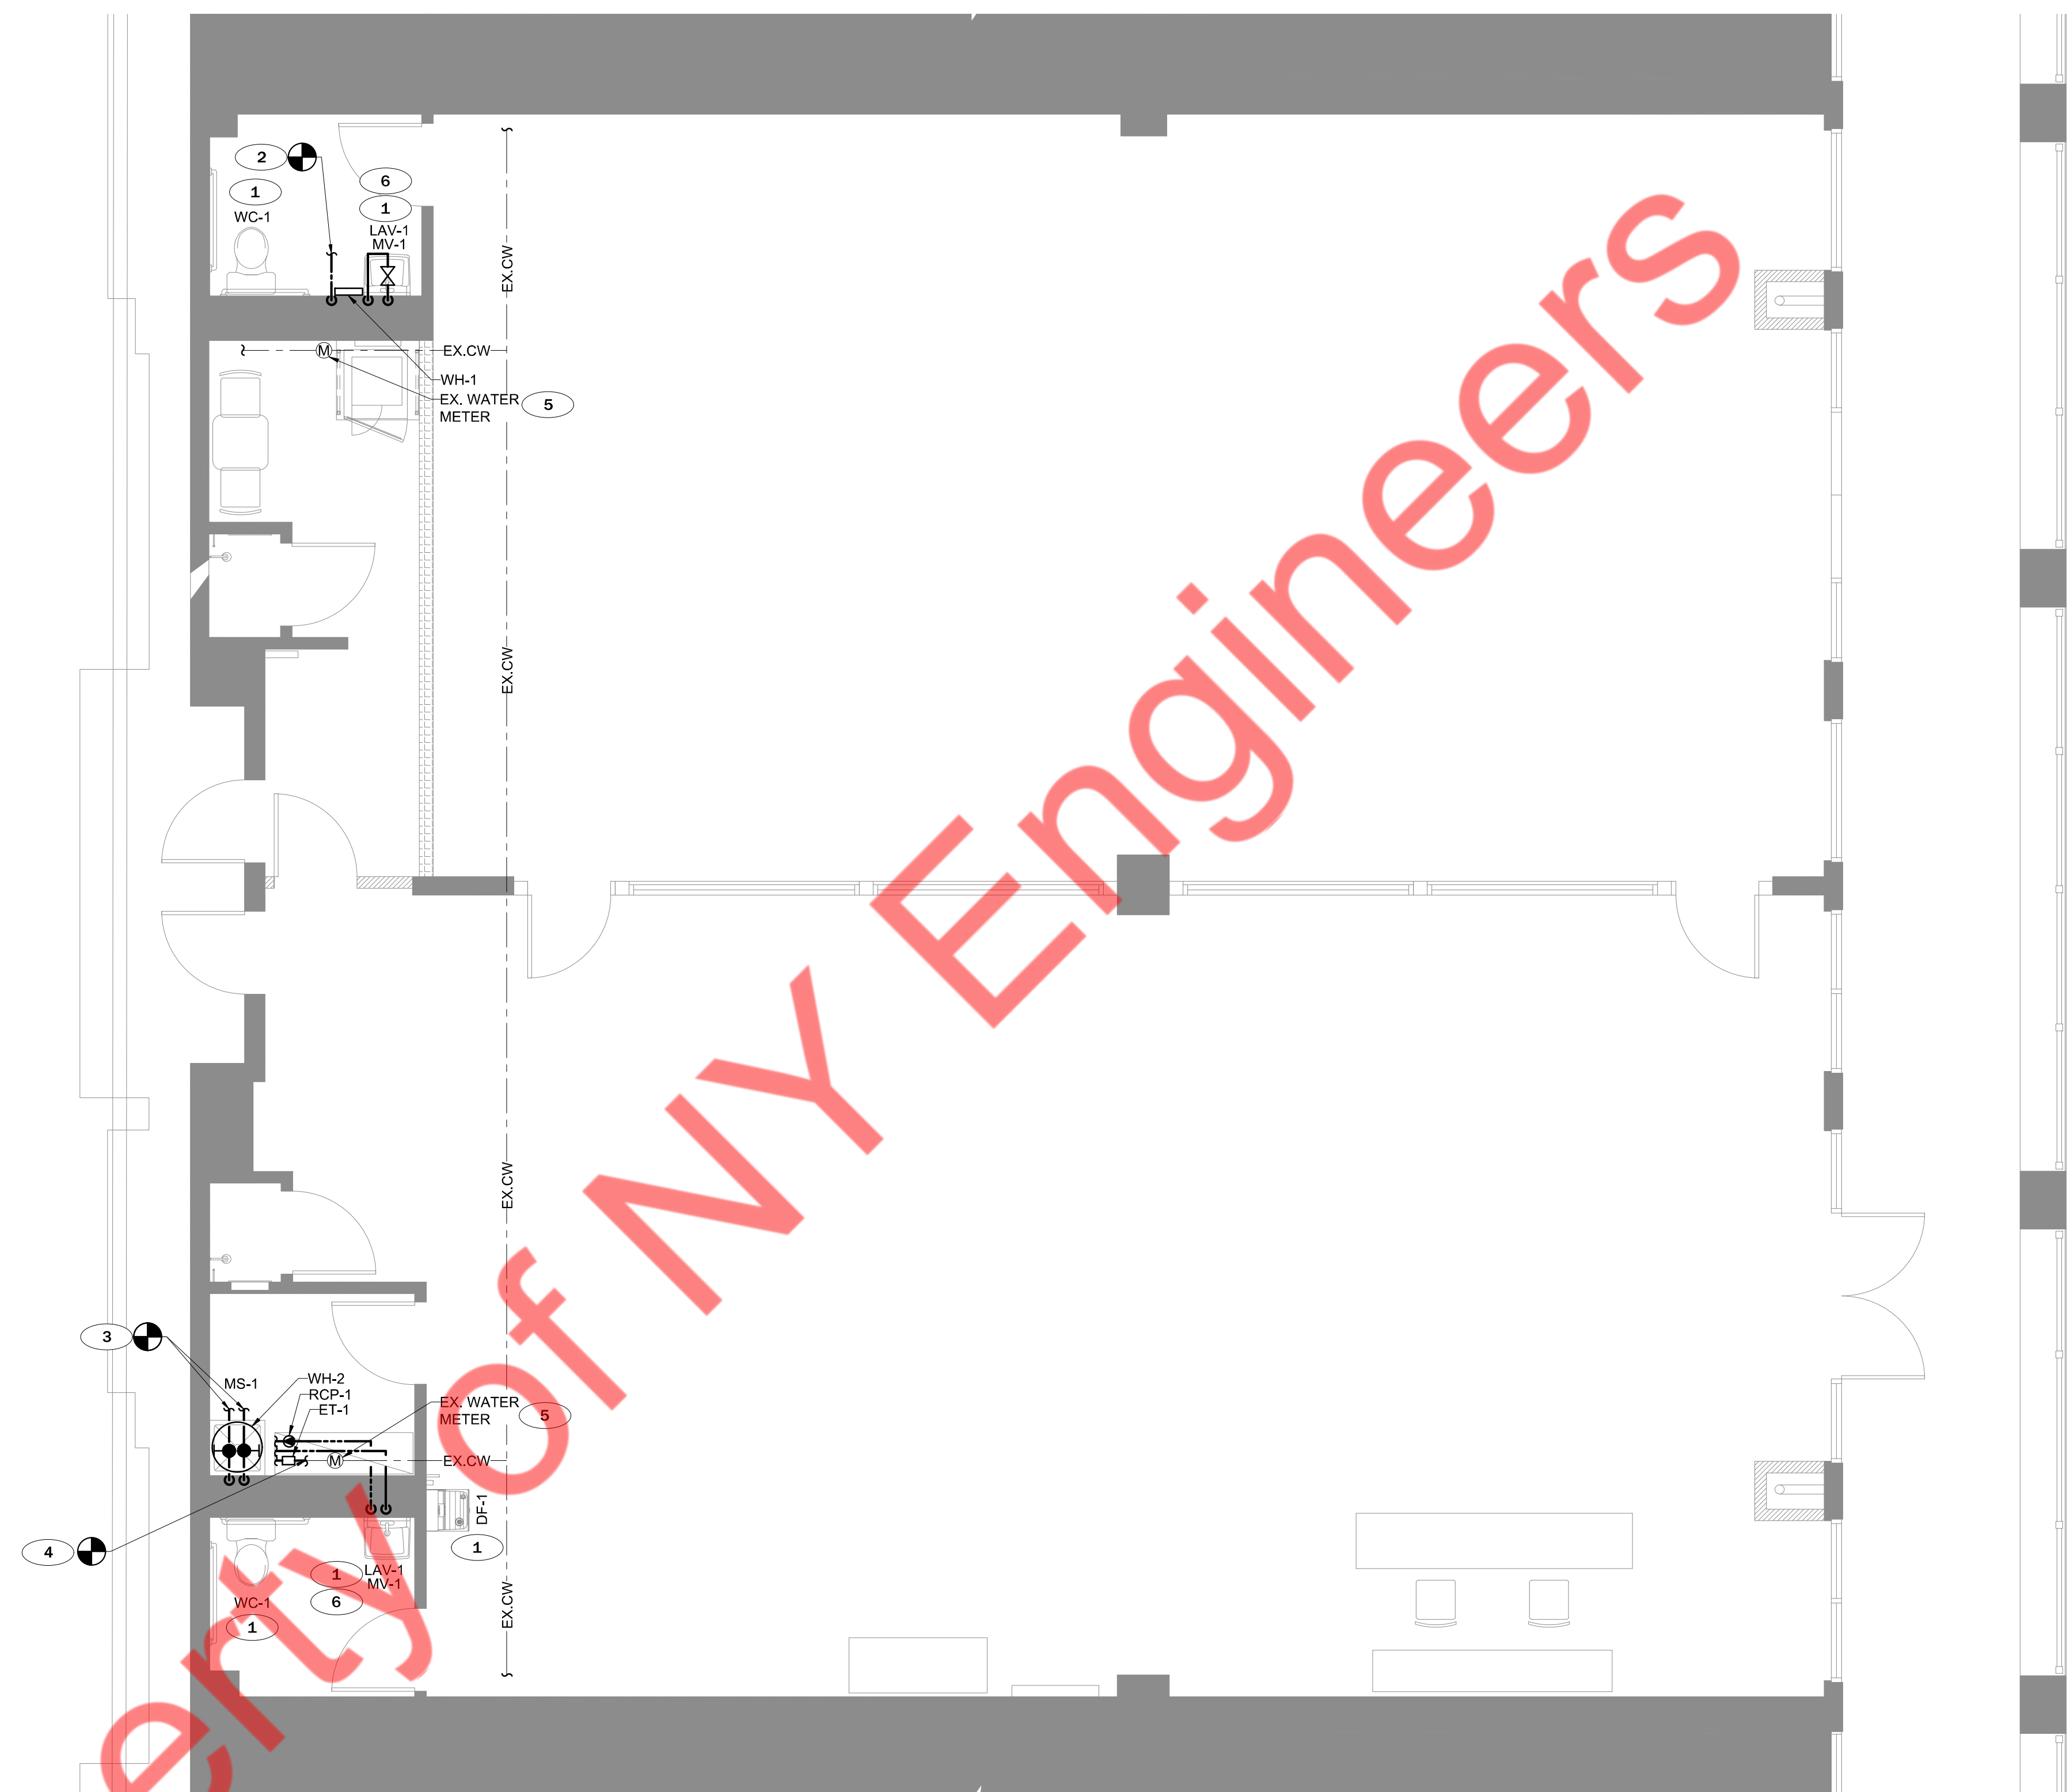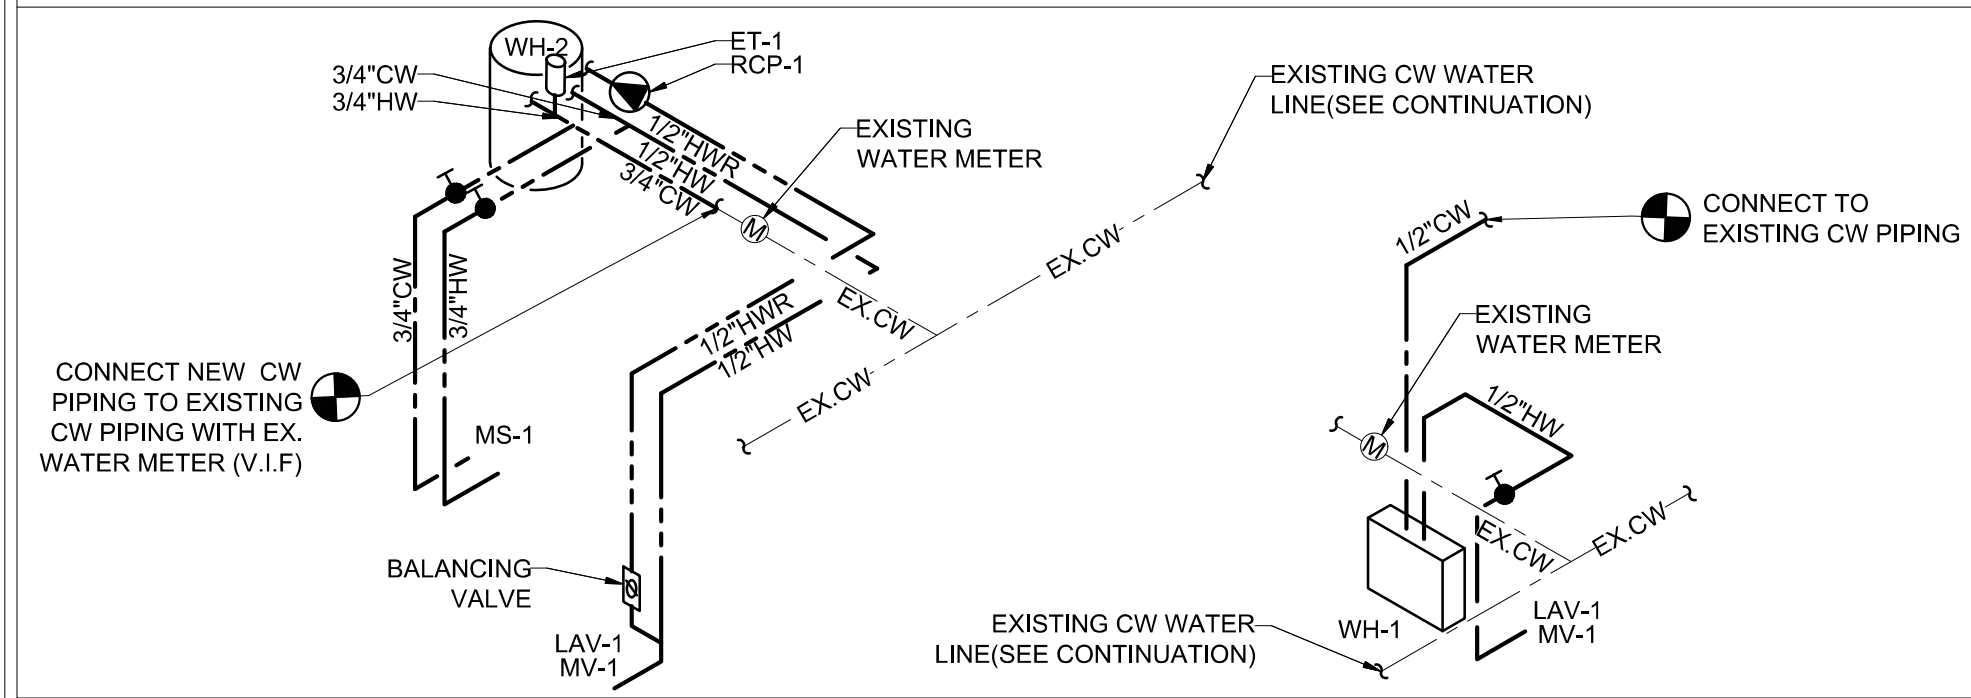



**1 PLUMBING WATER FLOOR PLAN**  
SCALE 1/4" = 1'-0"

1/4"=1'-0"

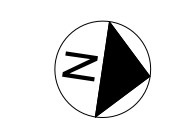

Property of NY Engineers

 **PROJECT INFORMATION:**  
  
KIDSUNITED

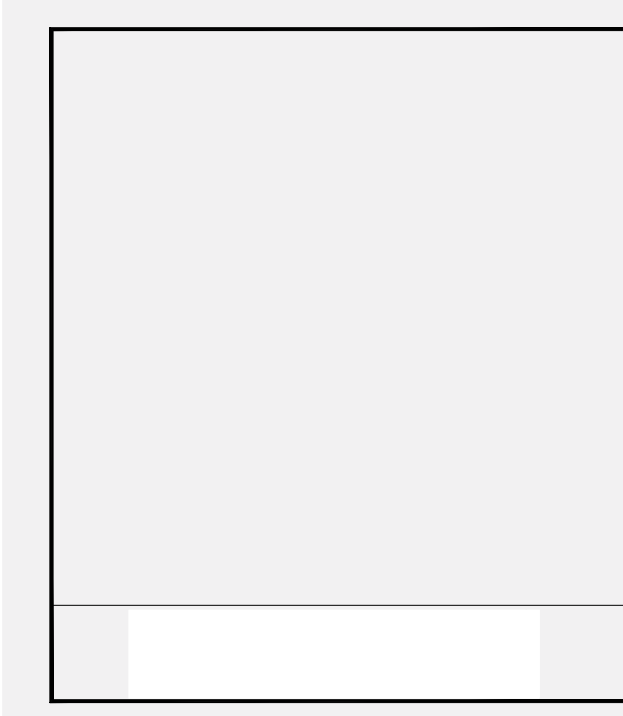

**DRAWING TITLE:**  
PLUMBING WATER PLAN  
AND RISER

**DRAWING NO.:**  
**P-1.0**


**GENERAL NOTES:**

1. CONTRACTOR TO FIELD VERIFY FEASIBILITY OF SLAB PENETRATION AS PER STRUCTURAL REQUIREMENT.
2. REFER RISER DIAGRAM FOR ALL PIPE SIZES.
3. CONTRACTOR SHALL CONFIRM EXISTING CONDITIONS PRIOR TO BID.
4. CONFIRM LOCATIONS OF ALL EXISTING UTILITIES AND ADJUST ROUTING OF TENANT SYSTEMS AS REQUIRED.

**KEYED NOTES:**


1. INSTALL NEW FIXTURE AND CONNECT TO THE EXISTING SANITARY & VENT PIPING. CONTRACTOR TO FIELD VERIFY THE SIZE AND LOCATION OF EXISTING PIPING.
2. CONNECT NEW 3" SANITARY PIPING TO EXISTING SANITARY PIPING IN SPACE. CONTRACTOR TO FIELD VERIFY EXACT SIZE, LOCATION, INVERT AND ROUTING OF EXISTING SANITARY PIPING.
3. CONNECT NEW VENT PIPING TO EXISTING VENT PIPING IN SPACE. CONTRACTOR TO FIELD VERIFY EXACT SIZE AND LOCATION OF EXISTING VENT PIPING.
4. EXISTING PLUMBING FIXTURES TO REMAIN AT SAME LOCATION WITH EXISTING EXISTING SANITARY & VENT PIPING. CONTRACTOR TO FIELD VERIFY THE CONDITION OF EXISTING PIPING AND REPLACE IF REQUIRED.

**RISER DIAGRAM:**

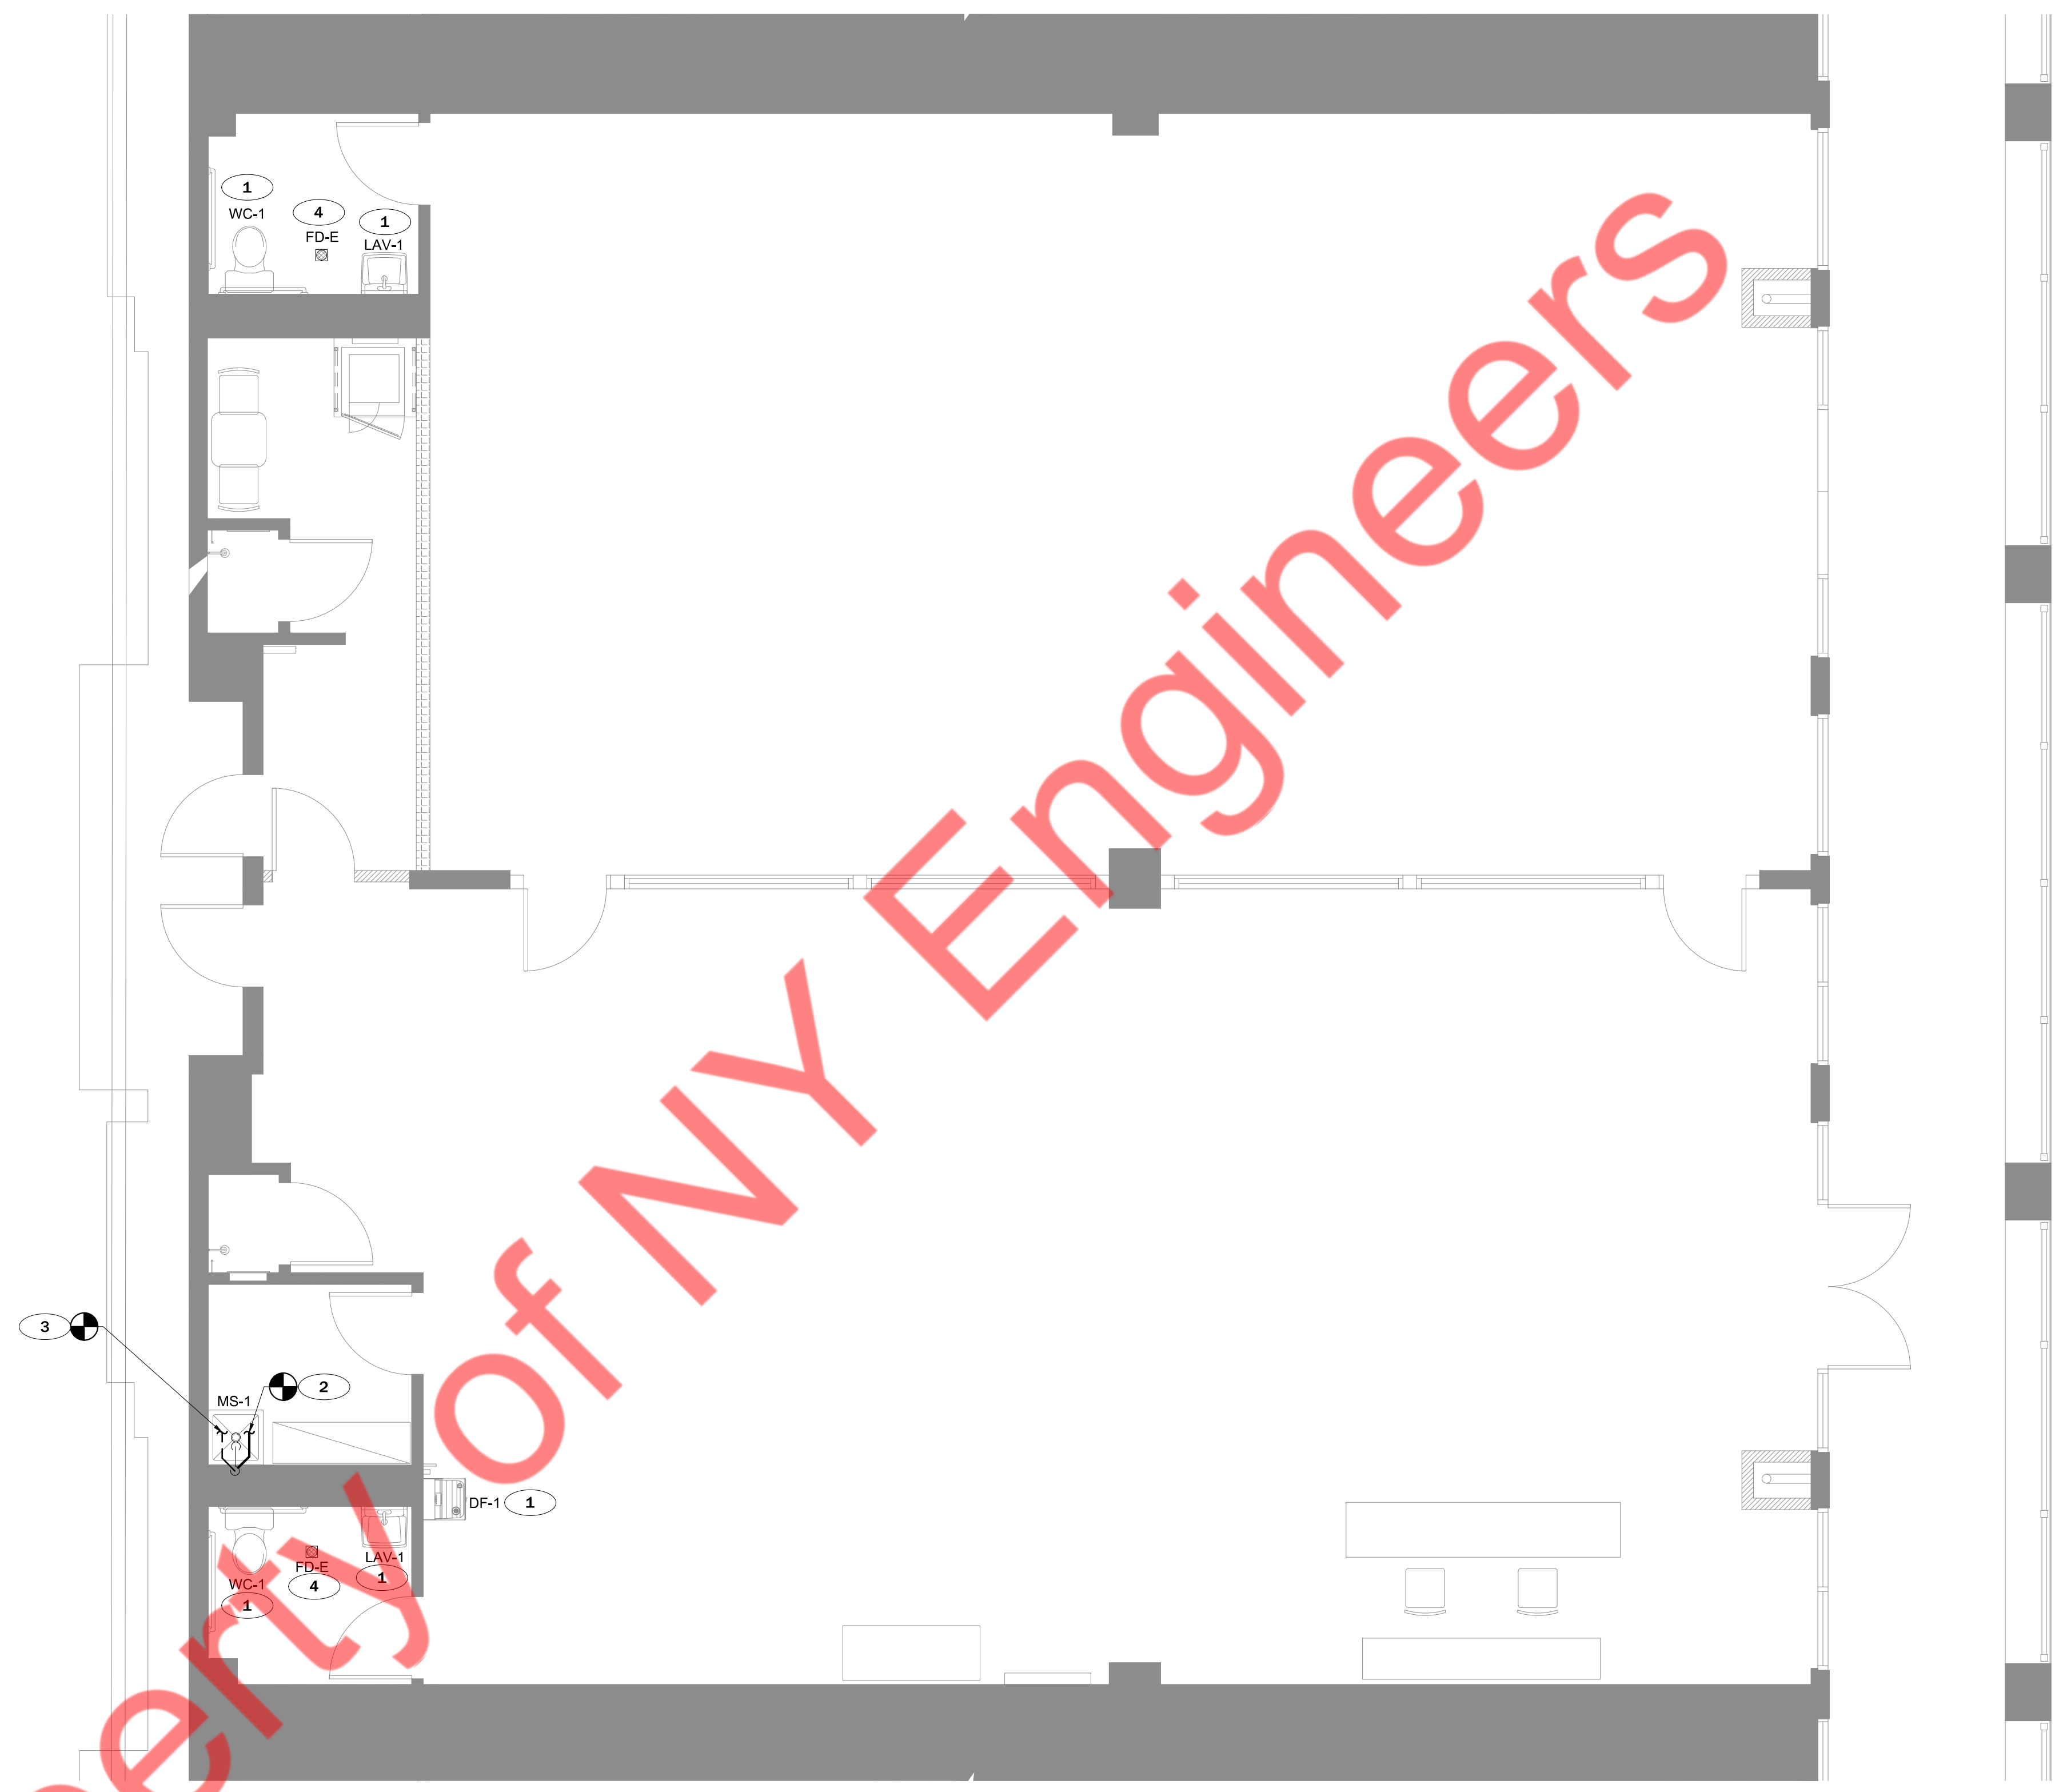

**1 PLUMBING SANITARY FLOOR PLAN**  
SCALE 1/4" = 1'-0"

1/4"=1'-0"

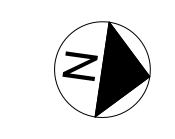

Property of NY Engineers

**PROJECT INFORMATION:**

**KIDSUNITED**

---


**DRAWING TITLE:**

PLUMBING SANITARY PLAN AND RISER


---

**DRAWING NO.:**


**P-2.0**

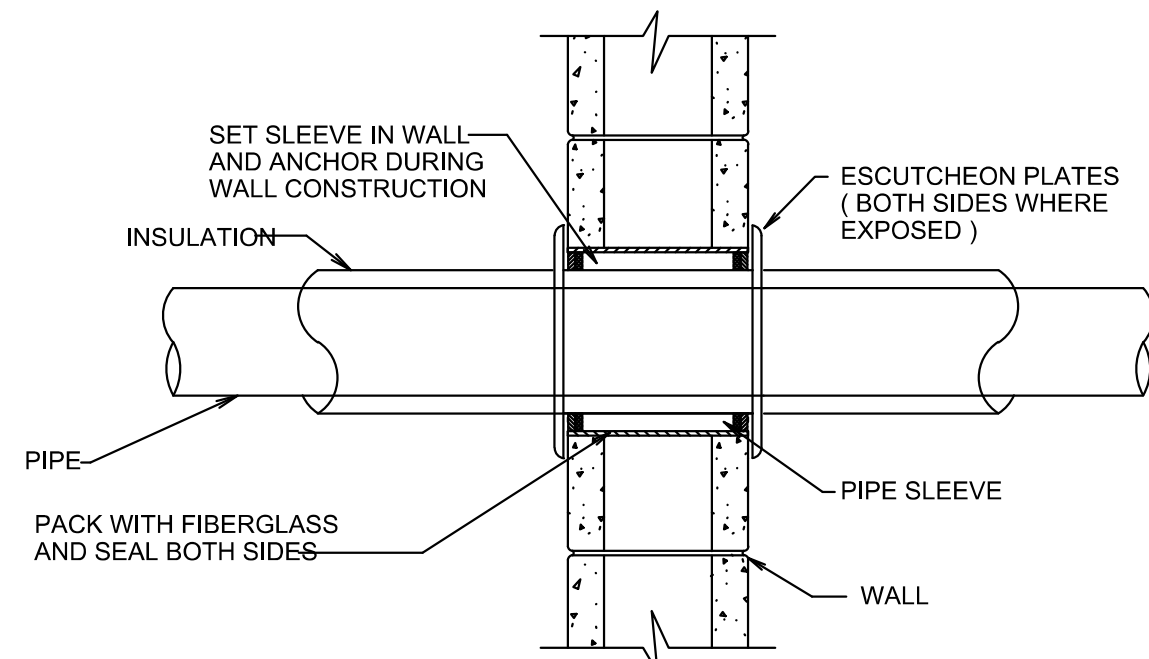

1 PIPE SLEEVE THRU WALL SECTION  
N.T.S.

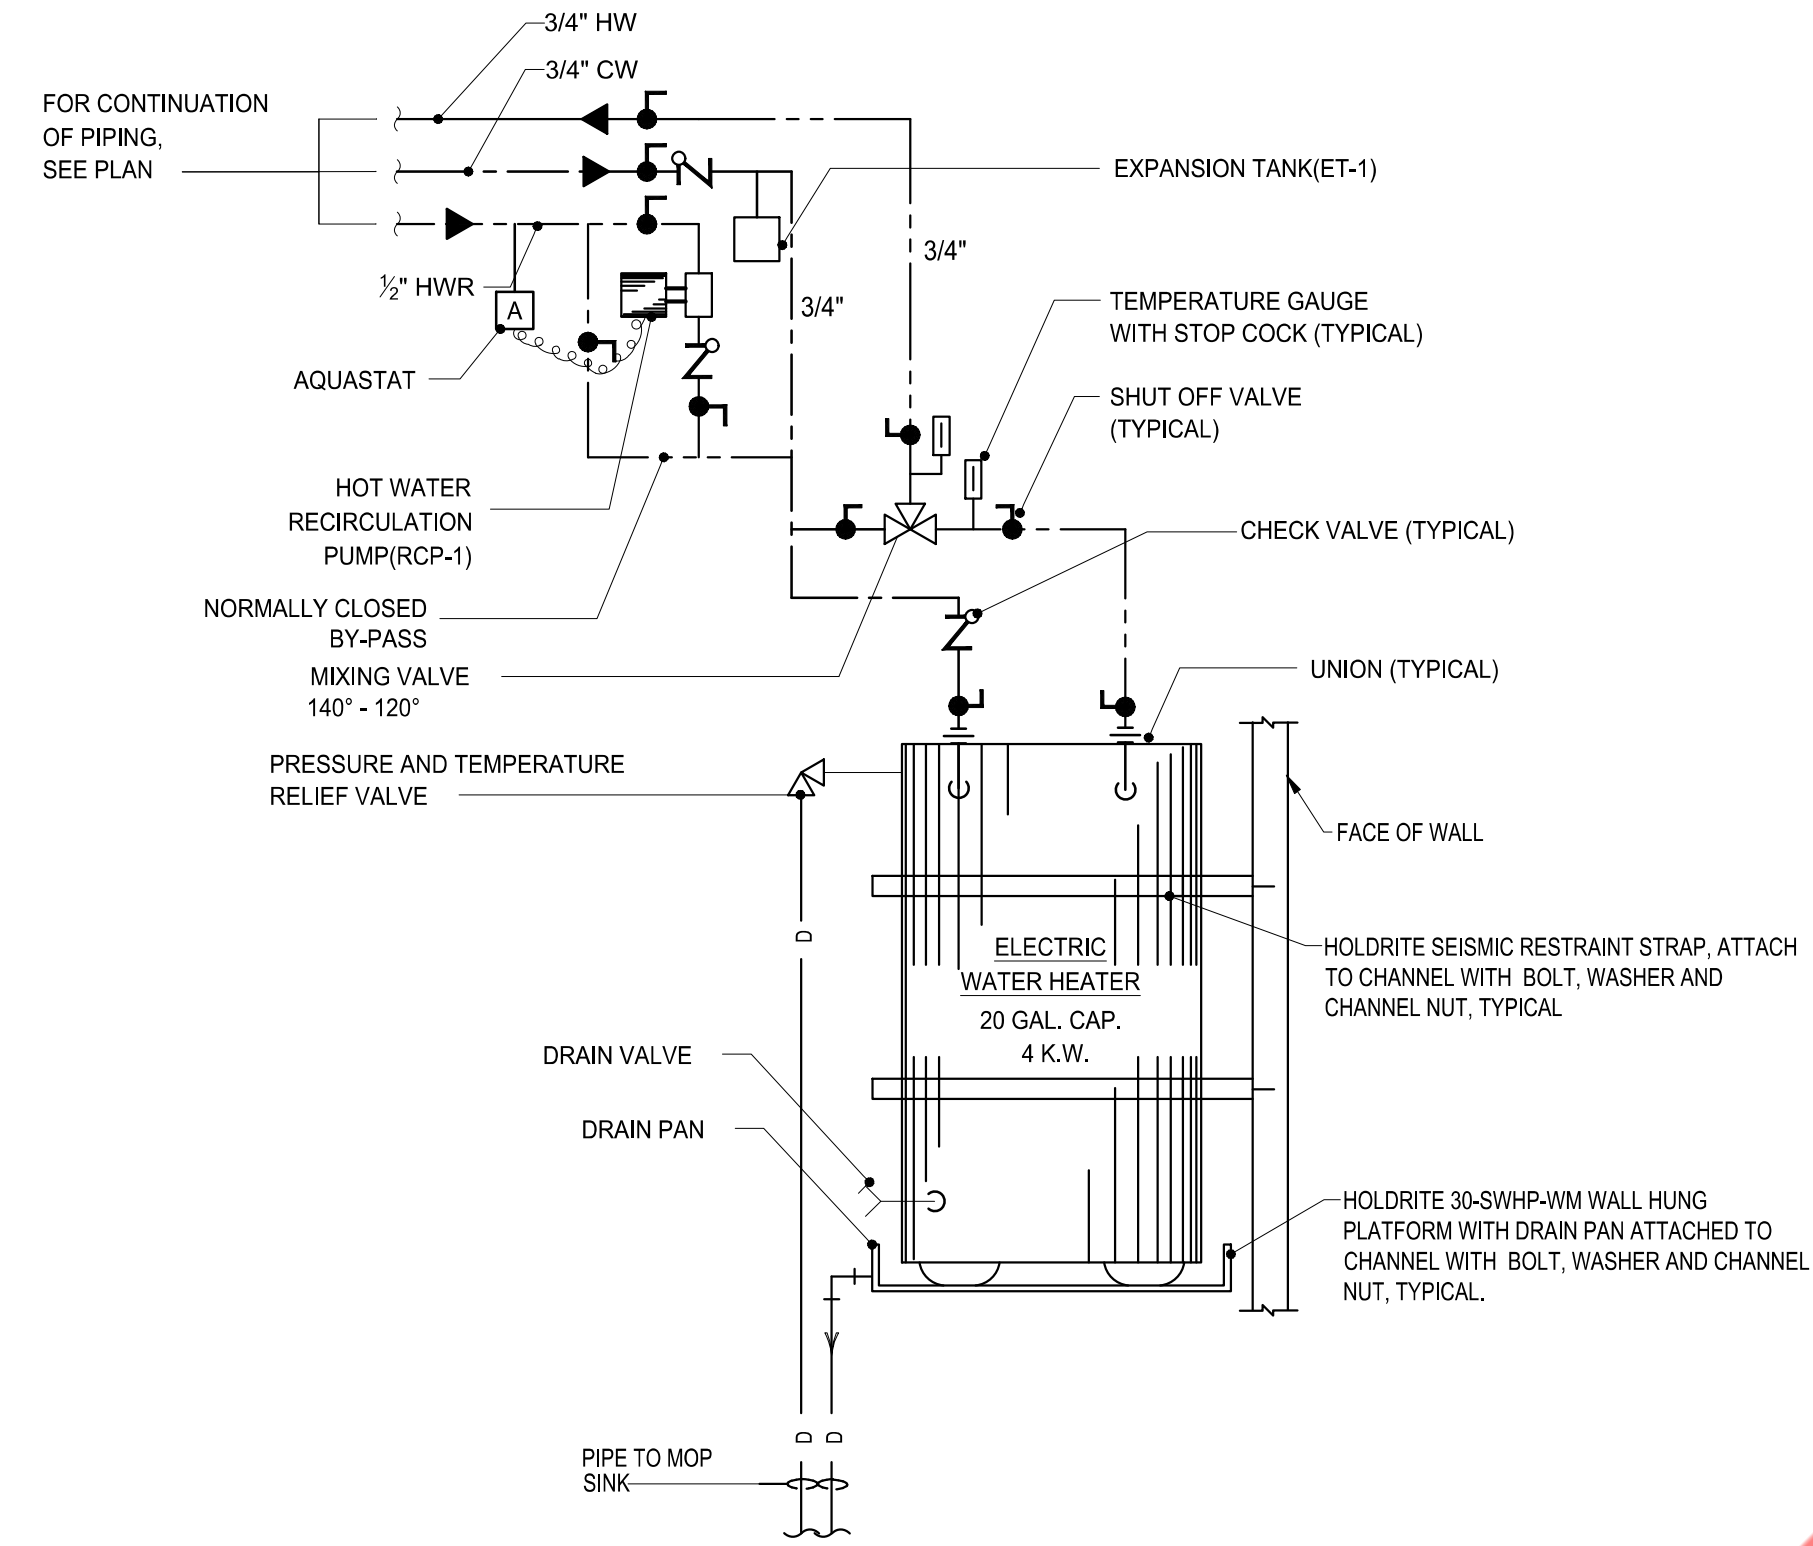

2 ELECTRIC WATER HEATER DETAIL (WH-2)  
N.T.S.

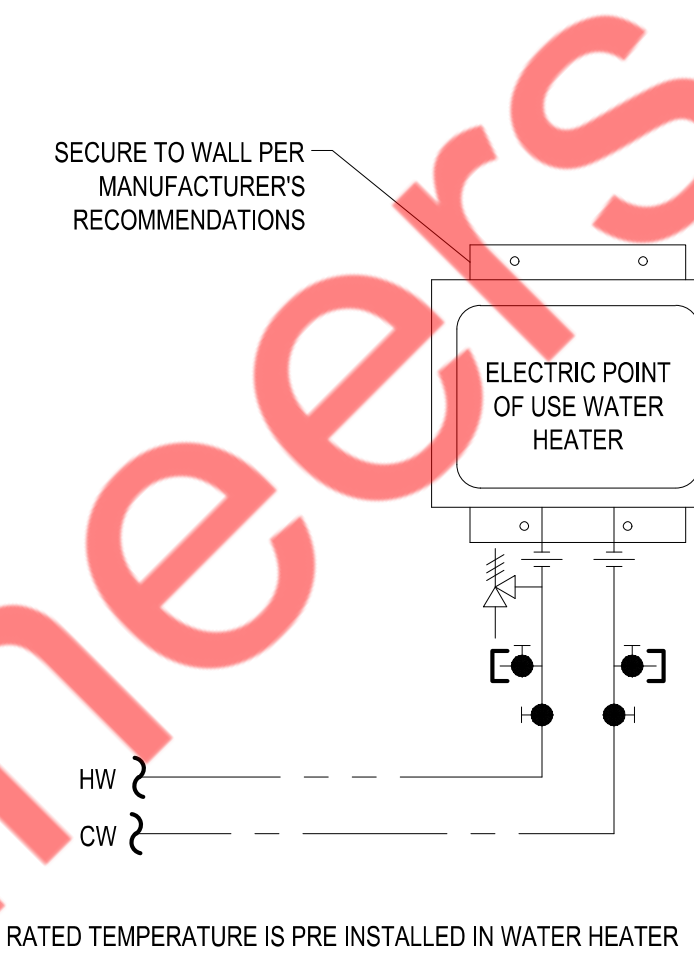


3 WATER HEATER DETAIL (WH-1)  
N.T.S.

**CONCEALED VALVES AND FITTINGS**


- \* WRAP WITH 1-INCH THICK, 1-POUND DENSITY TO REQUIRED PIPE INSULATION THICKNESS
- \* SECURE WITH WIRE OR TAPE.
- \* VAPOR SEAL COLD WATER, CHILLED WATER AND STORM WATER PIPING.

**CONCEALED VALVES AND FITTINGS**


- \* PREMOLDED FIBER GLASS OR RADIAL MITERED PIPE INSULATION
- \* SKIM COAT OF INSULATION CEMENT
- \* COAT OF MASTIC
- \* WRAP WITH FIBER GLASS REINFORCING CLOTH.
- \* FINISH COAT OF MASTIC
- \* OVERLAP 2-INCHES ON PIPE INSULATION.

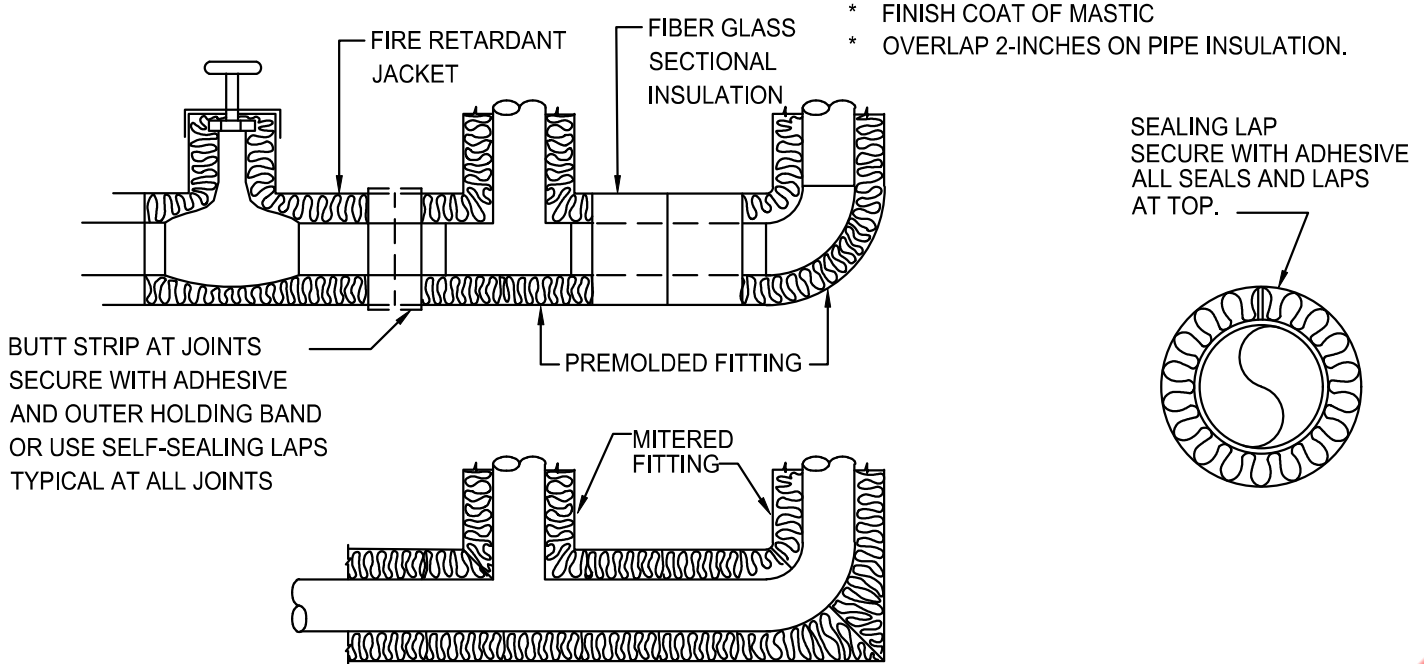

4 INSULATION OF PIPING, VALVES AND FITTINGS  
N.T.S.

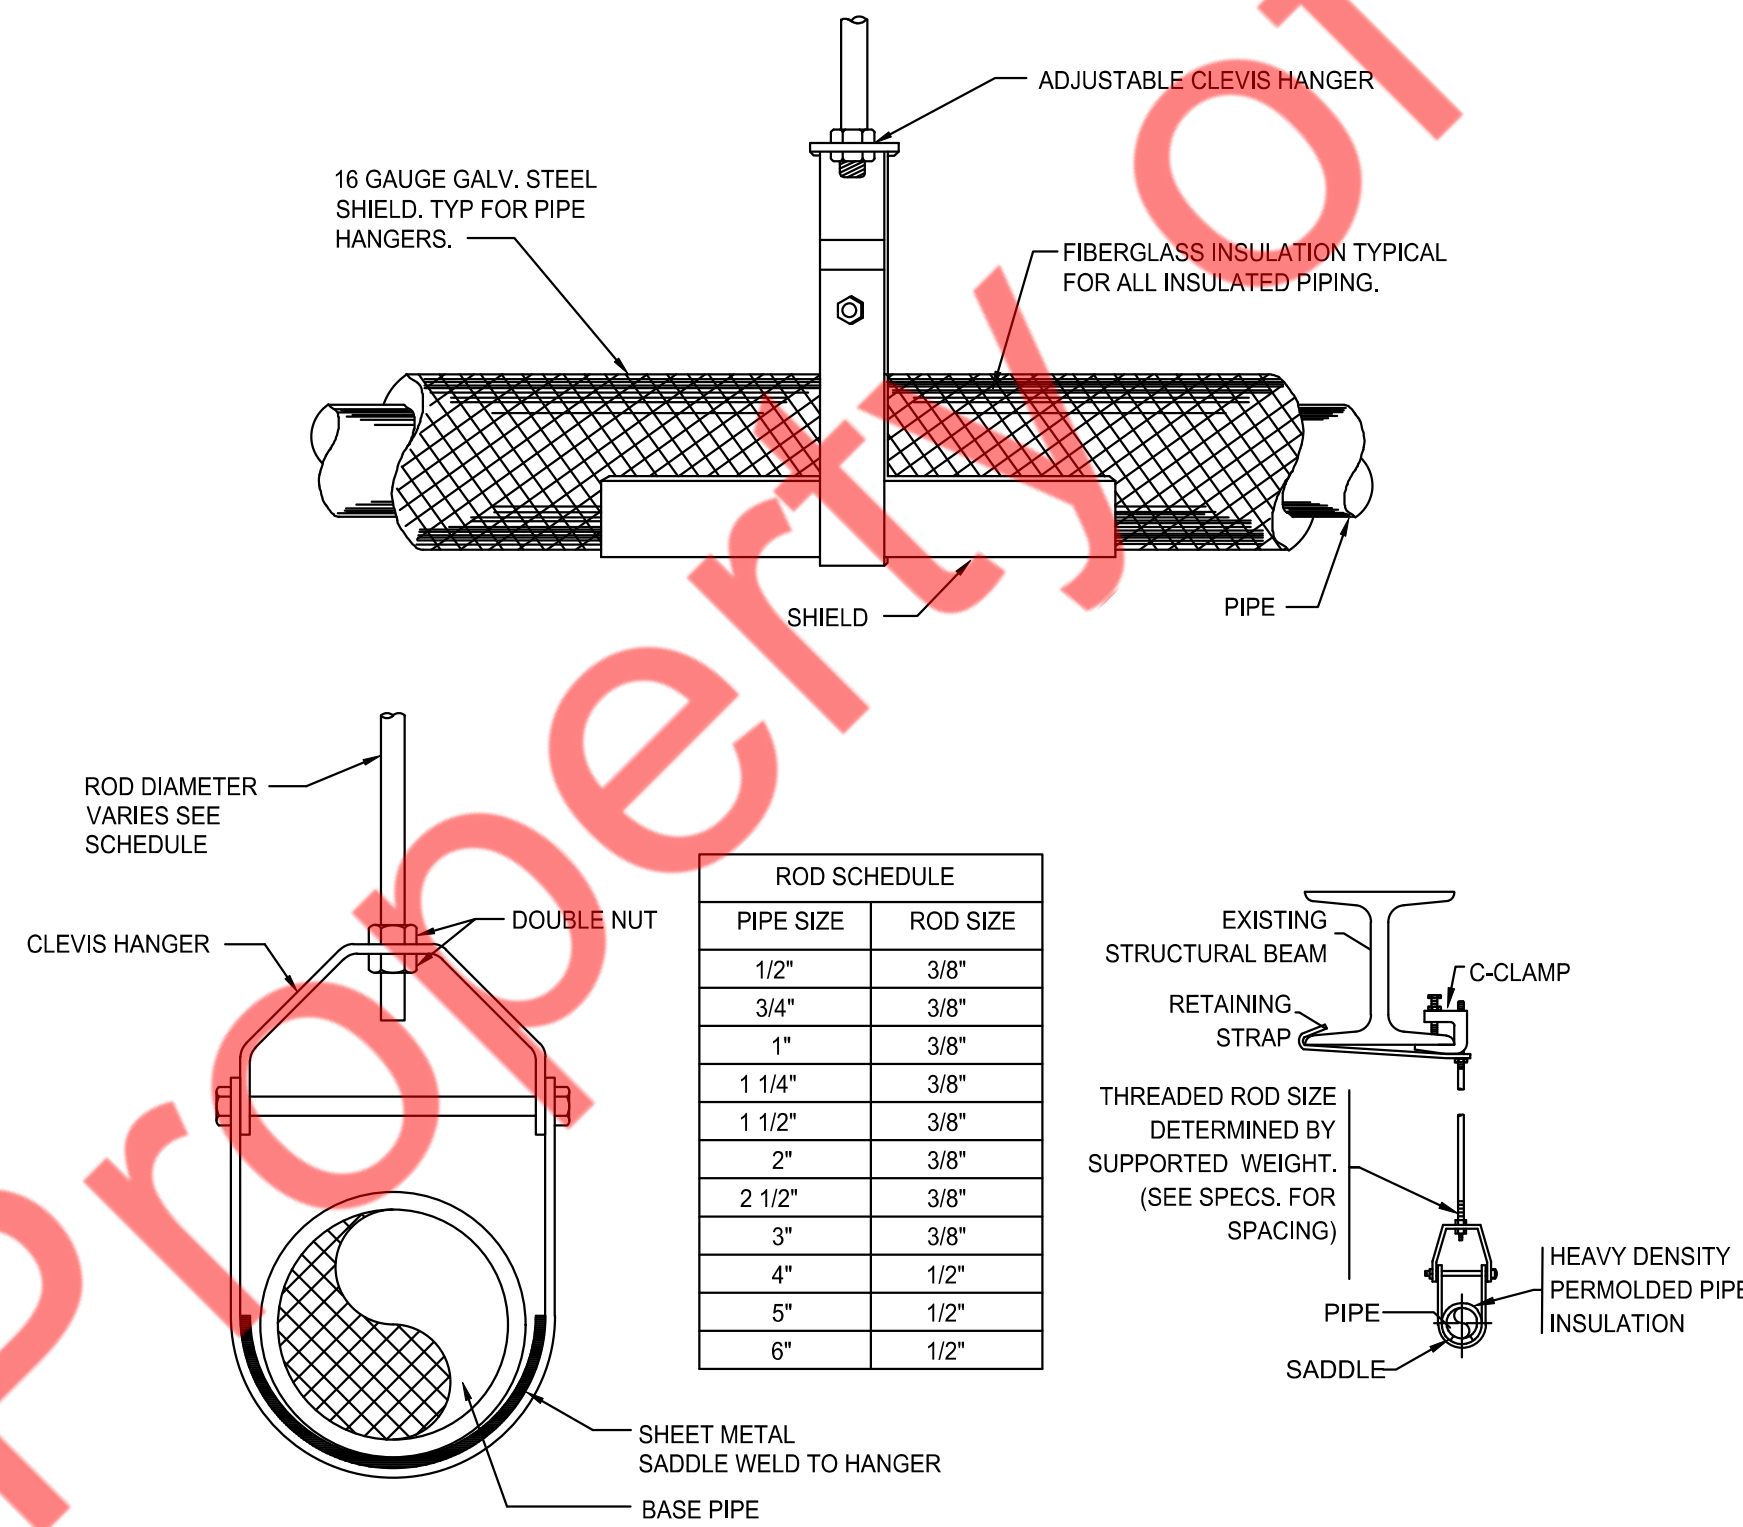

5 HANGER DETAIL  
N.T.S.

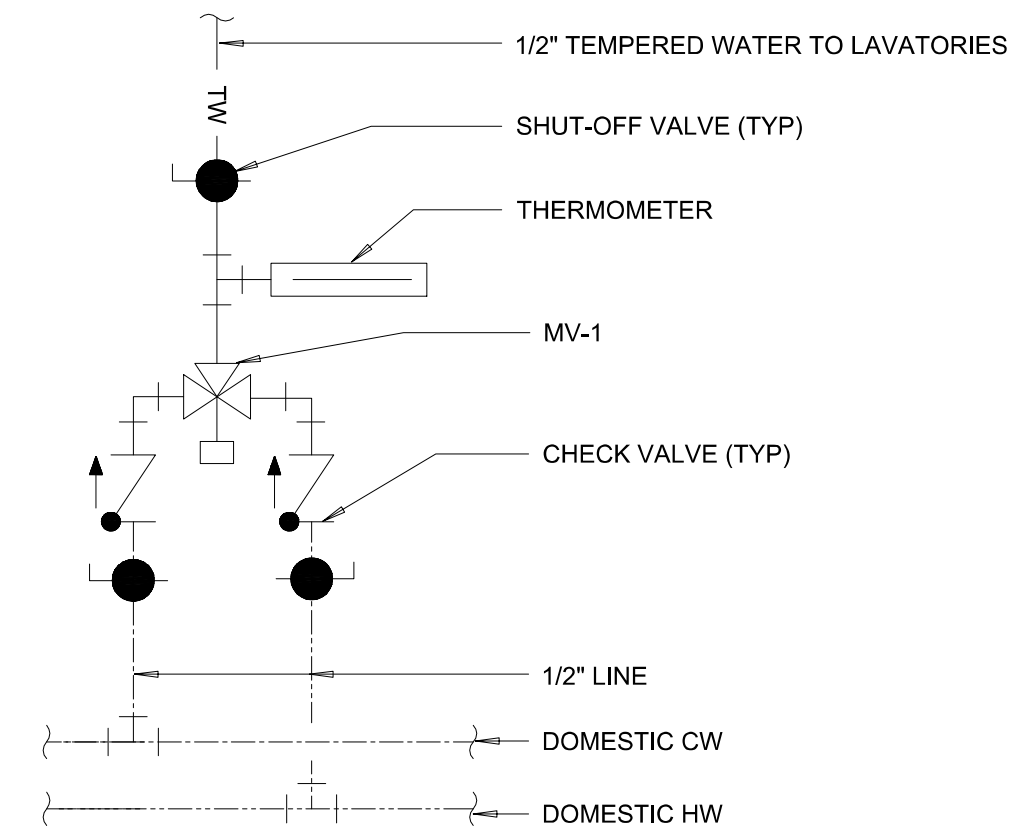

6 THERMOSTATIC MIXING VALVE DETAIL  
N.T.S.

PROJECT INFORMATION:  
  
KIDSUNITED

DRAWING TITLE:  
  
PLUMBING DETAILS

DRAWING NO.:  
  
P-3.0

**PLUMBING FIXTURE SCHEDULE**

TAG	PLUMBING FIXTURE	MANUFACTURER	MODEL	CONNECTION SIZE - INCHES					REMARKS
				TRAP	SOIL/WASTE	VENT	COLD WATER	HOT WATER	
WC-1	WATER CLOSET	SWISS MADISON	SM-1T25MB	E	E	E	E	..	ONE PIECE, FLOOR MOUNT TOILET, DUAL FLUSH 1.1/1.6 GPF
LAV-1	LAVATORY	WS BATH COLLECTIONS	LUXURY 60	E	E	E	E	E	8 IN. WIDESPREAD 2-HANDLE BATHROOM FAUCET WITH POP-UP ASSEMBLY IN MATE BLACK.
MS-1	MOP SINK	--	--	3"	3"	2"	3/4"	3/4"	PROVIDE A FAUCET W/VACUUM BREAKER, WALL BRACE, INTEGRAL STOPS.
DF-1	DRINKING FOUNTAIN	--	--	E	E	E	E	--	--
FD-E	FLOOR DRAIN - E	E	E	E	E	E	--	--	--

NOTE: CONTRACTOR TO COORDINATE WITH ARCHITECTURAL DRAWINGS ALL PLUMBING FIXTURES SPECIFICATIONS AND MOUNTING HEIGHT INSTALLATION.

**RECIRCULATING PUMP SCHEDULE**

TAG	SERVICE	GPM	TOTAL HEAD FT.	MOTOR HP	MANUFACTURER & REMARK
RCP-1	HW RECIRCULATION	2	10	0.115	GRUNDFOS UP 15-18 BUC5 W/AQUASTAT + TIMER

**EXPANSION TANK SCHEDULE**

ITEM	SERVICE	QTY.	GALLONS	MAKE	REMARKS
EXPANSION TANK (ET-1)	HOT WATER	1	2	AMTROL ST-5C-DD	DIMENSIONS- 14"(H) x 8"(DIA.) SHIPPING WEIGHT- 10 LBS

**ELECTRIC STORAGE WATER HEATER SCHEDULE**

TAG	MANUFACTURER AND MODEL NO.	STORAGE (GPH)	RECOVERY (GPH)	TEMP. RISE °F	APPROX. WEIGHT (LBS)	INPUT KW	ELECTRICAL INPUT	REMARKS
WH-2	AO SMITH DEL 20	20	18	90	73	4KW	208V/60HZ/3PH	DIMENSIONS- 22-1/4"(H) x 21-3/4"(DIA.) SHIPPING WEIGHT- 73 LBS

**THERMOSTATIC MIXING VALVE**

ITEM	QTY.	LOCATION	SERVICE	CAPACITY (GPM)	PRESSURE DROP (PSI)	MINIMUM FLOW (GPM)	MAKE	CW INLET	HIGH TEMP. INLET	LOW TEMP. OUTLET	REMARKS
MV-1	02	REFER PLAN	HOT WATER	17	5	1	LAWLER 801 OR EEQUAL	1/2"	1/2" (140°F)	1/2" (110°F)	-BRONZE BODY AND LEAD FREE CONSTRUCTION -ASSE CERTIFIED

**ELECTRIC INSTANTANEOUS WATER HEATER SCHEDULE**

TAG	MANUFACTURER	MODEL NO.	TEMP. RISE °F	QUANTITY	ELECTRICAL INPUT	INPUT KW	REMARKS
WH-1	CHRONOMITE	CMI-30L/208	85	1	208V/60HZ/1PH	6.24KW	DIMENSIONS- 6-1/4"(H) x 2-3/4"(DIA.)

Property of NY Engineers

PROJECT INFORMATION:

**KIDSUNITED**

DRAWING TITLE:

PLUMBING SCHEDULE

DRAWING NO.:

**P-4.0**