



NOTE:
 1. EXISTING DIFFUSERS, GRILLES, DUCTWORK, AC UNITS, RADIATORS, VAV BOXES, CONDENSATE PUMPS, CONDENSING DRAIN, CHILLED WATER PIPING, INLINE FANS LOCATION AND SIZES SHOWN ON PLAN ARE APPROXIMATE LOCATIONS, VERIFY ALL WITH FIELD CONDITIONS.

KEY NOTE:
 ◆ COORDINATE EXIST FLEX DUCT W/ DIFFUSERS BASED ON NEW CEILING PLAN

1 PARTIAL 3RD FLOOR MECHANICAL PLAN
 SCALE: 1/8" = 1'-0"

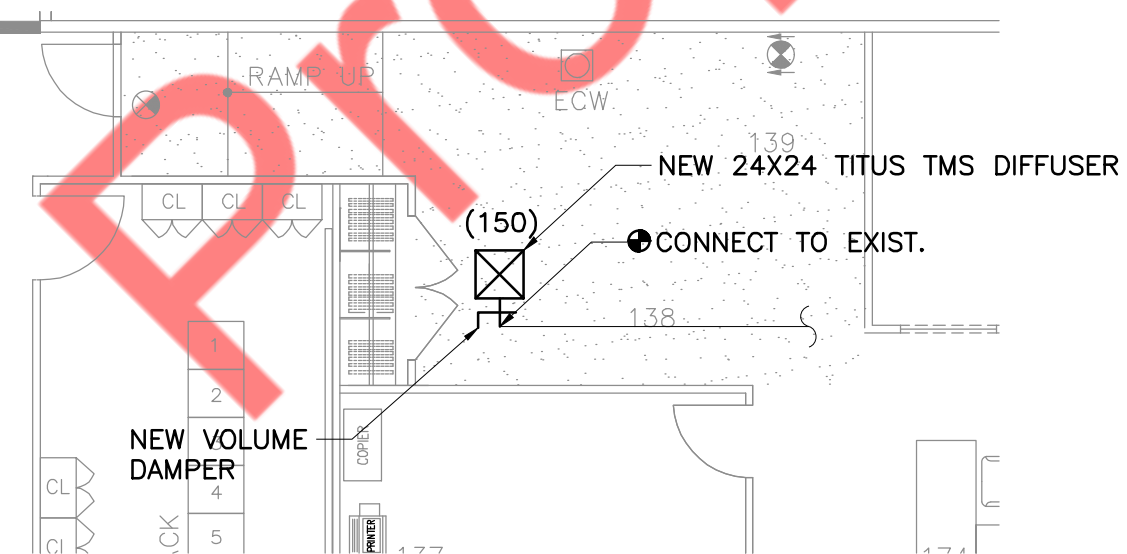


1 MECHANICAL ALTERNATE RECEPTION AREA
 SCALE: 1/8" = 1'-0"

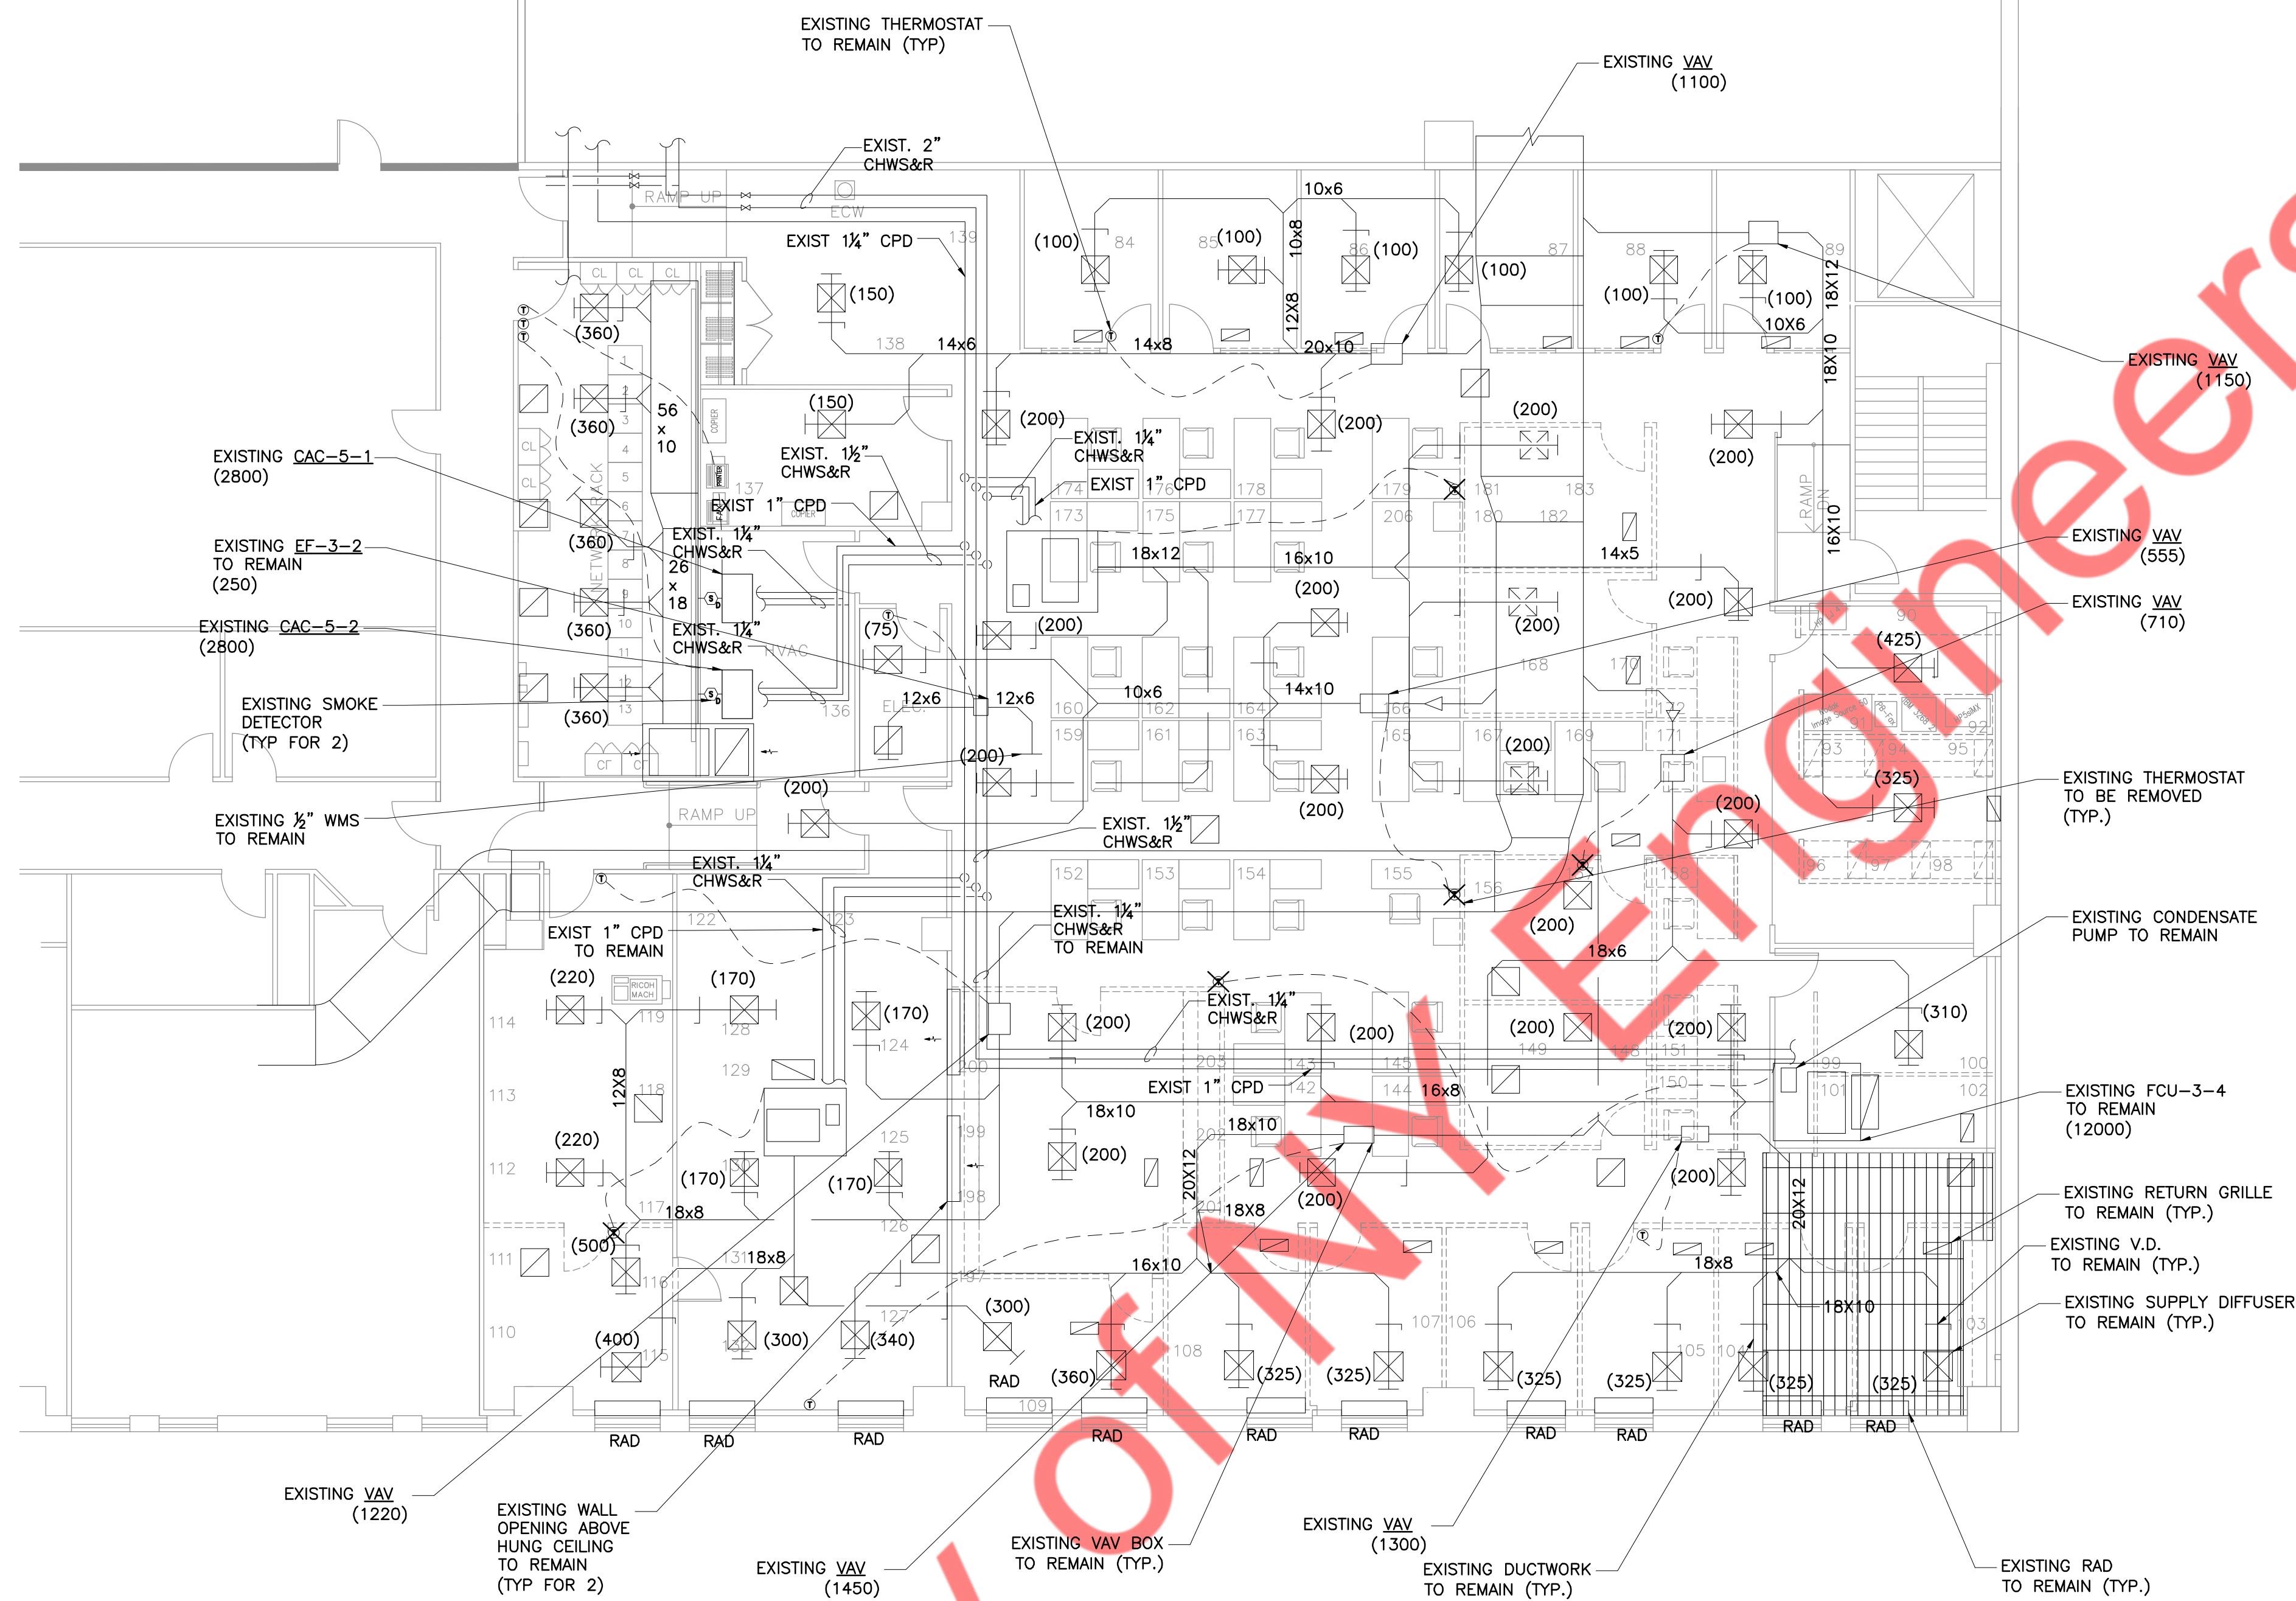

NOTE:
 1. EXISTING DIFFUSERS, GRILLES, DUCTWORK, AC UNITS, RADIATORS, VAV BOXES, CONDENSATE PUMPS, CONDENSING DRAIN, CHILLED WATER PIPING, INLINE FANS LOCATION AND SIZES SHOWN ON PLAN ARE APPROXIMATE LOCATIONS, VERIFY ALL WITH FIELD CONDITIONS.

1 PARTIAL 3RD FLOOR MECHANICAL DEMO PLAN
 SCALE: 1/8" = 1'-0"

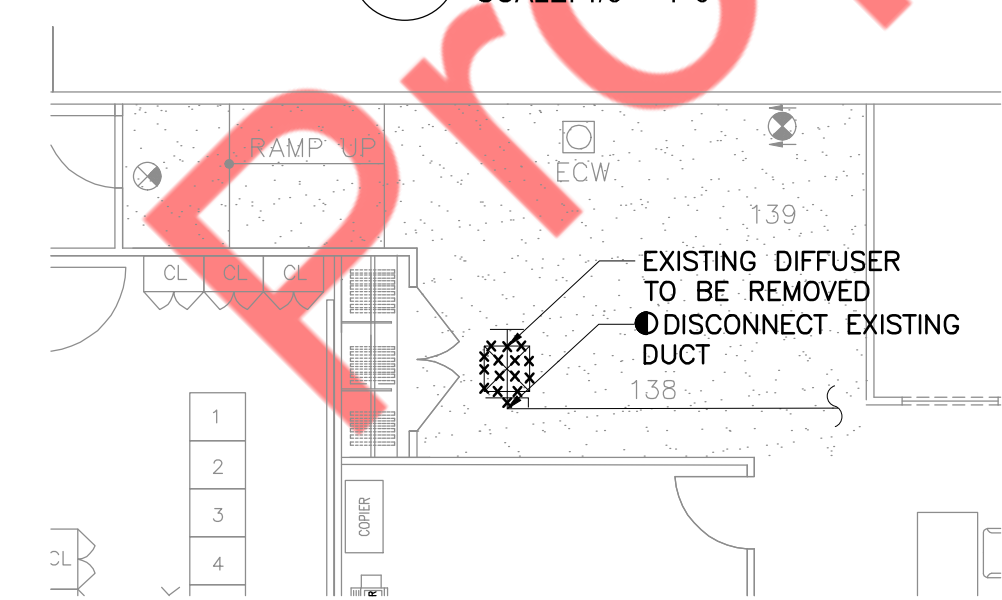

1 MECHANICAL ALTERNATE RECEPTION AREA
 SCALE: 1/8" = 1'-0"