



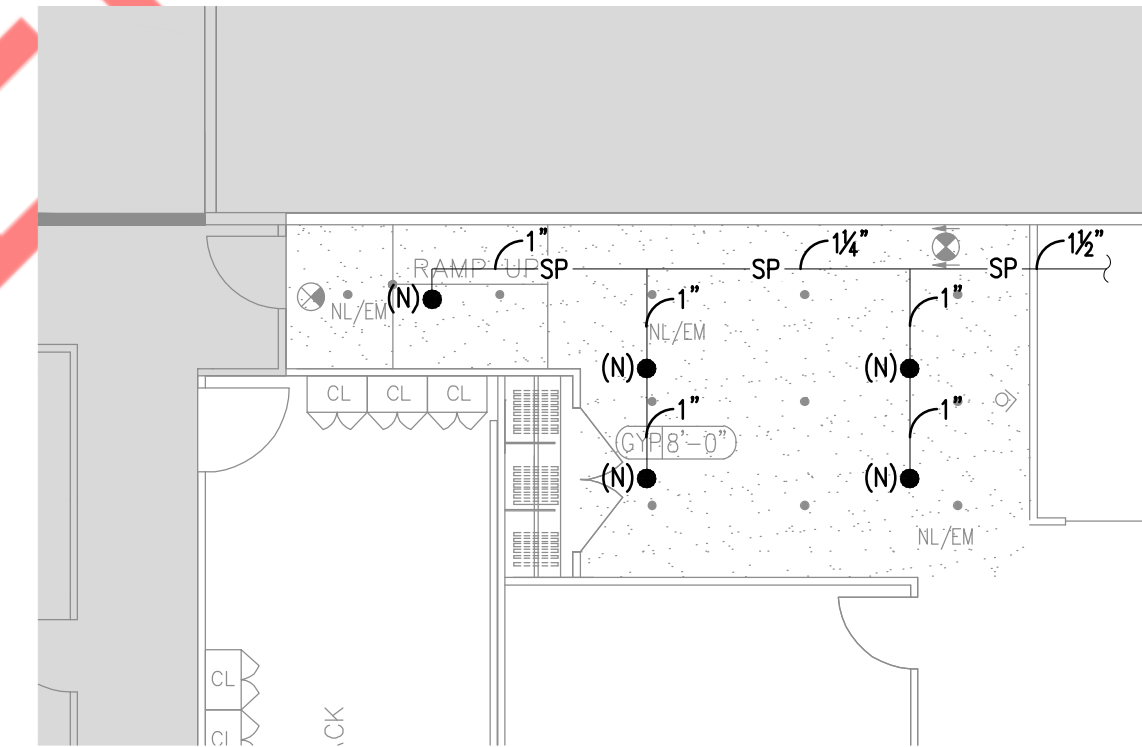

1 PARTIAL 3RD FLOOR SPRINKLER PLAN  
 SCALE: 1/8" = 1'-0"



1 SPRINKLER ALTERNATE RECEPTION AREA  
 SCALE: 1/8" = 1'-0"

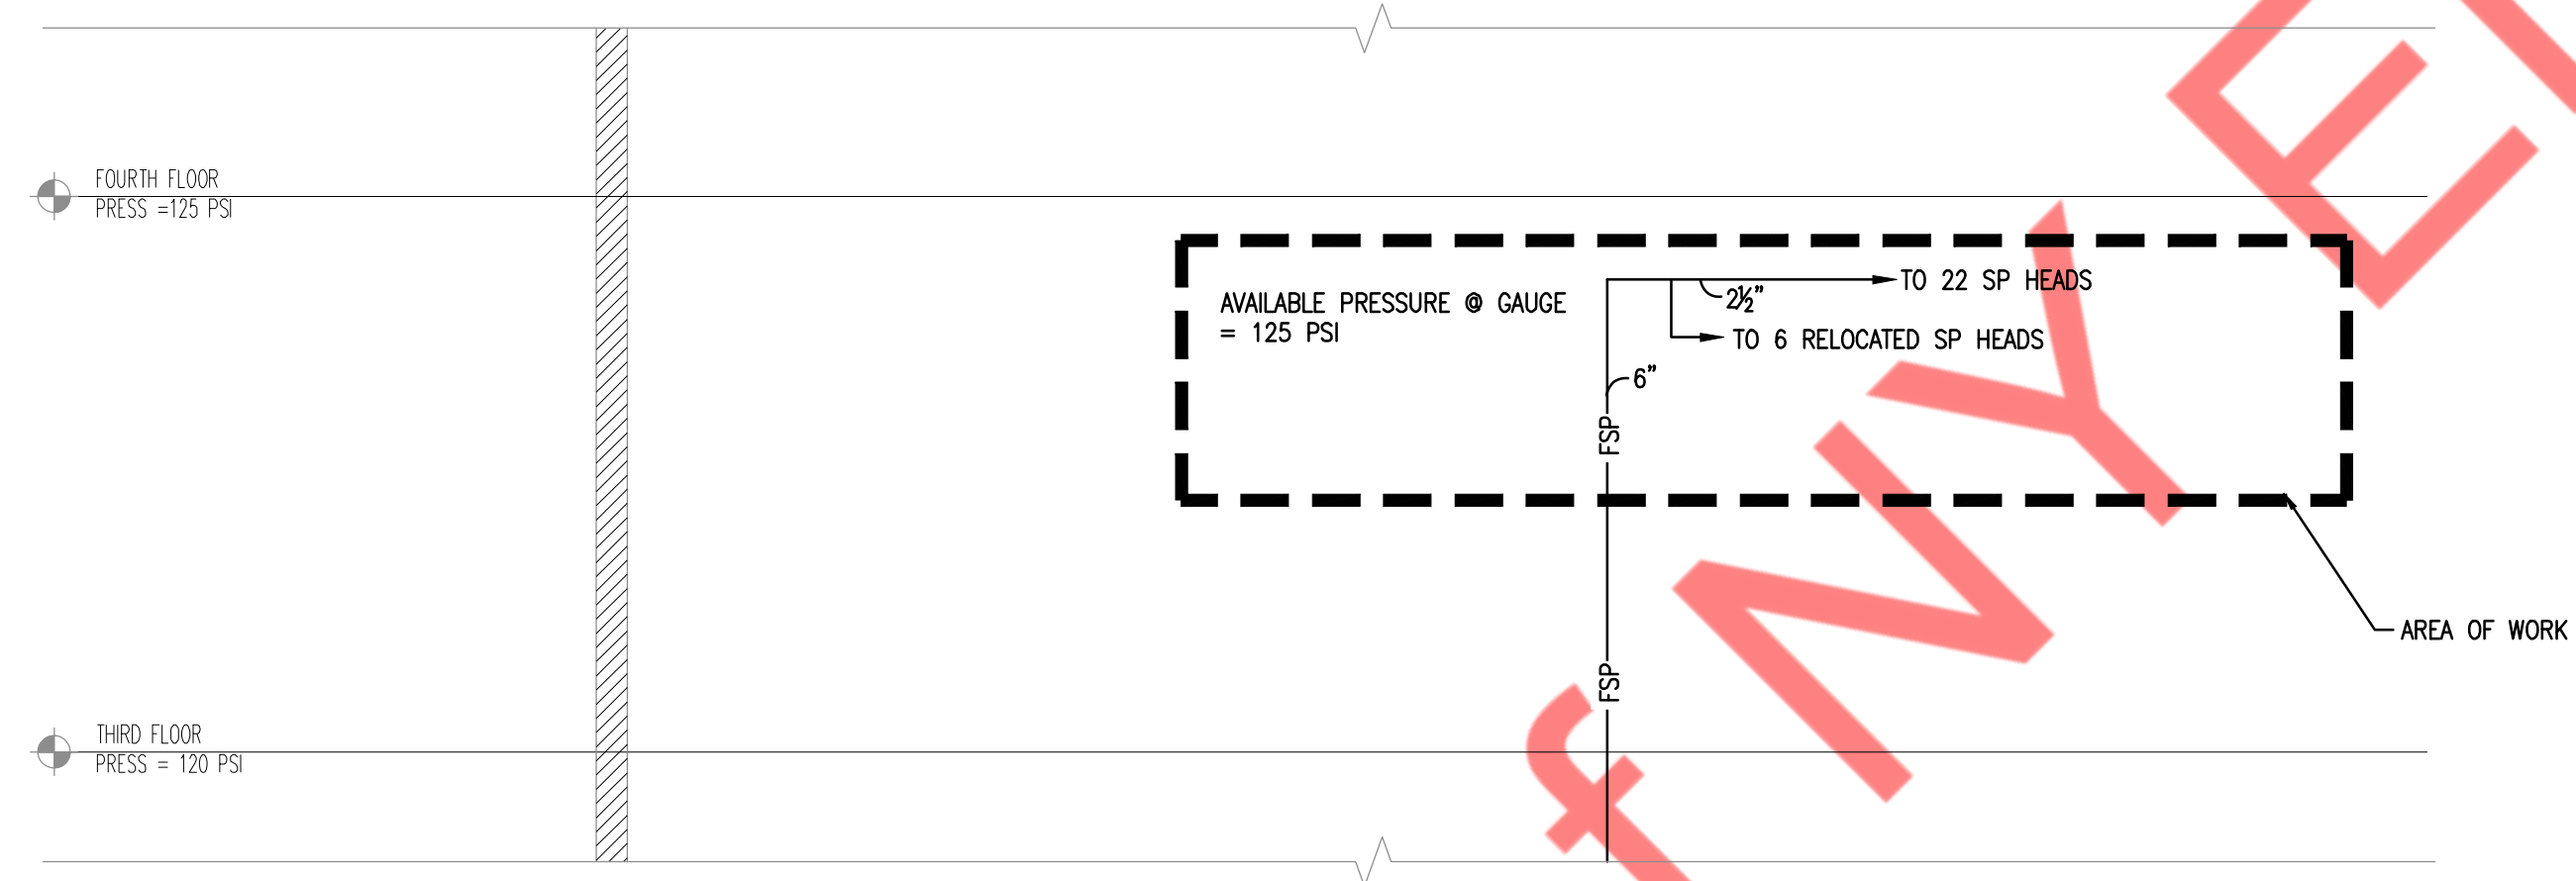

1 **SPRINKLER RISER DIAGRAM**  
SCALE: NTS

Property of NY Engineers