


F  
E  
D  
C  
B  
A

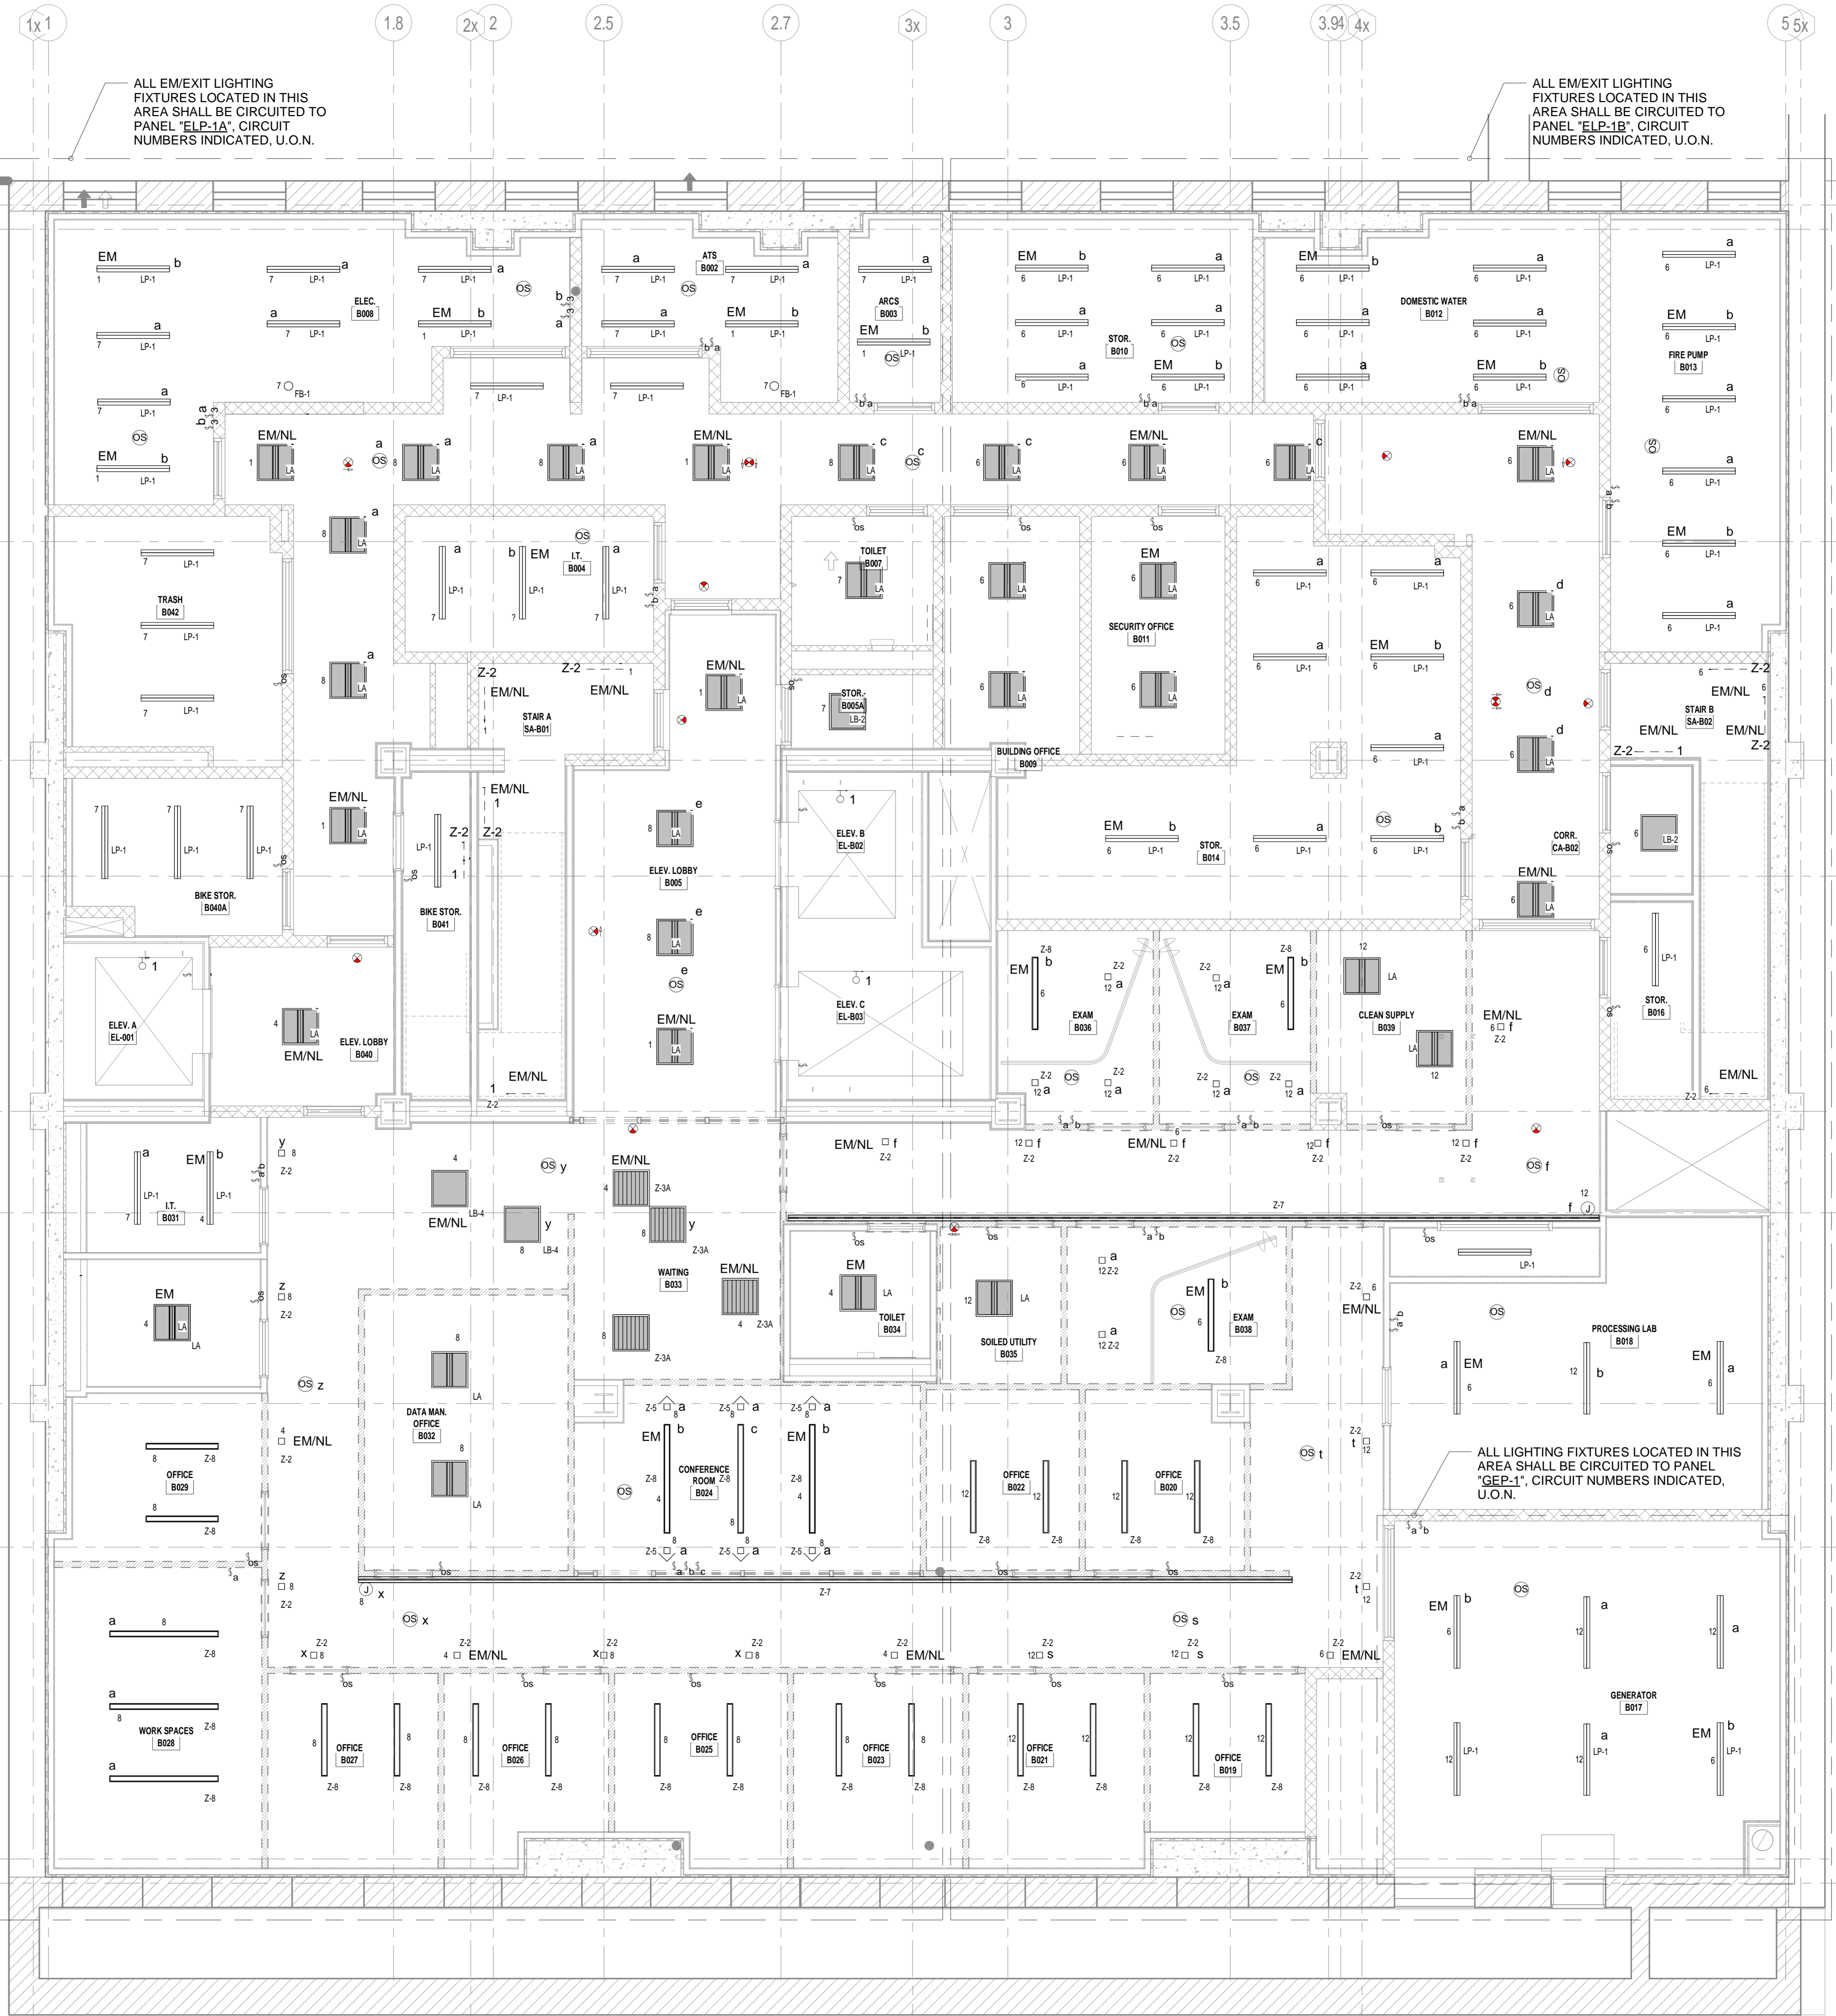

ALL EM/EXIT LIGHTING FIXTURES LOCATED IN THIS AREA SHALL BE CIRCUITED TO PANEL "ELP-1A", CIRCUIT NUMBERS INDICATED, U.O.N.


ALL EM/EXIT LIGHTING FIXTURES LOCATED IN THIS AREA SHALL BE CIRCUITED TO PANEL "ELP-1B", CIRCUIT NUMBERS INDICATED, U.O.N.

**LIGHTING DRAWING NOTES:**

1. REFER TO DWG. E-001.00 FOR ELECTRICAL GENERAL NOTES, SYMBOL LIST, ABBREVIATIONS AND LIGHTING FIXTURE SCHEDULE.
2. CIRCUITING FOR LIGHTING FIXTURES IN ROOMS WITH TOGGLE SWITCHES SHALL BE CONTROLLED BY DESIGNATED SWITCHES. IF SPECIFIC DESIGNATION IS NOT INDICATED, ALL LIGHTING FIXTURES IN ROOM/AREA SHALL BE CONTROLLED BY THE SWITCH INDICATED.
3. COORDINATE WITH ARCHITECTURE PLANS FOR FINAL SWITCH LOCATIONS.
4. TURN ON ALL LIGHTS IN THE CORRIDOR, WAITING AND RECEPTION AREA WITH ACTUATION OF ANY OCCUPANCY SENSOR.
5. USE UL924 OVERRIDE SWITCH FOR EVERY EMERGENCY CIRCUIT IN ENCLOSED SPACE AS INDICATED ON PLANS.

1) CELLAR LIGHTING PLAN  
1/4" = 1'-0"



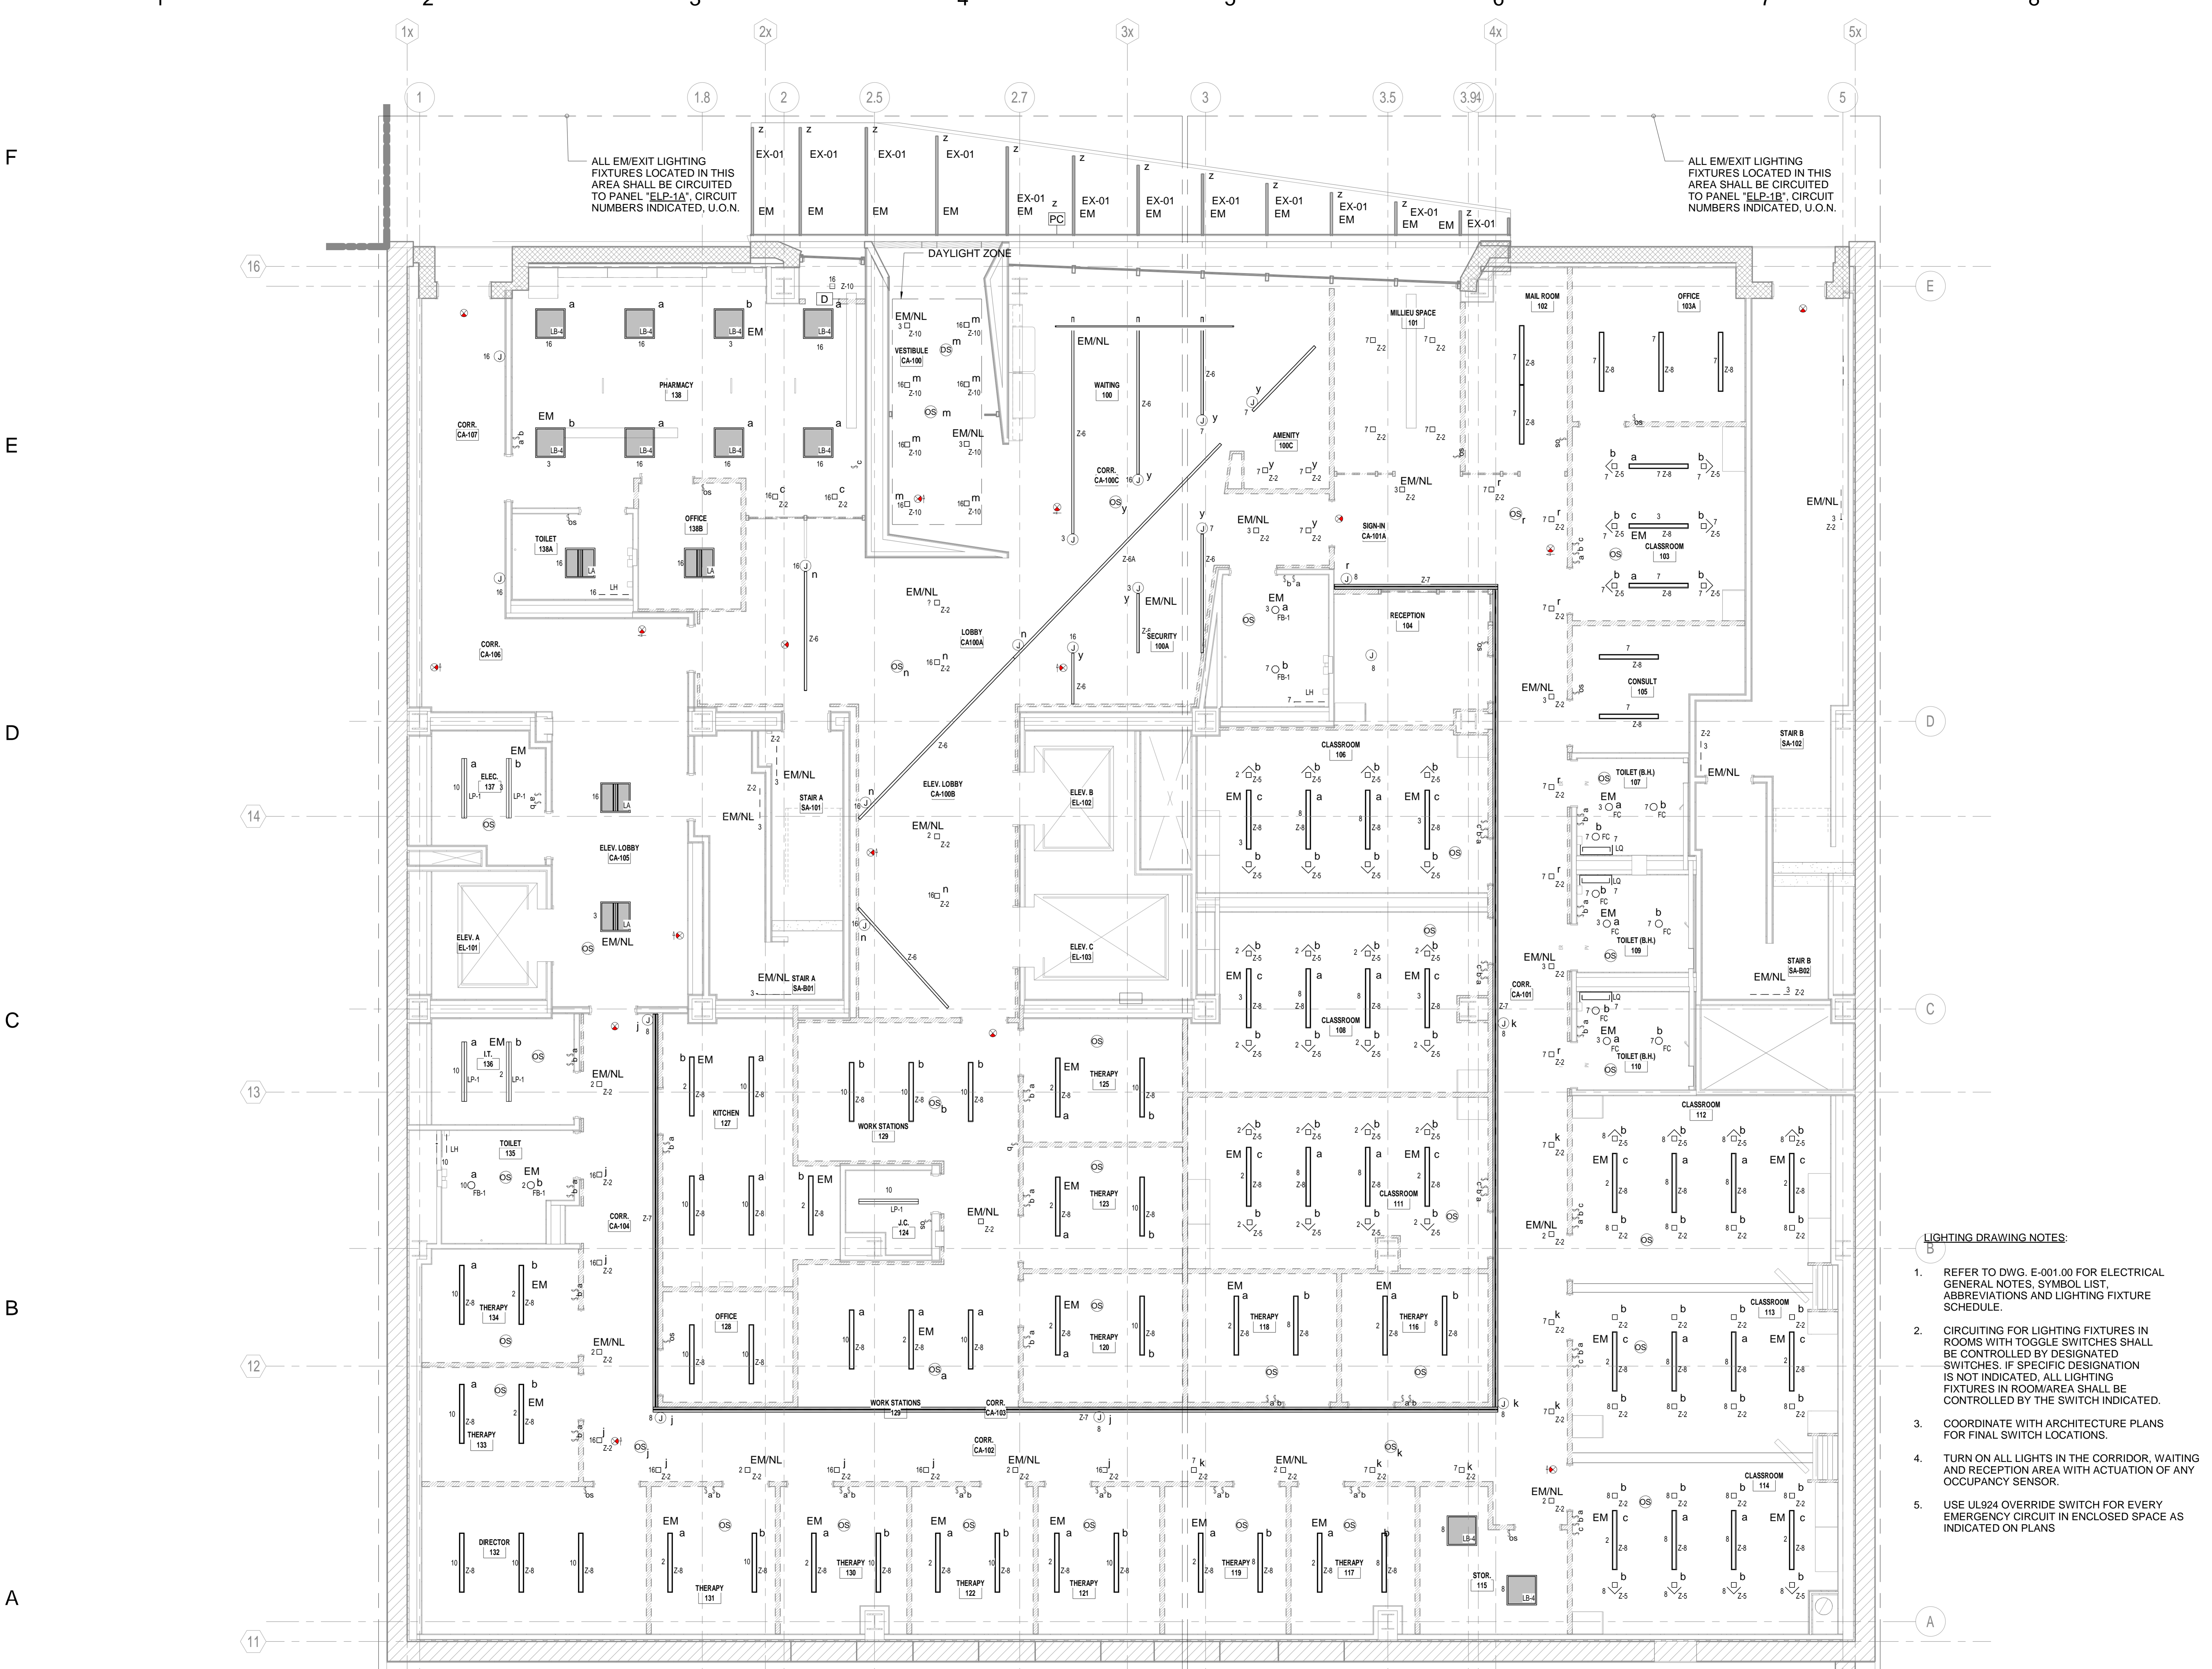

ALL EM/EXIT LIGHTING FIXTURES LOCATED IN THIS AREA SHALL BE CIRCUITED TO PANEL "ELP-1A", CIRCUIT NUMBERS INDICATED, U.O.N.

ALL EM/EXIT LIGHTING FIXTURES LOCATED IN THIS AREA SHALL BE CIRCUITED TO PANEL "ELP-1B", CIRCUIT NUMBERS INDICATED, U.O.N.

**LIGHTING DRAWING NOTES:**

1. REFER TO DWG. E-001.00 FOR ELECTRICAL GENERAL NOTES, SYMBOL LIST, ABBREVIATIONS AND LIGHTING FIXTURE SCHEDULE.
2. CIRCUITING FOR LIGHTING FIXTURES IN ROOMS WITH TOGGLE SWITCHES SHALL BE CONTROLLED BY DESIGNATED SWITCHES. IF SPECIFIC DESIGNATION IS NOT INDICATED, ALL LIGHTING FIXTURES IN ROOM/AREA SHALL BE CONTROLLED BY THE SWITCH INDICATED.
3. COORDINATE WITH ARCHITECTURE PLANS FOR FINAL SWITCH LOCATIONS.
4. TURN ON ALL LIGHTS IN THE CORRIDOR, WAITING AND RECEPTION AREA WITH ACTUATION OF ANY OCCUPANCY SENSOR.
5. USE UL924 OVERRIDE SWITCH FOR EVERY EMERGENCY CIRCUIT IN ENCLOSED SPACE AS INDICATED ON PLANS

1 FIRST FLOOR LIGHTING PLAN  
1/4" = 1'-0"



F  
E  
D  
C  
B  
A



ALL EM/EXIT LIGHTING FIXTURES LOCATED IN THIS AREA SHALL BE CIRCUITED TO PANEL "ELP-1A", CIRCUIT NUMBERS INDICATED, U.O.N.

ALL EM/EXIT LIGHTING FIXTURES LOCATED IN THIS AREA SHALL BE CIRCUITED TO PANEL "ELP-1B", CIRCUIT NUMBERS INDICATED, U.O.N.

- LIGHTING DRAWING NOTES:**
- REFER TO DWG. E-001.00 FOR ELECTRICAL GENERAL NOTES, SYMBOL LIST, ABBREVIATIONS AND LIGHTING FIXTURE SCHEDULE.
  - CIRCUITING FOR LIGHTING FIXTURES IN ROOMS WITH TOGGLE SWITCHES SHALL BE CONTROLLED BY DESIGNATED SWITCHES. IF SPECIFIC DESIGNATION IS NOT INDICATED, ALL LIGHTING FIXTURES IN ROOM/AREA SHALL BE CONTROLLED BY THE SWITCH INDICATED.
  - COORDINATE WITH ARCHITECTURE PLANS FOR FINAL SWITCH LOCATIONS.
  - TURN ON ALL LIGHTS IN THE CORRIDOR, WAITING AND RECEPTION AREA WITH ACTUATION OF ANY OCCUPANCY SENSOR.
  - USE UL924 OVERRIDE SWITCH FOR EVERY EMERGENCY CIRCUIT IN ENCLOSED SPACE AS INDICATED ON PLANS.

1 SECOND FLOOR LIGHTING PLAN  
1/4" = 1'-0"