

1 1ST FLOOR ELECTRICAL POWER PLAN
1/4" = 1'-0"



2 CELLAR ELECTRICAL POWER PLAN
1/4" = 1'-0"

ELECTRICAL LEGEND:


- 1. CONED PROPERTY LINE BOX. CONED SHALL BRING UTILITY WIRES TO THIS LOCATION & TERMINATE TO CUSTOMERS WIRES.
- 2. WALL MOUNTED 200A ELECTRIC METER AND DISCONNECT SWITCH STACKED
- 3. 200A-SINGLE PHASE RECESSED PANEL
- 4. INCOMING (1) 2" TELECOME CONDUIT

POWER DRAWING NOTES:

1. REFER TO DWG E-001.00 FOR ELECTRICAL GENERAL NOTES, SYMBOL LIST, & ABBREVIATIONS. E-003.00 & E-004.00 FOR ADDITIONAL ELECTRICAL SPECIFICATIONS.

KEYED WORK NOTE:

- A. PROVIDE NEMA 3R ENCLOSURE FOR OUTDOOR DISCONNECT SWITCH AND METER.

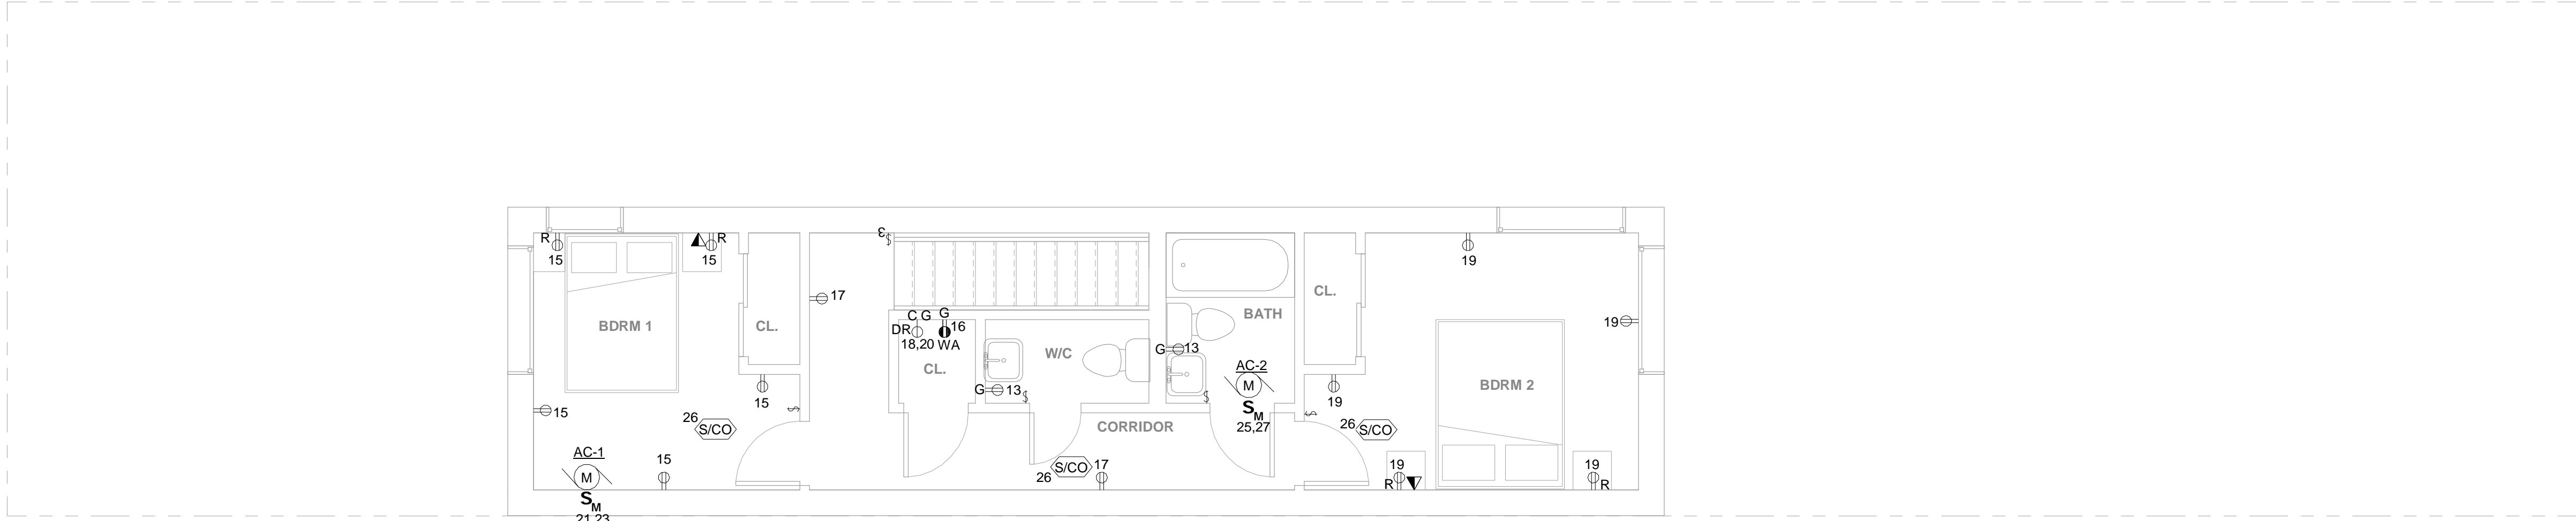

1 2ND FLOOR ELECTRICAL POWER PLAN
1/4" = 1'-0"

POWER DRAWING NOTES:

1. REFER TO DWG E-001.00 FOR ELECTRICAL GENERAL NOTES, SYMBOL LIST, & ABBREVIATIONS. E-003.00 & E-004.00 FOR ADDITIONAL ELECTRICAL SPECIFICATIONS.