


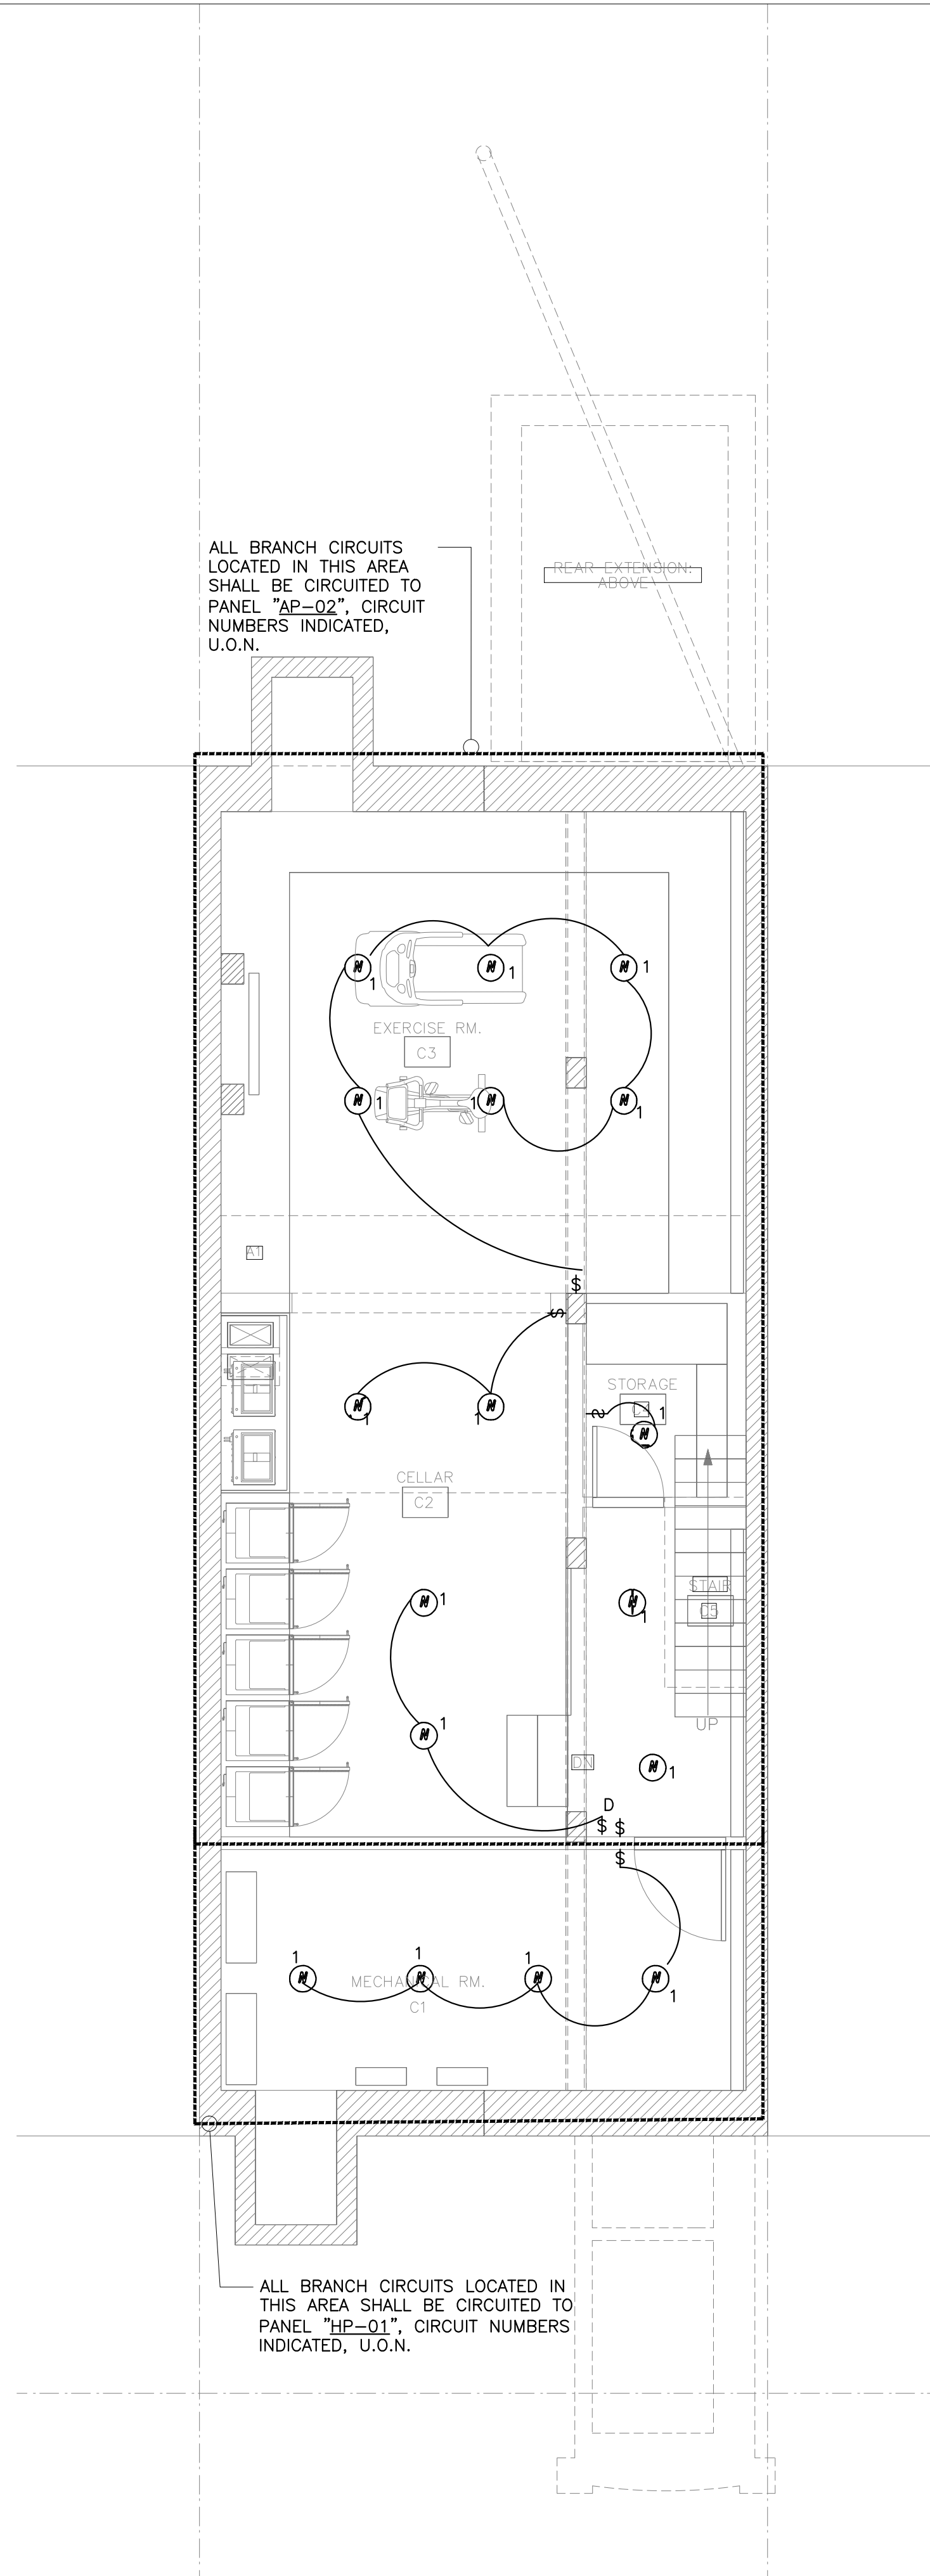


1 CELLAR LIGHTING PLAN  
SCALE: 1/4"=1'-0"

ALL BRANCH CIRCUITS LOCATED IN THIS AREA SHALL BE CIRCUITED TO PANEL "HP-Q1", CIRCUIT NUMBERS INDICATED, U.O.N.

ALL BRANCH CIRCUITS LOCATED IN THIS AREA SHALL BE CIRCUITED TO PANEL "AP-Q2", CIRCUIT NUMBERS INDICATED, U.O.N.

ALL BRANCH CIRCUITS LOCATED IN THIS AREA SHALL BE CIRCUITED TO PANEL "AP-Q1", CIRCUIT NUMBERS INDICATED, U.O.N.

ALL BRANCH CIRCUITS LOCATED IN THIS AREA SHALL BE CIRCUITED TO PANEL "HP-Q1", CIRCUIT NUMBERS INDICATED, U.O.N.

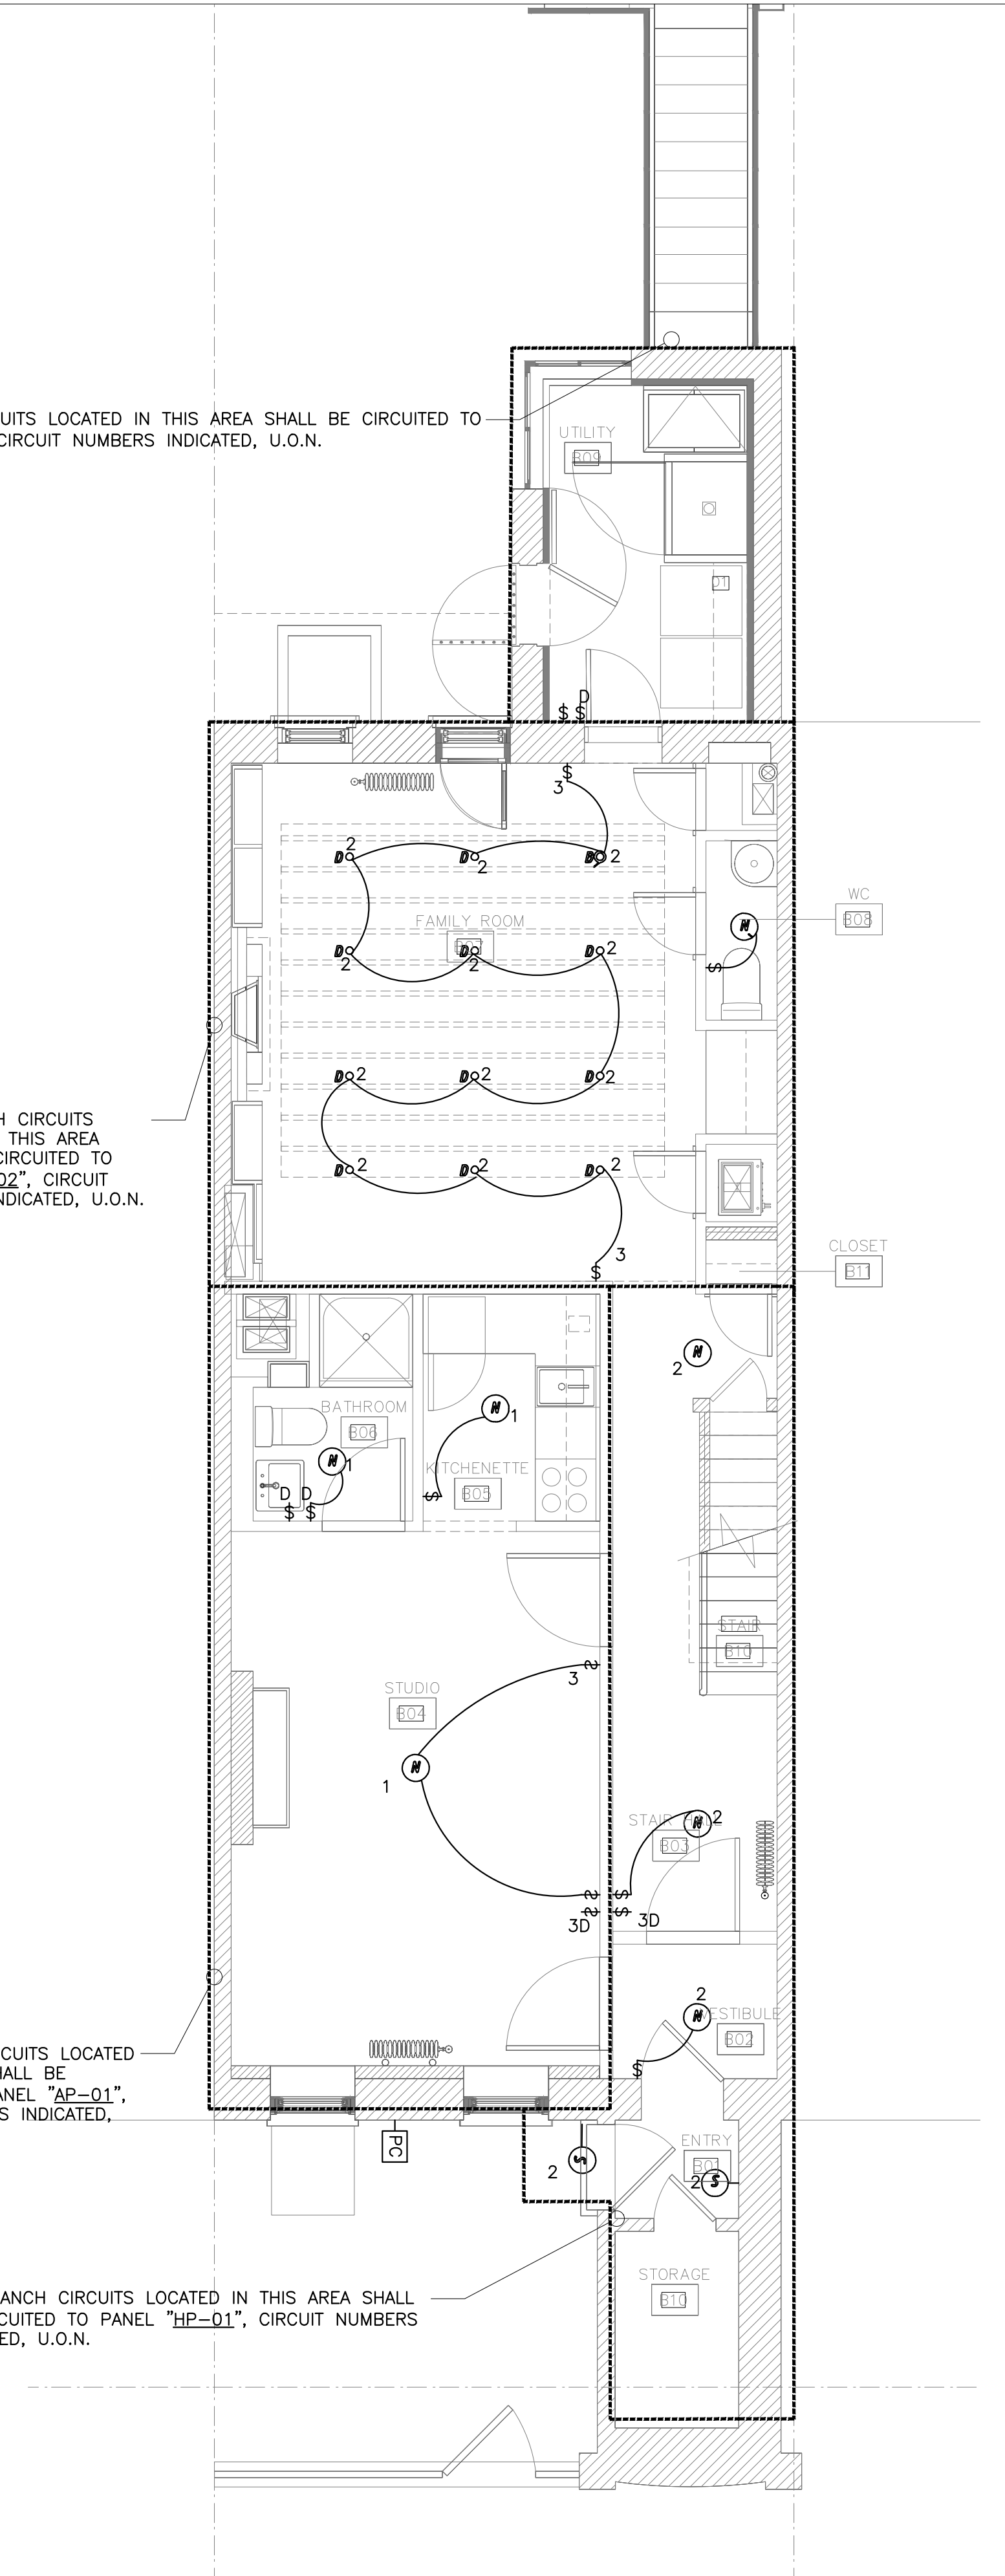

2 BASMENT LIGHTING PLAN  
SCALE: 1/4"=1'-0"



### 3 1ST FLOOR LIGHTING PLAN

SCALE: 1/4"=1'-0"



ALL BRANCH CIRCUITS LOCATED IN THIS AREA SHALL BE CIRCUITED TO PANEL "AP-02", CIRCUIT NUMBERS INDICATED, U.O.N.

4 2ND FLOOR LIGHTING PLAN  
SCALE: 1/4"=1'-0"




## ELECTRICAL KEYED NOTE

- 1 SERVICE END BOX CON-ED SPEC EP-9525-B (400A)
- 2 200A DISCONNECT SWITCH AND METER STACKED
- 3 100A DISCONNECT SWITCH AND METER STACKED
- 4 60A DISCONNECT SWITCH AND METER STACKED
- 5 60A DISCONNECT SWITCH FOR FUTURE SOLAR SYSTEM
- 6 CONTRACTOR TO FIELD VERIFY THE EXACT LOCATION OF POE ON SITE.
- 7 INSTALL 4"x12 $\frac{1}{2}$ " COPPER GROUND BAR WITH INSULATED STANDOFFS AND PRE-DRILLED WITH  $\frac{1}{4}$ " HOLES IN LEFT REAR CORNER.

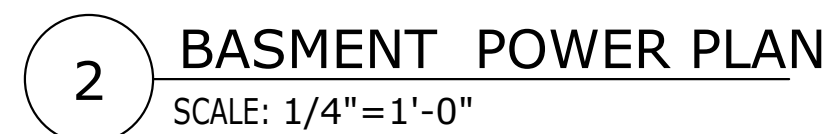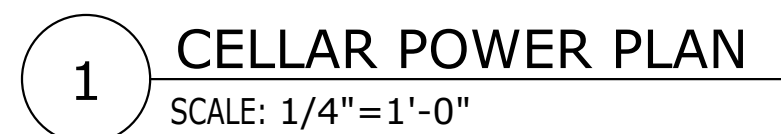




ALL BRANCH CIRCUITS LOCATED IN THIS AREA SHALL BE CIRCUITED TO PANEL "AP-02", CIRCUIT NUMBERS INDICATED, U.O.N.

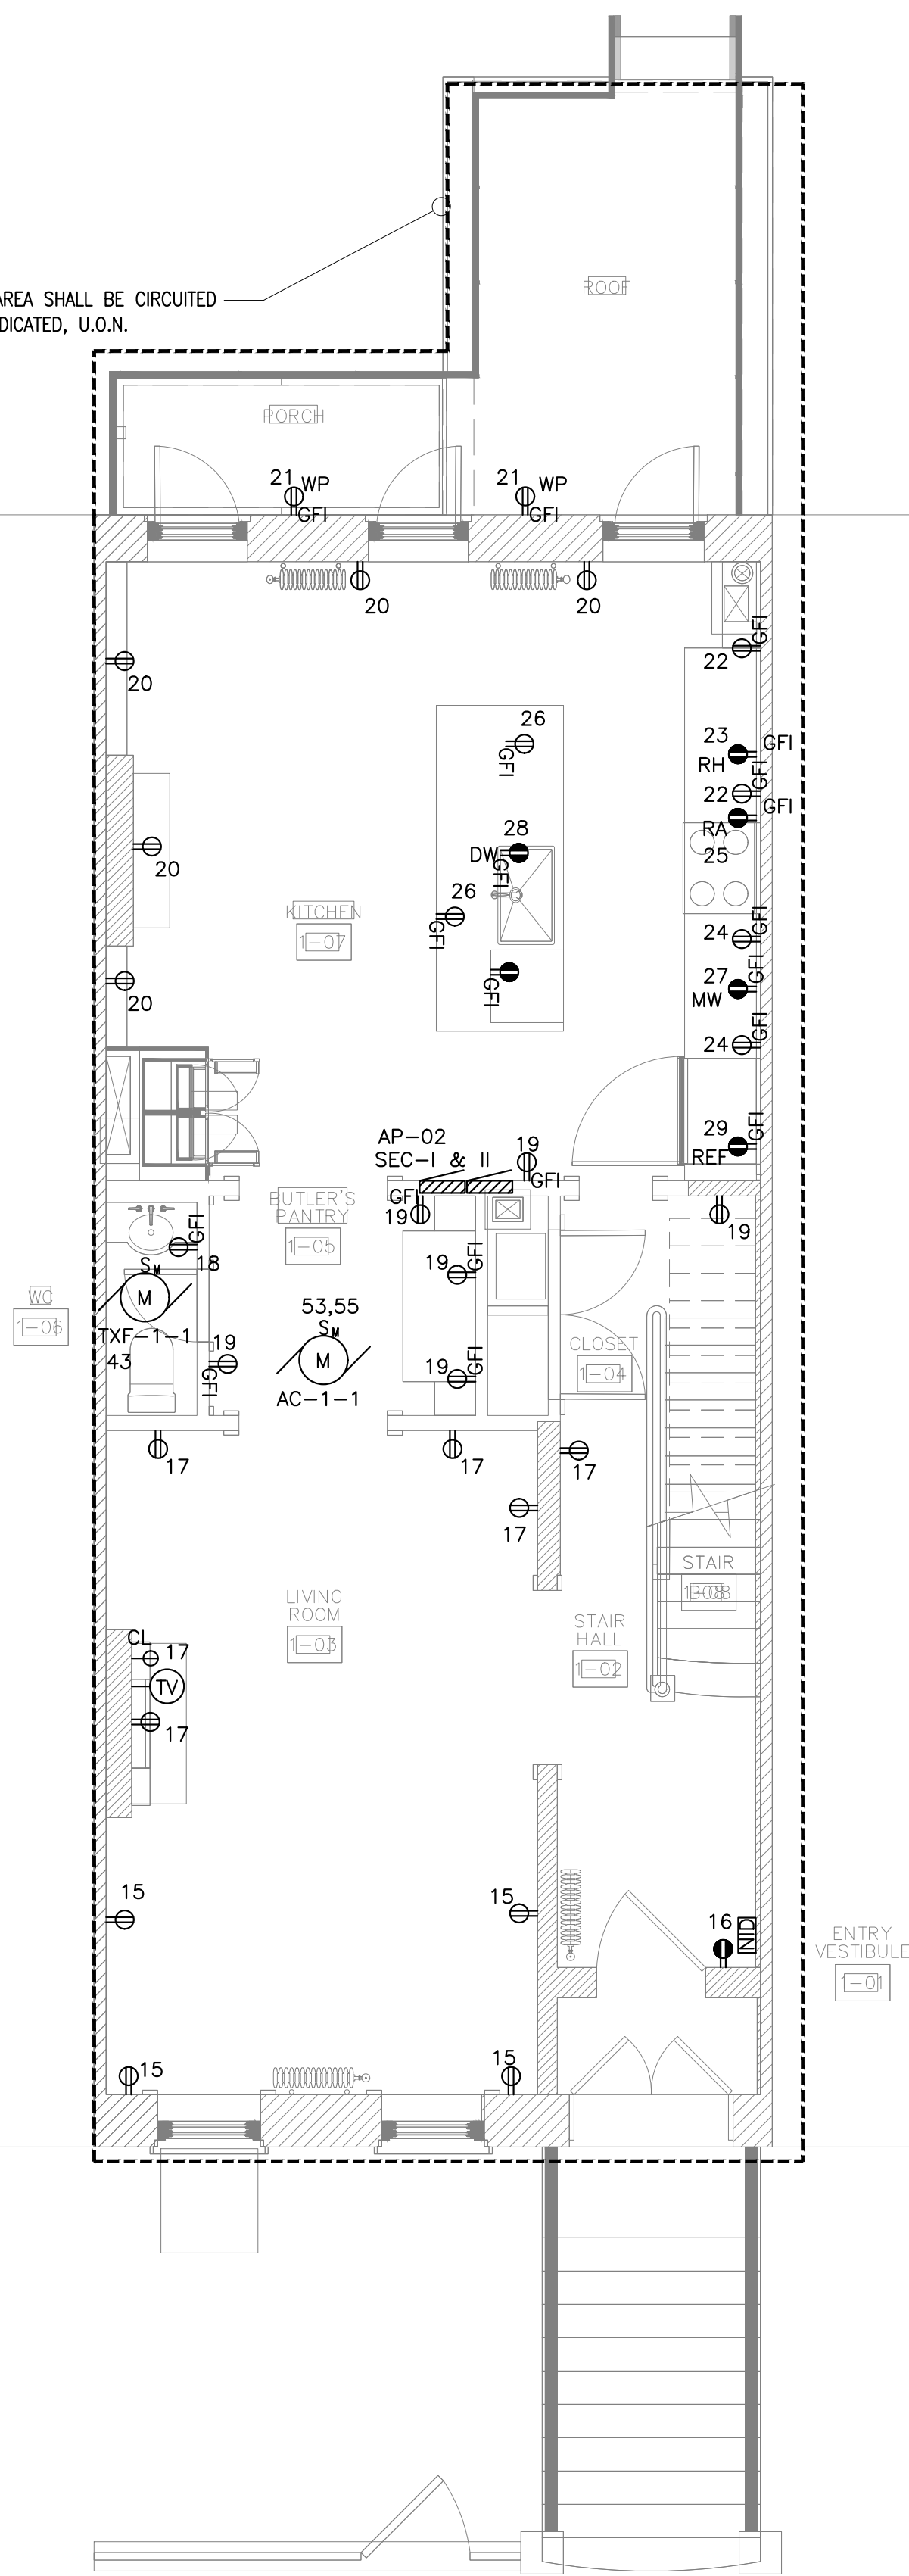


3 1ST FLOOR POWER PLAN  
SCALE: 1/4"=1'-0"

ALL BRANCH CIRCUITS LOCATED IN THIS AREA SHALL BE CIRCUITED TO PANEL "AP-02", CIRCUIT NUMBERS INDICATED, U.O.N.

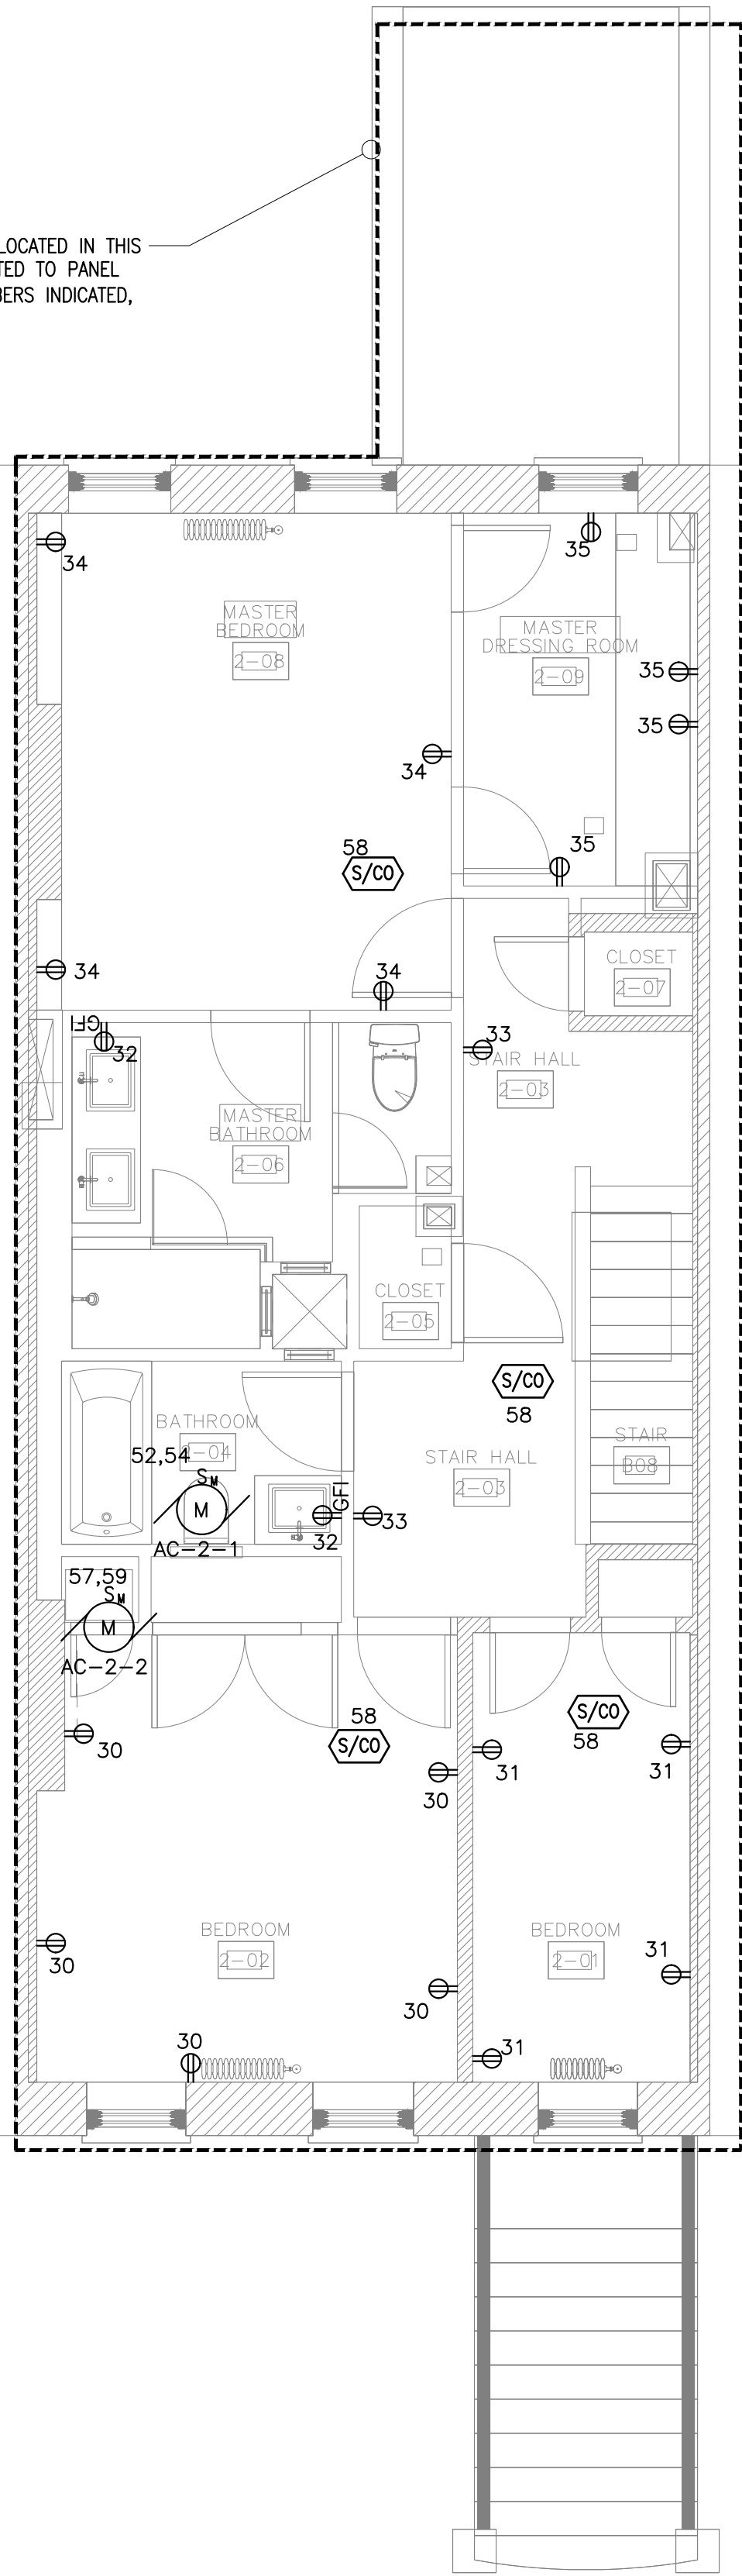

4 2ND FLOOR POWER PLAN  
SCALE: 1/4"=1'-0"

ALL BRANCH CIRCUITS LOCATED IN THIS AREA SHALL BE CIRCUITED TO PANEL "AP-02", CIRCUIT NUMBERS INDICATED, U.O.N.

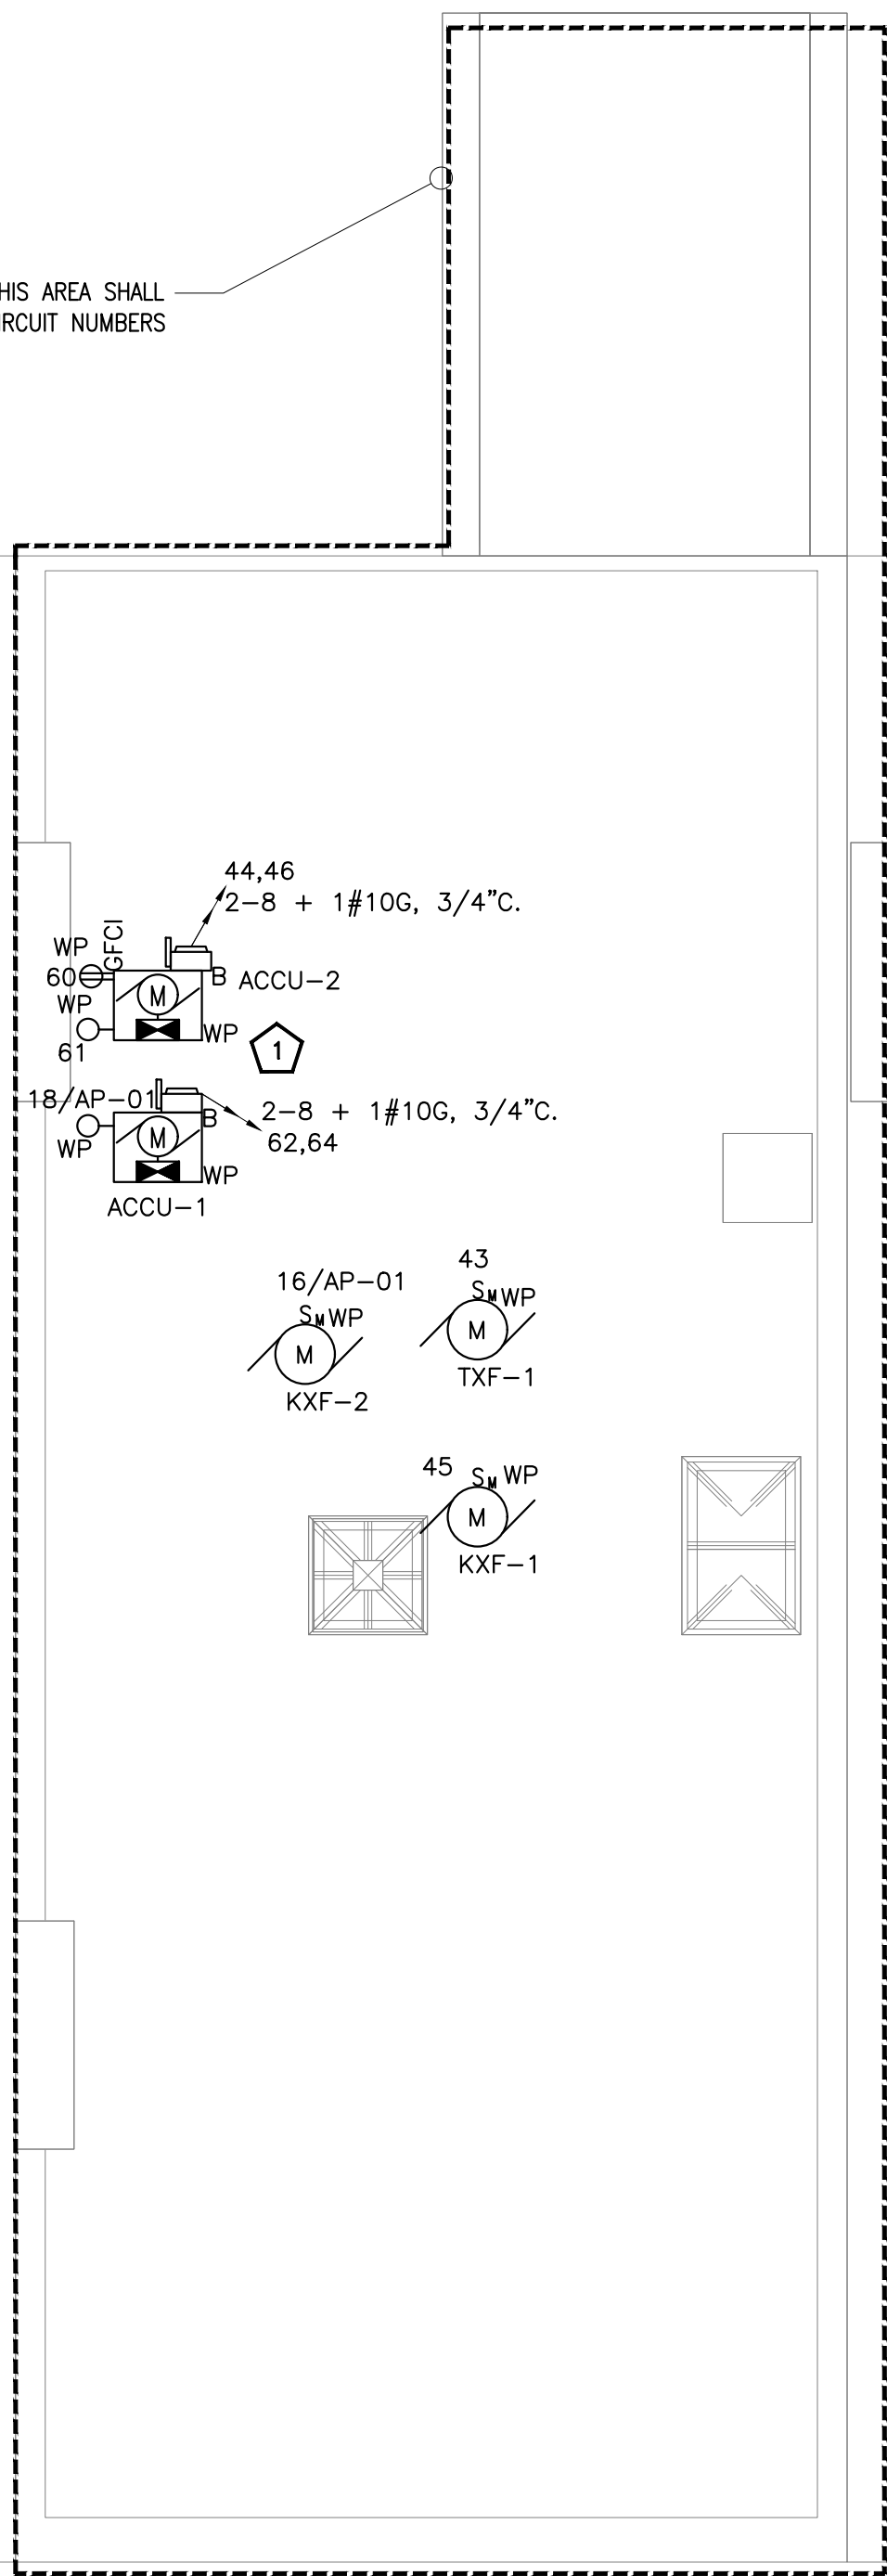

KEYED NOTE

1 LIGHT FIXTURE WITH LOCAL SWITCH FOR MANUAL ON/OFF ARE MOUNTED ON KINDORF SUPPORT

ELECTRICAL POWER NOTE

ALL RECEPTACLES IN DWELLING UNIT SHALL BE TAMPER RESISTANT

5 ROOF POWER PLAN  
SCALE: 1/4"=1'-0"