


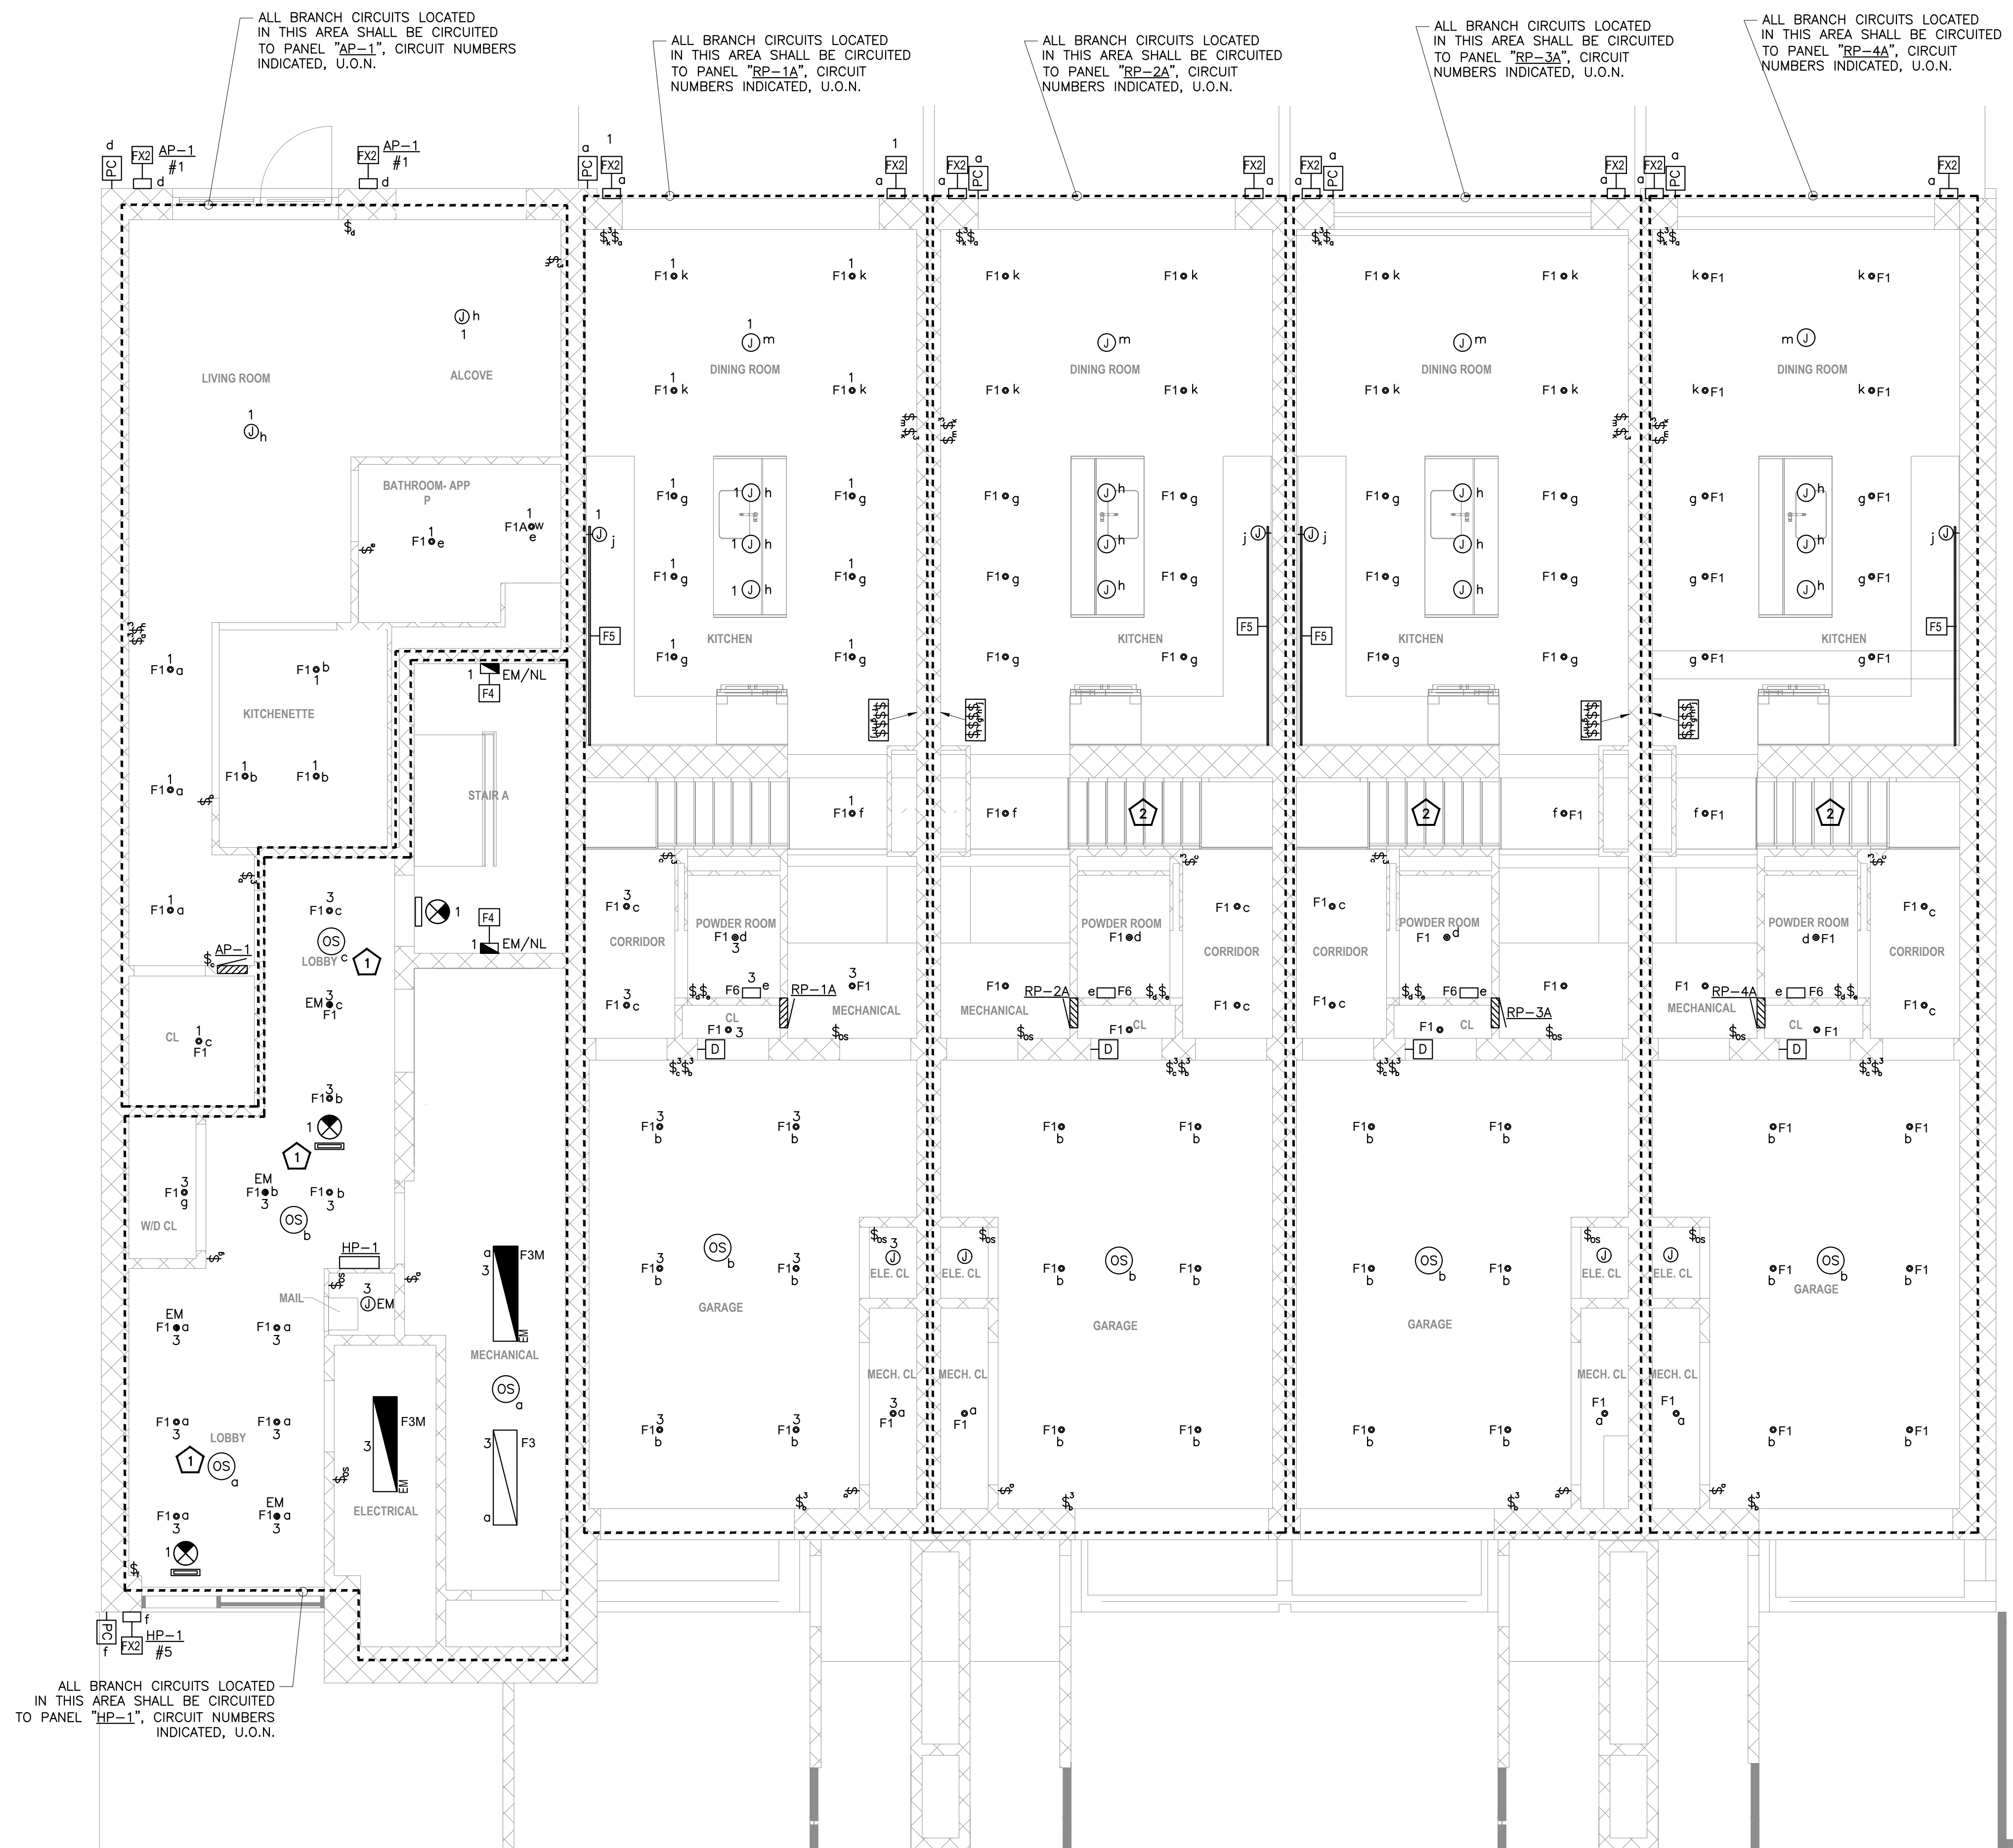

1 GROUND FLOOR LIGHTING PLAN
SCALE: 1/4"=1'-0"




1 **2ND FLOOR LIGHTING PLAN**
SCALE: 1/4"=1'-0"

KEYED WORK NOTES:

- 1 ALL BRANCH CIRCUITS HOMERUNS ASSIGN INDICATED ON THIS AREA SHALL BE CIRCUITED TO PANEL "HP-1" CIRCUIT NUMBER INDICATED, U.O.N.
- 2 REFER TYPICAL TOWNHOUSE "T1" FOR LIGHTING CIRCUITING. REFER PANEL SCHEDULE ON SHEET E-601.00.

LIGHTING DRAWING NOTES:

- 1. REFER TO DWG. E-001.00 FOR ELECTRICAL GENERAL NOTES, SYMBOL LIST AND ABBREVIATIONS.
- 2. CIRCUITING FOR LIGHTING FIXTURES IN ROOMS WITH TOGGLE SWITCHES SHALL BE CONTROLLED BY DESIGNATED SWITCHES. IF SPECIFIC DESIGNATION IS NOT INDICATED, ALL LIGHTING FIXTURES IN ROOM/AREA SHALL BE CONTROLLED BY THE SWITCH INDICATED.
- 3. REFER DWG. E-001.00 FOR LIGHT FIXTURE SCHEDULE & LIGHTING CONTROL SCHEDULE.
- 4. ALL F4-EM/NL FIXTURES IN STAIR-CASE OF MIH BUILDING TO HAVE BUILT IN OCCUPANCY SENSOR TO AUTOMATICALLY TURN ON/OFF LIGHT FIXTURES.

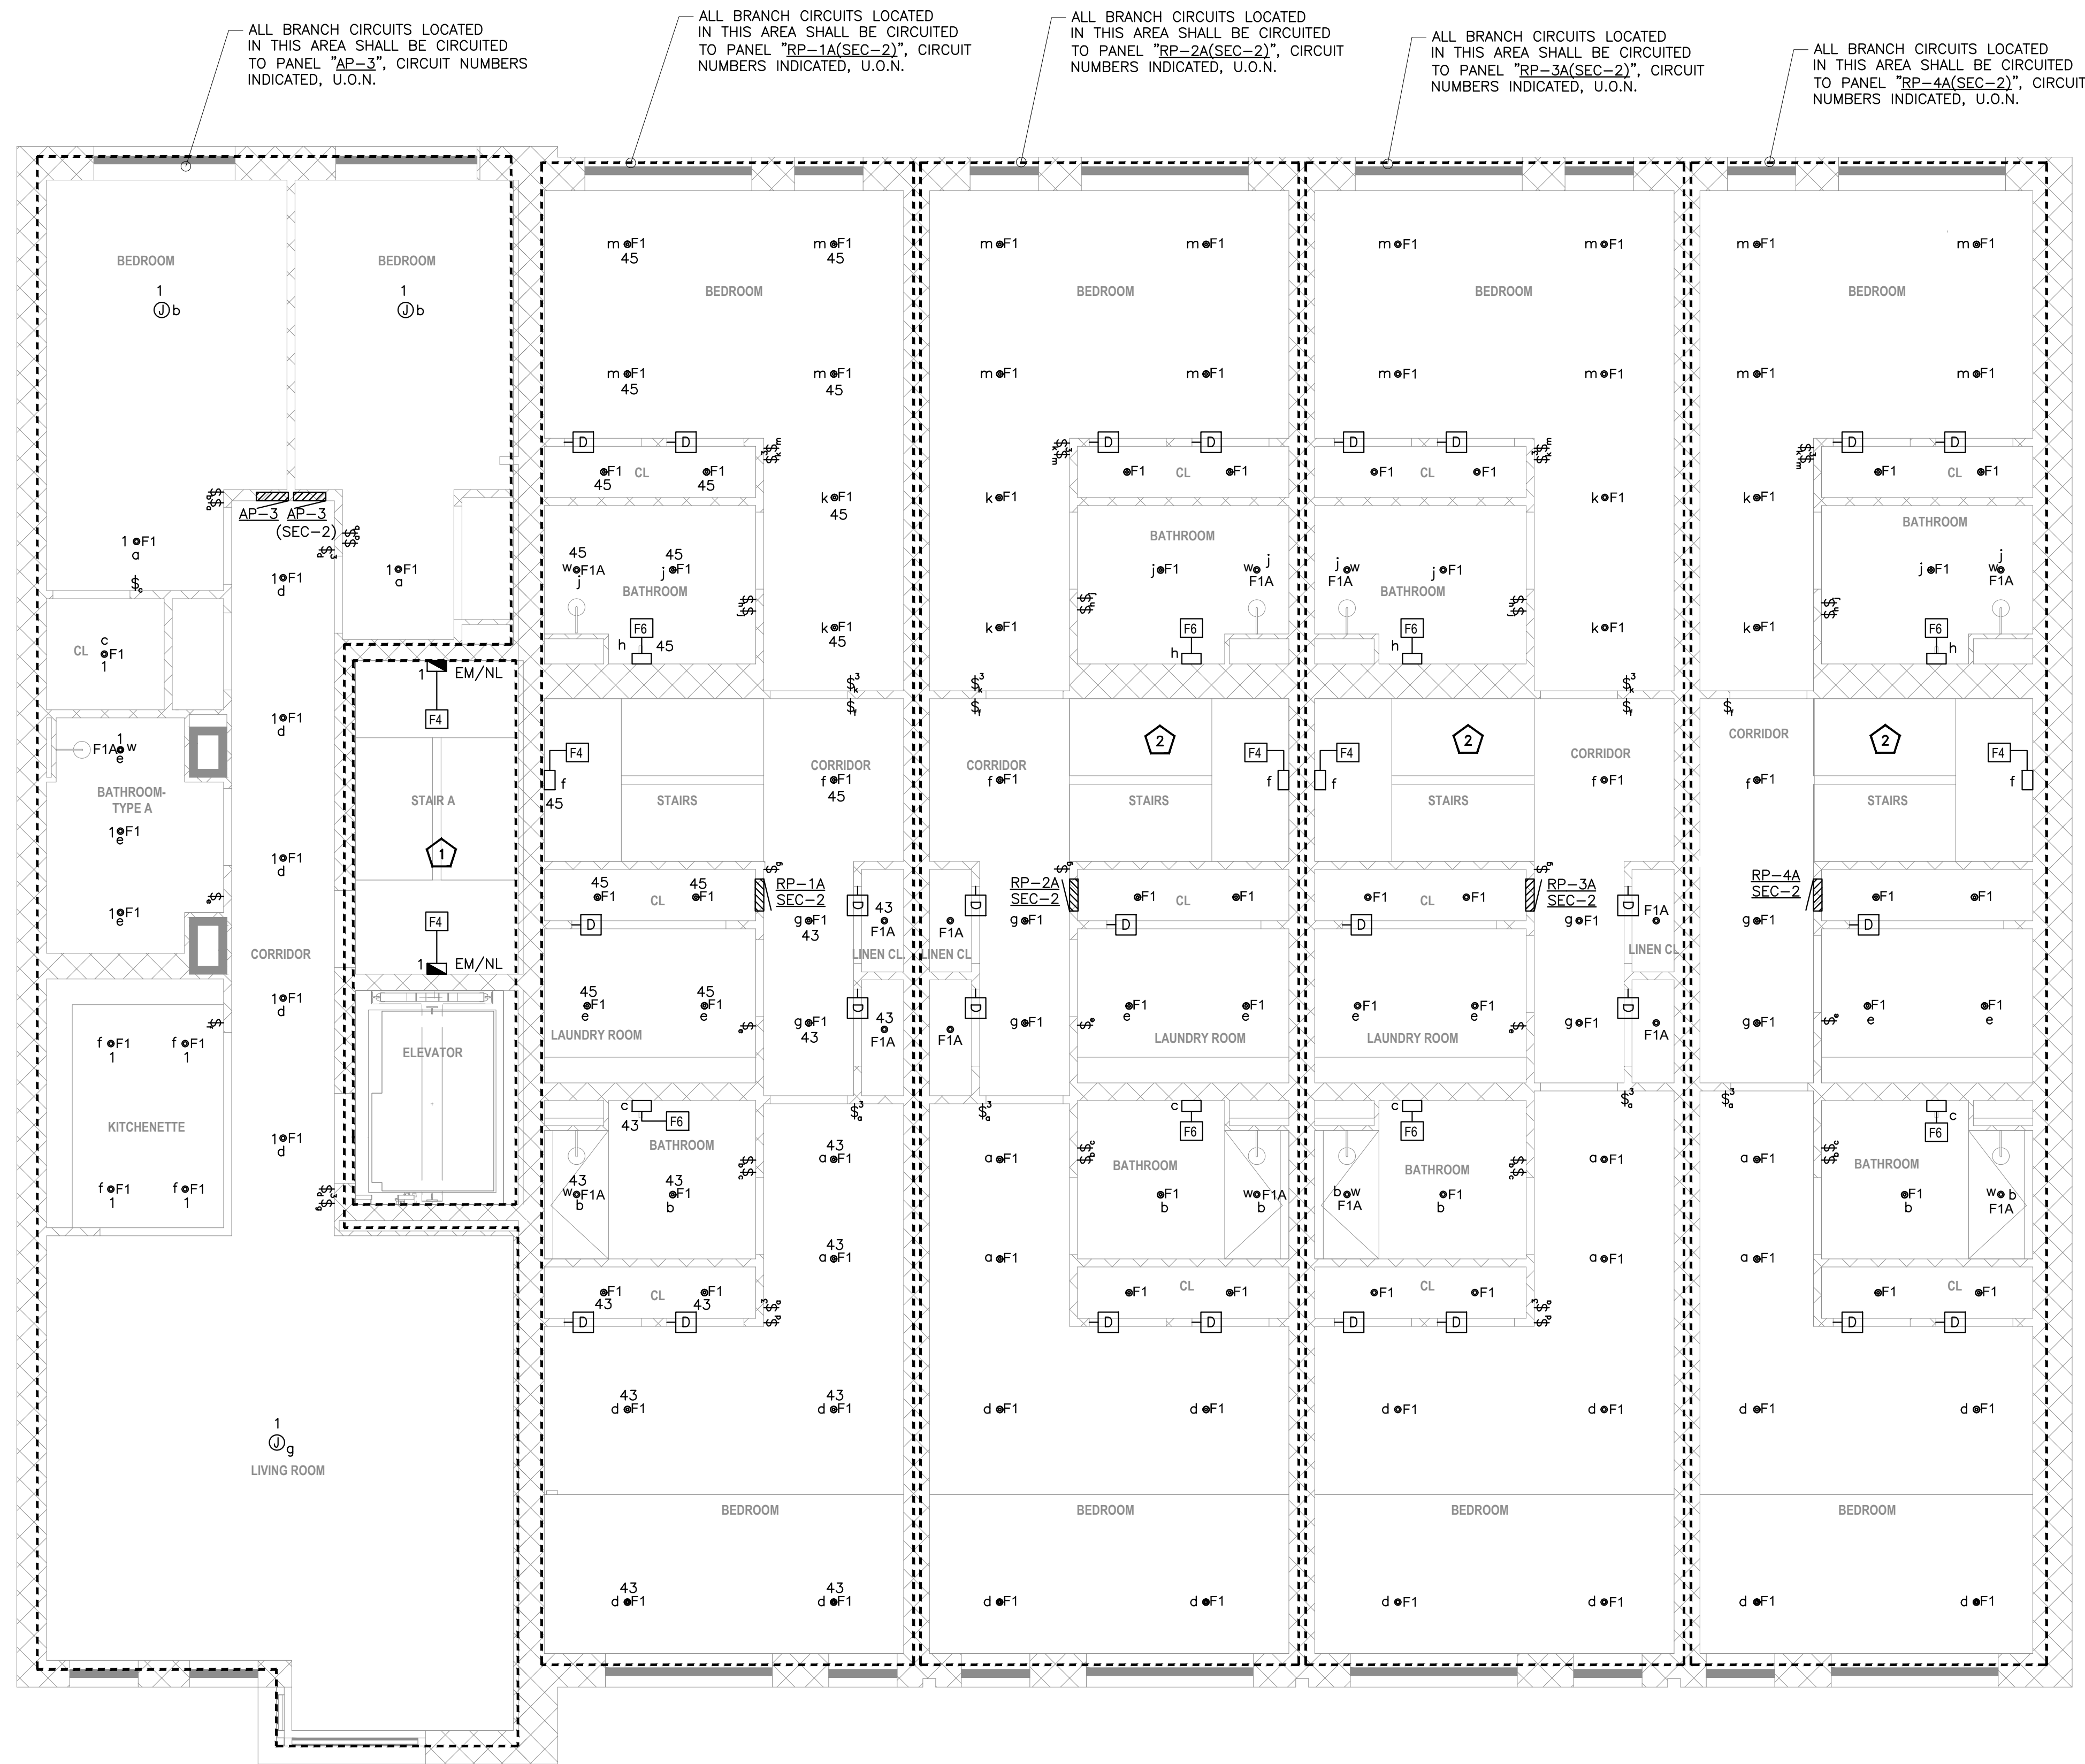

1 3RD FLOOR LIGHTING PLAN
SCALE: 1/4"=1'-0"

KEYED WORK NOTES:

- 1 ALL BRANCH CIRCUITS HOMERUNS ASSIGN INDICATED ON THIS AREA SHALL BE CIRCUITED TO PANEL "HP-1" CIRCUIT NUMBER INDICATED, U.O.N.
- 2 REFER TYPICAL TOWNHOUSE "T1" FOR LIGHTING CIRCUITING. REFER PANEL SCHEDULE ON SHEET E-601.00.

LIGHTING DRAWING NOTES:

1. REFER TO DWG. E-001.00 FOR ELECTRICAL GENERAL NOTES, SYMBOL LIST AND ABBREVIATIONS.
2. CIRCUITING FOR LIGHTING FIXTURES IN ROOMS WITH TOGGLE SWITCHES SHALL BE CONTROLLED BY DESIGNATED SWITCHES. IF SPECIFIC DESIGNATION IS NOT INDICATED, ALL LIGHTING FIXTURES IN ROOM/AREA SHALL BE CONTROLLED BY THE SWITCH INDICATED.
3. REFER DWG E-001.00 FOR LIGHT FIXTURE SCHEDULE & LIGHTING CONTROL SCHEDULE.
4. ALL F4-EM/NL FIXTURES IN STAIR-CASE OF MIH BUILDING TO HAVE BUILT IN OCCUPANCY SENSOR TO AUTOMATICALLY TURN ON/OFF LIGHT FIXTURES.



1 4TH FLOOR LIGHTING PLAN
SCALE: 1/4"=1'-0"


KEYED WORK NOTES:

- ALL BRANCH CIRCUITS HOMERUNS ASSIGN INDICATED ON THIS AREA SHALL BE CIRCUITED TO PANEL "HP-1" CIRCUIT NUMBER INDICATED, U.O.N.
- REFER TYPICAL TOWNHOUSE "T1" FOR LIGHTING CIRCUITING. REFER PANEL SCHEDULE ON SHEET E-601.00.

LIGHTING DRAWING NOTES:

- REFER TO DWG. E-001.00 FOR ELECTRICAL GENERAL NOTES, SYMBOL LIST AND ABBREVIATIONS.
- CIRCUITING FOR LIGHTING FIXTURES IN ROOMS WITH TOGGLE SWITCHES SHALL BE CONTROLLED BY DESIGNATED SWITCHES. IF SPECIFIC DESIGNATION IS NOT INDICATED, ALL LIGHTING FIXTURES IN ROOM/AREA SHALL BE CONTROLLED BY THE SWITCH INDICATED.
- REFER DWG E-001.00 FOR LIGHT FIXTURE SCHEDULE & LIGHTING CONTROL SCHEDULE.
- ALL F4-EM/NL FIXTURES IN STAIR-CASE OF MIH BUILDING TO HAVE BUILT IN OCCUPANCY SENSOR TO AUTOMATICALLY TURN ON/OFF LIGHT FIXTURES.

1. REFER TO DWG. E-001.00 FOR ELECTRICAL GENERAL NOTES, SYMBOL LIST AND ABBREVIATIONS.
2. CIRCUITING FOR LIGHTING FIXTURES IN ROOMS WITH TOGGLE SWITCHES SHALL BE CONTROLLED BY DESIGNATED SWITCHES. IF SPECIFIC DESIGNATION IS NOT INDICATED, ALL LIGHTING FIXTURES IN ROOM/AREA SHALL BE CONTROLLED BY THE SWITCH INDICATED.
3. REFER DWG E-001.00 FOR LIGHT FIXTURE SCHEDULE & LIGHTING CONTROL SCHEDULE.
4. ALL F4-EM/NL FIXTURES IN STAIR-CASE OF MIH BUILDING TO HAVE BUILT IN OCCUPANCY SENSOR TO AUTOMATICALLY TURN ON/OFF LIGHT FIXTURES.

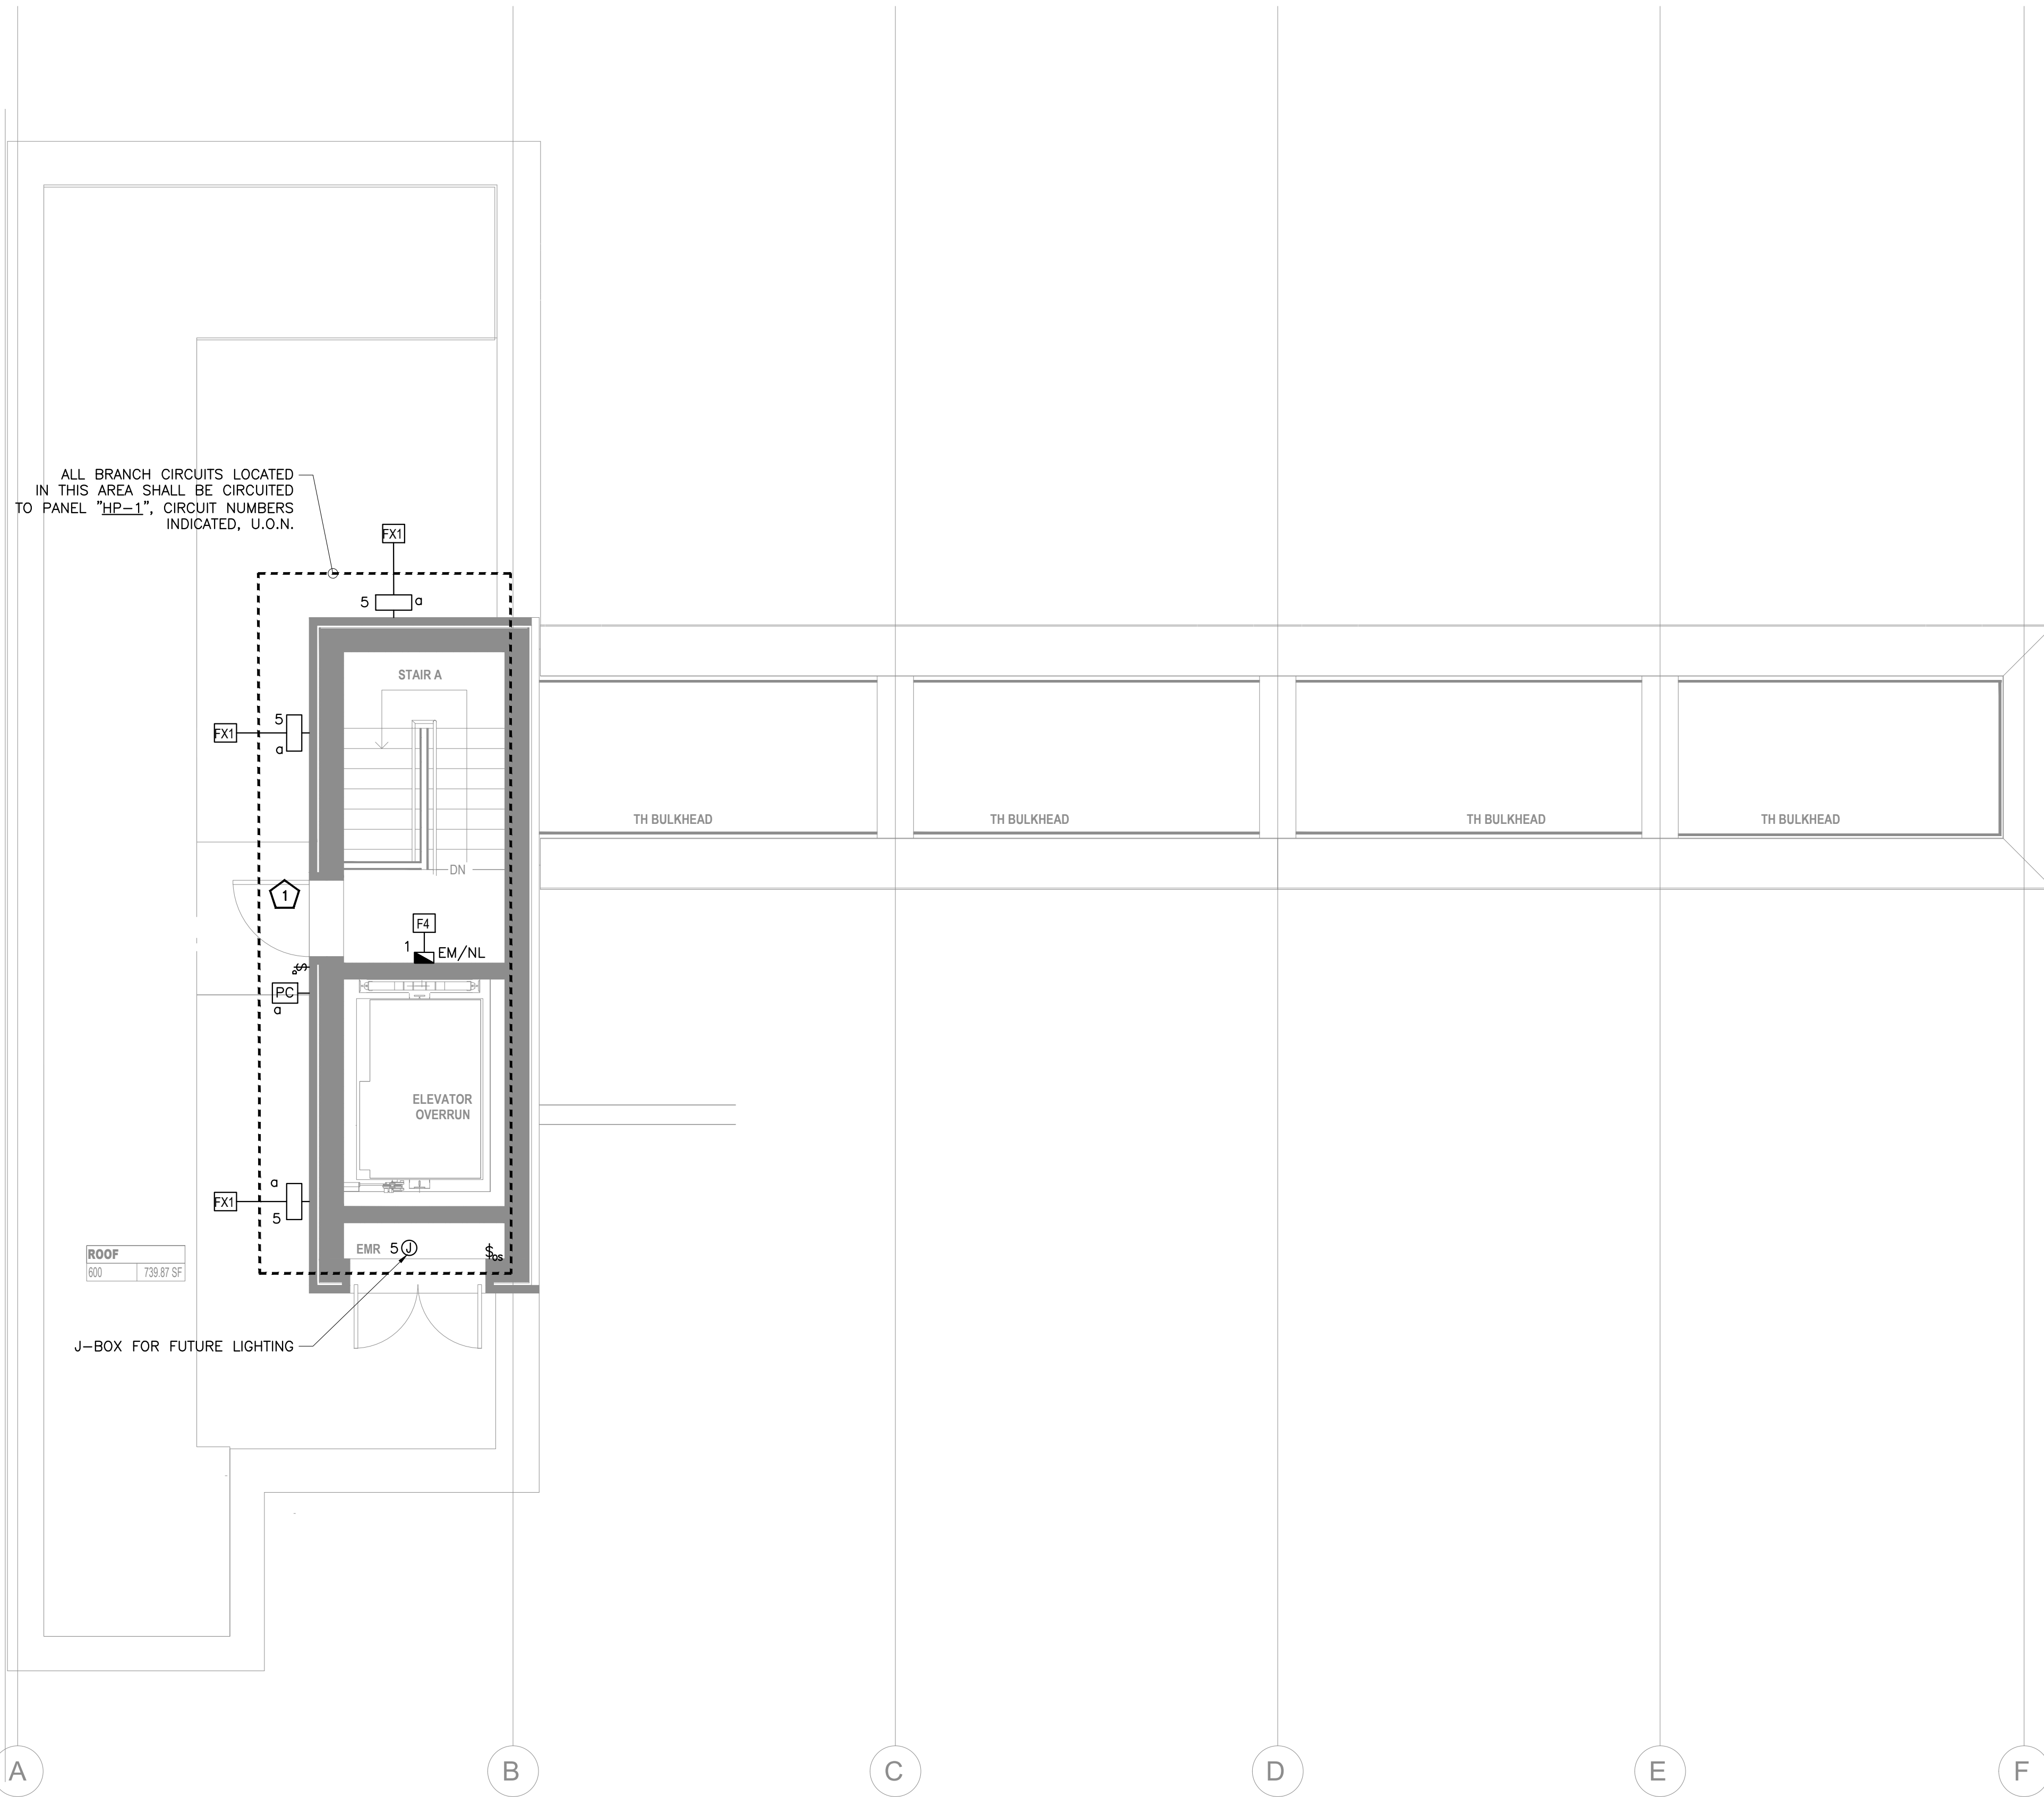


1 ROOF LIGHTING PLAN
SCALE: 1/4"=1'-0"

KEYED WORK NOTES:

- 1 PROVIDE NEMA 3R ENCLOSURE.

LIGHTING DRAWING NOTES:

1. REFER TO DWG. E-001.00 FOR ELECTRICAL GENERAL NOTES, SYMBOL LIST AND ABBREVIATIONS.
2. REFER DWG E-001.00 FOR LIGHT FIXTURE SCHEDULE & LIGHTING CONTROL SCHEDULE.
3. ALL F4-EM/NL FIXTURES IN STAIR-CASE OF MIH BUILDING TO HAVE BUILT IN OCCUPANCY SENSOR TO AUTOMATICALLY TURN ON/OFF LIGHT FIXTURES.

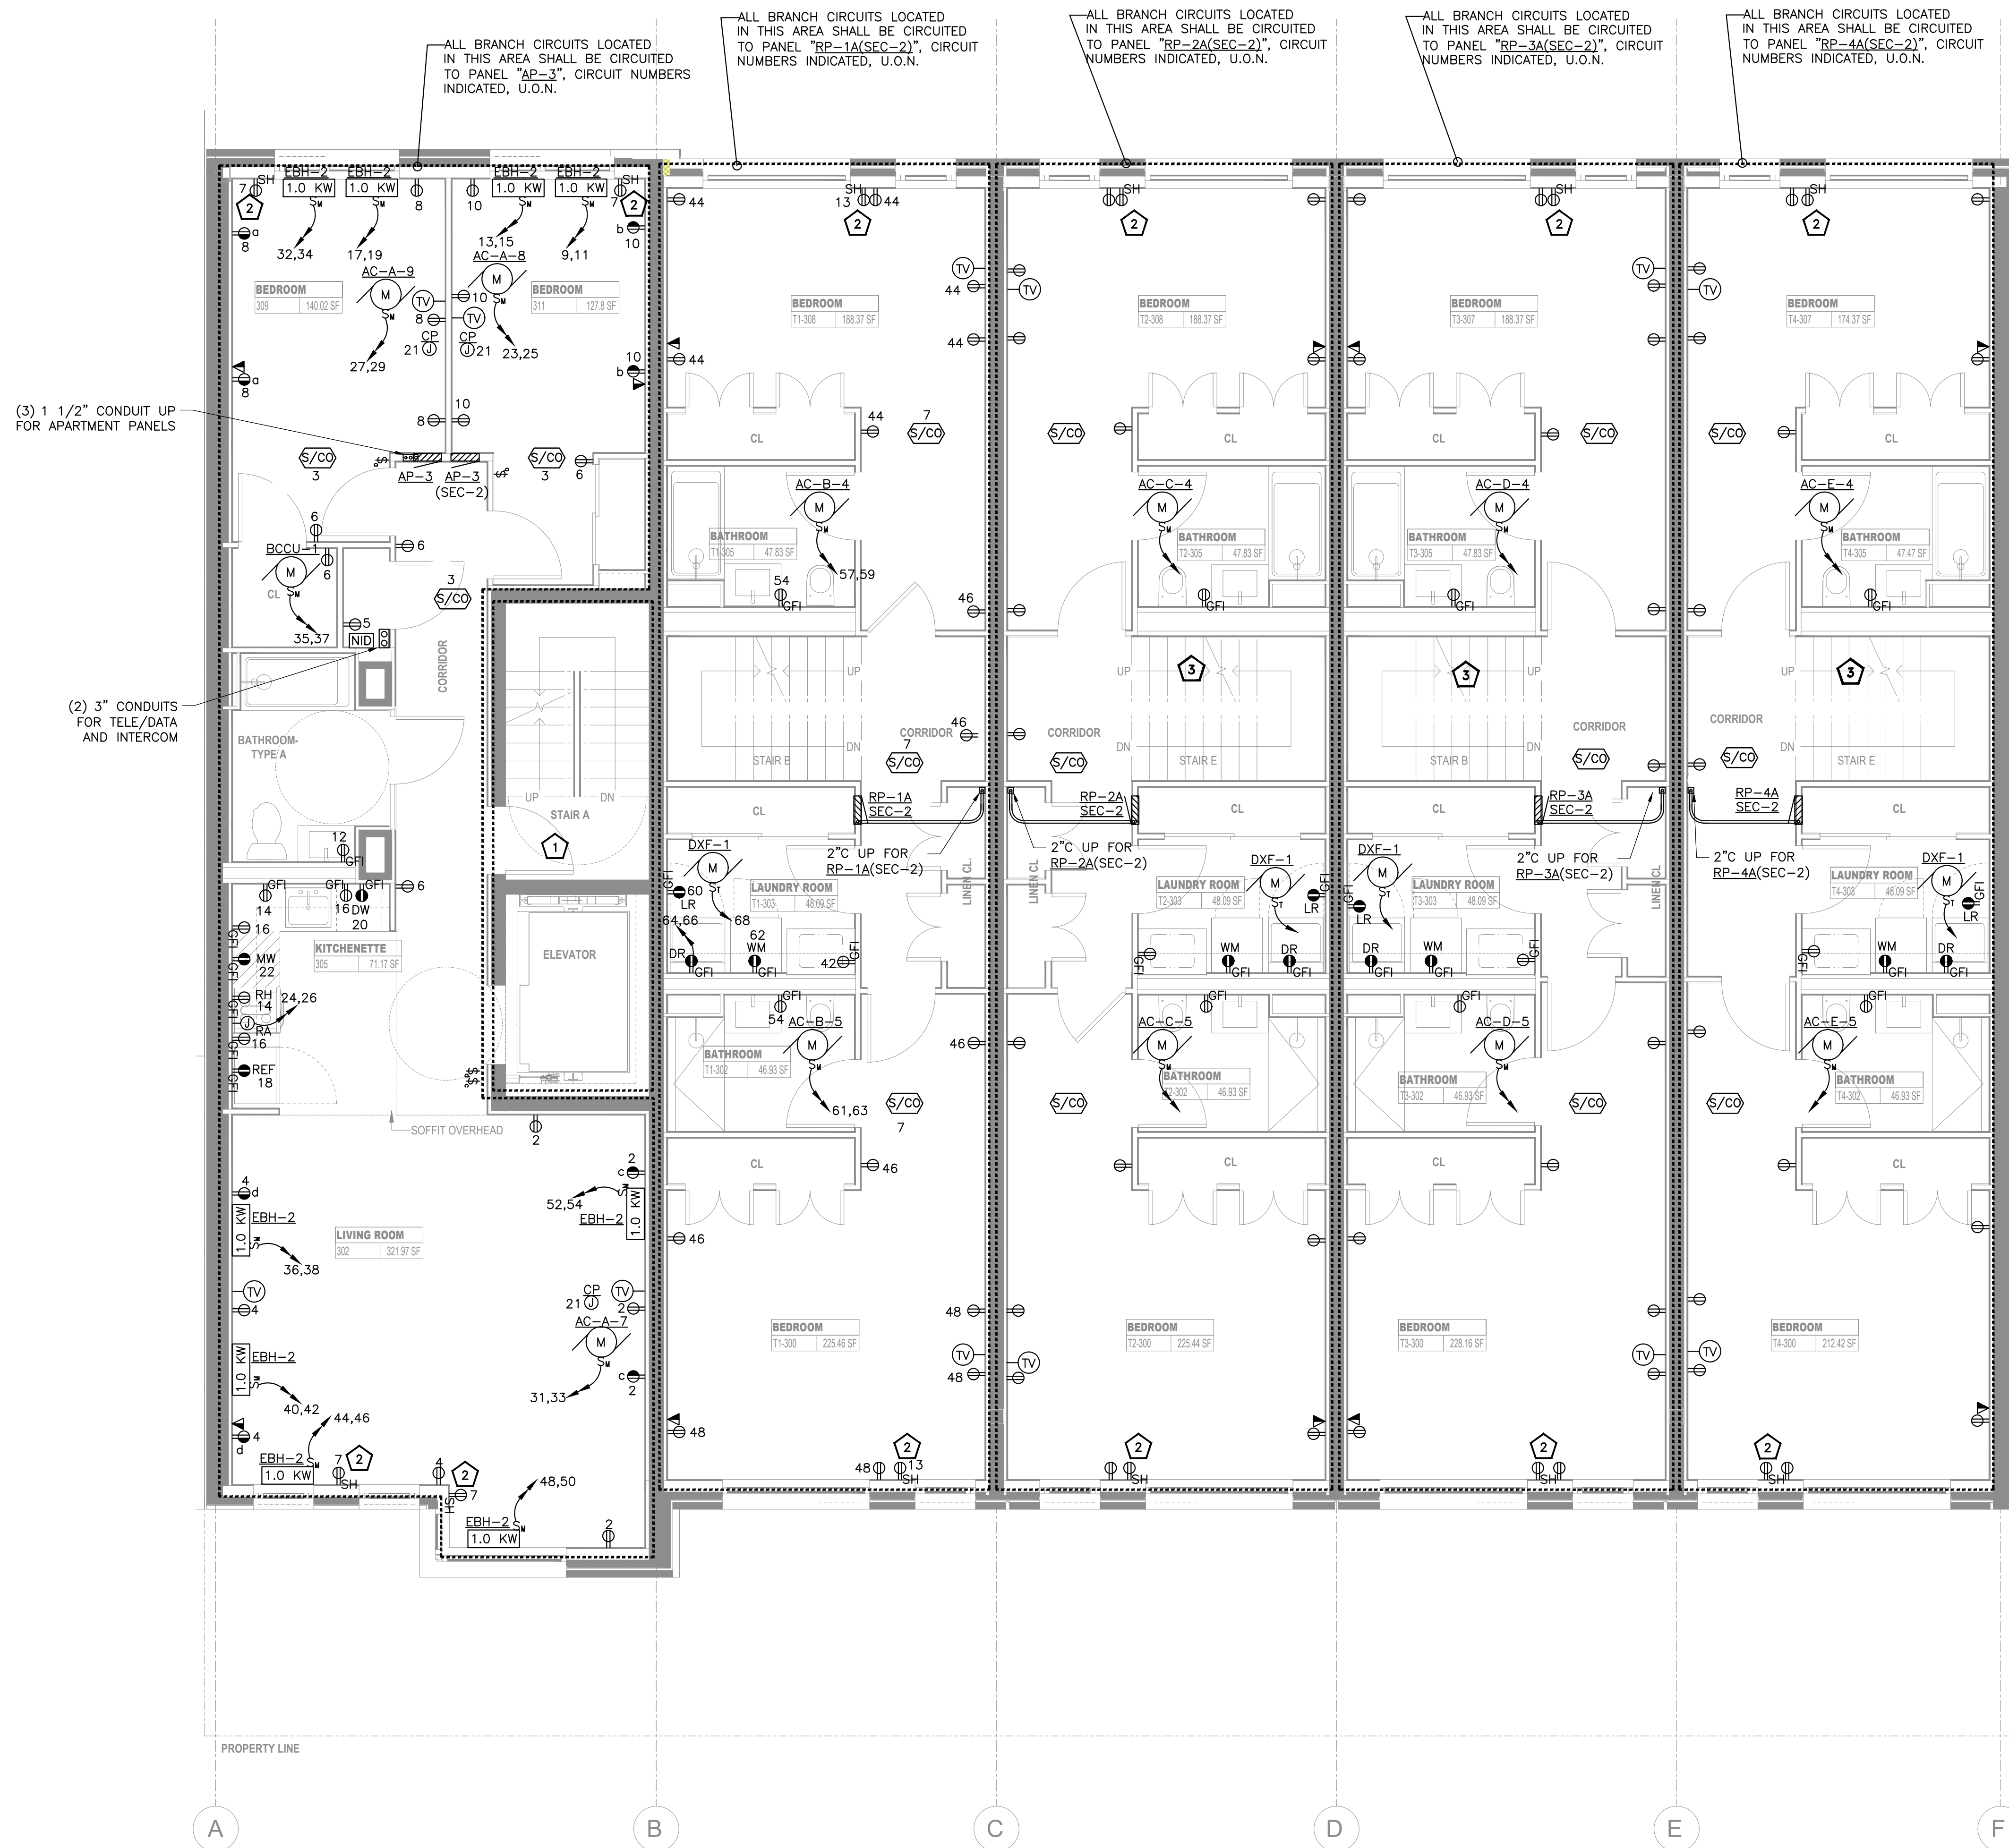

KEYED WORK NOTES:

- 1 ALL BRANCH CIRCUITS HOMERUNS ASSIGN INDICATED ON THIS AREA SHALL BE CIRCUITED TO PANEL "HP-1" CIRCUIT NUMBER INDICATED, U.O.N.
- 2 MOTORIZED SHADES RECEPTACLE TO BE MOUNTED HIGH ON WALL AT THE TOP OF THE WINDOW.
- 3 REFER TYPICAL TOWNHOUSE "T1" FOR POWER CIRCUITING. REFER PANEL SCHEDULE ON SHEET E-601.00.

POWER DRAWING NOTES:

1. REFER DWG. E-001.00 FOR ELECTRICAL GENERAL NOTES, SYMBOL LIST AND ABBREVIATIONS.
2. ALL BRANCH CIRCUITS HOMERUNS ASSIGN INDICATED ON THIS PLAN SHALL BE CIRCUITED TO PANEL AS MENTIONED ON PLANS, CIRCUIT NUMBER INDICATED, U.O.N.
3. ALL BRANCH CIRCUITS LOCATED IN THIS AREA SHALL BE CIRCUITED TO PANEL AS SHOWN, CIRCUIT NUMBERS INDICATED, U.O.N.
4. REFER ARCHITECTURAL DRAWINGS FOR EXACT LOCATION AND MOUNTING HEIGHTS OF OUTLETS.
5. MINIMUM 4" WALL THICKNESS IS REQUIRED TO FLUSH THE PANEL INTO THE WALL.
6. ALL RECEPTACLE IN DWELLING UNIT SHOULD BE TAMPER PROOF AS PER NEC 406.11.

1

3RD FLOOR POWER PLAN

SCALE: 1/4"=1'-0"

ALL BRANCH CIRCUITS LOCATED IN THIS AREA SHALL BE CIRCUITED TO PANEL "AP-4", CIRCUIT NUMBERS INDICATED, U.O.N.

ALL BRANCH CIRCUITS LOCATED IN THIS AREA SHALL BE CIRCUITED TO PANEL "RP-1A(SEC-2)", CIRCUIT NUMBERS INDICATED, U.O.N.


ALL BRANCH CIRCUITS LOCATED IN THIS AREA SHALL BE CIRCUITED TO PANEL "RP-2A(SEC-2)", CIRCUIT NUMBERS INDICATED, U.O.N.

ALL BRANCH CIRCUITS LOCATED IN THIS AREA SHALL BE CIRCUITED TO PANEL "RP-3A(SEC-2)", CIRCUIT NUMBERS INDICATED, U.O.N.

ALL BRANCH CIRCUITS LOCATED IN THIS AREA SHALL BE CIRCUITED TO PANEL "RP-4A(SEC-2)", CIRCUIT NUMBERS INDICATED, U.O.N.

(2) 1 1/2" CONDUIT UP FOR APARTMENT PANELS

(2) 3" CONDUITS FOR TELE/DATA AND INTERCOM

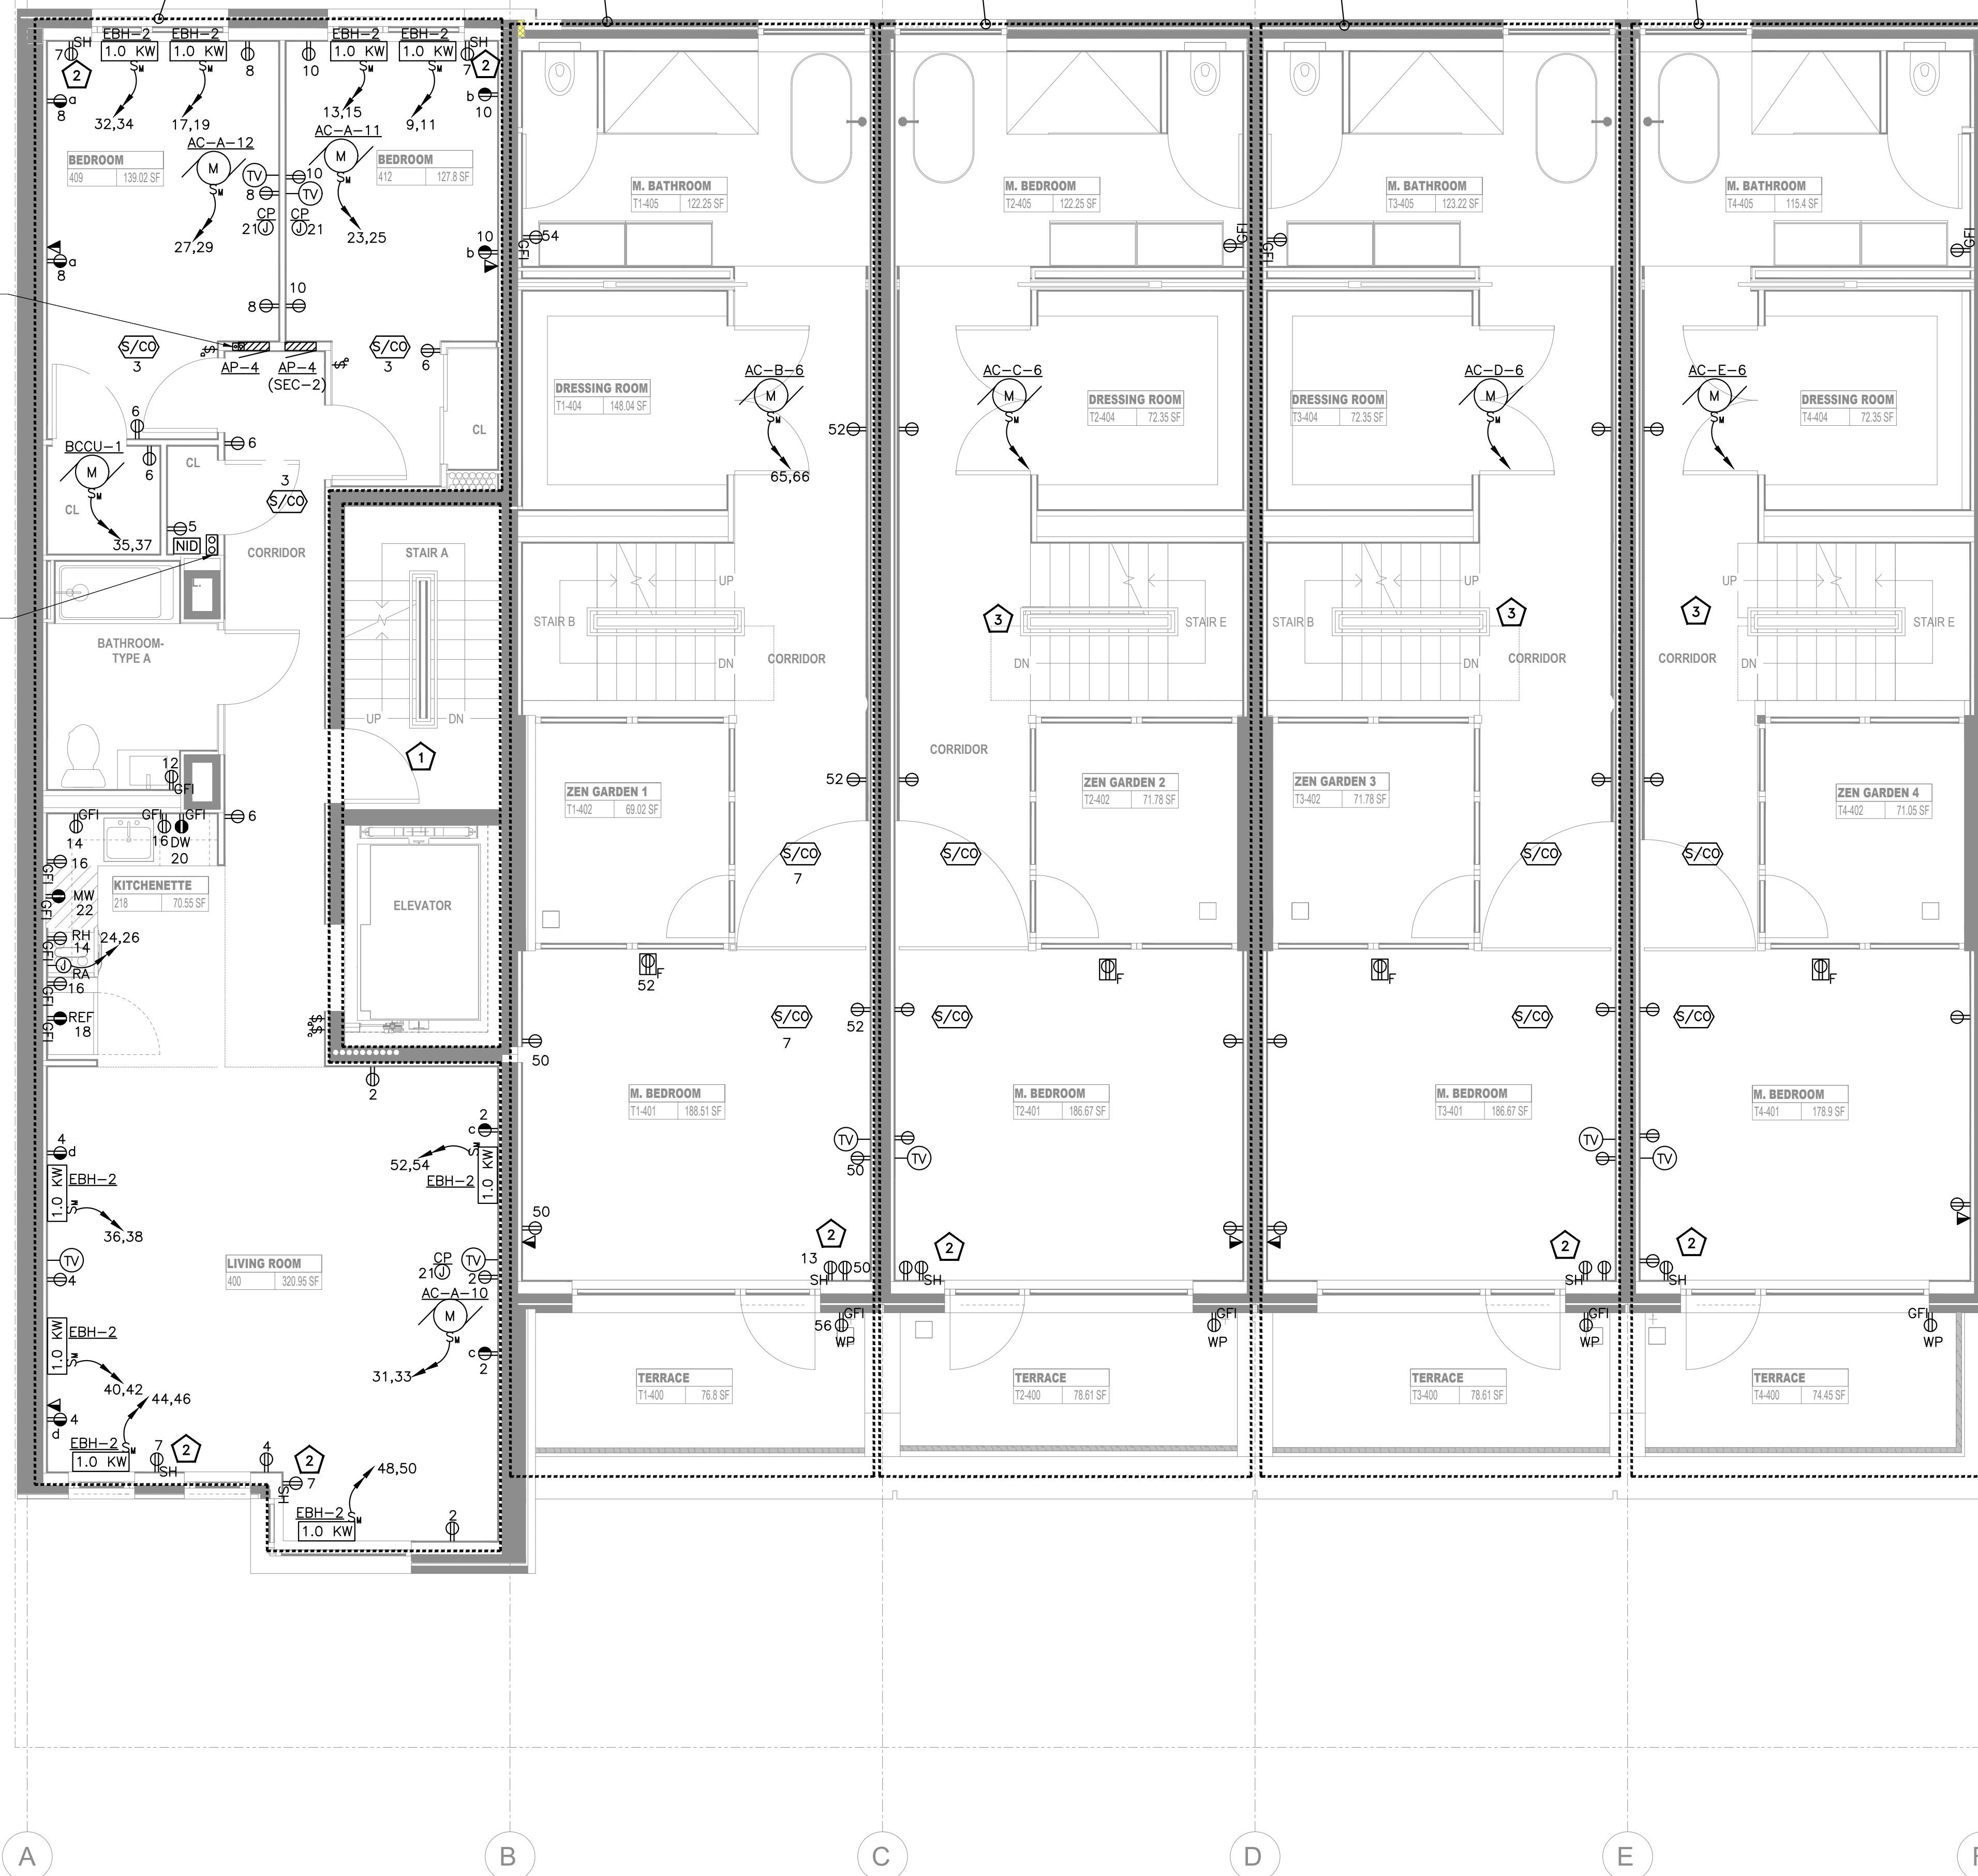

KEYED WORK NOTES:

- 1 ALL BRANCH CIRCUITS HOMERUNS ASSIGN INDICATED ON THIS AREA SHALL BE CIRCUITED TO PANEL "HP-1" CIRCUIT NUMBER INDICATED, U.O.N.
- 2 MOTORIZED SHADES RECEPTACLE TO BE MOUNTED HIGH ON WALL AT THE TOP OF THE WINDOW.
- 3 REFER TYPICAL TOWNHOUSE "T1" FOR POWER CIRUITING. REFER PANEL SCHEDULE ON SHEET E-601.00.


POWER DRAWING NOTES:

1. REFER DWG. E-001.00 FOR ELECTRICAL GENERAL NOTES, SYMBOL LIST AND ABBREVIATIONS.
2. ALL BRANCH CIRCUITS HOMERUNS ASSIGN INDICATED ON THIS PLAN SHALL BE CIRCUITED TO PANEL AS MENTIONED ON PLANS, CIRCUIT NUMBER INDICATED, U.O.N.
3. ALL BRANCH CIRCUITS LOCATED IN THIS AREA SHALL BE CIRCUITED TO PANEL AS SHOWN, CIRCUIT NUMBERS INDICATED, U.O.N.
4. REFER ARCHITECTURAL DRAWINGS FOR EXACT LOCATION AND MOUNTING HEIGHTS OF OUTLETS.
5. MINIMUM 4" WALL THICKNESS IS REQUIRED TO FLUSH THE PANEL INTO THE WALL.
6. ALL RECEPTACLE IN DWELLING UNIT SHOULD BE TAMPER PROOF AS PER NEC 406.11.
7. PROVIDE WEATHER PROOF ENCLOSURE FOR ALL OUTDOOR RECEPTABLES.



- KEYED WORK NOTES:**
- 1 ALL BRANCH CIRCUITS HOMERUNS ASSIGN INDICATED ON THIS AREA SHALL BE CIRCUITED TO PANEL "HP-1" CIRCUIT NUMBER INDICATED, U.O.N.
 - 2 MOTORIZED SHADES RECEPTACLE TO BE MOUNTED HIGH ON WALL AT THE TOP OF THE WINDOW.
 - 3 REFER TYPICAL TOWNHOUSE "T1" FOR POWER CIRUITING. REFER PANEL SCHEDULE ON SHEET E-601.00.
- POWER DRAWING NOTES:**
- 1. REFER DWG. E-001.00 FOR ELECTRICAL GENERAL NOTES, SYMBOL LIST AND ABBREVIATIONS.
 - 2. ALL BRANCH CIRCUITS HOMERUNS ASSIGN INDICATED ON THIS PLAN SHALL BE CIRCUITED TO PANEL AS MENTIONED ON PLANS, CIRCUIT NUMBER INDICATED, U.O.N.
 - 3. ALL BRANCH CIRCUITS LOCATED IN THIS AREA SHALL BE CIRCUITED TO PANEL AS SHOWN, CIRCUIT NUMBERS INDICATED, U.O.N.
 - 4. REFER ARCHITECTURAL DRAWINGS FOR EXACT LOCATION AND MOUNTING HEIGHTS OF OUTLETS.
 - 5. MINIMUM 4" WALL THICKNESS IS REQUIRED TO FLUSH THE PANEL INTO THE WALL.
 - 6. ALL RECEPTACLE IN DWELLING UNIT SHOULD BE TAMPER PROOF AS PER NEC 406.11.
 - 7. PROVIDE WEATHER PROOF ENCLOSURE FOR ALL OUTDOOR RECEPTACLES.

1 5TH FLOOR POWER PLAN
SCALE: 1/4"=1'-0"

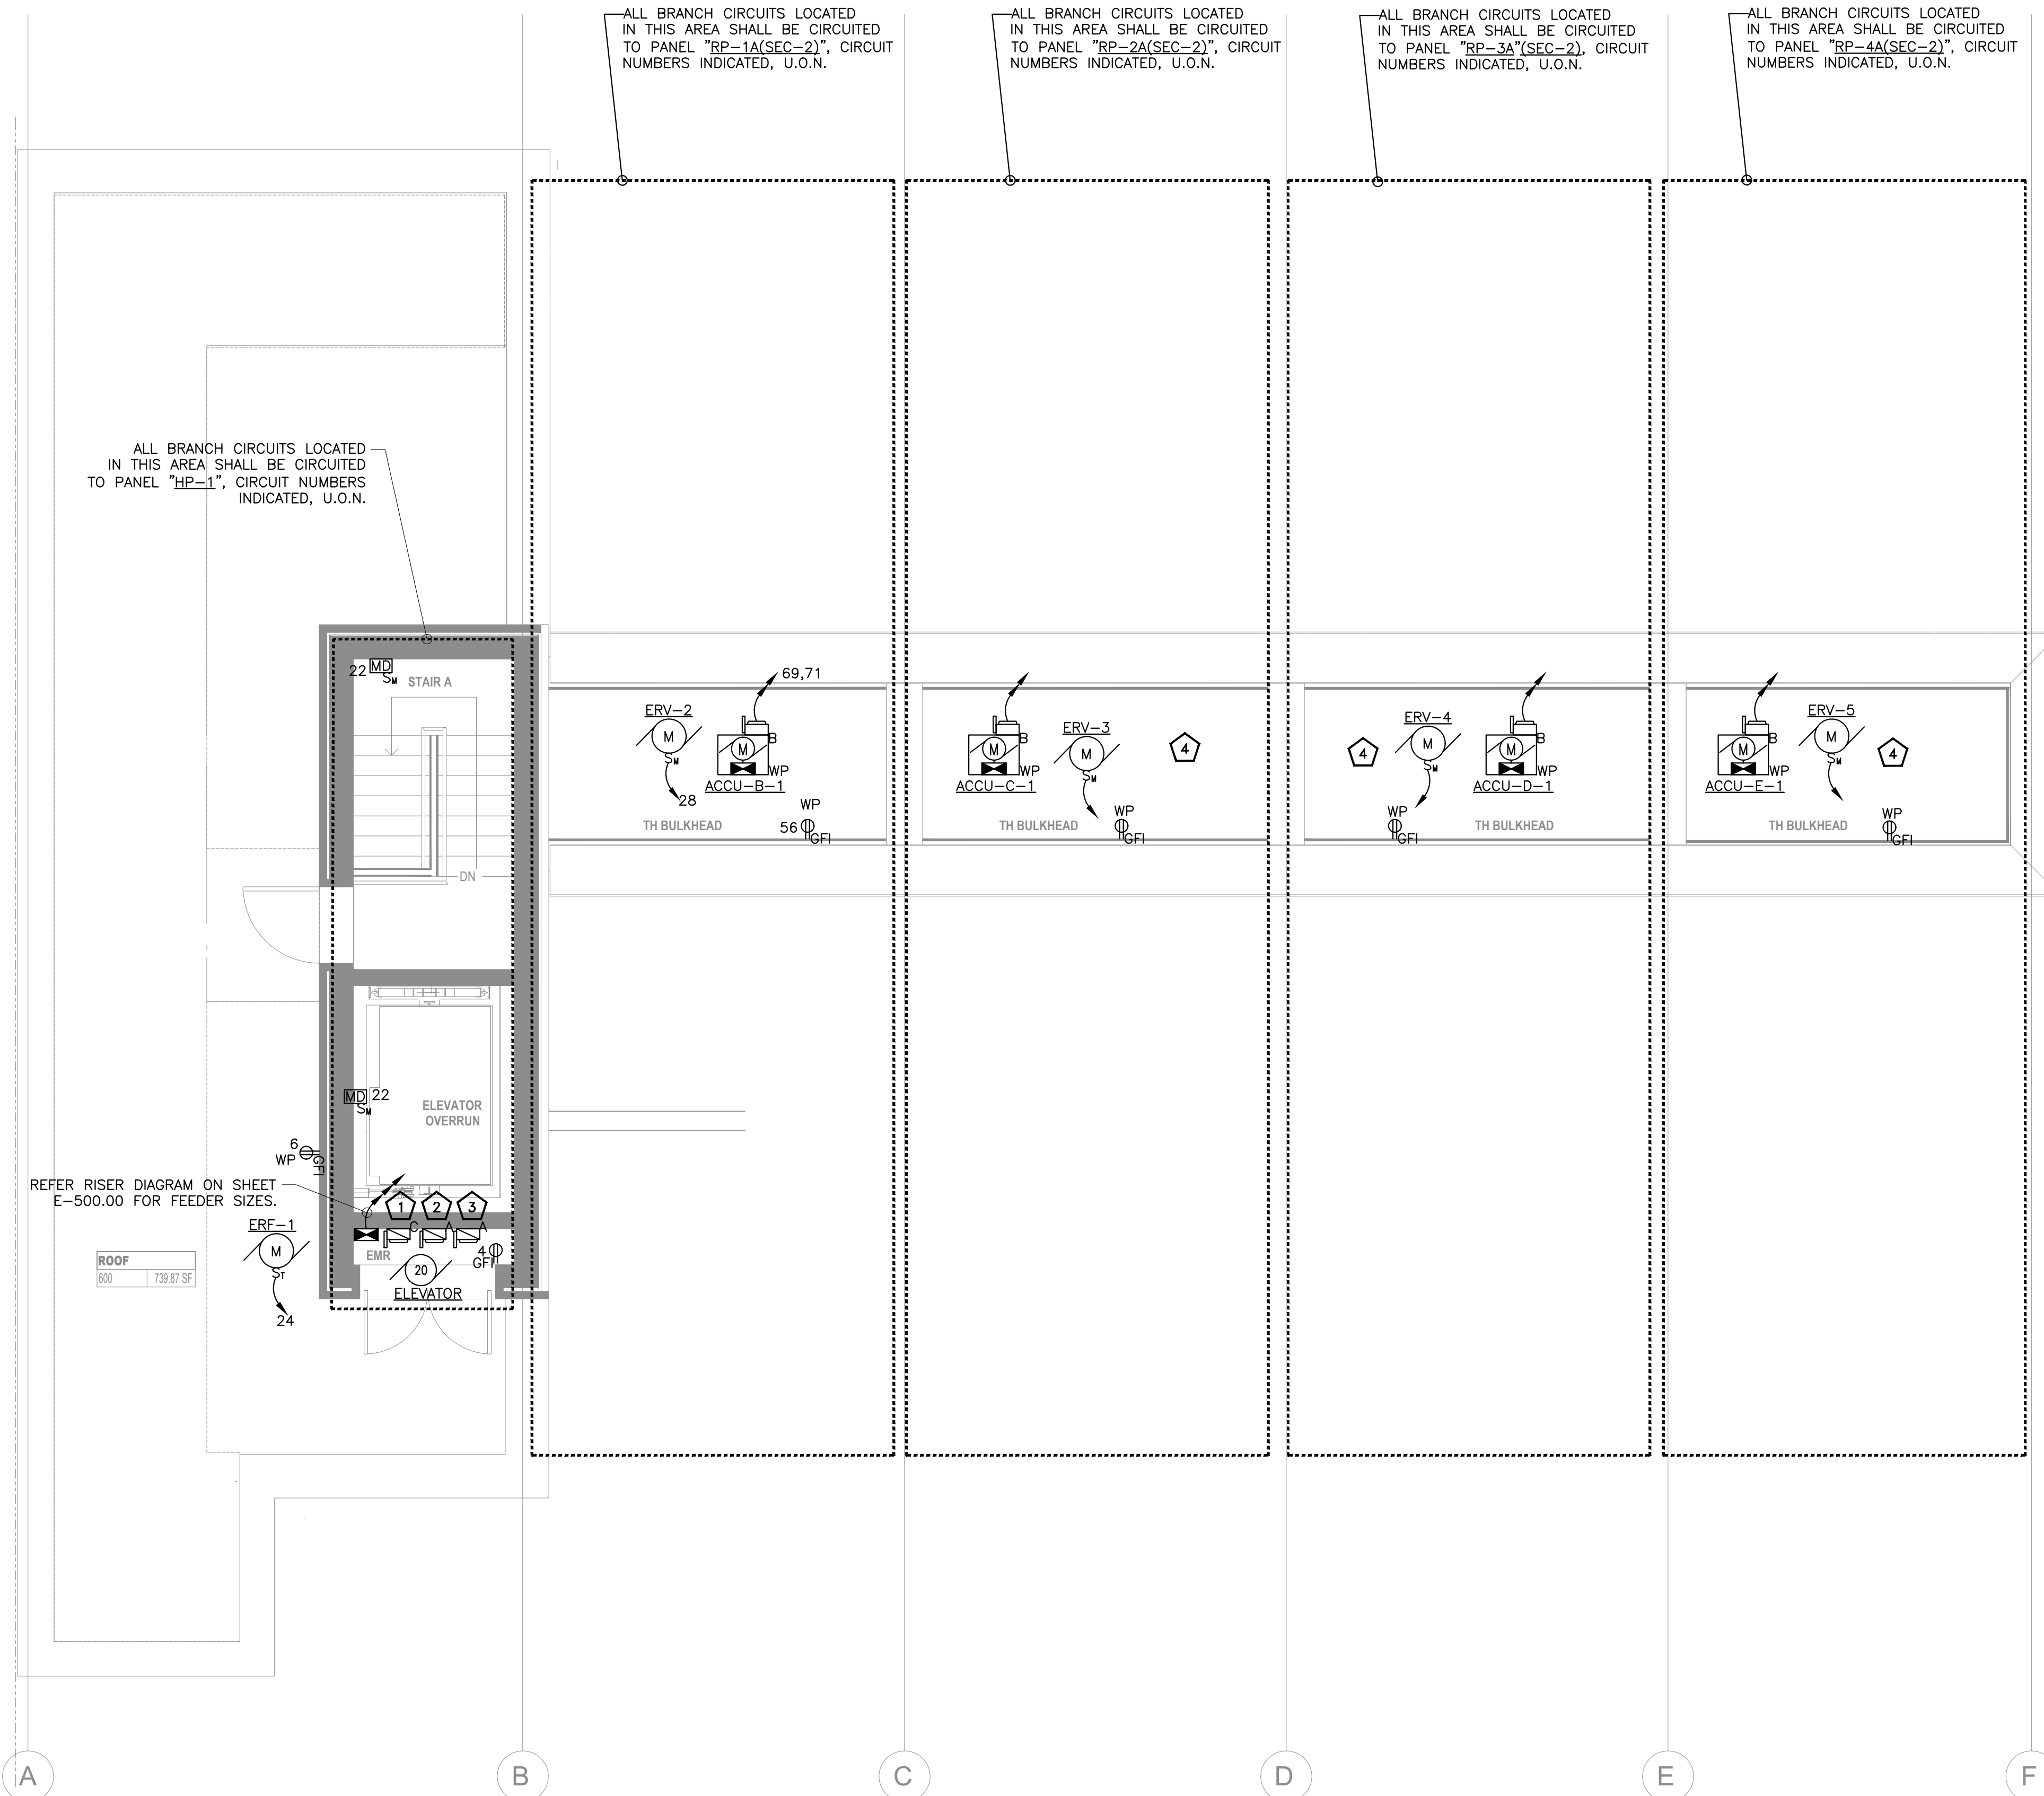

KEYED WORK NOTES:

- 100AS/80AF/208V DISCONNECT SWITCH FOR ELEVATOR CONTROLLER.
- 30AS/20AF/115V DISC. SWITCH FOR ELEVATOR CAB AUX. POWER.
- 30AS/20AF/115V DISC. SWITCH FOR ELEVATOR CAB LIGHTING.
- REFER TYPICAL TOWNHOUSE "T1" FOR LIGHTING CIRCUITING. REFER PANEL SCHEDULE ON SHEET E-601.00.


POWER DRAWING NOTES:

- REFER DWG. E-001.00 FOR ELECTRICAL GENERAL NOTES, SYMBOL LIST AND ABBREVIATIONS.
- ALL BRANCH CIRCUITS HOMERUNS ASSIGN INDICATED ON THIS PLAN SHALL BE CIRCUITED TO PANEL AS MENTIONED ON PLANS, CIRCUIT NUMBER INDICATED, U.O.N.
- ALL BRANCH CIRCUITS LOCATED IN THIS AREA SHALL BE CIRCUITED TO PANEL AS SHOWN, CIRCUIT NUMBERS INDICATED, U.O.N.
- REFER ARCHITECTURAL DRAWINGS FOR EXACT LOCATION AND MOUNTING HEIGHTS OF OUTLETS.
- PROVIDE WEATHER PROOF ENCLOSURE FOR ALL OUTDOOR RECEPTACLES.

1 ROOF POWER PLAN

SCALE: 1/4"=1'-0"

ALL BRANCH CIRCUITS LOCATED
IN THIS AREA SHALL BE CIRCUITED
TO PANEL "HP-1", CIRCUIT NUMBERS
INDICATED, U.O.N.

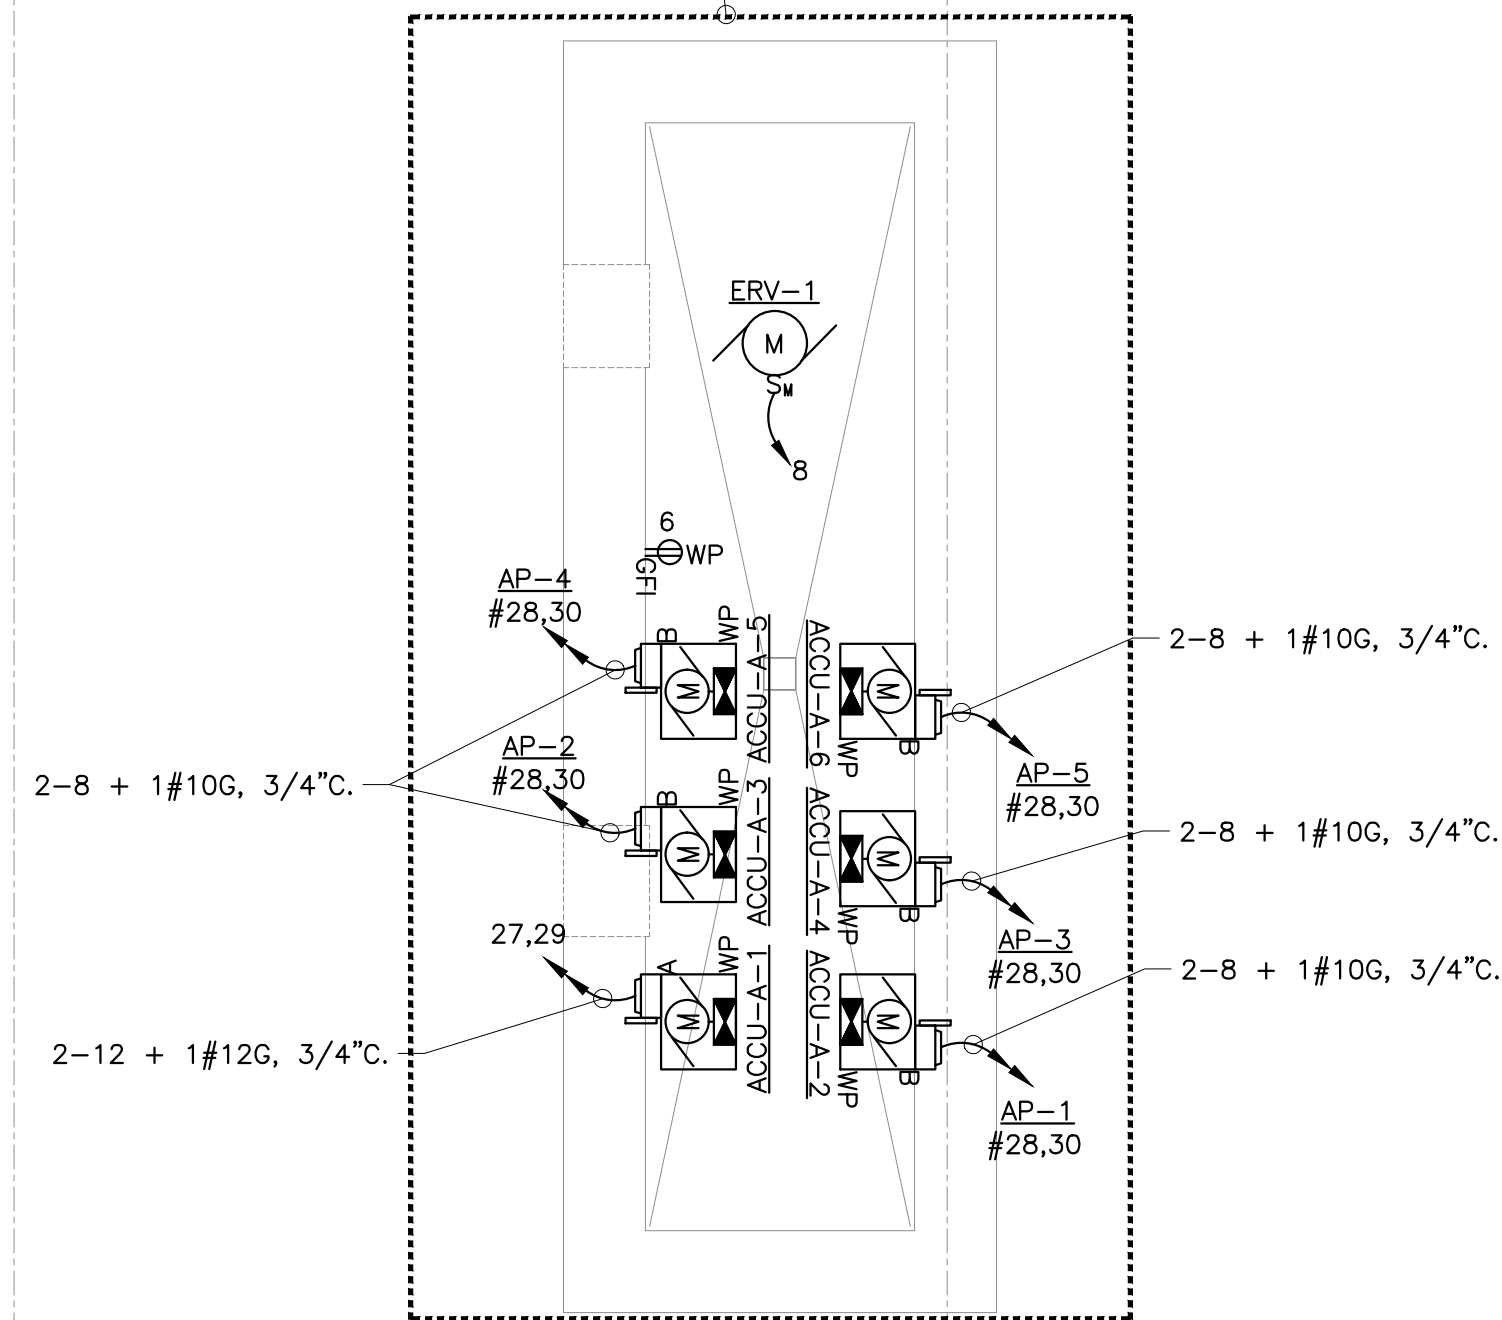

POWER DRAWING NOTES:

1. REFER DWG. E-001.00 FOR ELECTRICAL GENERAL NOTES, SYMBOL LIST AND ABBREVIATIONS.
2. ALL BRANCH CIRCUITS HOMERUNS ASSIGN INDICATED ON THIS PLAN SHALL BE CIRCUITED TO PANEL AS MENTIONED ON PLANS, CIRCUIT NUMBER INDICATED, U.O.N.
3. ALL BRANCH CIRCUITS LOCATED IN THIS AREA SHALL BE CIRCUITED TO PANEL AS SHOWN, CIRCUIT NUMBERS INDICATED, U.O.N.
4. REFER ARCHITECTURAL DRAWINGS FOR EXACT LOCATION AND MOUNTING HEIGHTS OF OUTLETS.
5. PROVIDE WEATHER PROOF ENCLOSURE FOR ALL OUTDOOR RECEPTACLES.