




1 MIH-GROUND FLOOR FIRE ALARM PLAN
SCALE: 1/4"=1'-0"

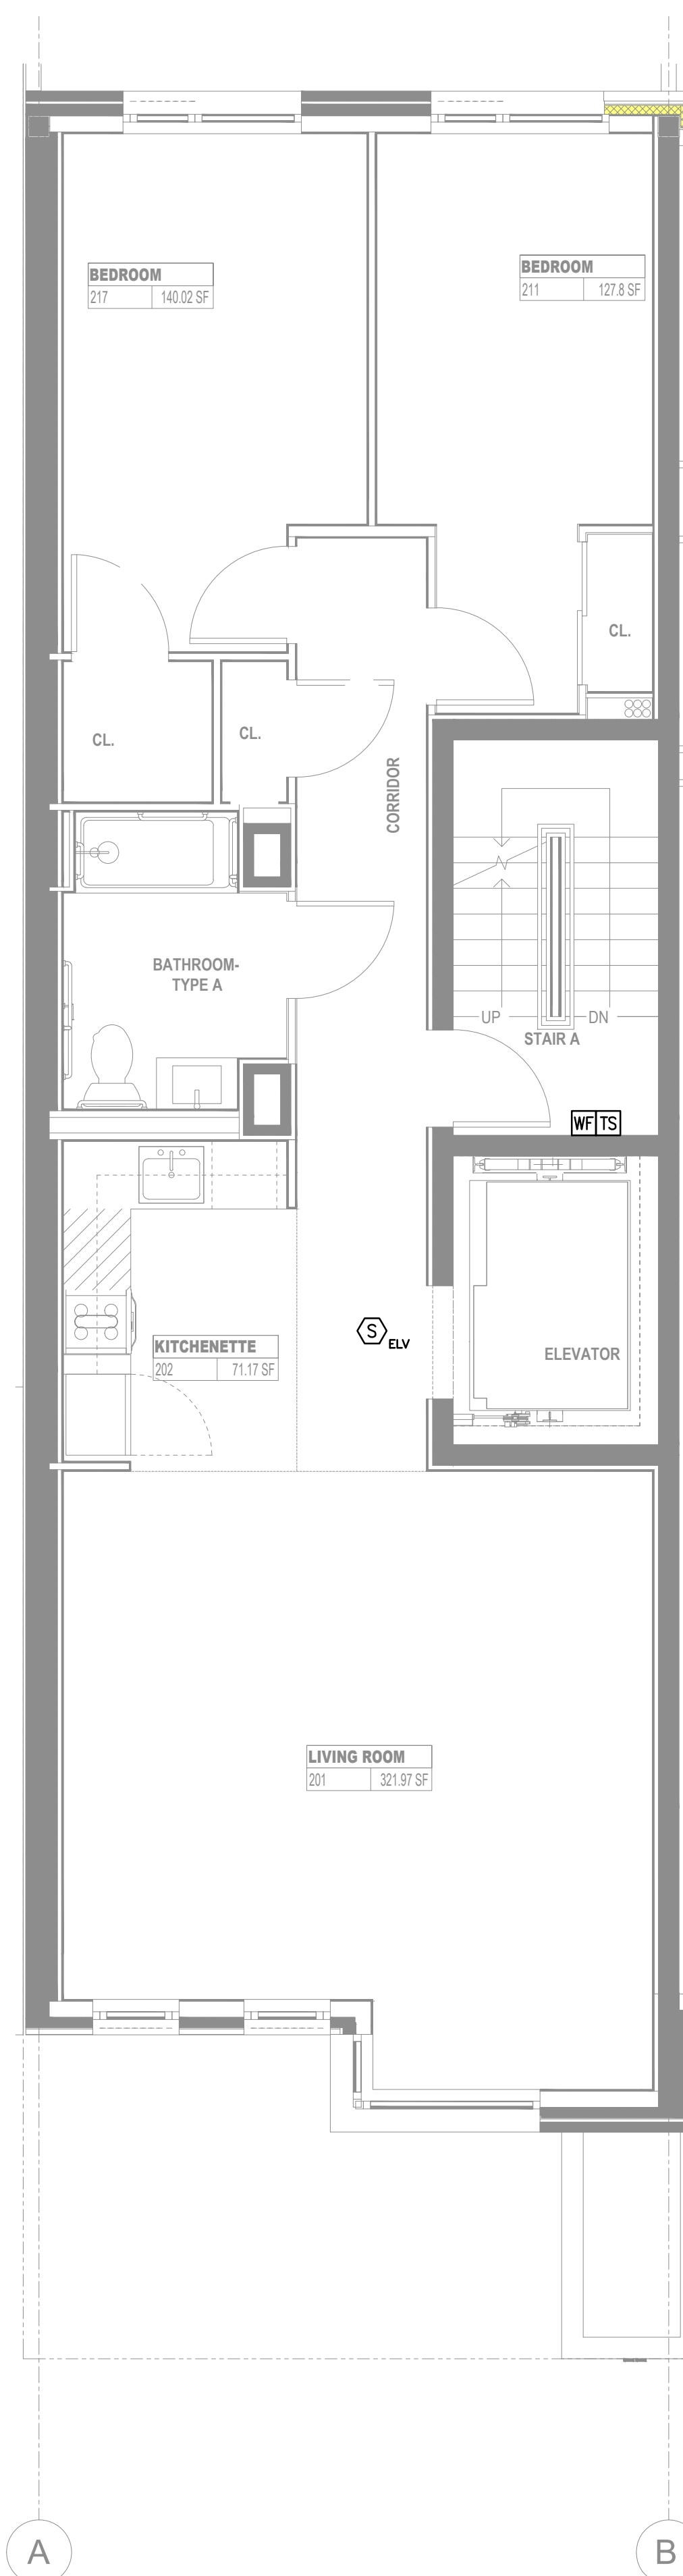

2 MIH-2ND FLOOR FIRE ALARM PLAN
SCALE: 1/4"=1'-0"

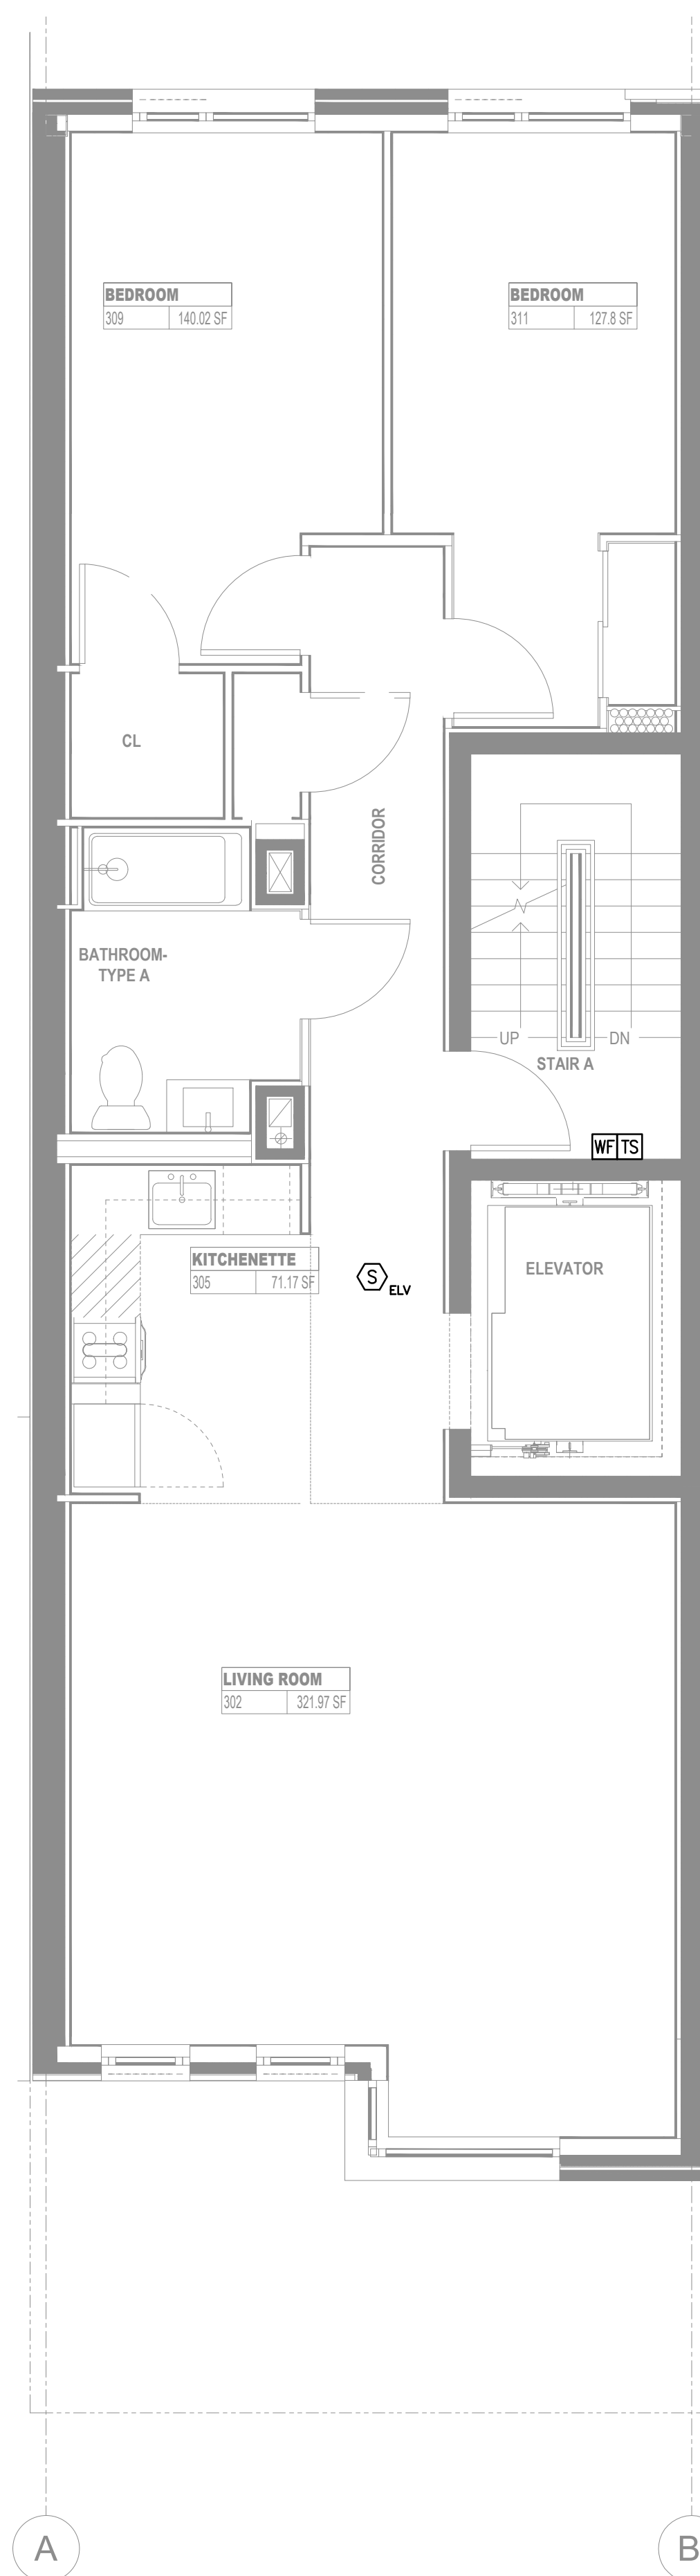


3 MIH-3RD FLOOR FIRE ALARM PLAN
SCALE: 1/4"=1'-0"

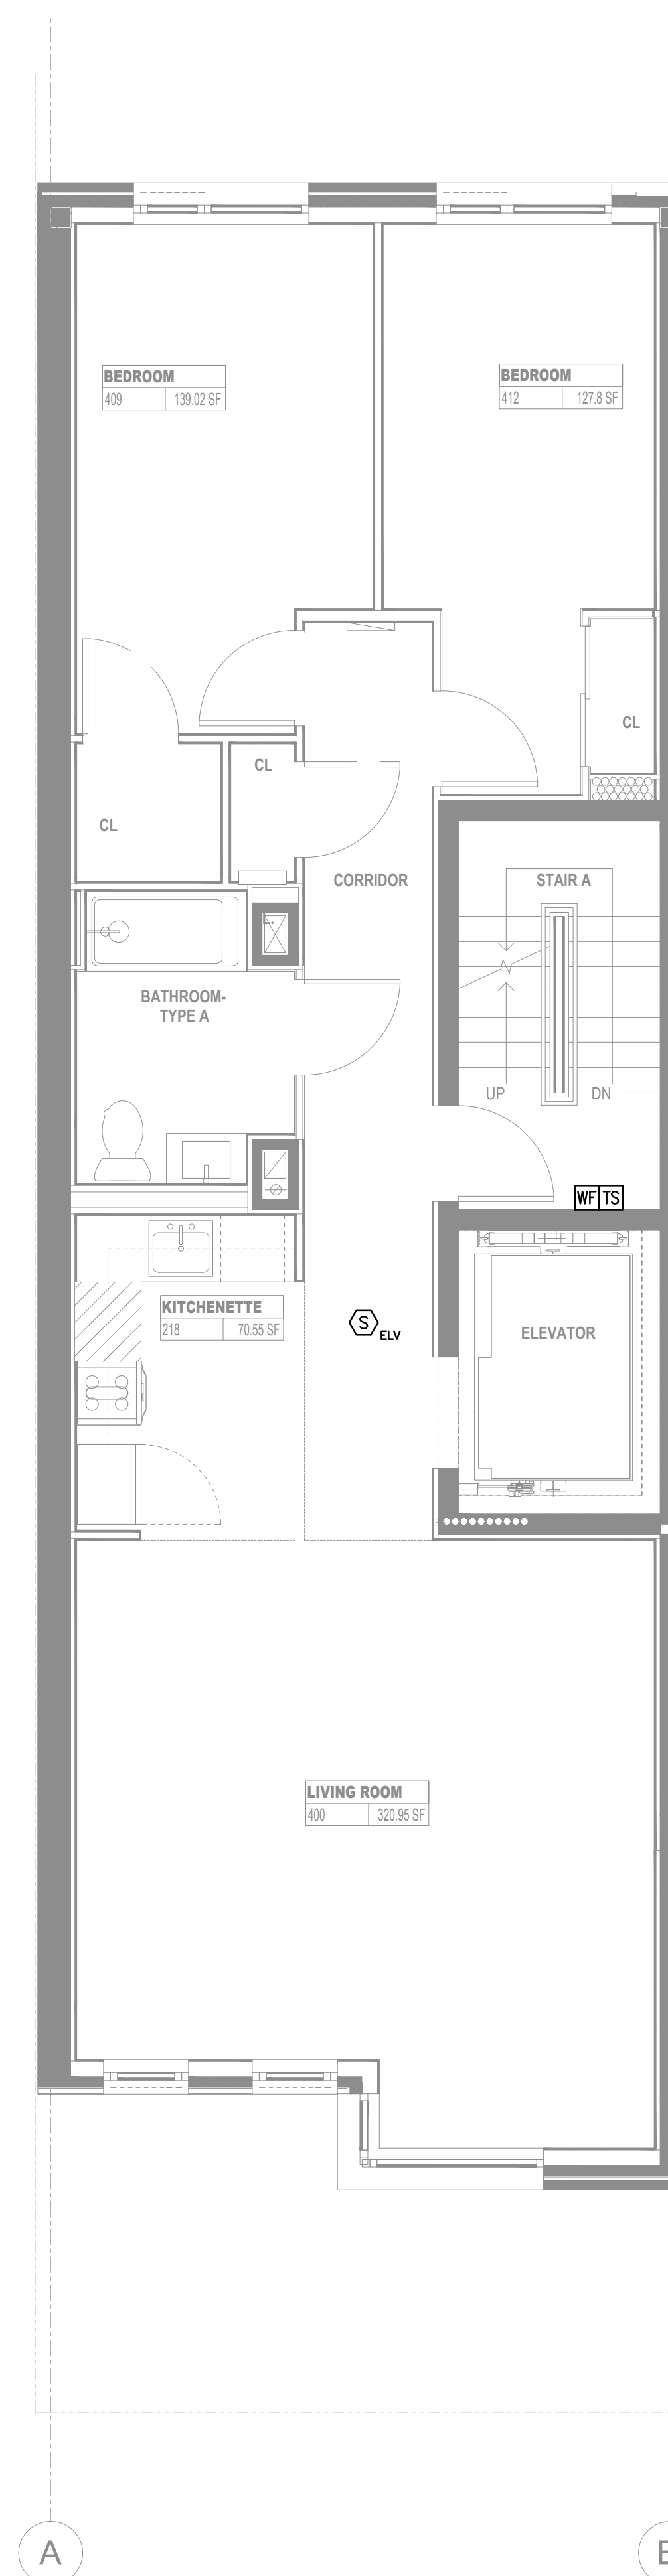


4 MIH-4TH FLOOR FIRE ALARM PLAN
SCALE: 1/4"=1'-0"

FIRE ALARM DRAWING NOTES:


1. REFER TO DWG. FA-001.00 FOR FIRE ALARM SYMBOL LIST, ABBREVIATIONS, BUILDING DATA AND I/O MATRIX.
2. REFER TO DWG. FA-004.00 FOR FIRE ALARM SYSTEM RISER DIAGRAM.
3. FINAL CONDUIT/CABLE ROUTING SHALL BE DETERMINED IN-FIELD, AND PRIOR TO THE COMMENCEMENT OF WORK, COORDINATED WITH OTHER TRADE CONTRACTORS AND THE OWNER.
4. NO CO PRODUCING EQUIPMENTS LOCATED ON FLOOR, FLOOR ABOVE OR FLOOR BELOW.

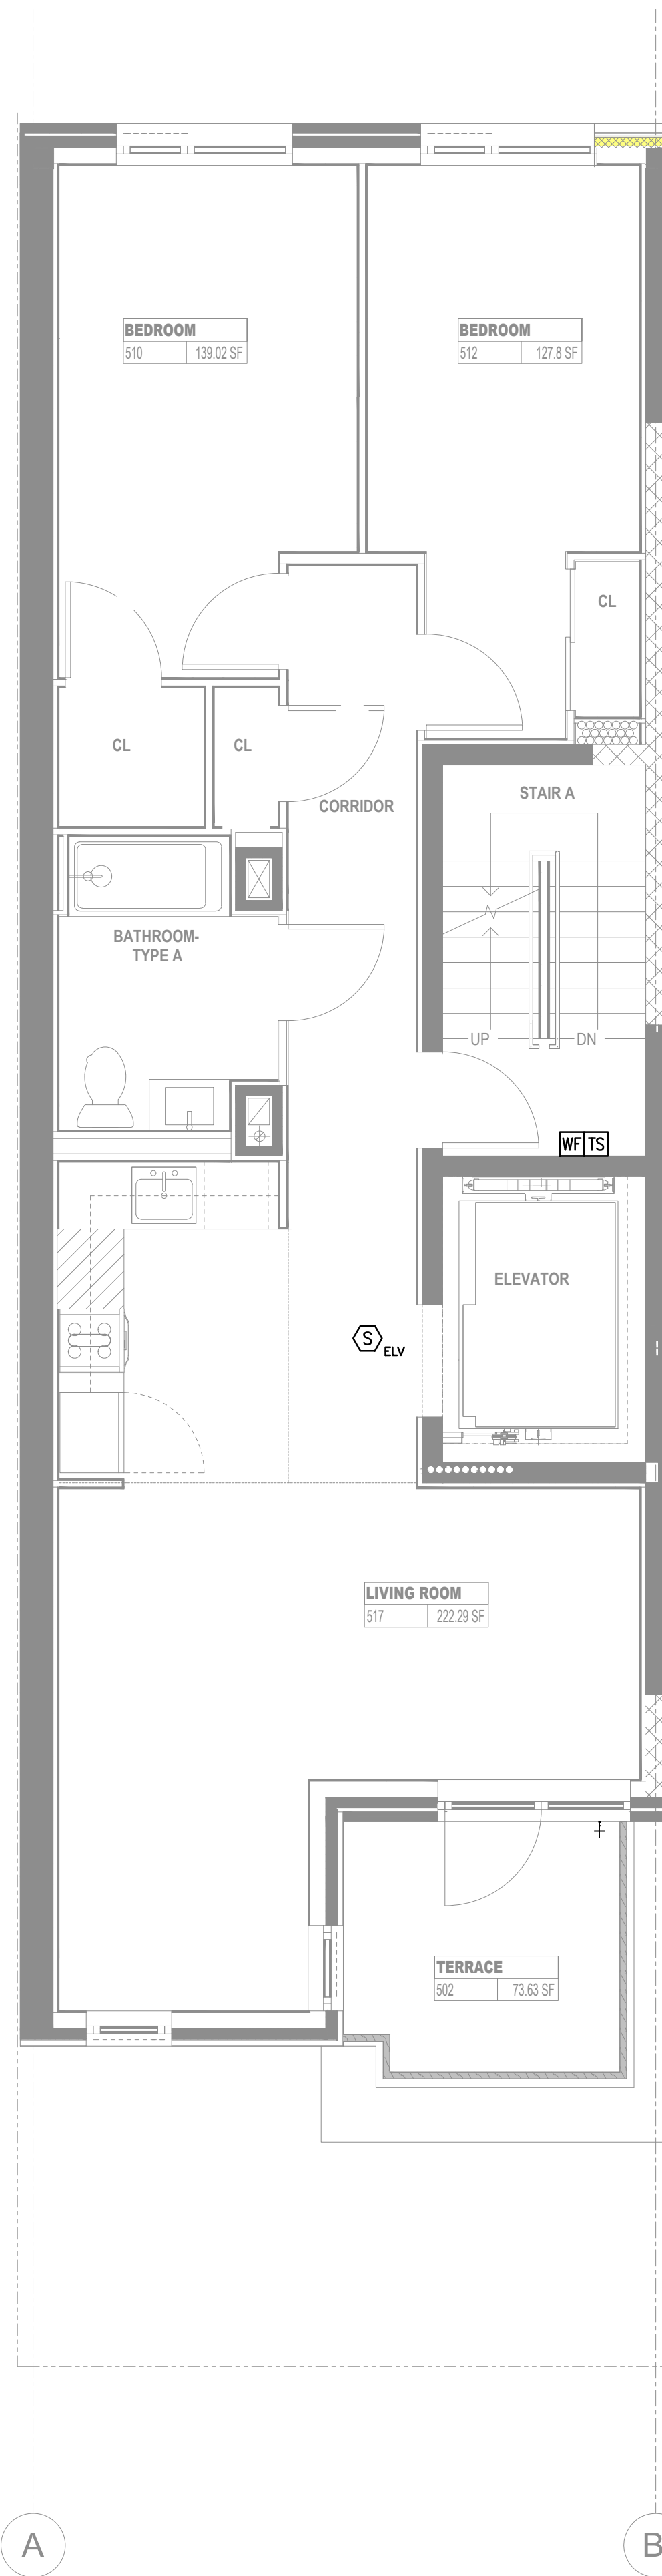

1 MIH-5TH FLOOR FIRE ALARM PLAN
SCALE: 1/4"=1'-0"

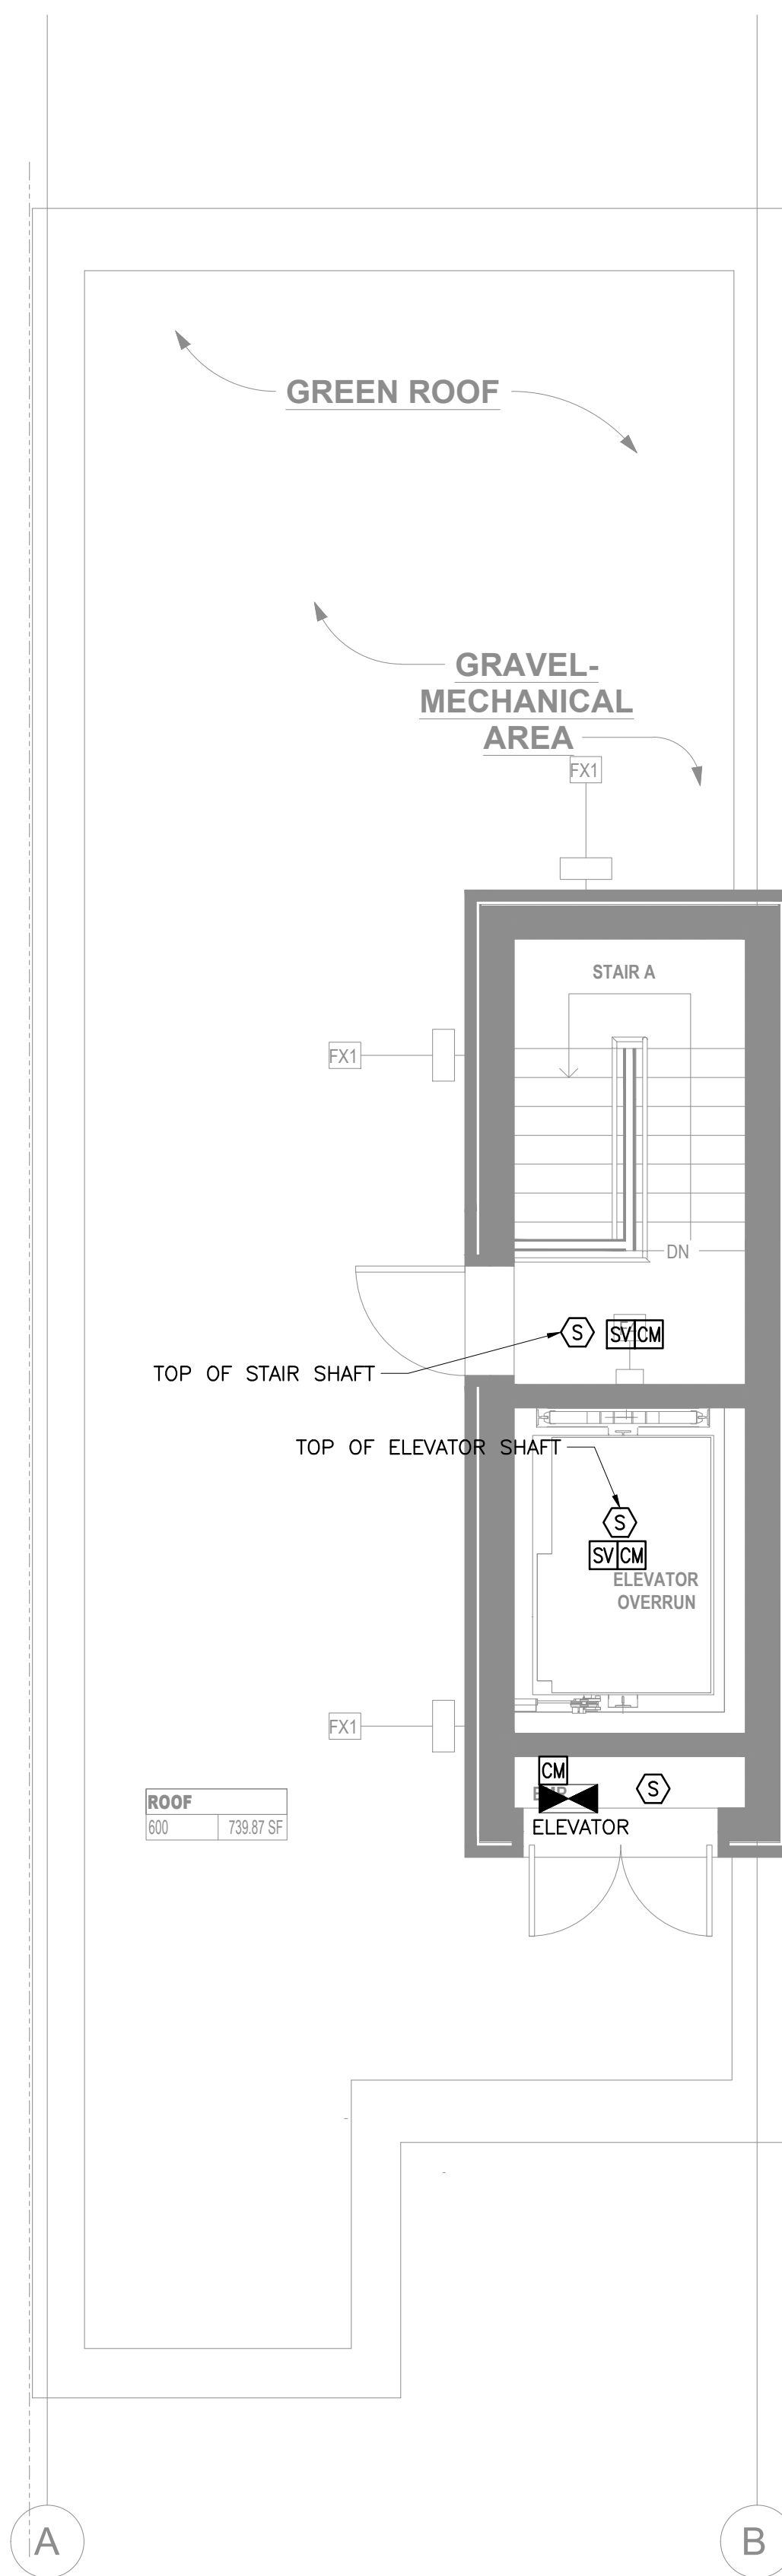

2 ROOF FIRE ALARM PLAN
SCALE: 1/4"=1'-0"

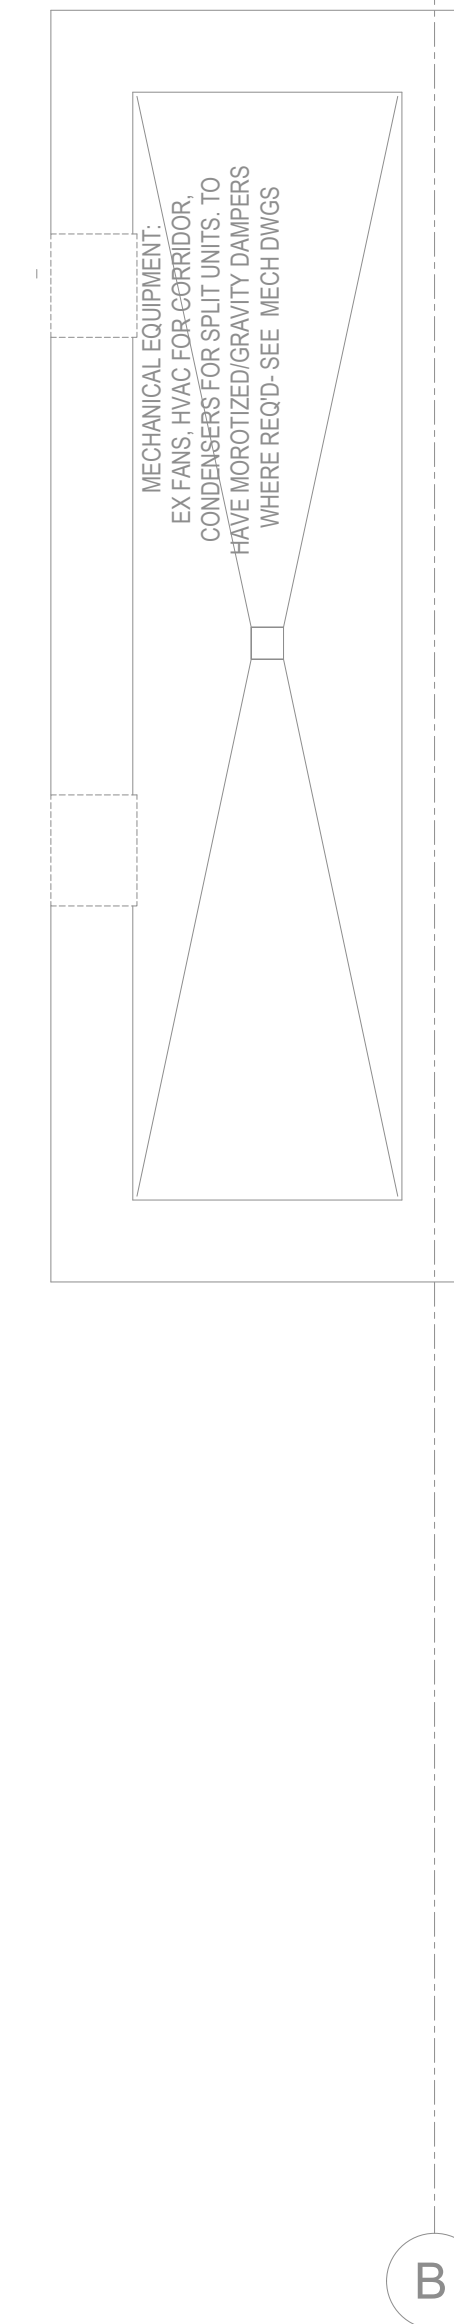

3 BULKHEAD FIRE ALARM
SCALE: 1/4"=1'-0"

FIRE ALARM DRAWING NOTES:

1. REFER TO DWG. FA-001.00 FOR FIRE ALARM SYMBOL LIST, ABBREVIATIONS, BUILDING DATA AND I/O MATRIX.
2. REFER TO DWG. FA-004.00 FOR FIRE ALARM SYSTEM RISER DIAGRAM.
3. FINAL CONDUIT/CABLE ROUTING SHALL BE DETERMINED IN-FIELD, AND PRIOR TO THE COMMENCEMENT OF WORK, COORDINATED WITH OTHER TRADE CONTRACTORS AND THE OWNER.
4. NO CO PRODUCING EQUIPMENTS LOCATED ON FLOOR, FLOOR ABOVE OR FLOOR BELOW.