


Property of NY Engineers

1 UNDERGROUND PLUMBING PLAN
 SCALE: 3/16" = 1'-0"

DOB STAMP

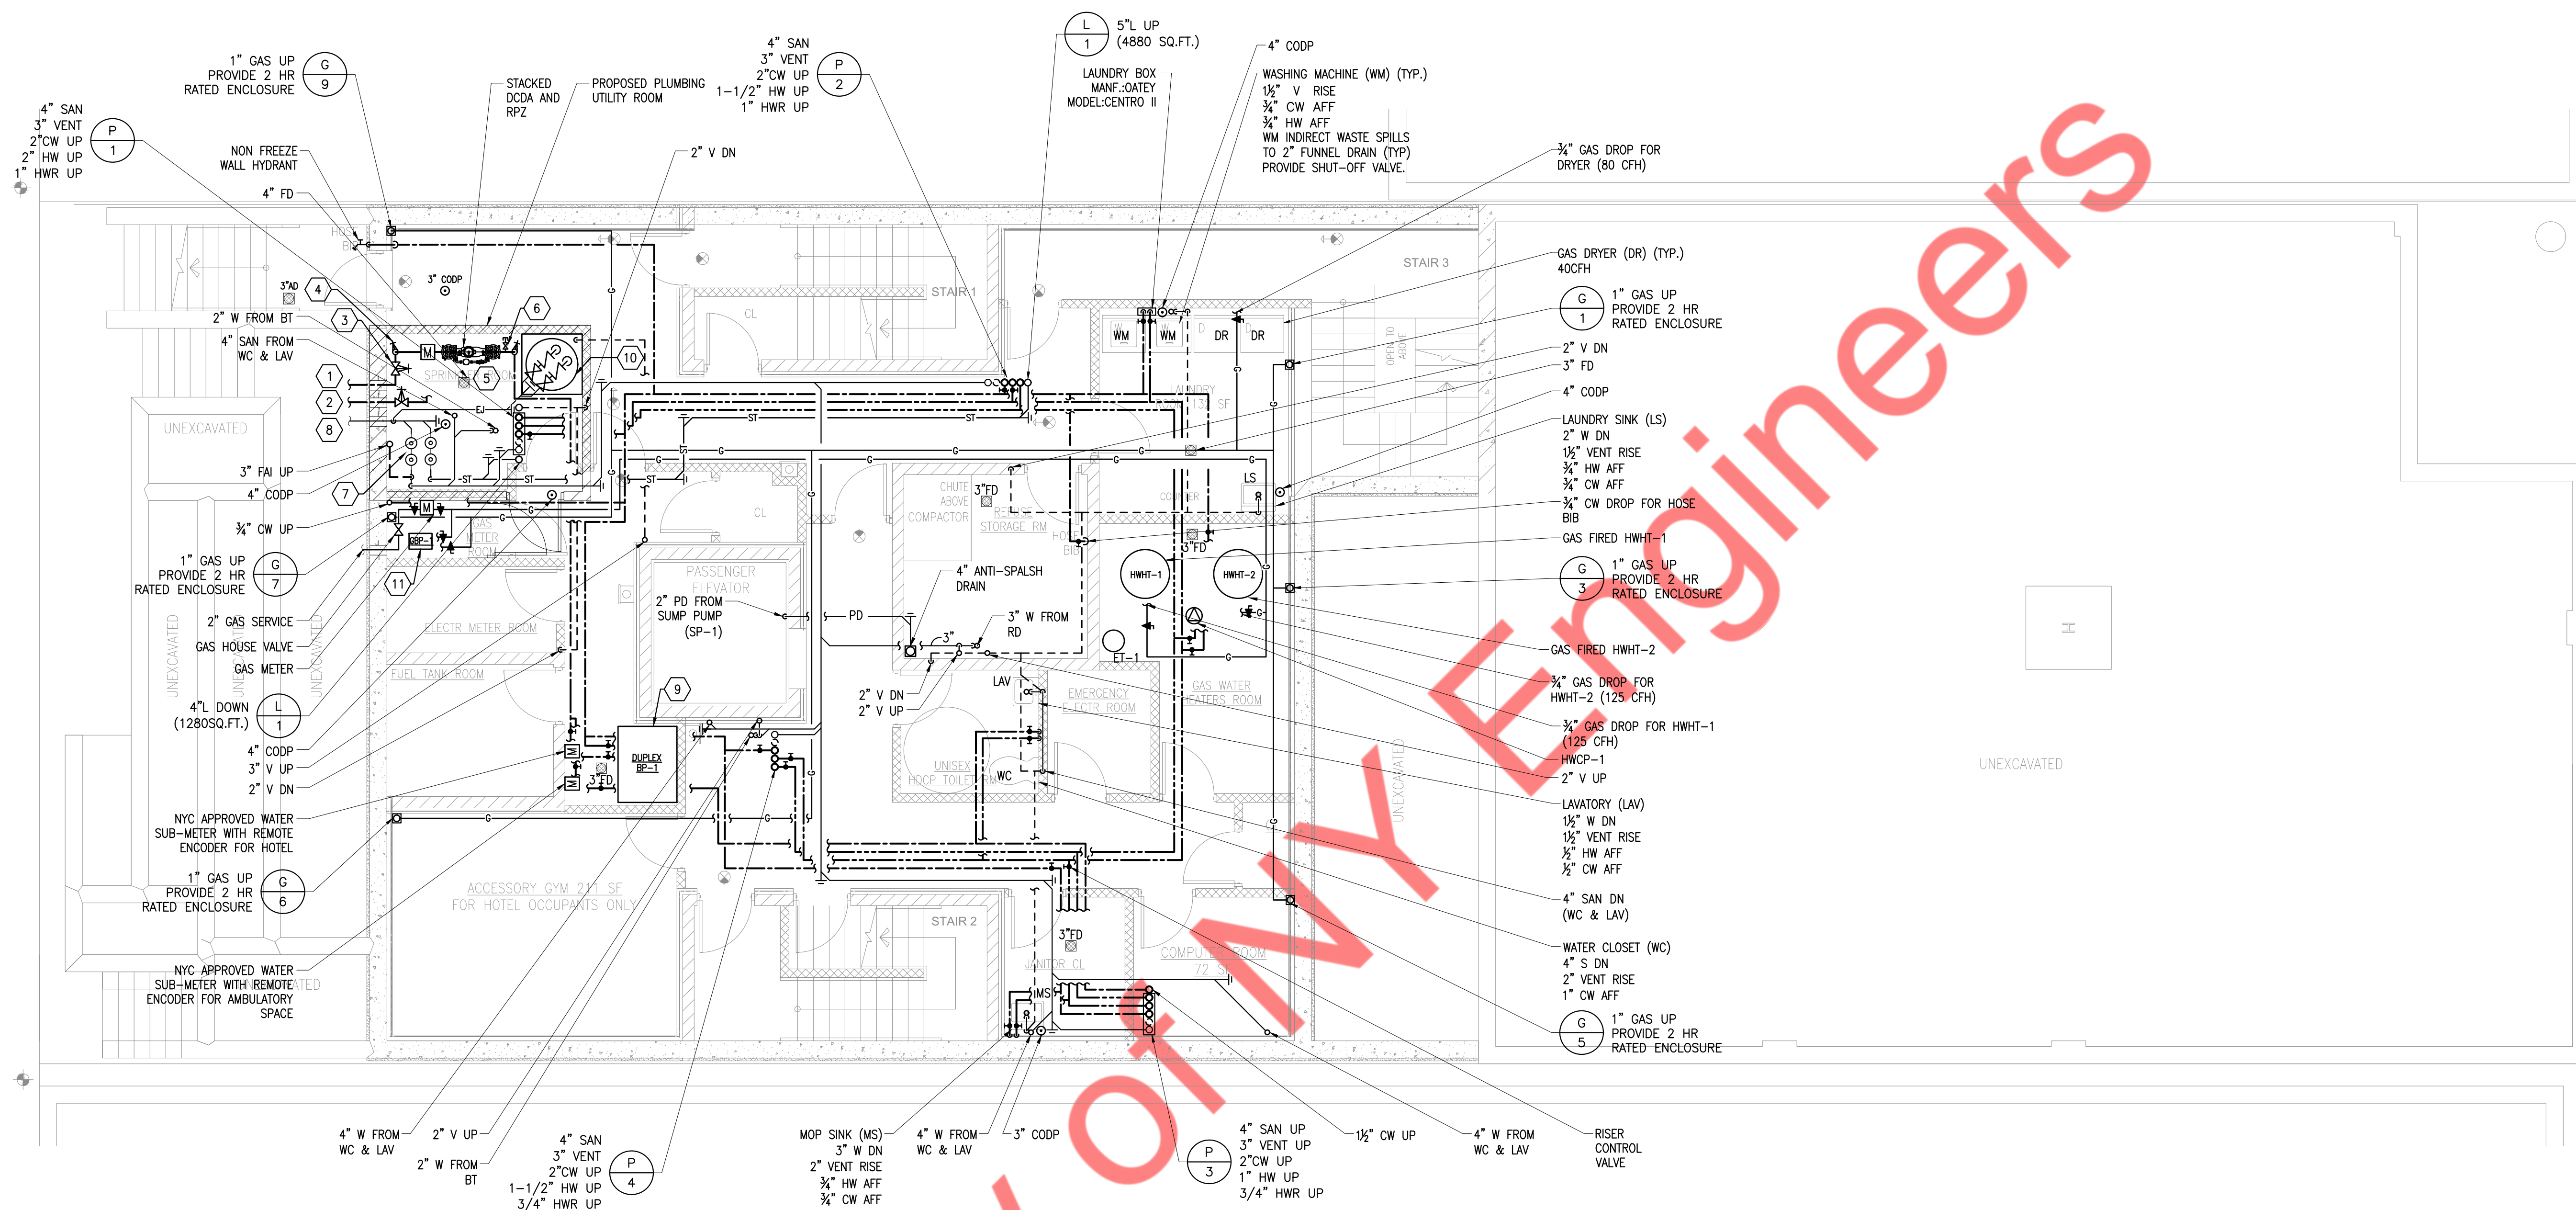


PLUMBING LEGEND			
1	NEW 2½" DOMESTIC WATER SERVICE	7	4" SANITARY & 8" STORM HOUSE TRAP
2	NEW 4" FIRE WATER SERVICE WITH 4" HOUSE GATE VALVE (OS&Y TYPE)	8	8" COMBINED SANITARY/STORM SEWER
3	2½" HOUSE GATE VALVE	9	DOMESTIC WATER DUPLEX BOOSTER PUMP (BP-1)
4	2½" MICV WITH NYC APPROVED WATER METER.	10	DUPLEX SEWAGE EJECTOR (SE-1) IN (36" DIA. x 60" DEEP) PIT WITH EMERGENCY ALARM SYSTEM
5	STACKED 4" DCDA FOR FIRE AT 2'-6" & 2½" DOMESTIC BACKFLOW PREVENTER RPZ TYPE AT 6"-10".	11	GAS BOOSTER PUMP (GBP-1)
6	2" TEST TEE & 2½" MOCV		

1 CELLAR PLUMBING PLAN
SCALE: 3/16" = 1'-0"

GENERAL NOTE:
 1. FOR PIPE SIZES, REFER TO PLUMBING RISER DIAGRAM.
 2. FOR BFP DETAIL REFER APPROVED BFP APPLICATION DRAWINGS
 3. ALL WATER PIPING SHOULD BE PROVIDED WITH INSULATION ACCORDING TO NYC ECC 2016.
 4. HEAT TRAP, SUPPLY AND DISCHARGE PIPING ASSOCIATED WITH EQUIPMENT FOR NON-CIRCULATION SYSTEM AS PER NYC ECC 2016.

DOB STAMP

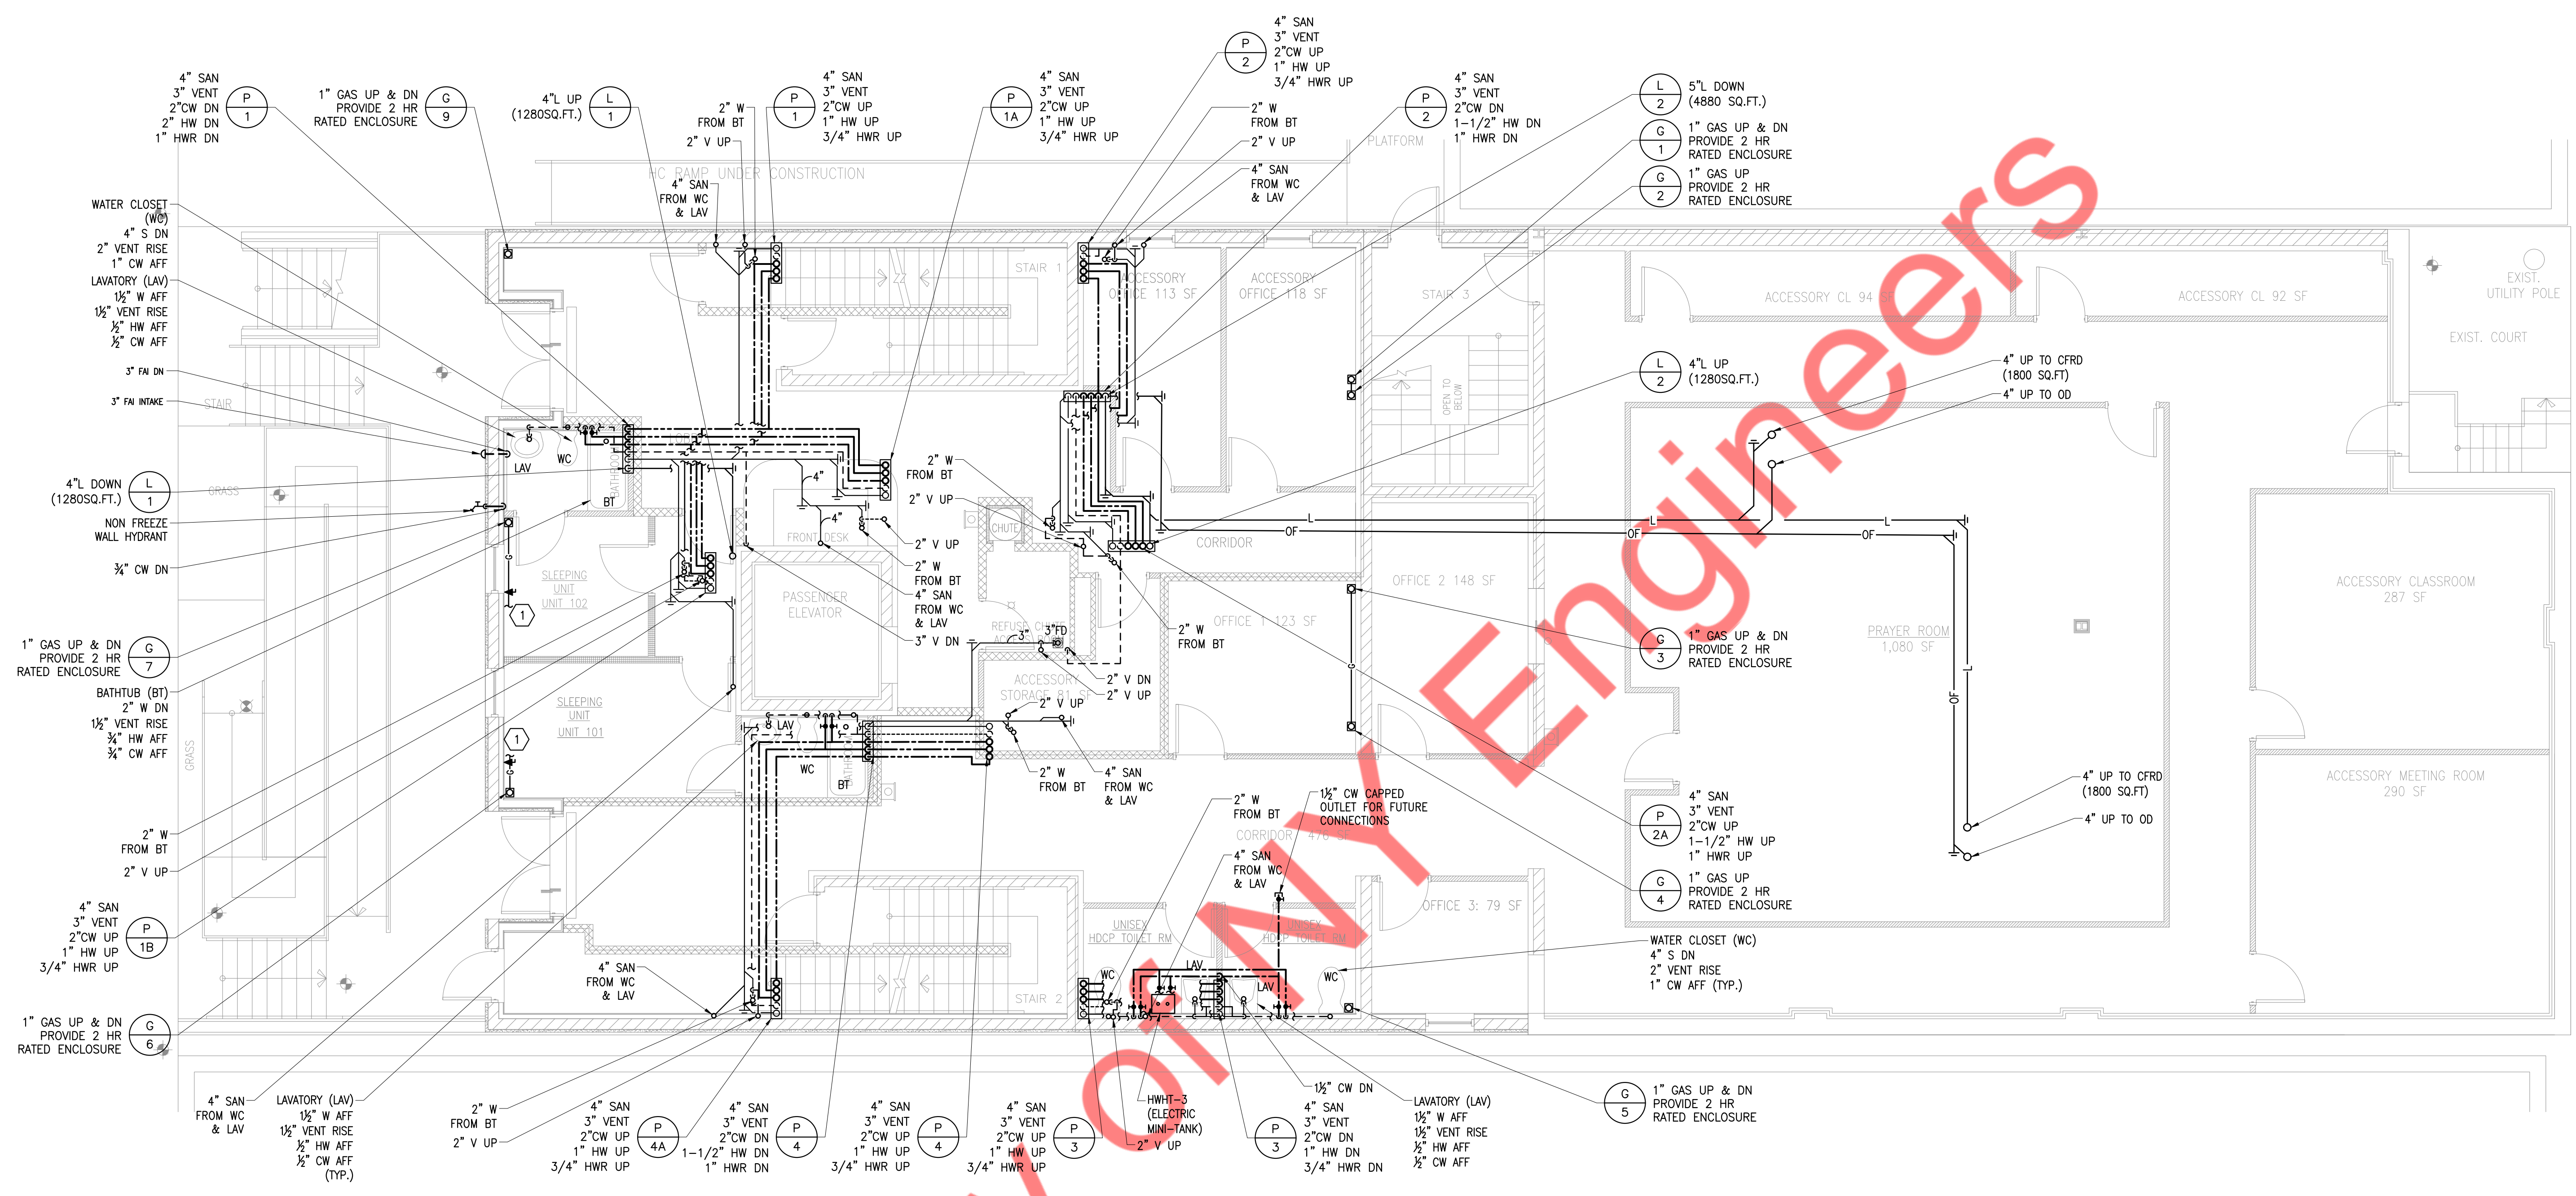


- GENERAL NOTE:
1. FOR PIPE SIZES, REFER TO PLUMBING RISER DIAGRAM.
 2. ALL WATER PIPING SHOULD BE PROVIDED WITH INSULATION ACCORDING TO NYC ECC 2016.
 3. HEAT TRAP, SUPPLY AND DISCHARGE PIPING ASSOCIATED WITH EQUIPMENT FOR NON-CIRCULATION SYSTEM AS PER NYC ECC 2016.

KEYED NOTES:
 (1) 3/4" GAS DROP FOR PTAC-1 (12 CFH)

1 FIRST FLOOR PLUMBING PLAN
 SCALE: 3/16" = 1'-0"


DOB STAMP

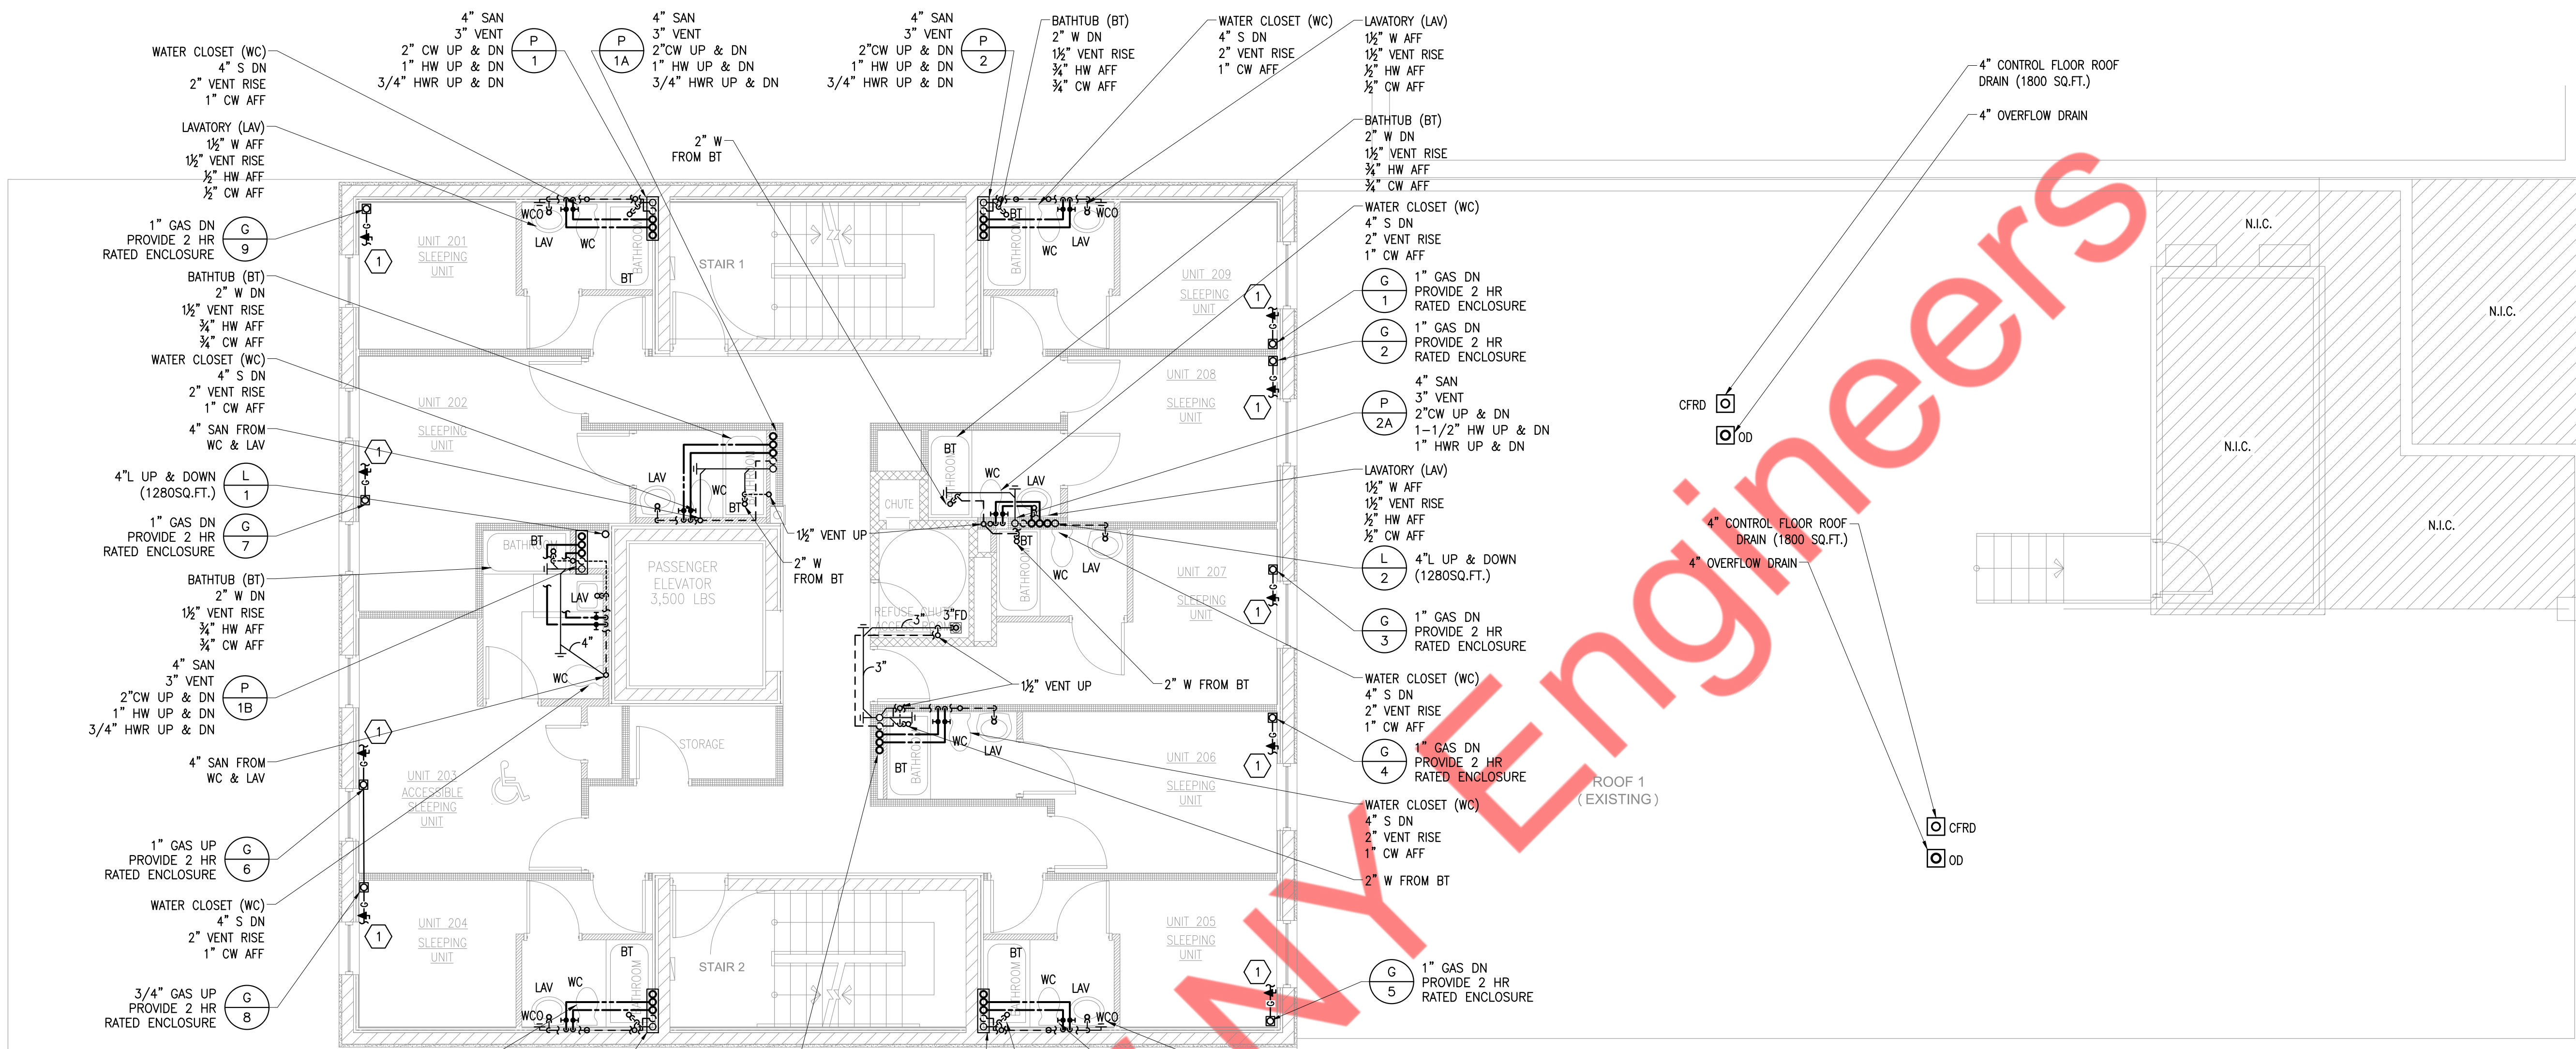

1 SECOND FLOOR PLUMBING PLAN
SCALE: 3/32" = 1'-0"

- GENERAL NOTE:
1. FOR PIPE SIZES, REFER TO PLUMBING RISER DIAGRAM.
 2. ALL WATER PIPING SHOULD BE PROVIDED WITH INSULATION ACCORDING TO NYC ECC 2016.
 3. HEAT TRAP, SUPPLY AND DISCHARGE PIPING ASSOCIATED WITH EQUIPMENT FOR NON-CIRCULATION SYSTEM AS PER NYC ECC 2016.
- KEYED NOTES:
- 1 3/4" GAS DROP FOR PTAC-1 (12 CFH)

DOB STAMP

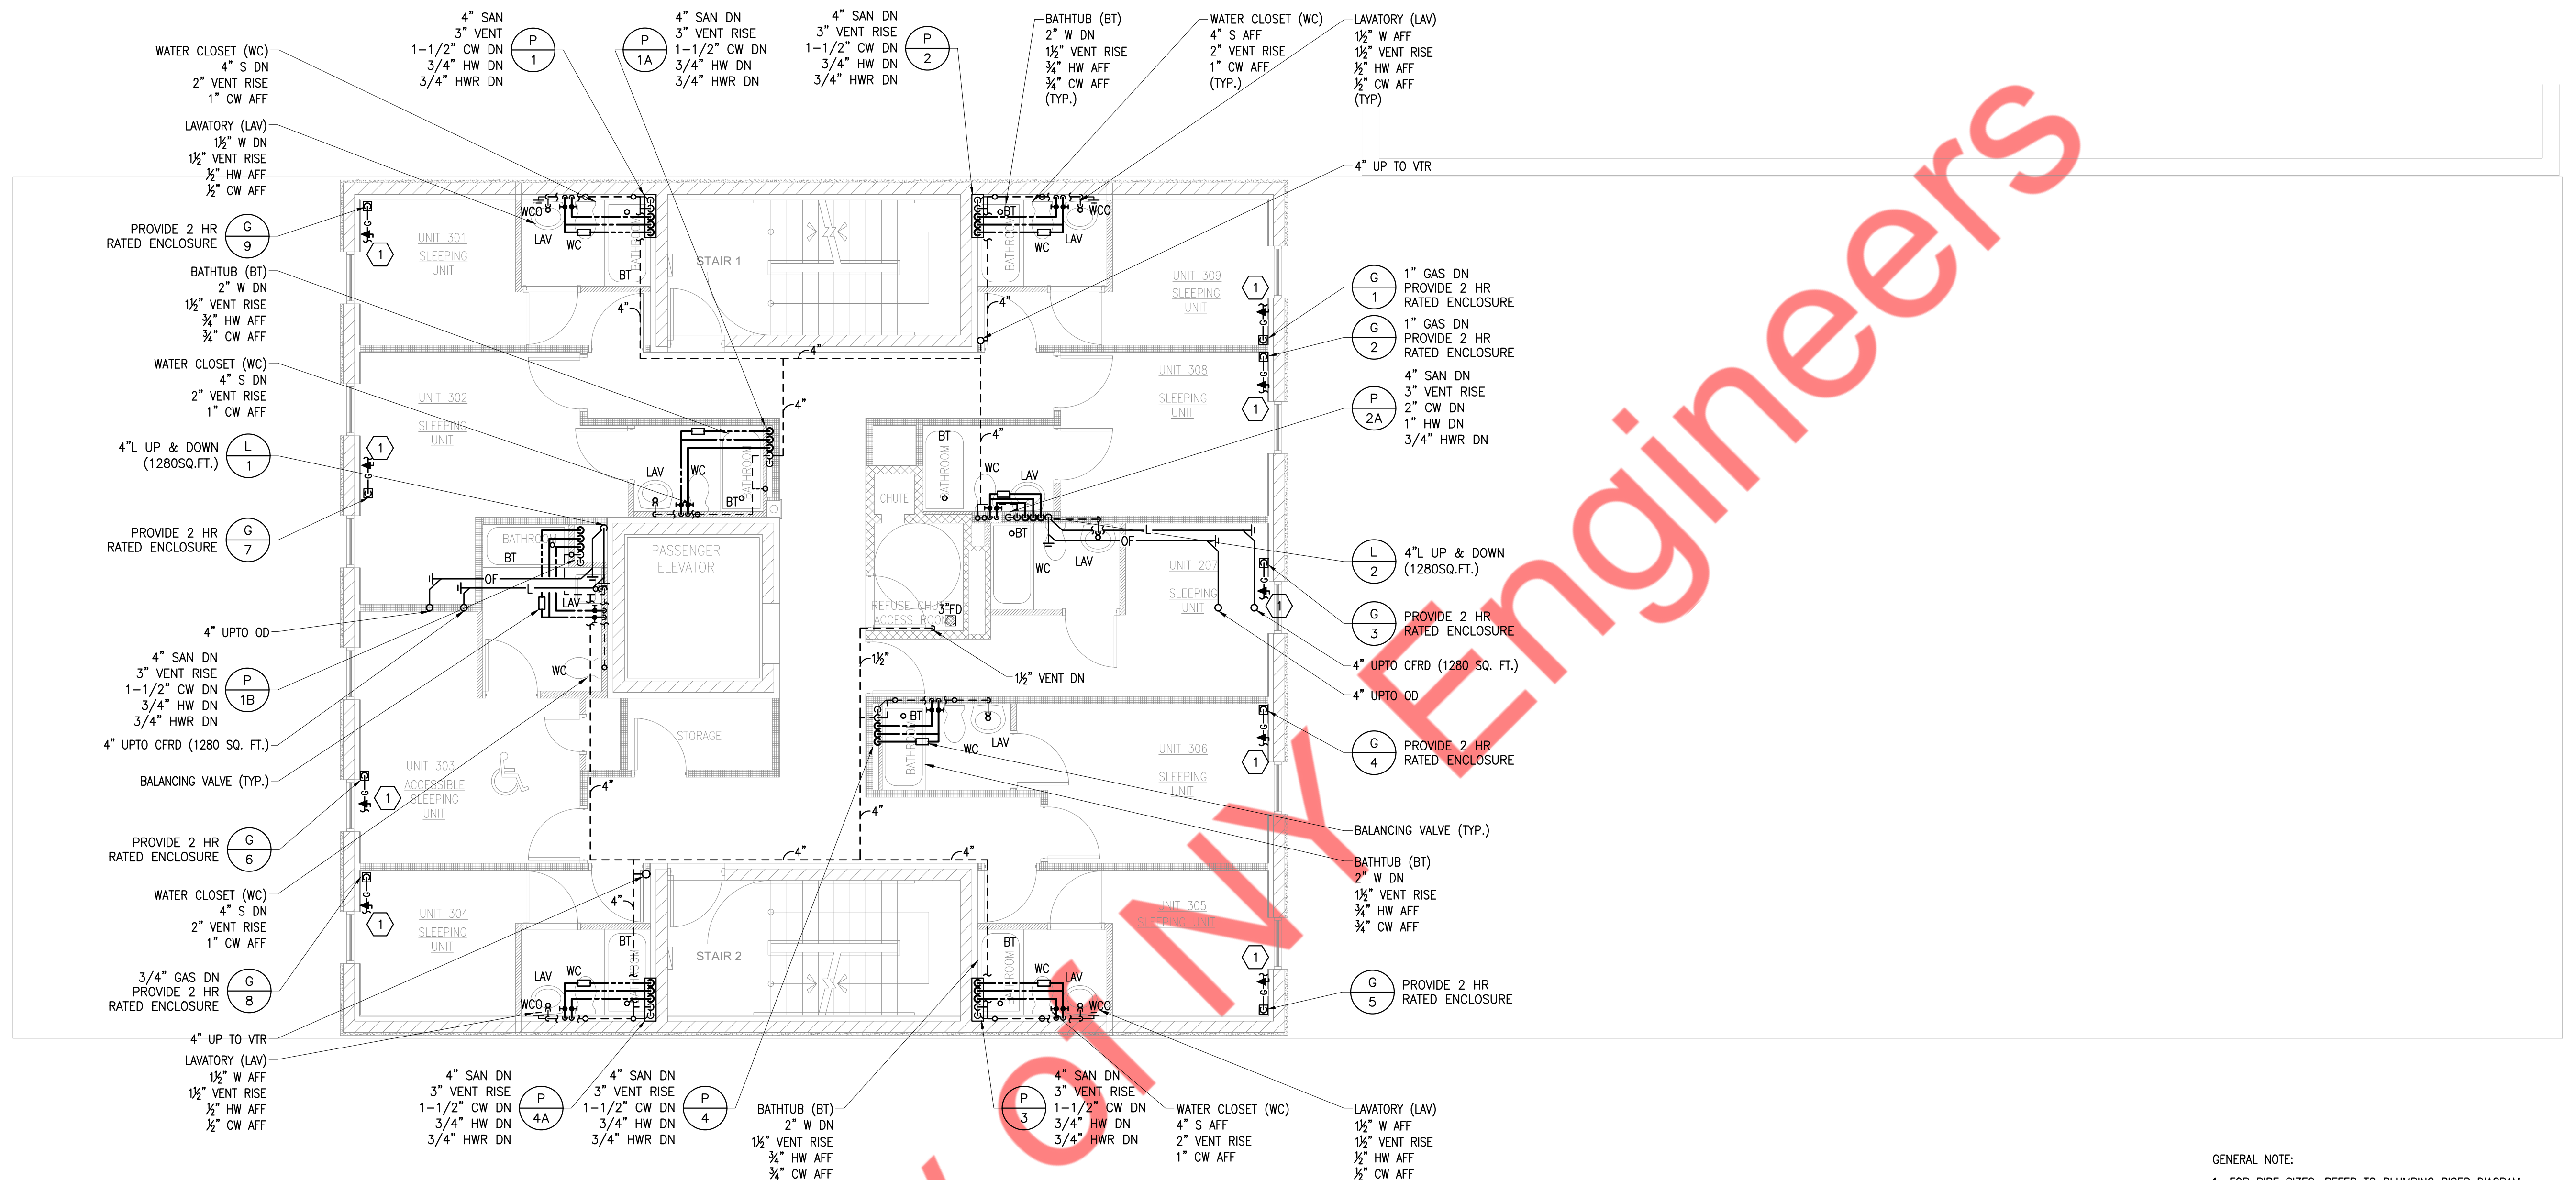


- GENERAL NOTE:
1. FOR PIPE SIZES, REFER TO PLUMBING RISER DIAGRAM.
 2. ALL WATER PIPING SHOULD BE PROVIDED WITH INSULATION ACCORDING TO NYC ECC 2016.
 3. HEAT TRAP SUPPLY AND DISCHARGE PIPING ASSOCIATED WITH EQUIPMENT FOR NON-CIRCULATION SYSTEM AS PER NYC ECC 2016.

- KEYED NOTES:
- (1) 3/4" GAS DROP FOR PTAC-1 (12 CFH)

1 THIRD FLOOR PLUMBING PLAN
SCALE: 3/16" = 1'-0"

DOB STAMP

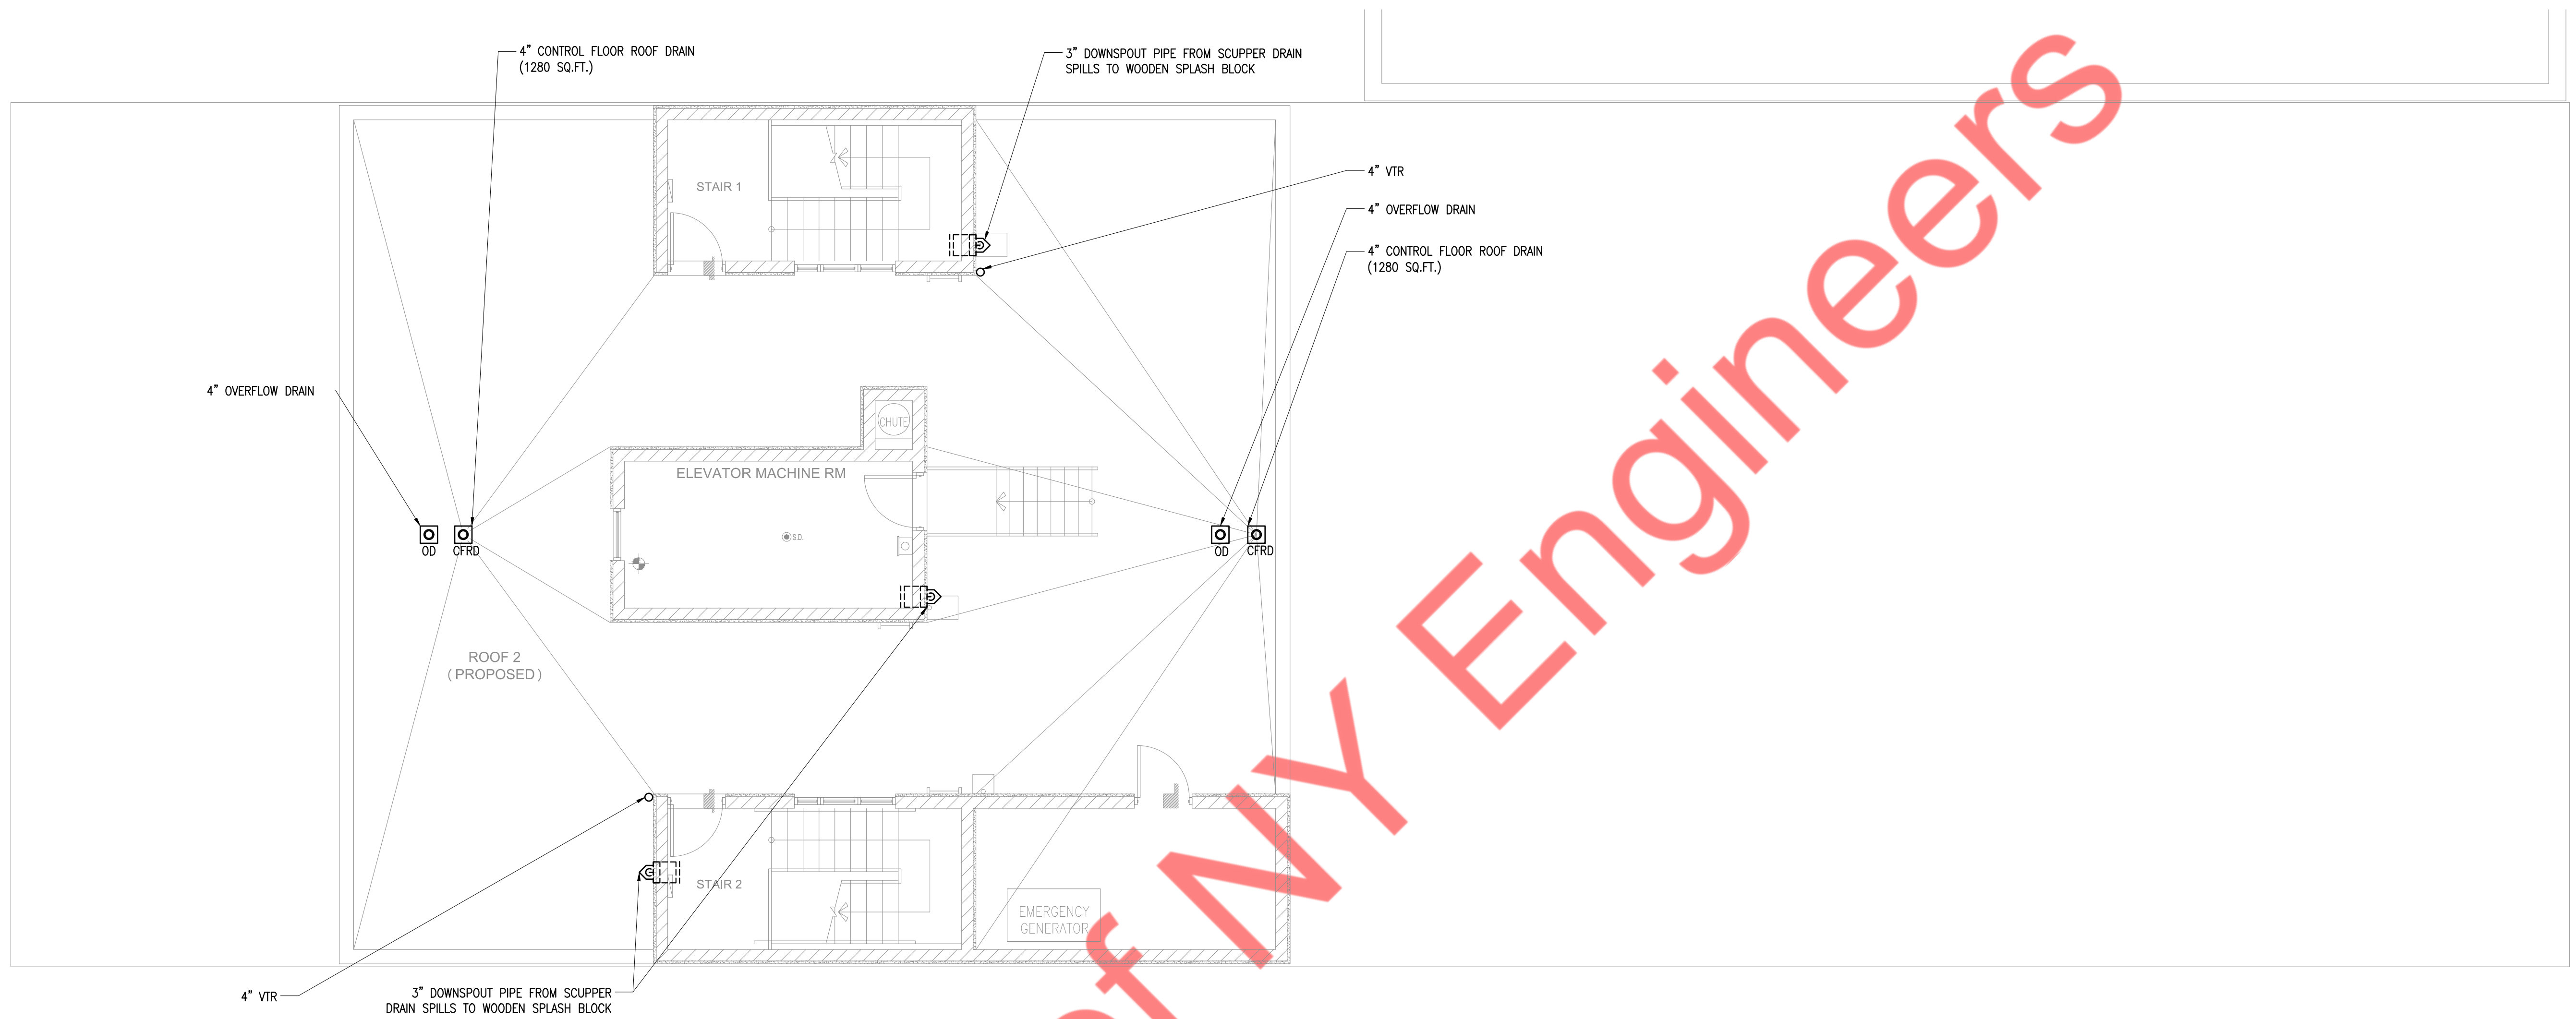

Property of NY Engineers

1 ROOF PLUMBING PLAN
SCALE: 3/16" = 1'-0"

DOB STAMP