



NOTE:
1. WATER SERVICE PIPING TO BE PROVIDED WITH INSULATION AS PER NYC ECC 2016, C404.4.
2. PROVIDE HEAT TRAP ON SUPPLY AND DISCHARGE PIPING ASSOCIATED WITH EQUIPMENTS FOR NON-CIRCULATING SYSTEMS AS PER NYC ECC 2016, C404.3.
3. PROVIDE CONTROLS FOR AUTOMATIC CIRCULATION OF HOT WATER SYSTEM AS PER NYC ECC 2016, C404.6.

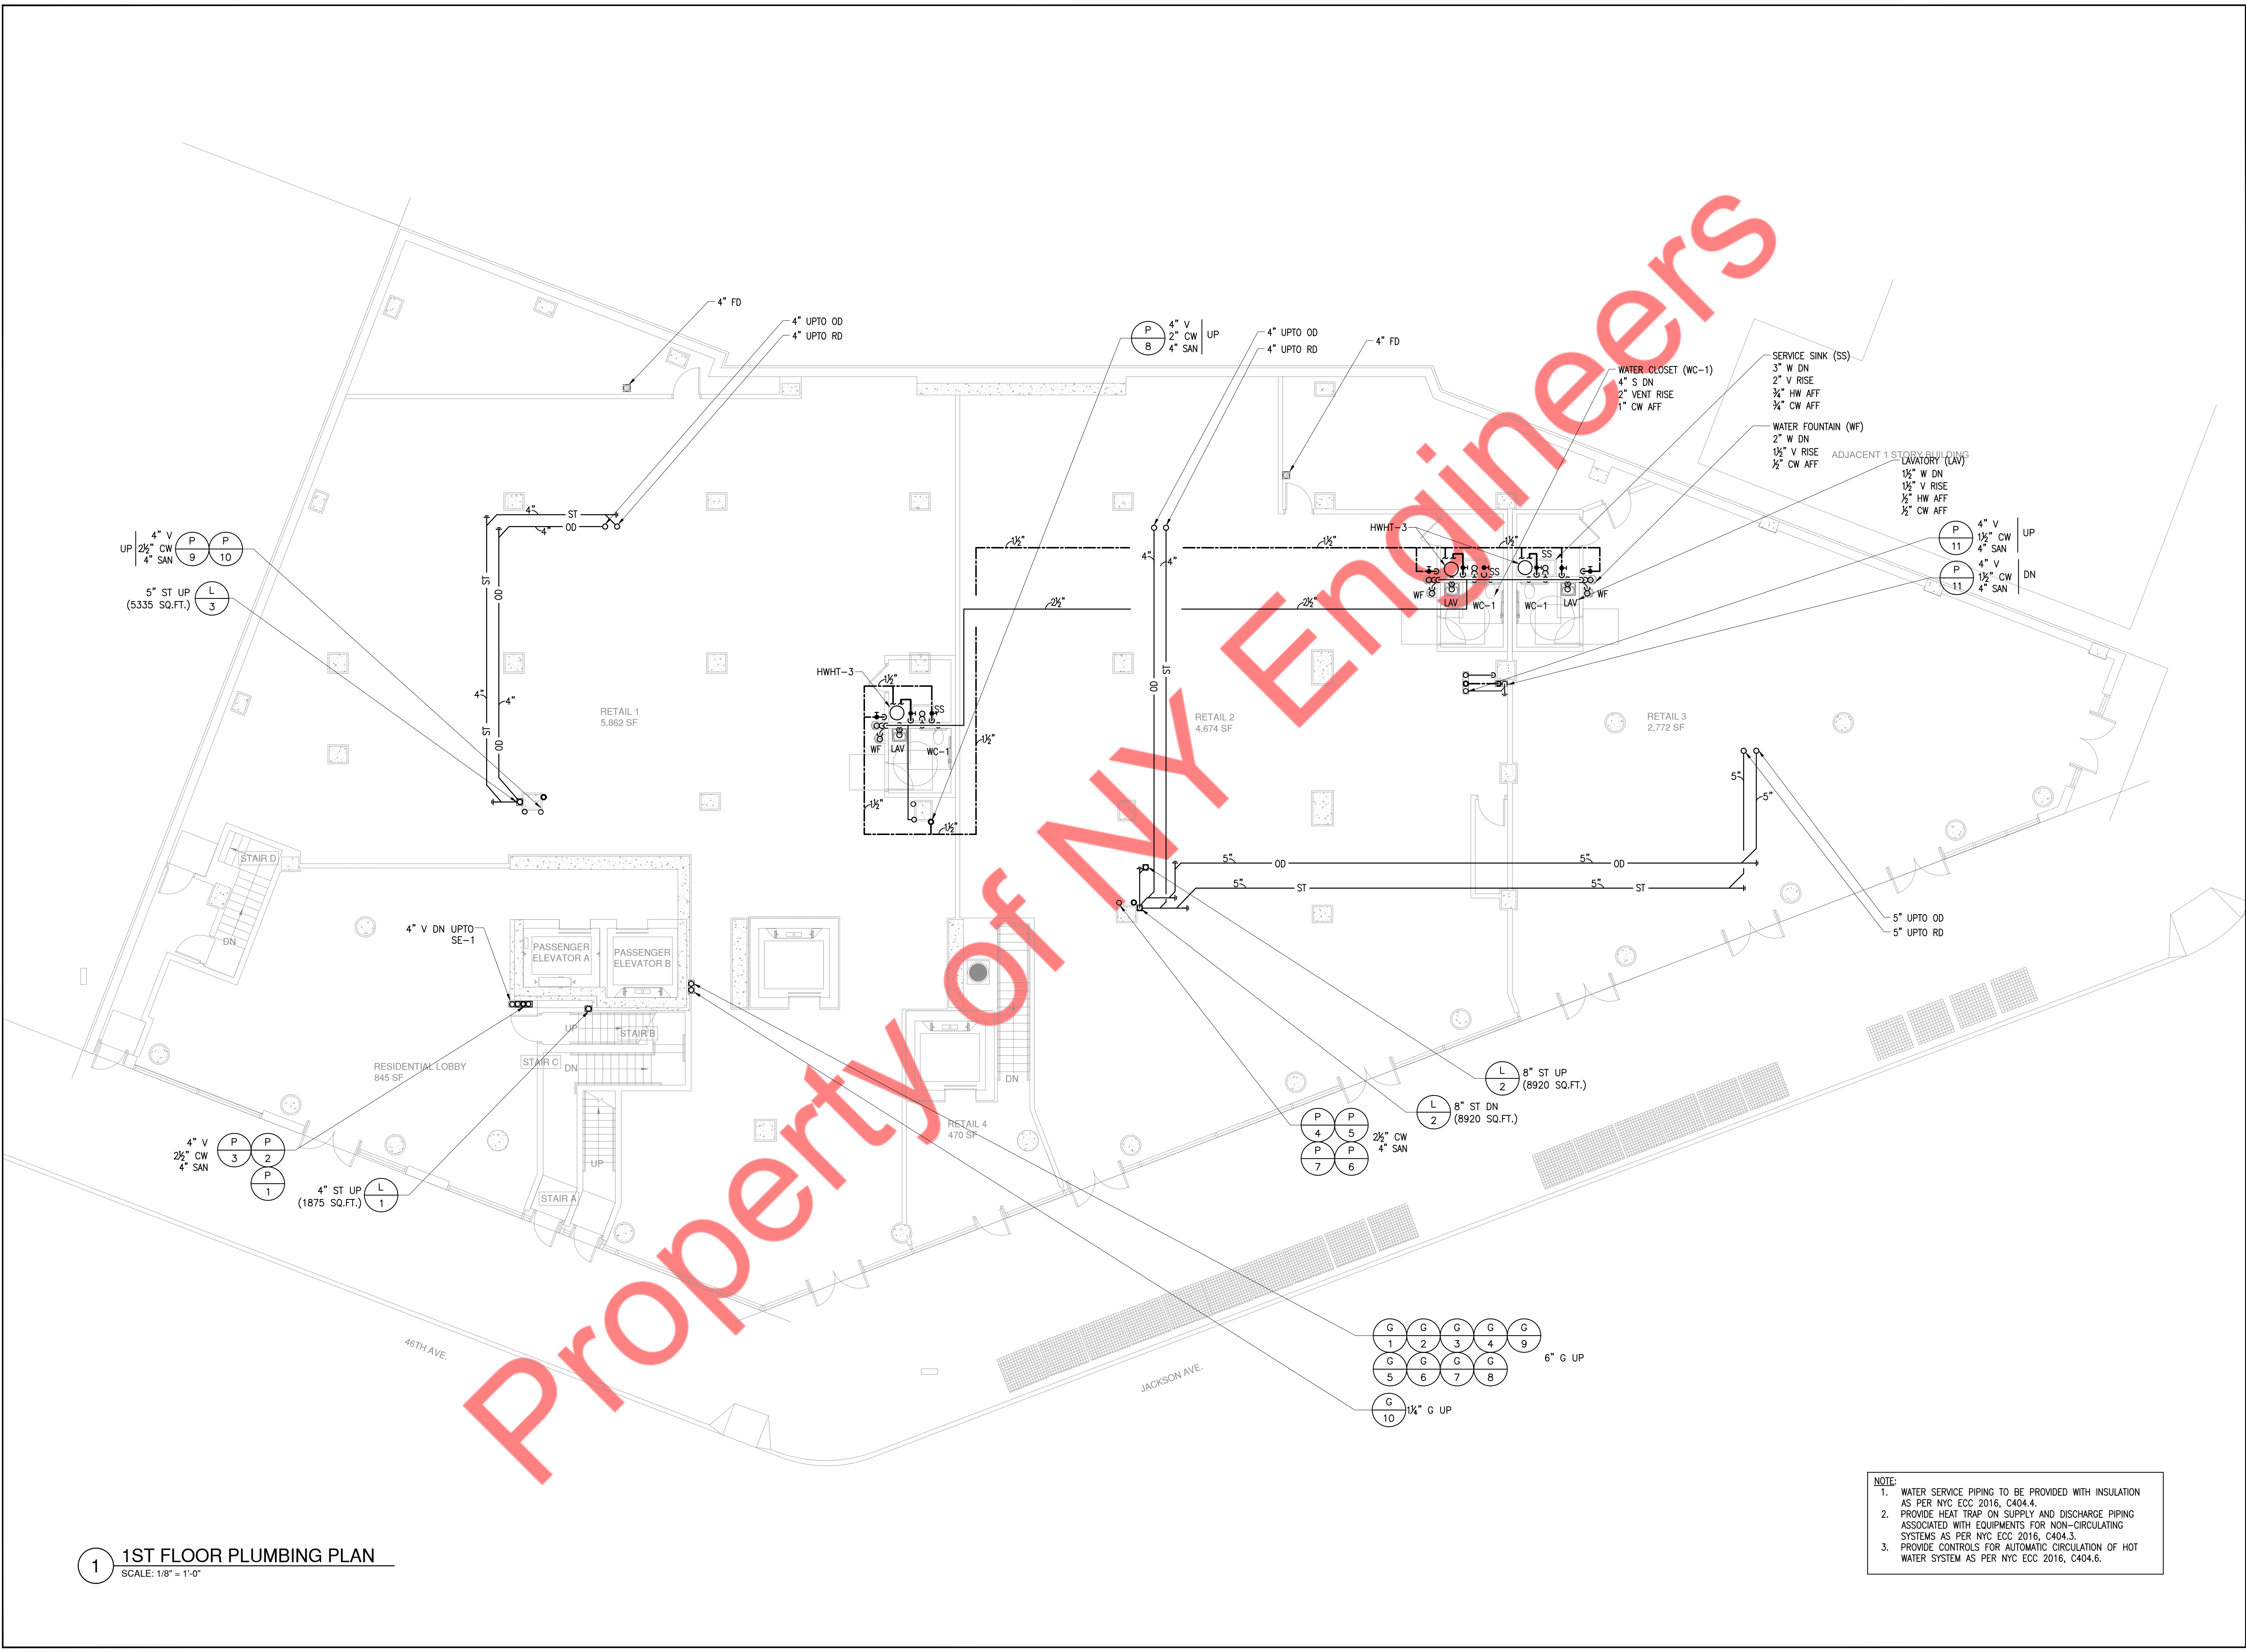

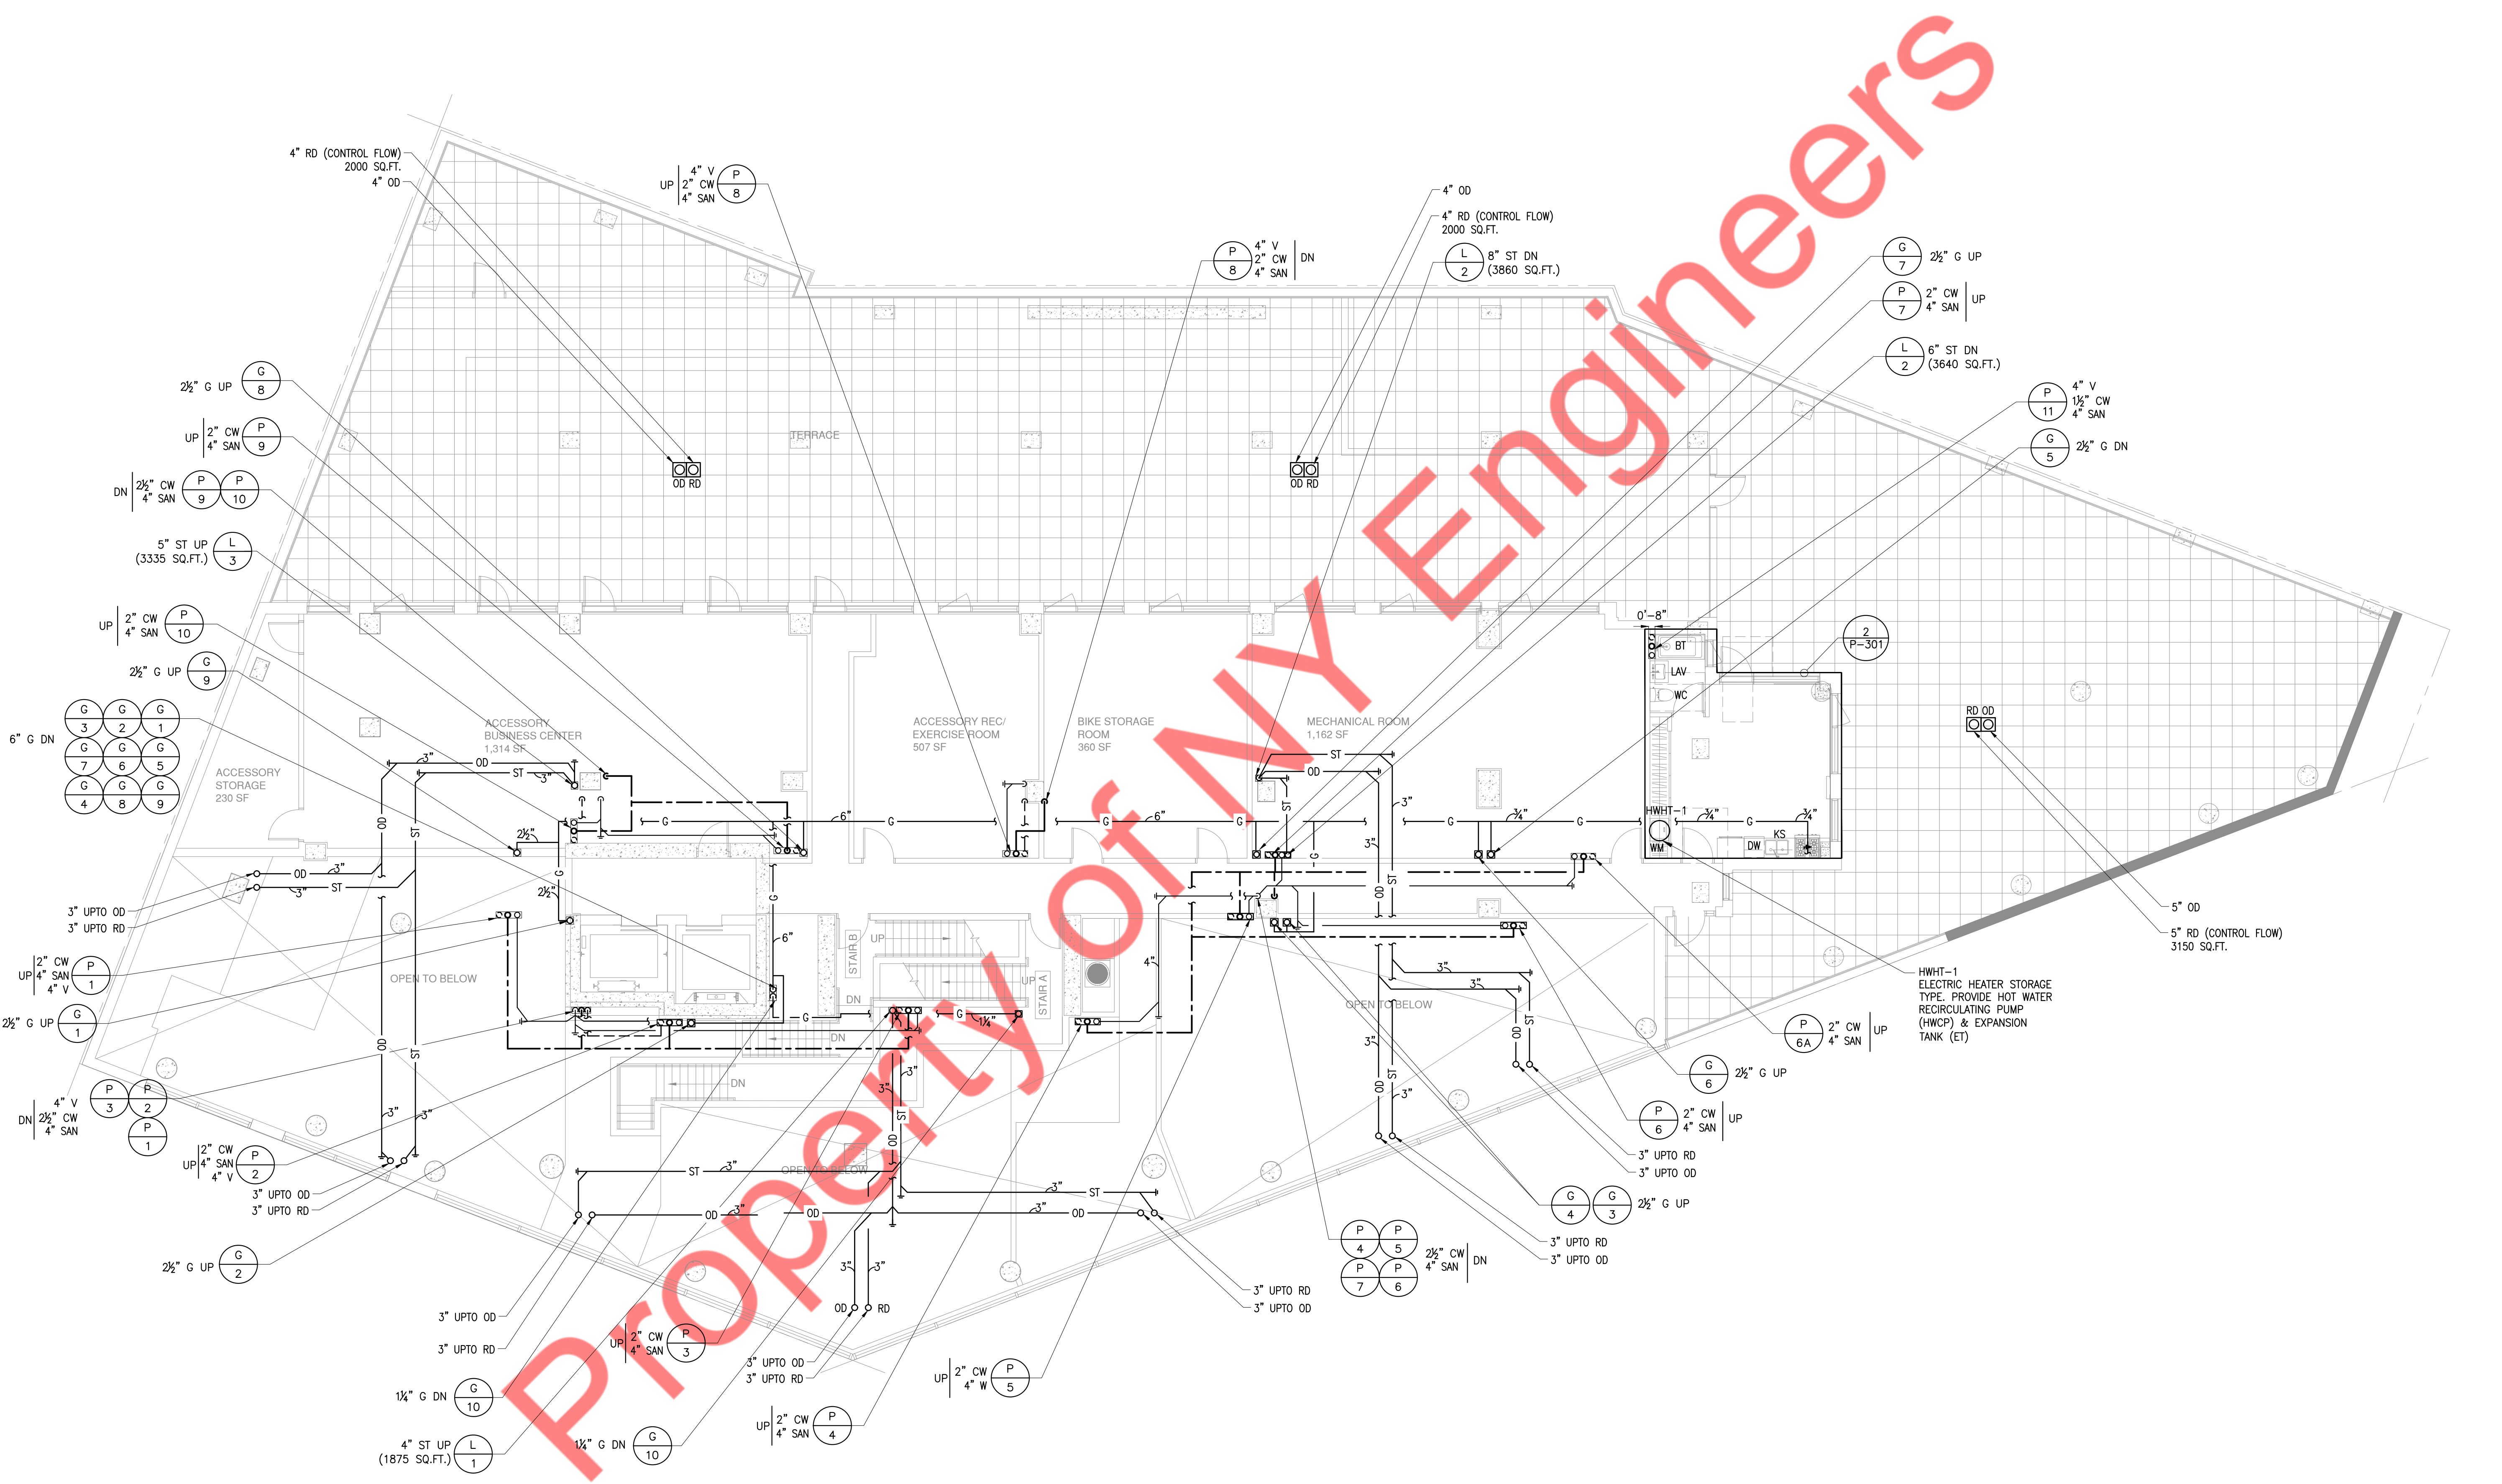


1 2ND FLOOR PLUMBING PLAN
SCALE: 1/8" = 1'-0"


- NOTE:
1. WATER SERVICE PIPING TO BE PROVIDED WITH INSULATION AS PER NYC ECC 2016, C404.4.
 2. PROVIDE HEAT TRAP ON SUPPLY AND DISCHARGE PIPING ASSOCIATED WITH EQUIPMENTS FOR NON-CIRCULATING SYSTEMS AS PER NYC ECC 2016, C404.3.
 3. PROVIDE CONTROLS FOR AUTOMATIC CIRCULATION OF HOT WATER SYSTEM AS PER NYC ECC 2016, C404.6.

1 TYPICAL 7TH & 8TH FLOOR PLUMBING PLAN
SCALE: 1/8" = 1'-0"


- NOTE:
1. WATER SERVICE PIPING TO BE PROVIDED WITH INSULATION AS PER NYC ECC 2016, C404.4.
 2. PROVIDE HEAT TRAP ON SUPPLY AND DISCHARGE PIPING ASSOCIATED WITH EQUIPMENTS FOR NON-CIRCULATING SYSTEMS AS PER NYC ECC 2016, C404.3.
 3. PROVIDE CONTROLS FOR AUTOMATIC CIRCULATION OF HOT WATER SYSTEM AS PER NYC ECC 2016, C404.6.

- NOTE:
1. WATER SERVICE PIPING TO BE PROVIDED WITH INSULATION AS PER NYC ECC 2016, C404.4.
 2. PROVIDE HEAT TRAP ON SUPPLY AND DISCHARGE PIPING ASSOCIATED WITH EQUIPMENTS FOR NON-CIRCULATING SYSTEMS AS PER NYC ECC 2016, C404.3.
 3. PROVIDE CONTROLS FOR AUTOMATIC CIRCULATION OF HOT WATER SYSTEM AS PER NYC ECC 2016, C404.6.

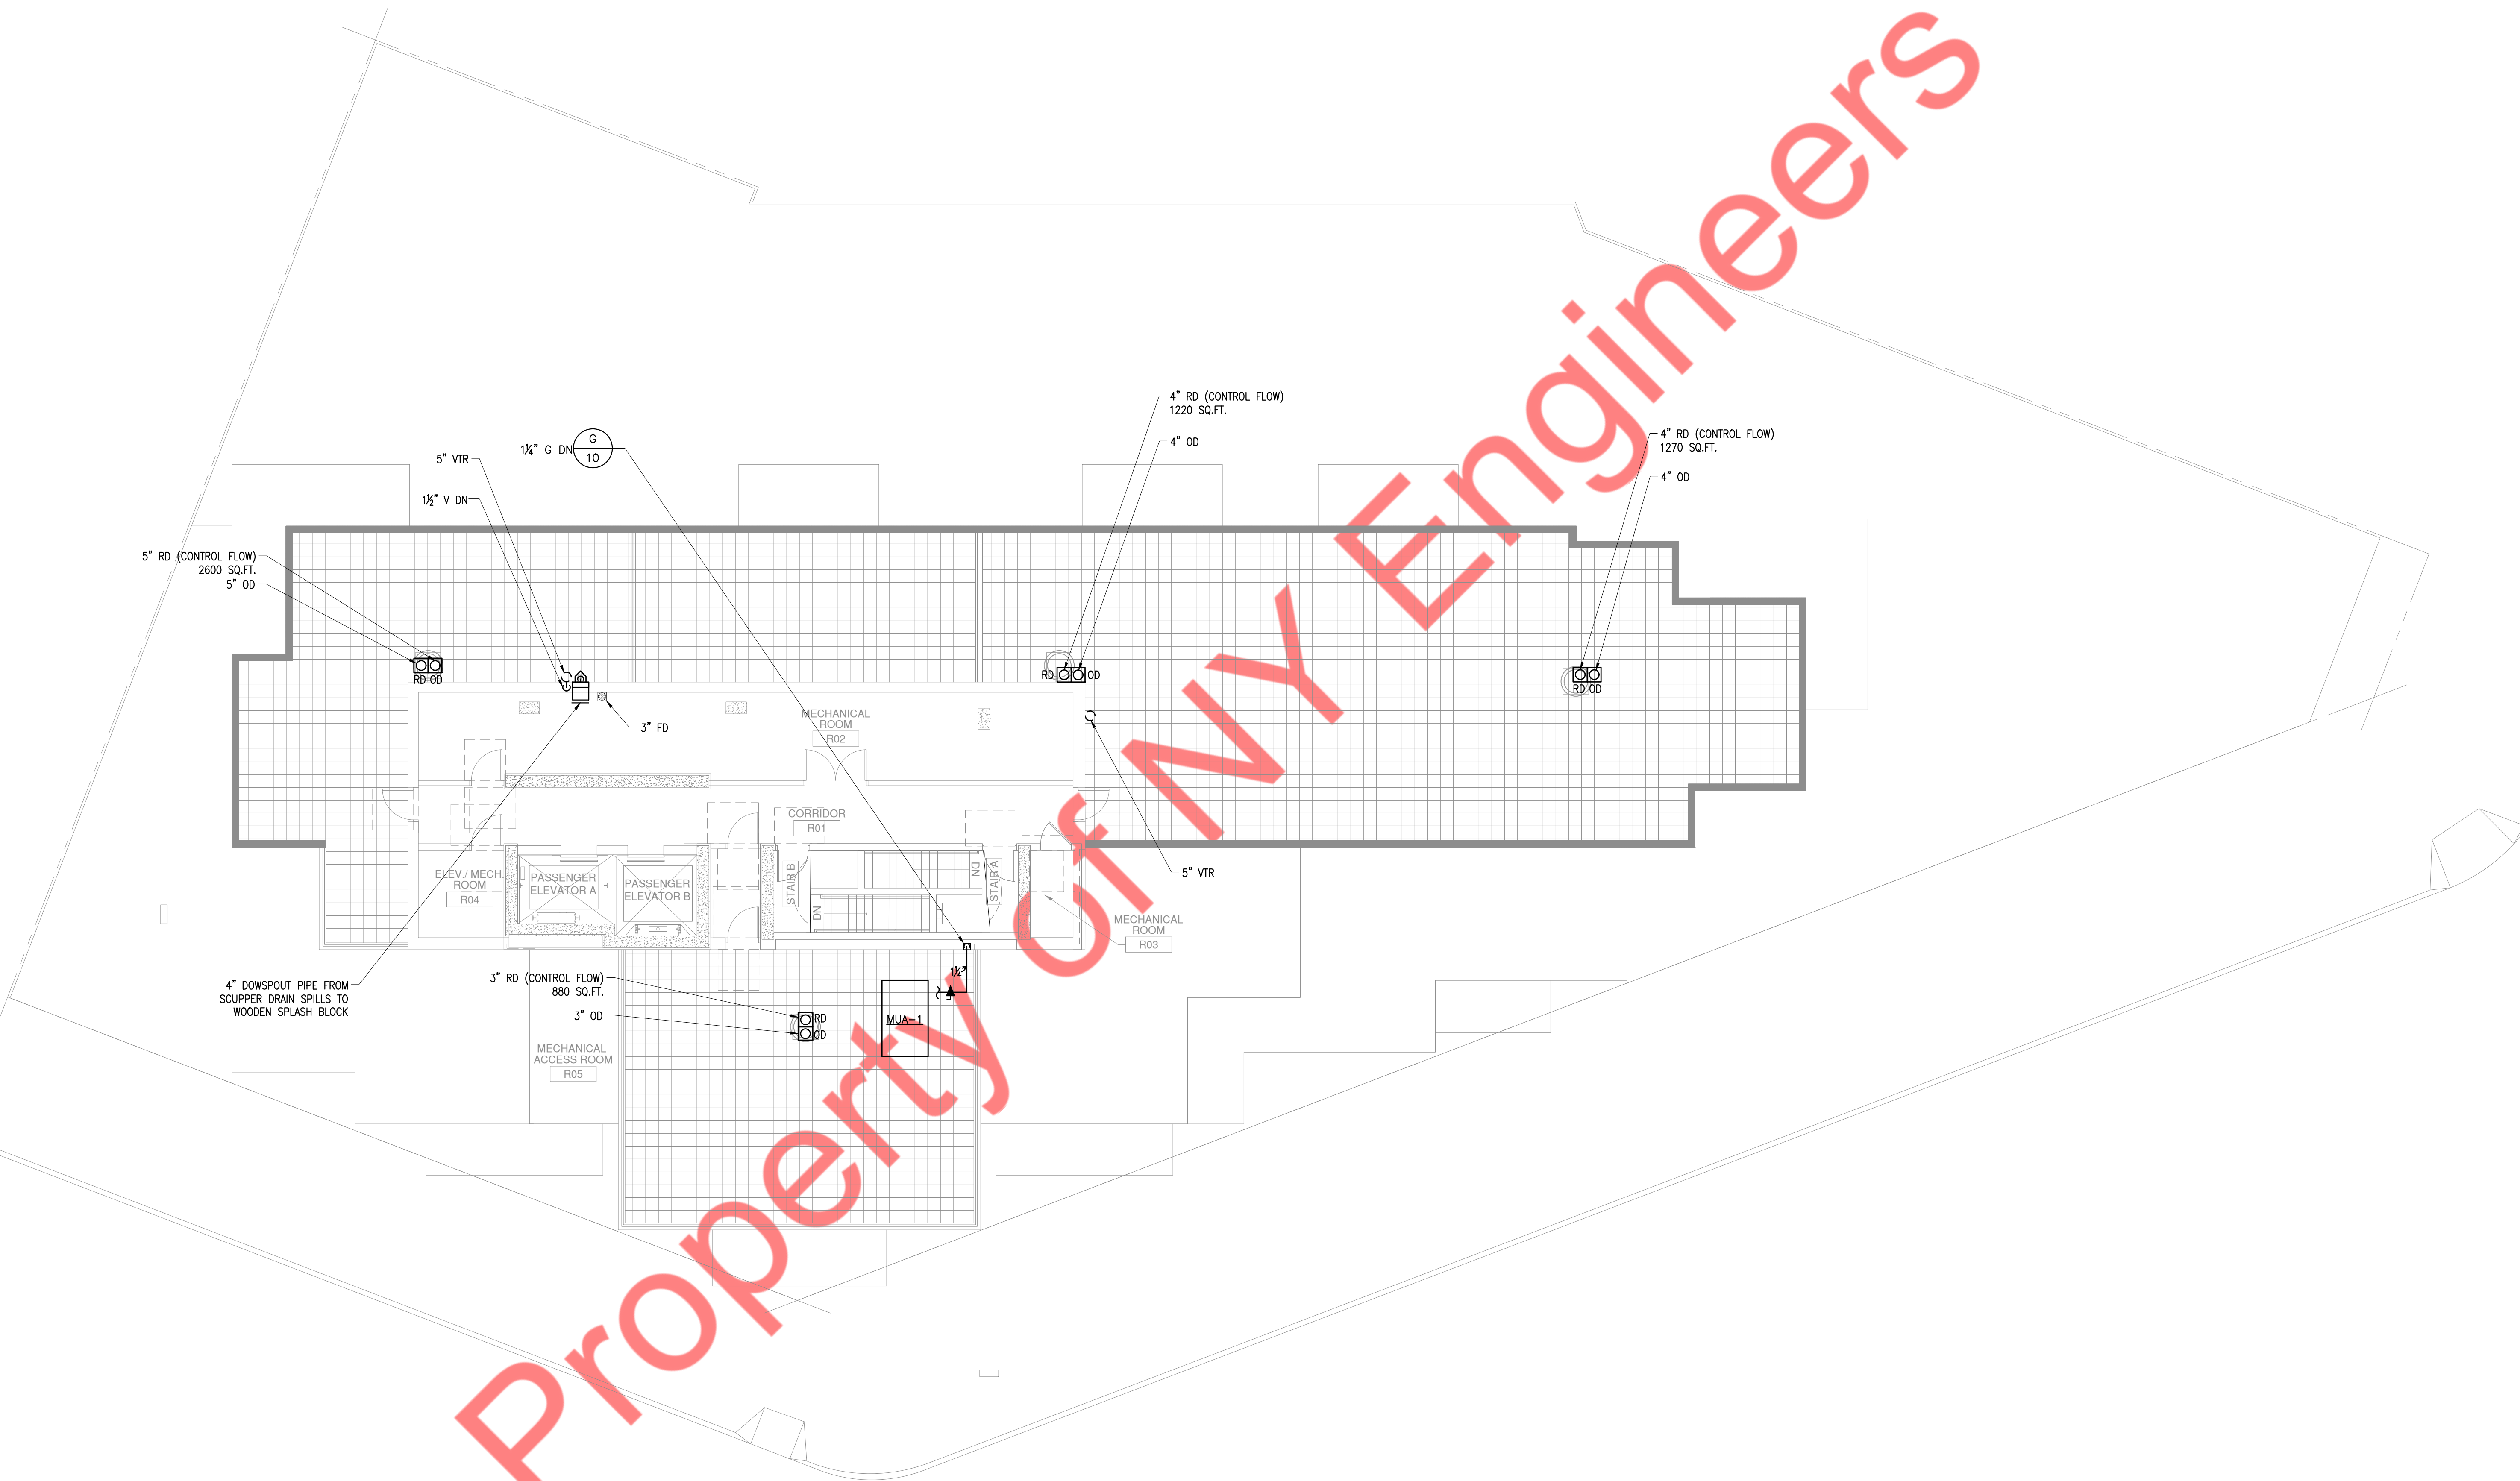


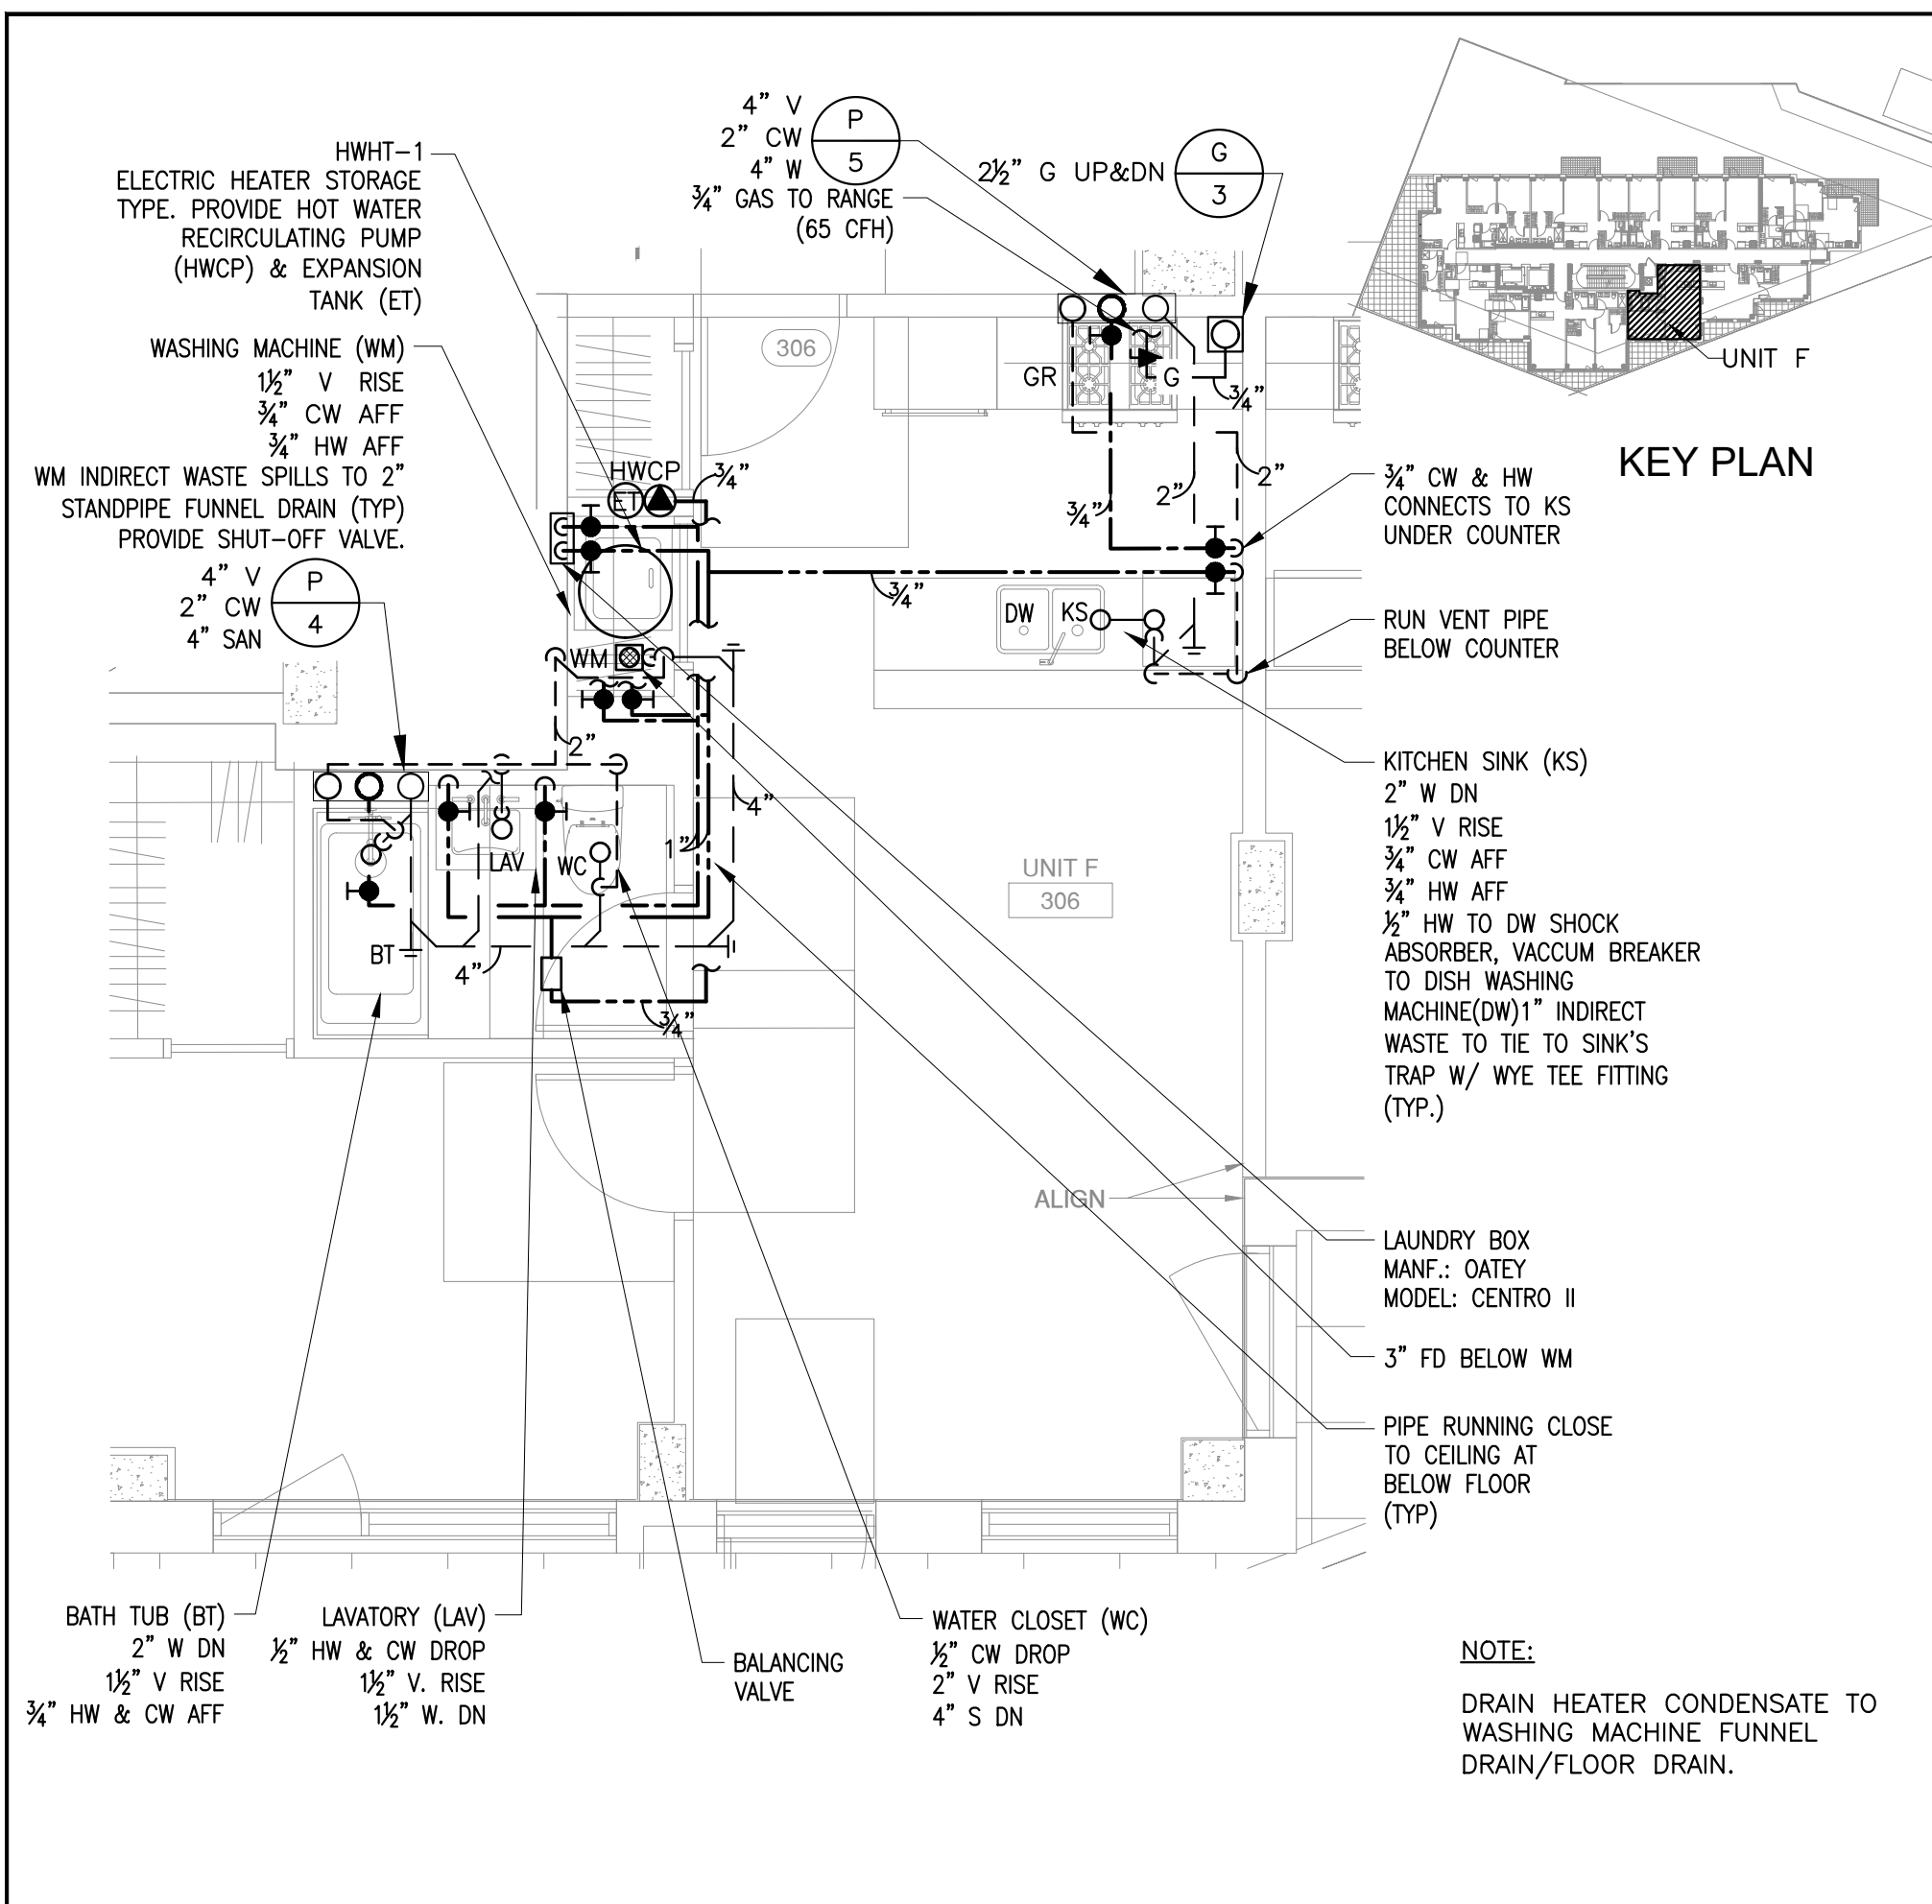


5 UNIT F
SCALE: 1/4" = 1'-0"

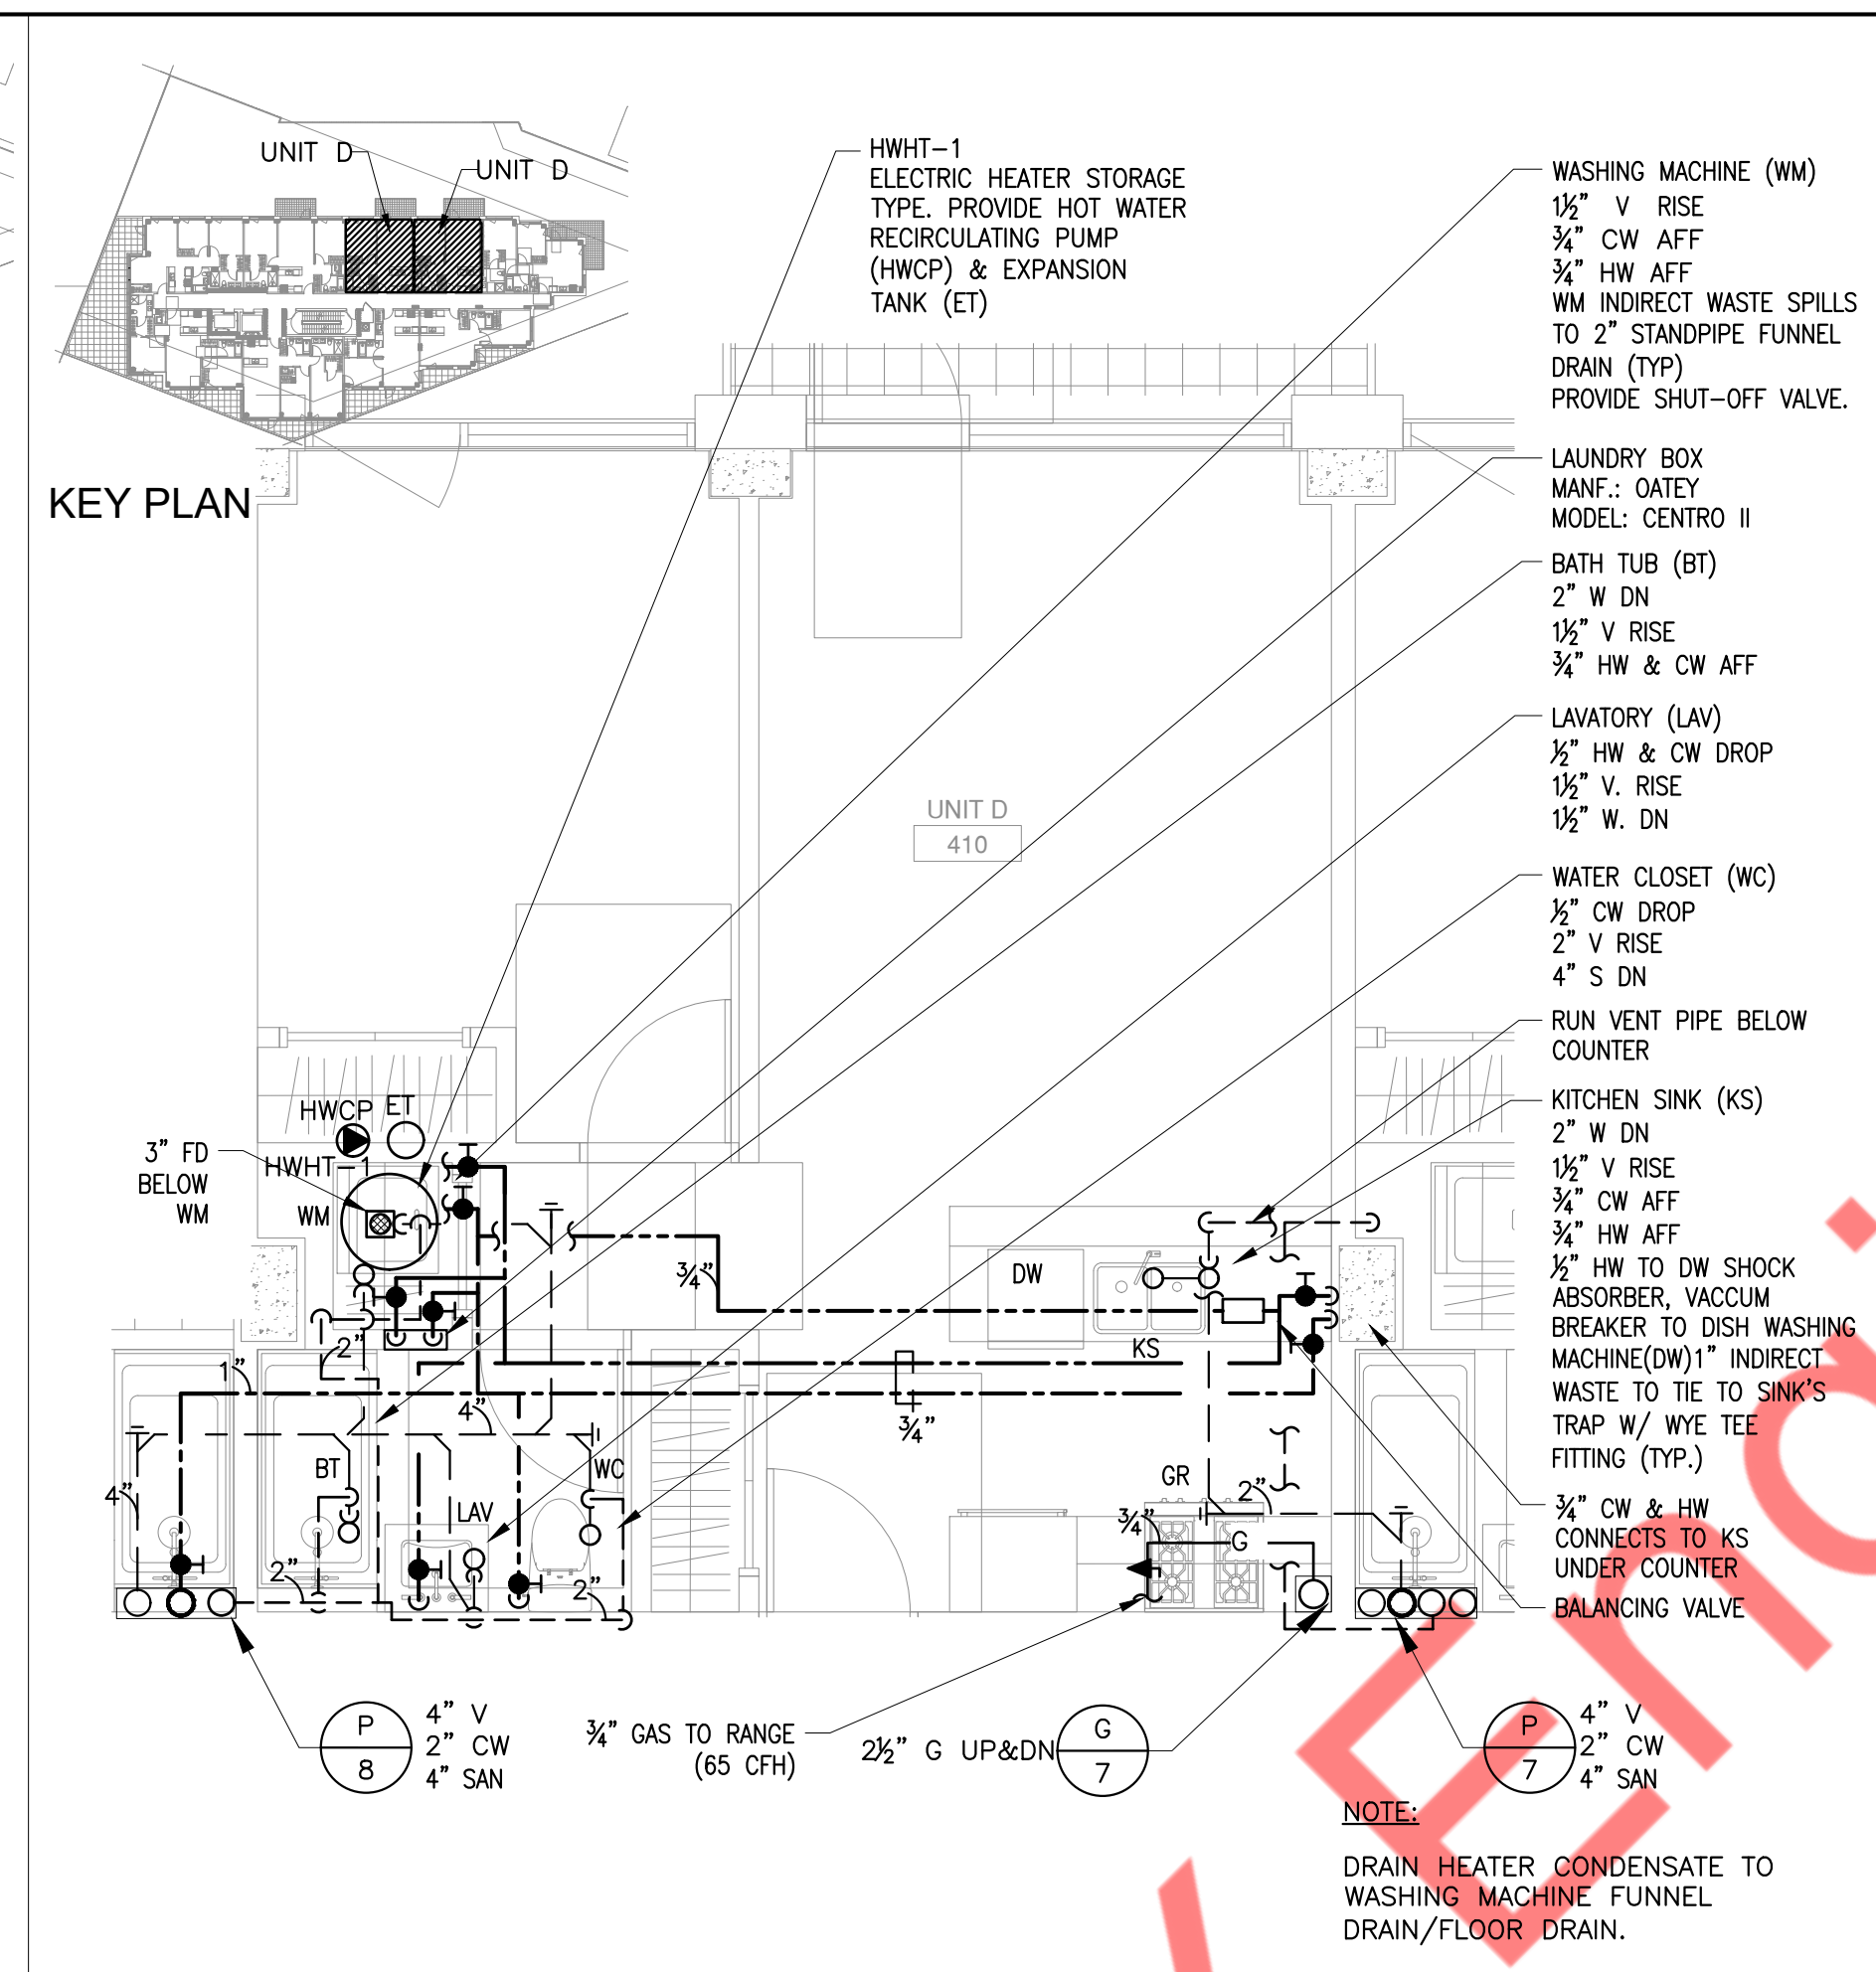


4 UNIT D
SCALE: 1/4" = 1'-0"

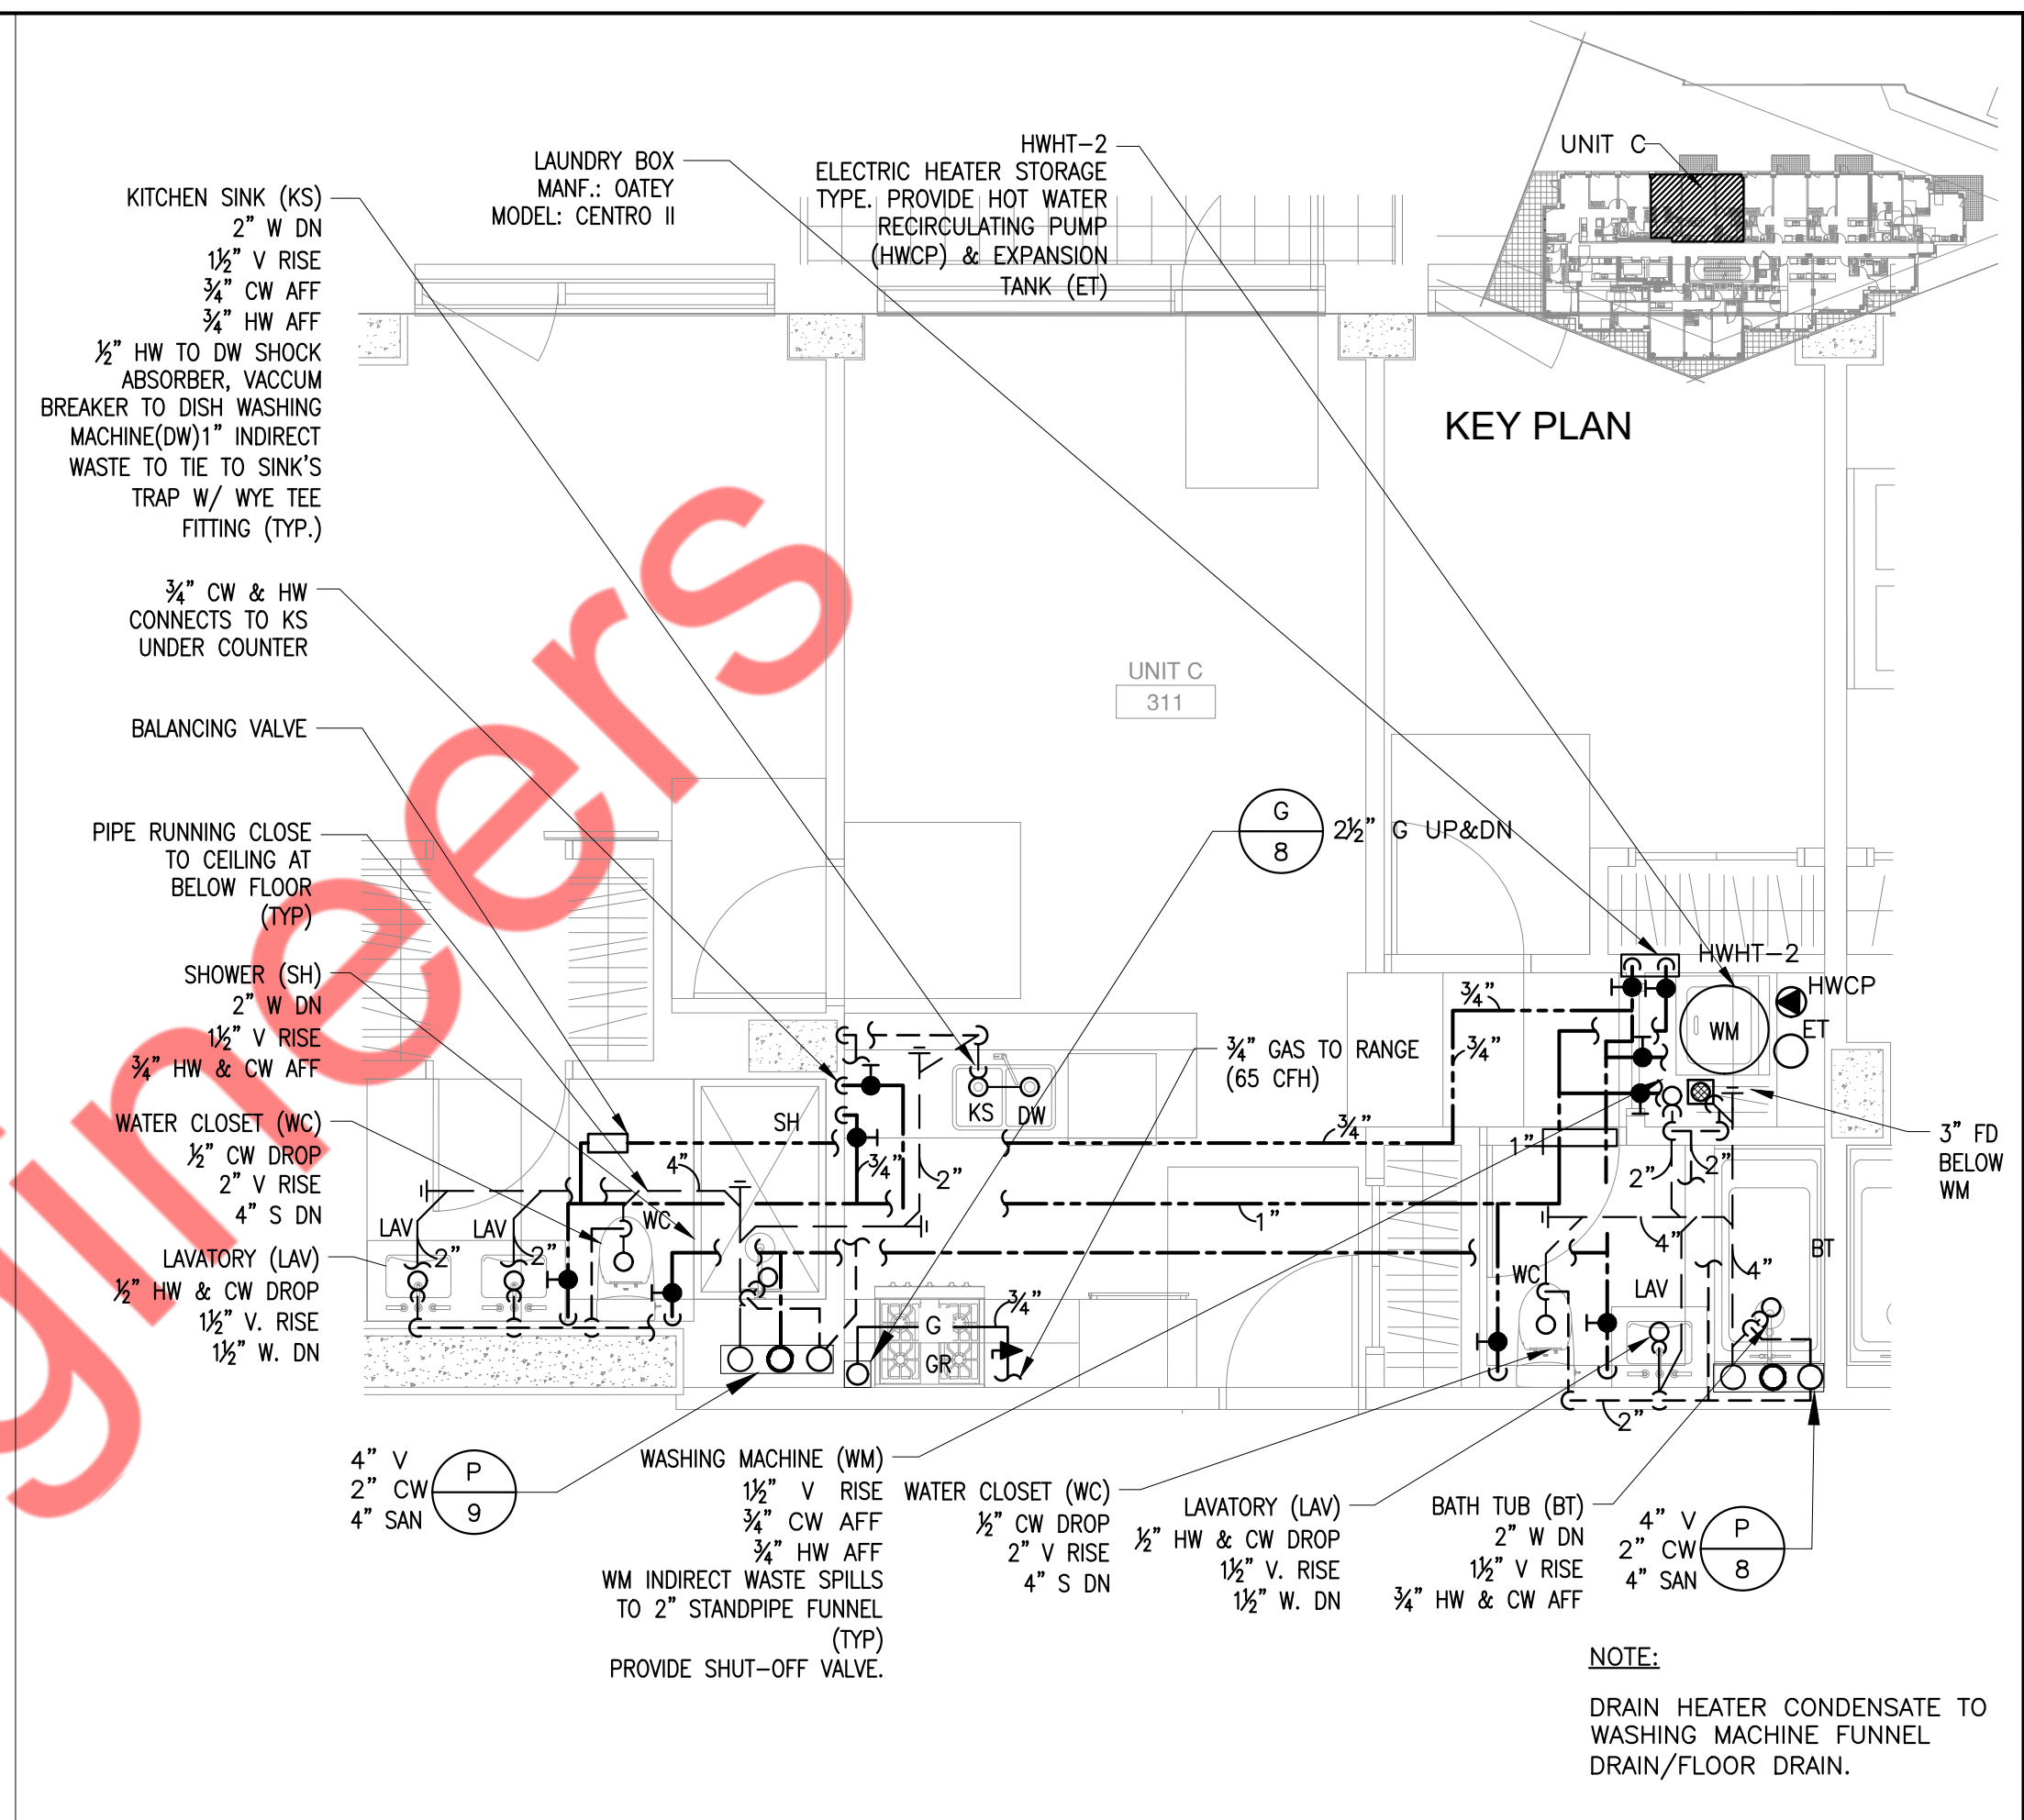

3 UNIT C
SCALE: 1/4" = 1'-0"

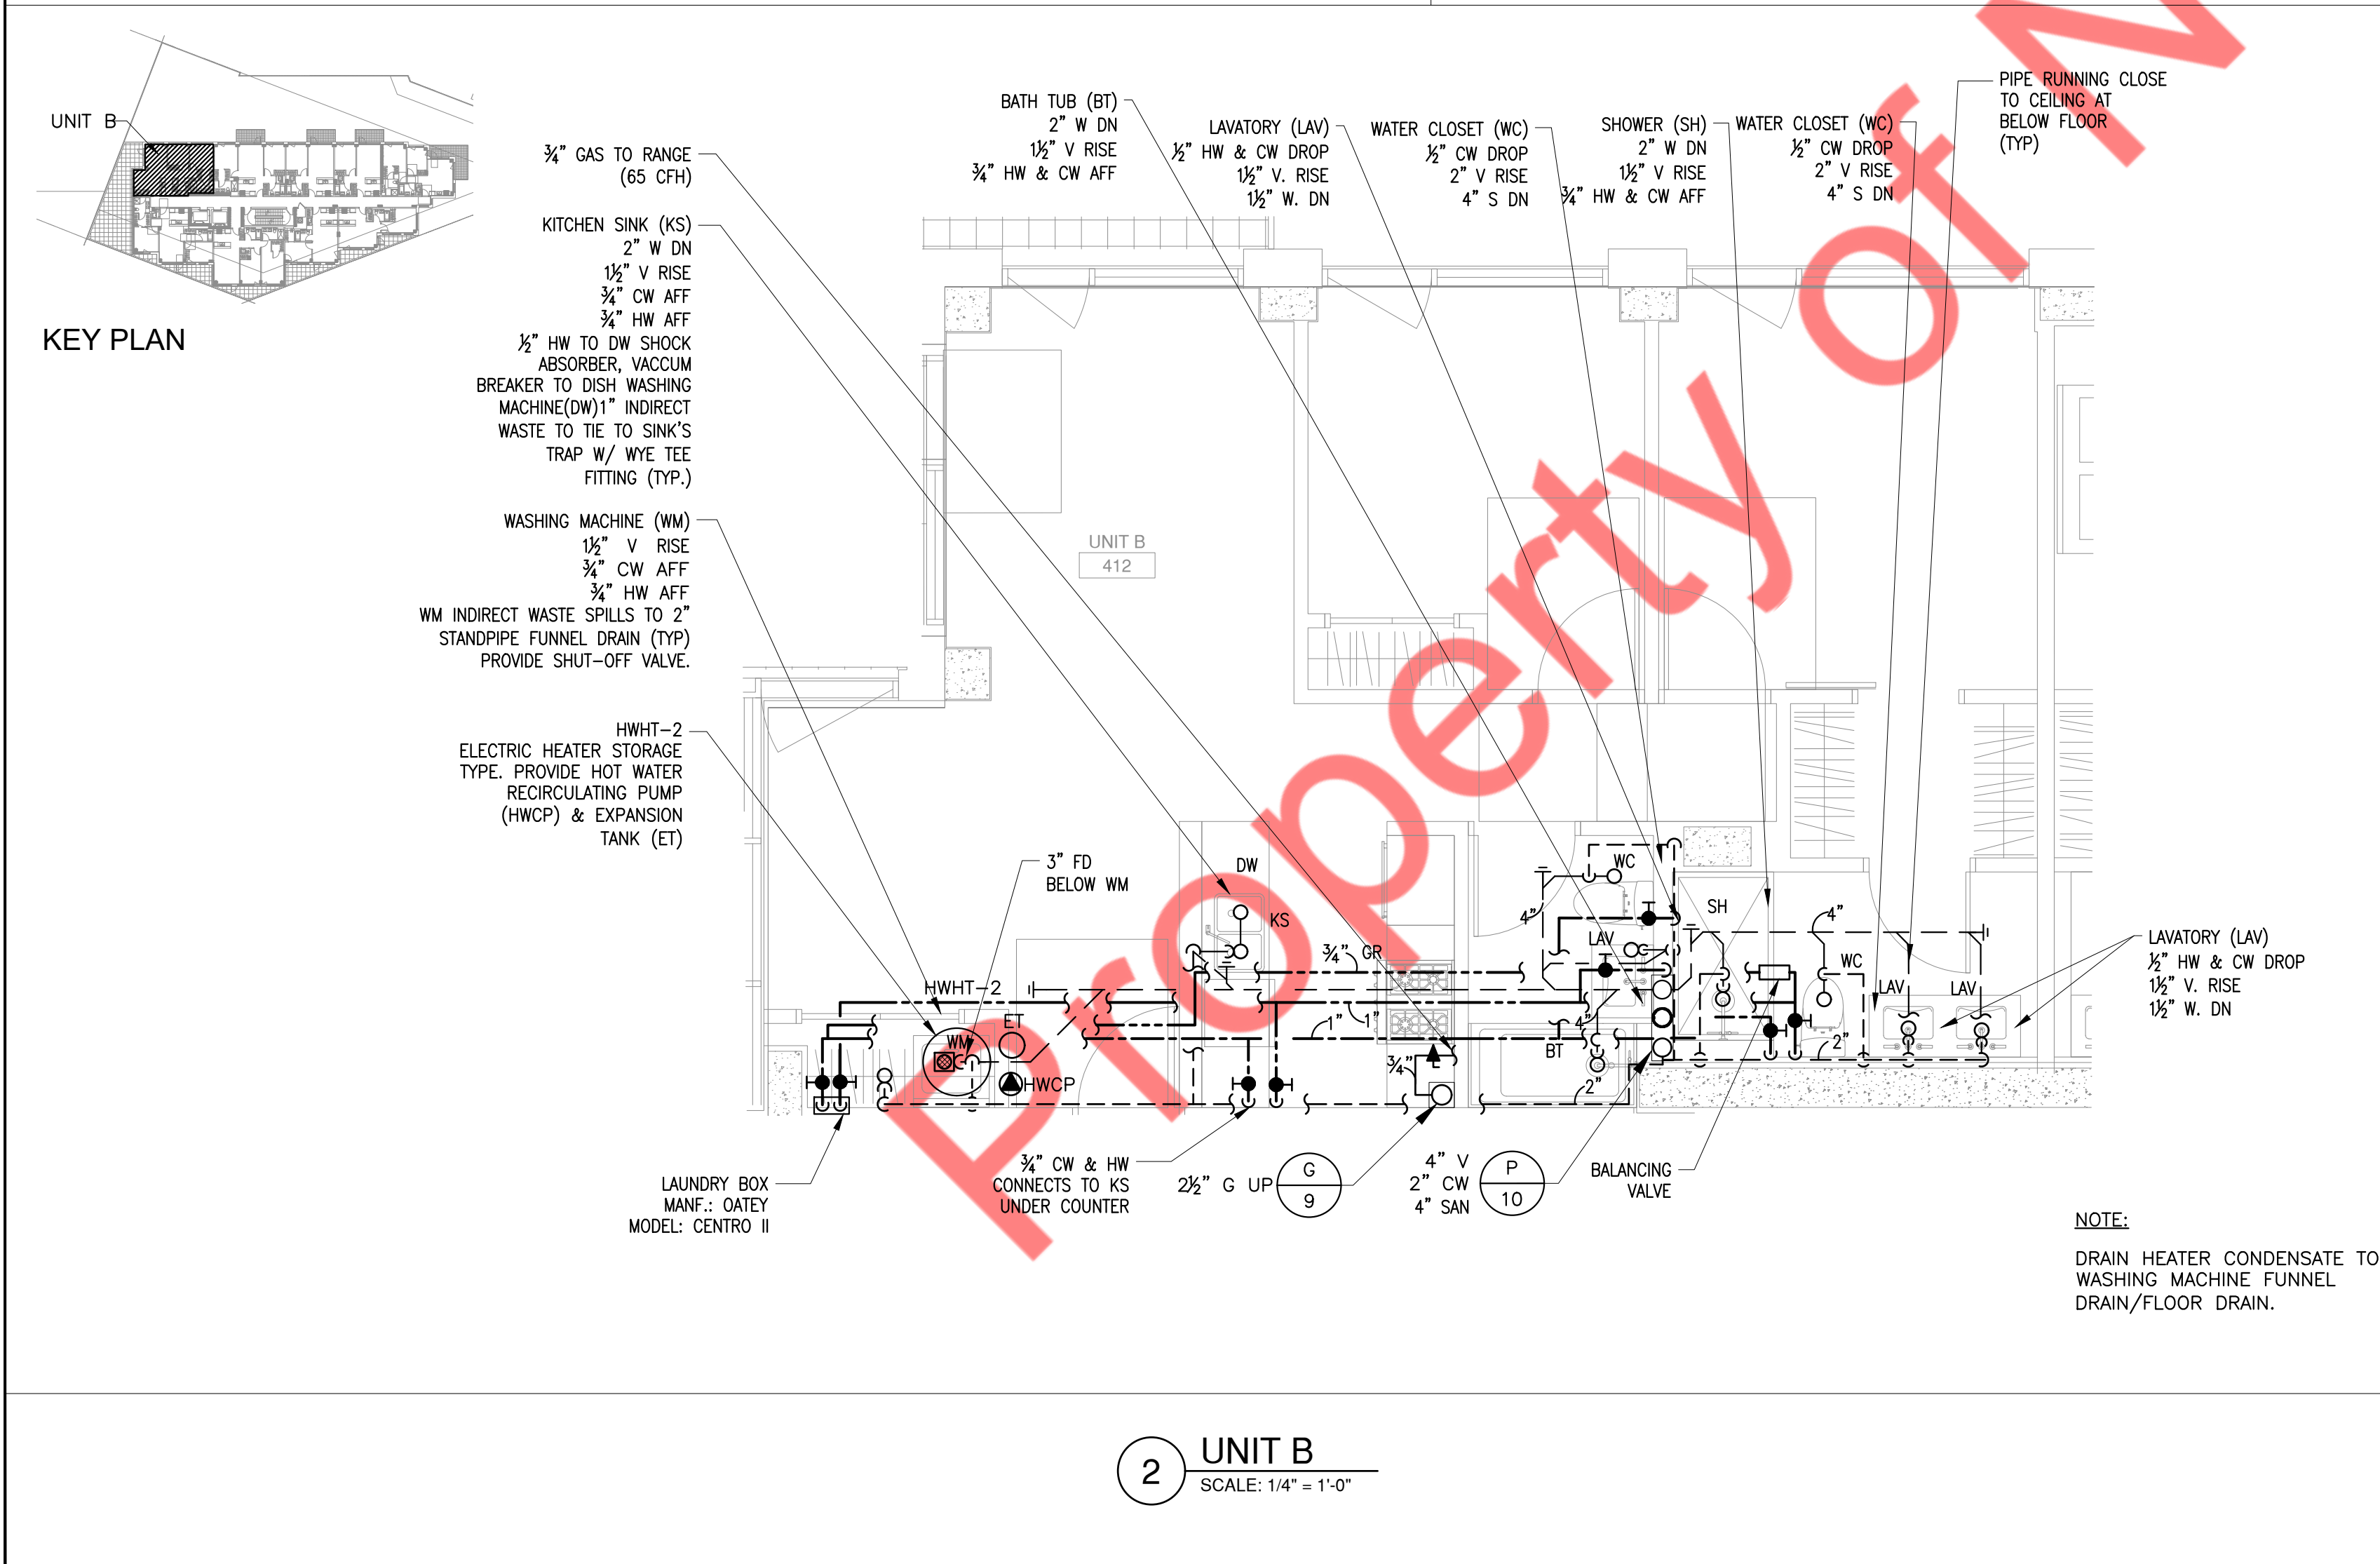

2 UNIT B
SCALE: 1/4" = 1'-0"

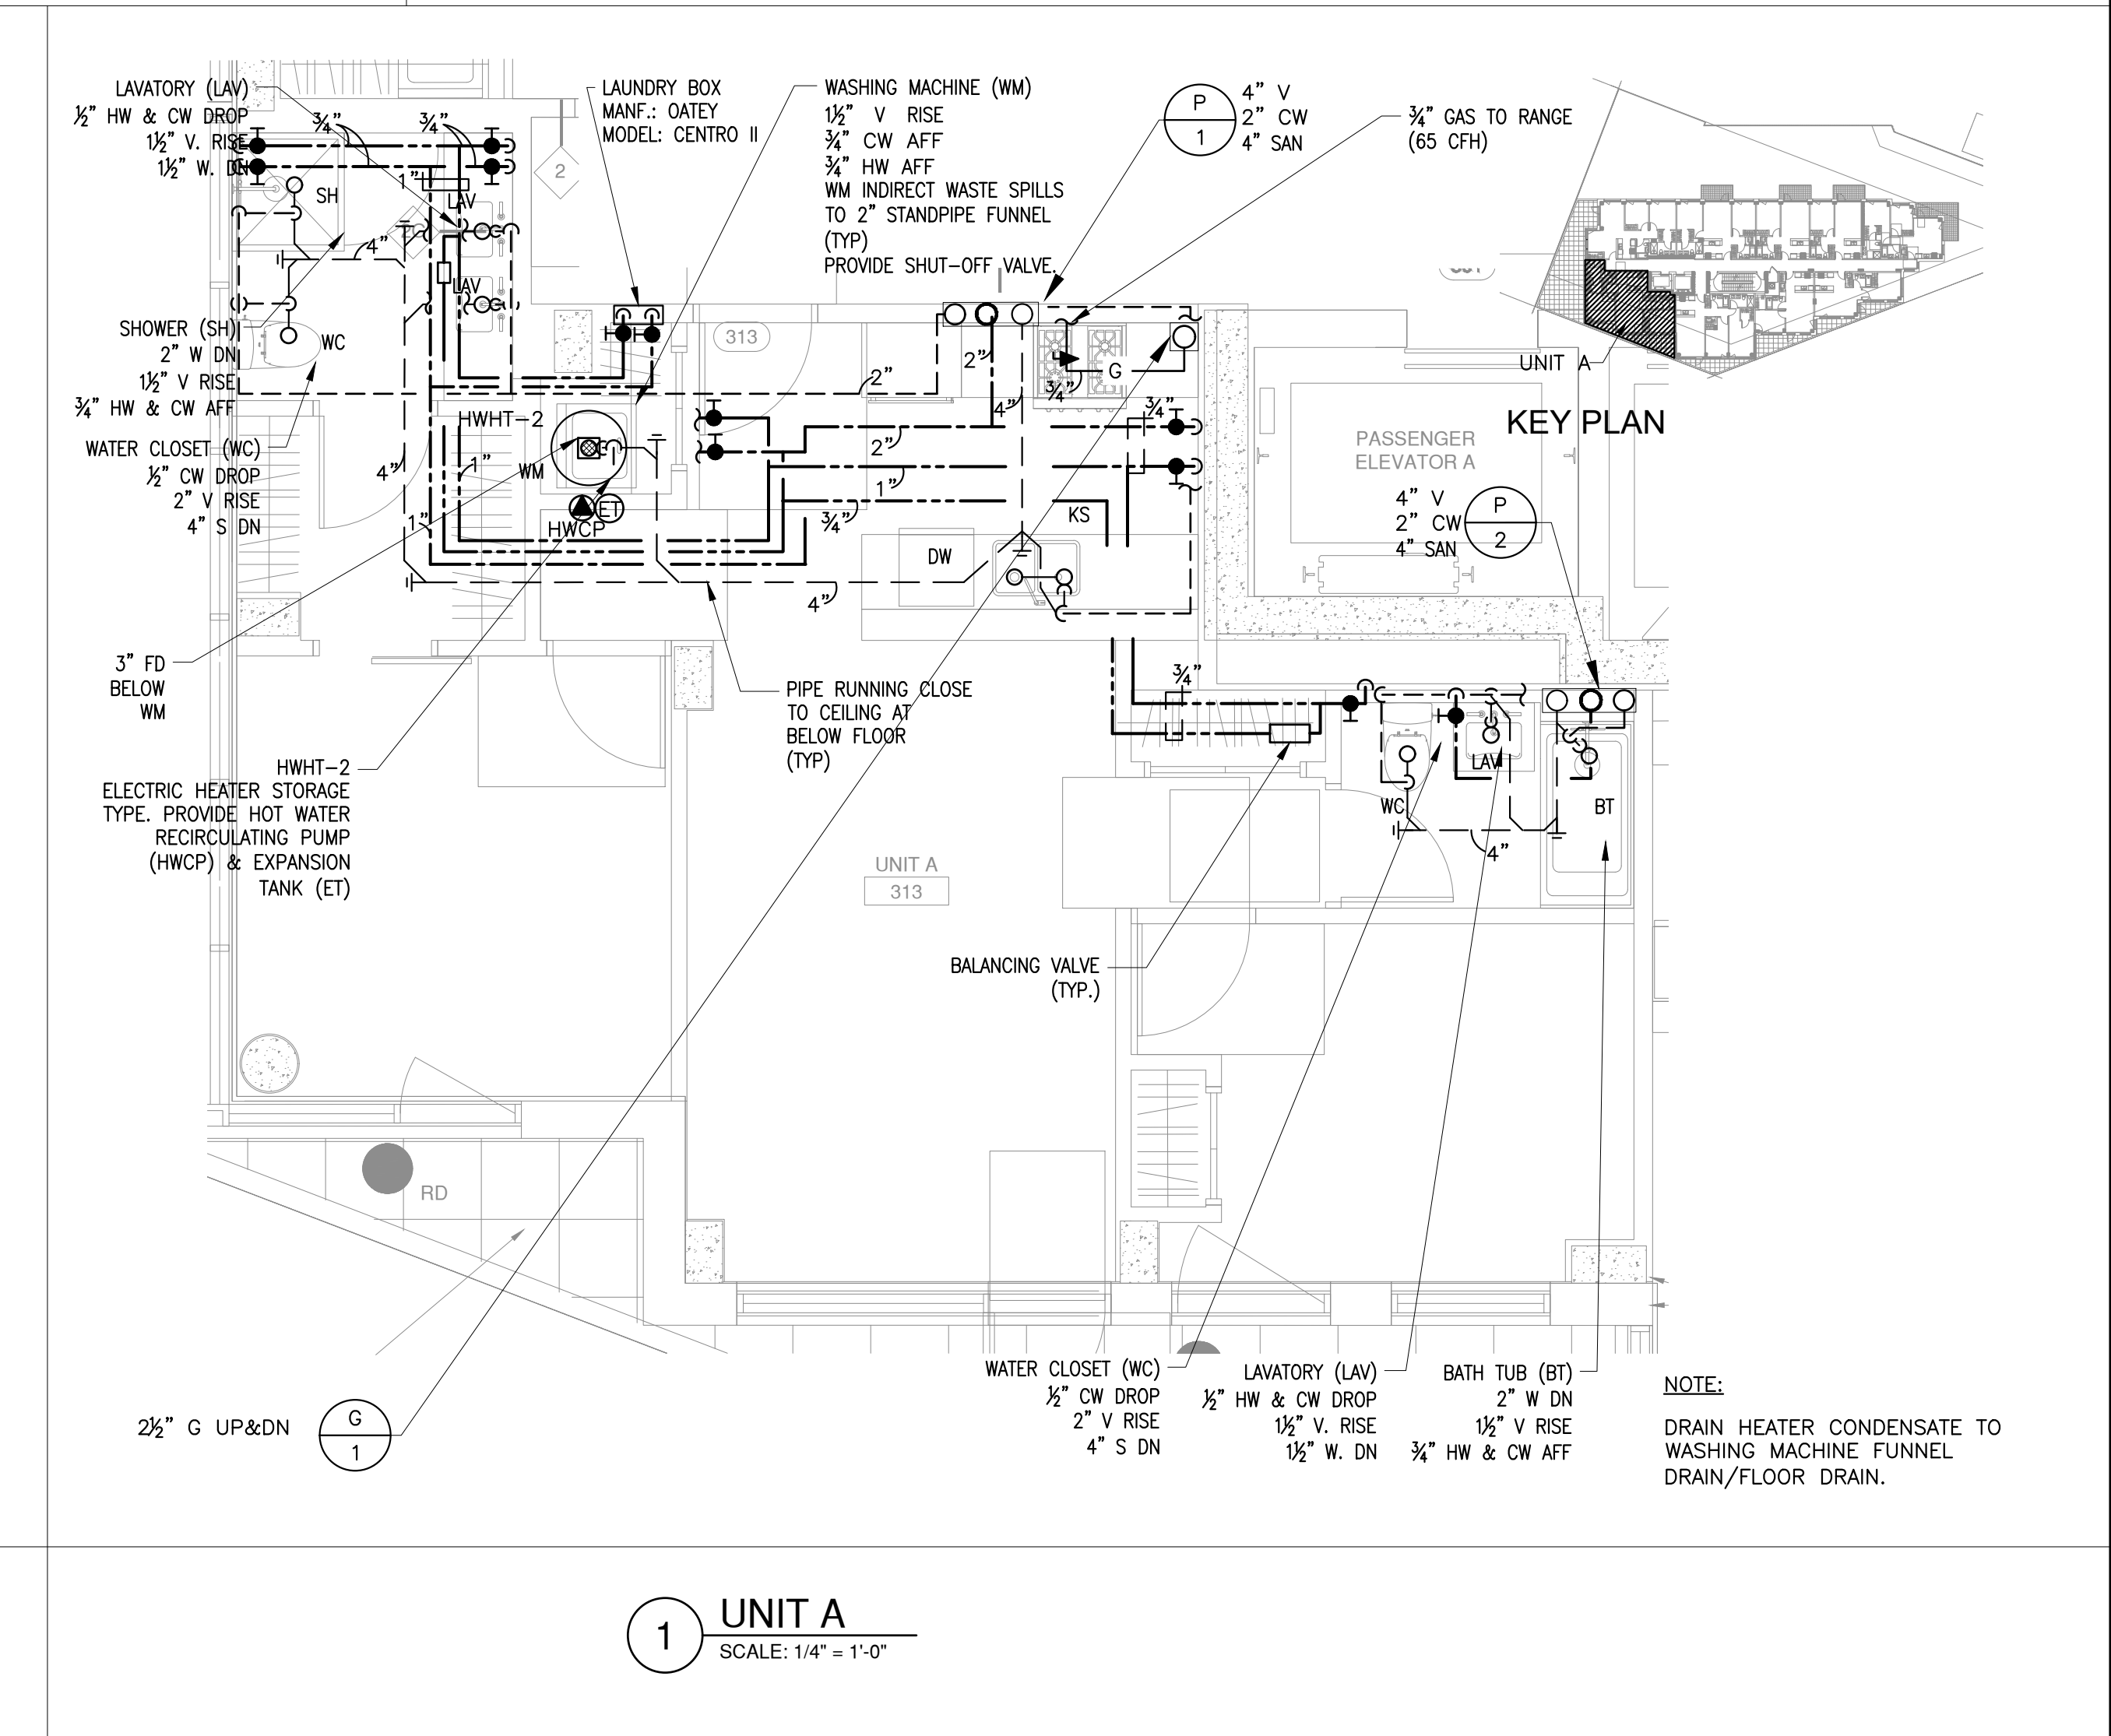

1 UNIT A
SCALE: 1/4" = 1'-0"

